


REFER TO DRAWING  
C3328a-E08.dwg FOR BOOTH  
& STUDIO FLOOR PLANS

REFER TO DRAWING  
C3328a-E08.dwg FOR THE  
CANTEEN KITCHEN PLAN

**NOTE:**  
REFER TO THE ARCHITECTURAL SETOUT DRAWINGS  
FOR DIMENSIONED POSITIONS OF THE FLOOR BOXES.

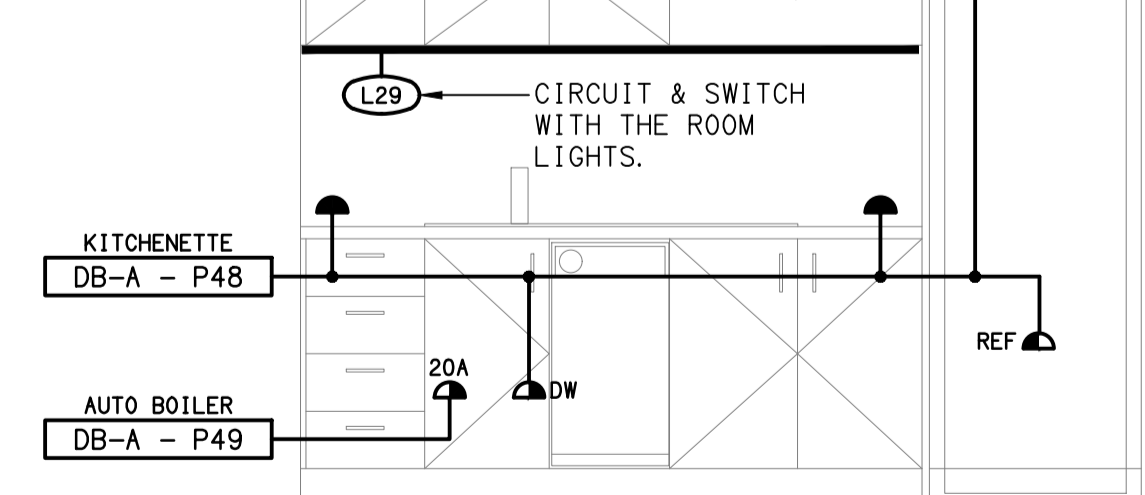

**DETAIL A**  
WORK AREA KITCHENETTE ELEVATION  
SCALE 1:25

ELECTRICAL DESIGN GROUP BRISBANE PTY LTD ACN 092 710 793 TRADING AS: ELECTRICAL DESIGN GROUP	THE COPYRIGHT OF THIS DRAWING REMAINS THE PROPERTY OF THE ELECTRICAL DESIGN GROUP. USE FIGURED DIMENSIONS IN PREFERENCE TO SCALE. ALL DIMENSIONS TO BE VERIFIED ONSITE.	construction hospitality property <b>rohrig</b> rohrig.com.au	Rohrig (Qld) Pty Ltd ABN 67 093 753 970 QBSA LIC NO 740842 250 Abbotsford Road, Bowen Hills Qld 4006 PO Box 86 Albion DC Qld 4010 T+61 (7) 3257 4411 F+61 (7) 3257 2211 www.rohrig.com.au	<b>ELECTRICAL DESIGN GROUP</b> ELECTRICAL BUILDING SERVICES CONSULTANTS BRISBANE GOLD COAST	PROJECT: <b>ORMISTON COLLEGE          CENTRE FOR LEARNING &amp; INNOVATION</b> 97 DUNDAS STREET WEST, ORMISTON	B INFORMATION 24/10/2024
						REV: DESCRIPTION: DATE:
DRAWING: <b>ELECTRICAL SERVICES          GROUND LEVEL FLOOR PLAN</b>						
SCALE: 1:100 UNO	AT A1	PROJECT NO: <b>C3328a</b>	DRAWING NO: <b>E04</b>	REVISION: <b>B</b>		