


**NOTE:**  
REFER TO DRAWING C3328a-E03.dwg FOR  
ADDITIONAL LIGHTING DETAILS FOR THE  
OUTDOOR / LANDSCAPING AREAS.

**NOTE:**  
REFER TO DRAWING C3328a-E03.dwg FOR  
ADDITIONAL LIGHTING DETAILS FOR THE  
OUTDOOR / LANDSCAPING AREAS.

**NOTE:**  
REFER TO DRAWING C3328a-E03.dwg FOR  
ADDITIONAL LIGHTING DETAILS FOR THE  
OUTDOOR / LANDSCAPING AREAS.

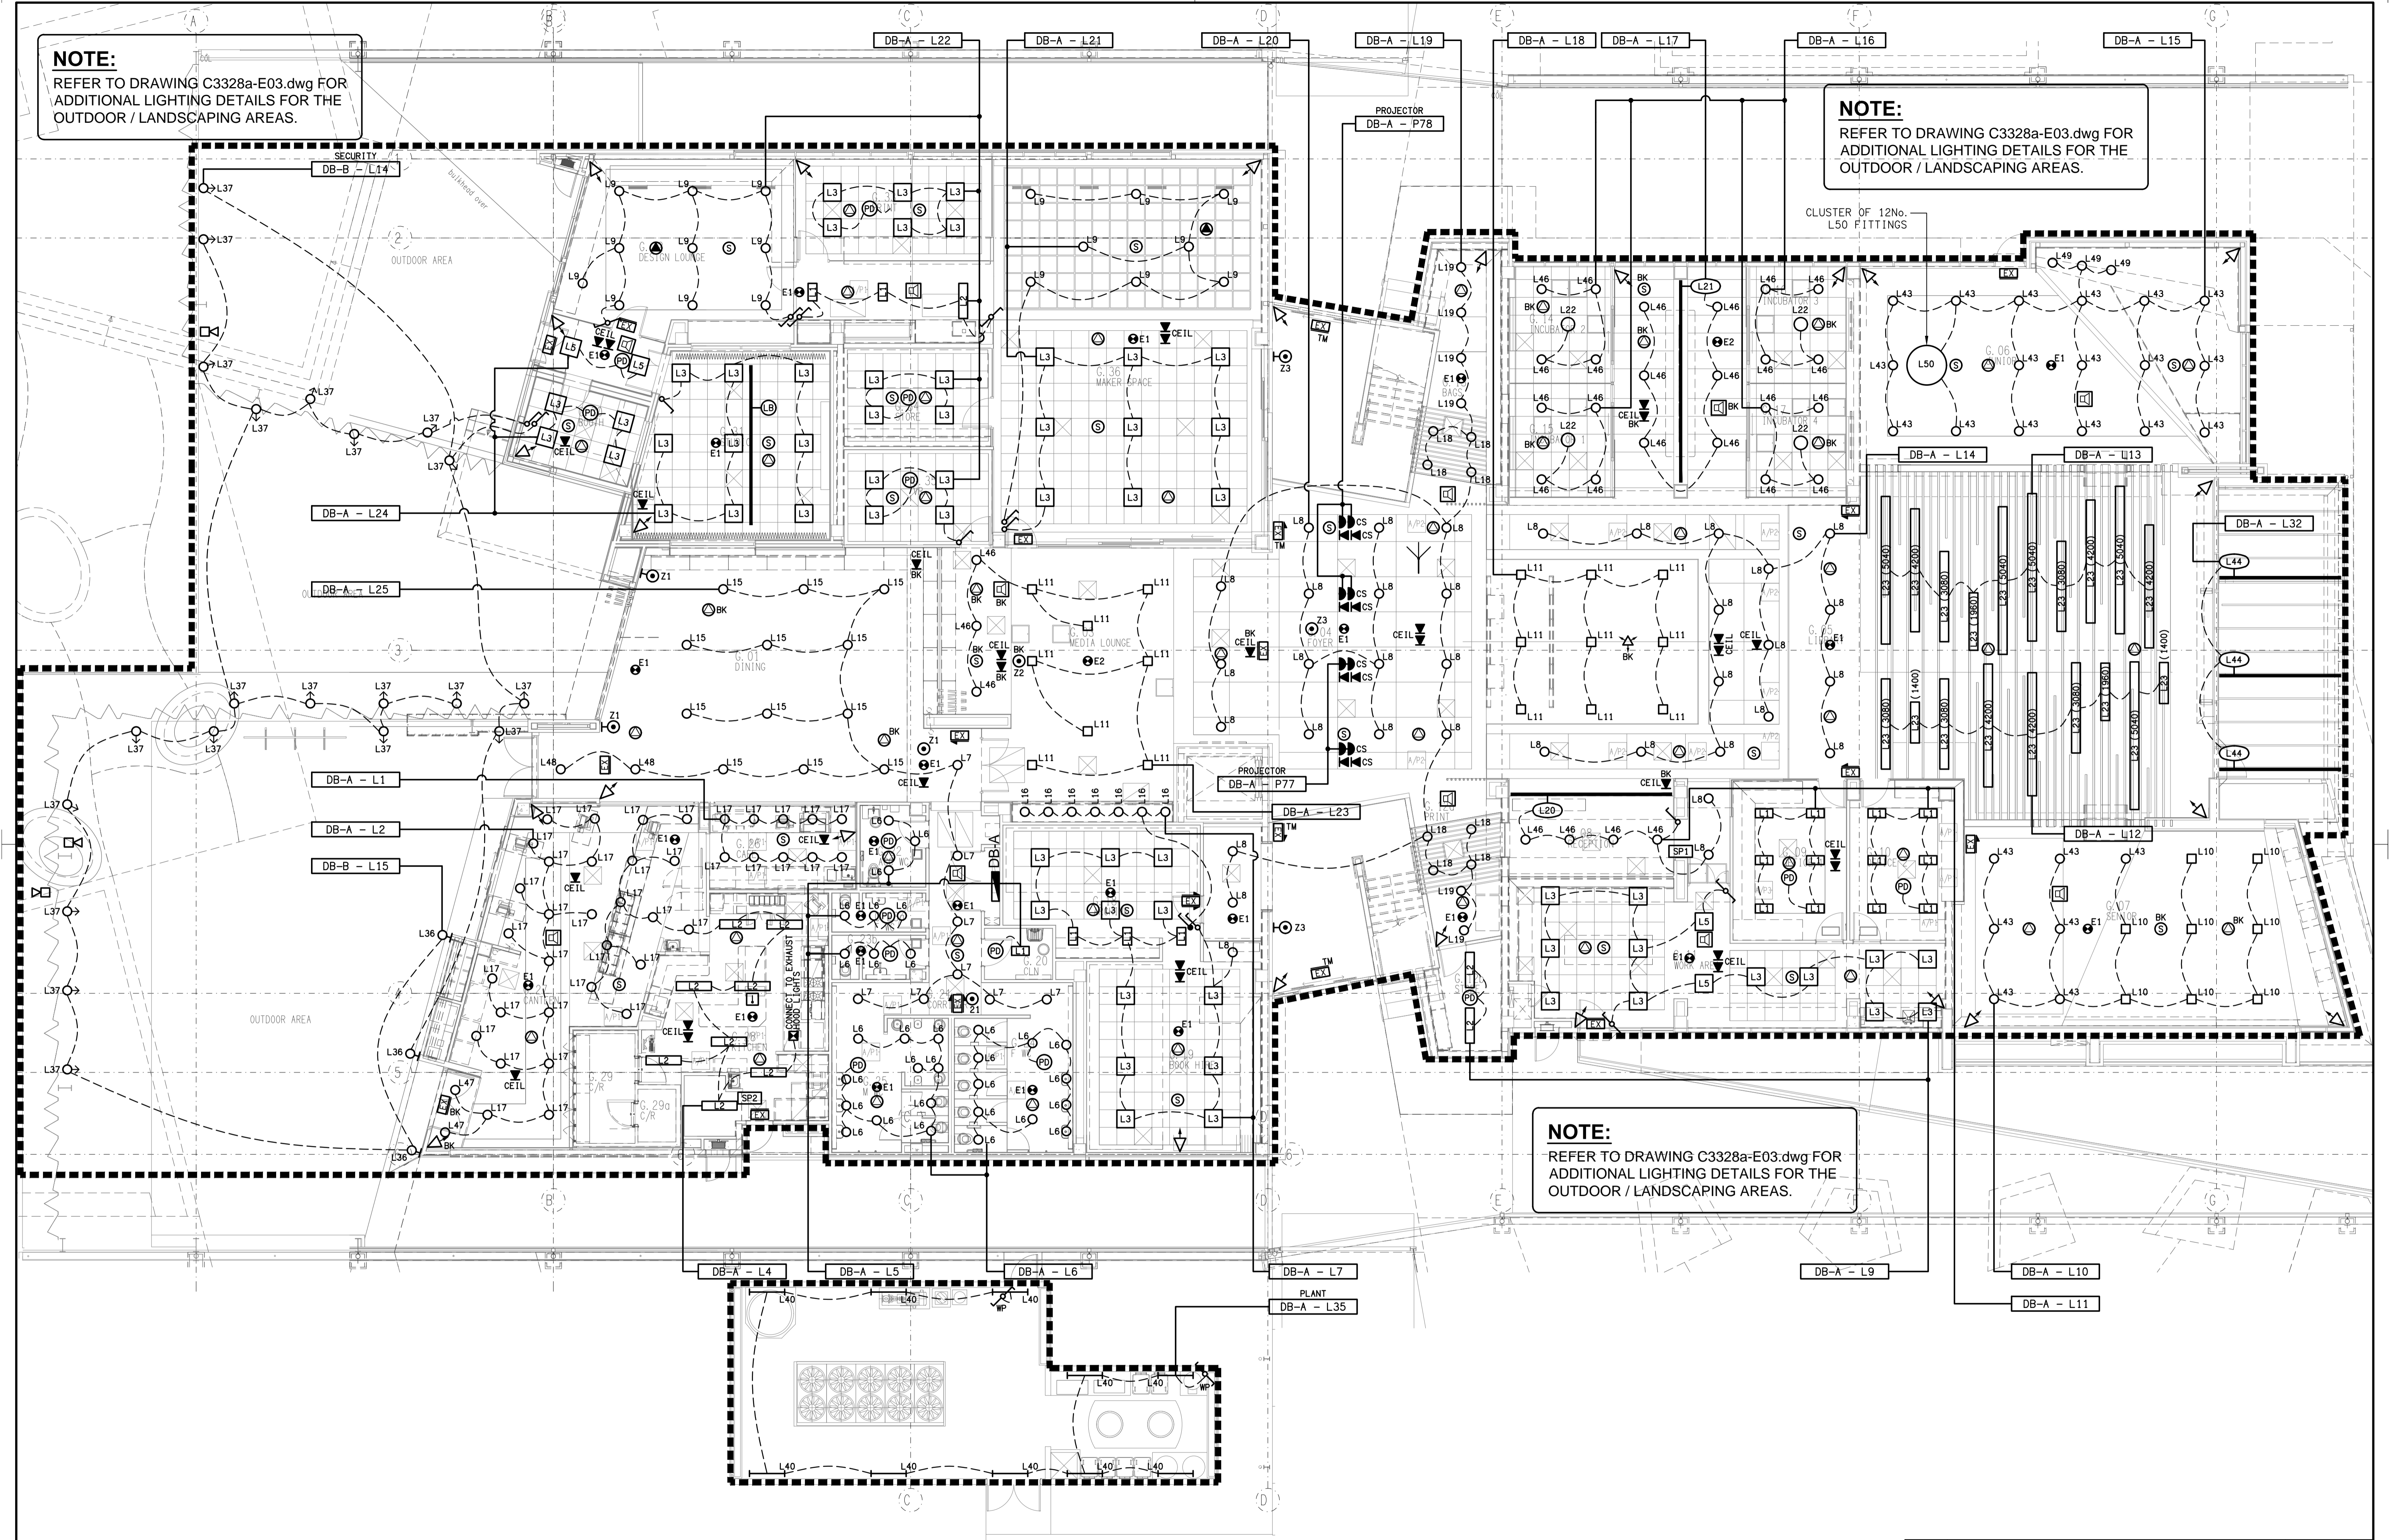

ELECTRICAL DESIGN GROUP BRISBANE  
PTY LTD  
ACN 092 710 793  
TRADING AS:  
ELECTRICAL DESIGN GROUP

THE COPYRIGHT OF THIS DRAWING  
REMAINS THE PROPERTY OF THE  
ELECTRICAL DESIGN GROUP.  
USE FIGURED DIMENSIONS  
IN PREFERENCE TO SCALE.  
ALL DIMENSIONS TO BE  
VERIFIED ONSITE.



Rohrig (Qld) Pty Ltd  
ABN 67 093 753 970  
QBSA LIC NO 740842  
250 Abbotsford Road, Bowen Hills Qld 4006  
PO Box 86 Albion DC Qld 4010  
T+61 (7) 3257 4411 F+61 (7) 3257 2211  
www.rohrig.com.au

**ELECTRICAL DESIGN GROUP**  
ELECTRICAL BUILDING SERVICES CONSULTANTS  
BRISBANE GOLD COAST  
P.O. Box 15, Sherwood Q. 4075  
Phone: (07) 3278 4375  
Email: brisbane@edg.net.au  
Web: www.edg.net.au

PROJECT:  
**ORMISTON COLLEGE  
CENTRE FOR LEARNING & INNOVATION**  
97 DUNDAS STREET WEST, ORMISTON

C	INFORMATION	31/10/2024
REV:	DESCRIPTION:	DATE:
DRAWING:	<b>ELECTRICAL SERVICES GROUND LEVEL REFLECTED CEILING PLAN</b>	
SCALE: 1:100	PROJECT NO: AT A1 <b>C3328a</b>	DRAWING NO: <b>E05</b>
		REVISION: <b>C</b>