



**ALL EXISTING ELECTRICAL SERVICES WITHIN THIS AREA ARE TO BE REMOVED, UNLESS NOTED OTHERWISE.**

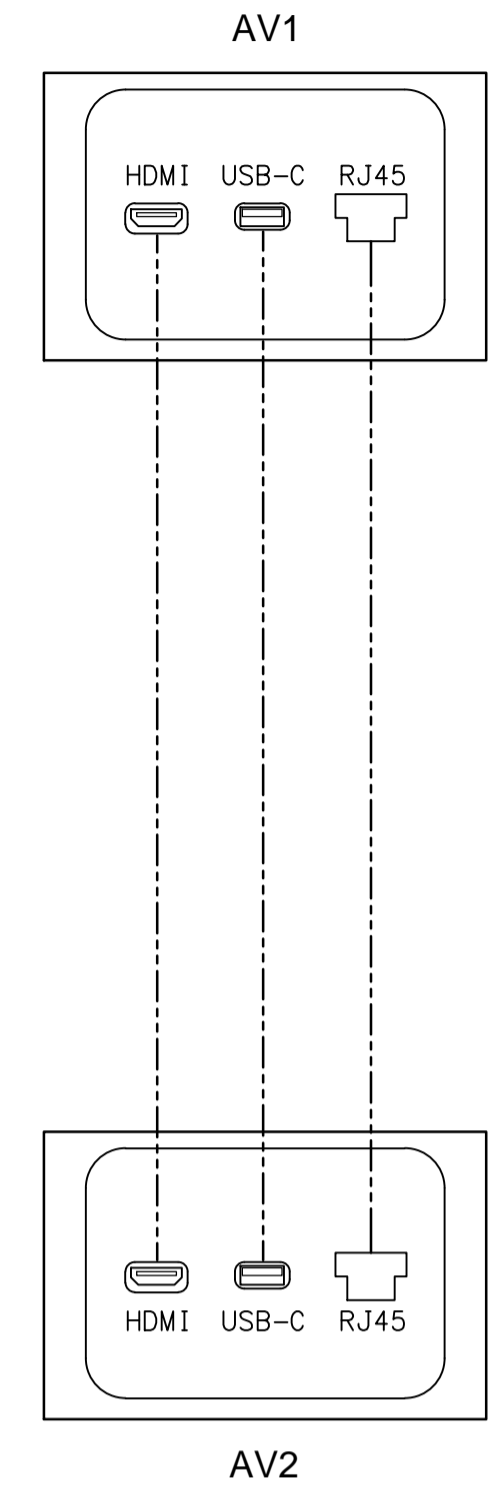

**DETAIL**  
TYPICAL AV1 / AV2 FACEPLATES  
NOT TO SCALE

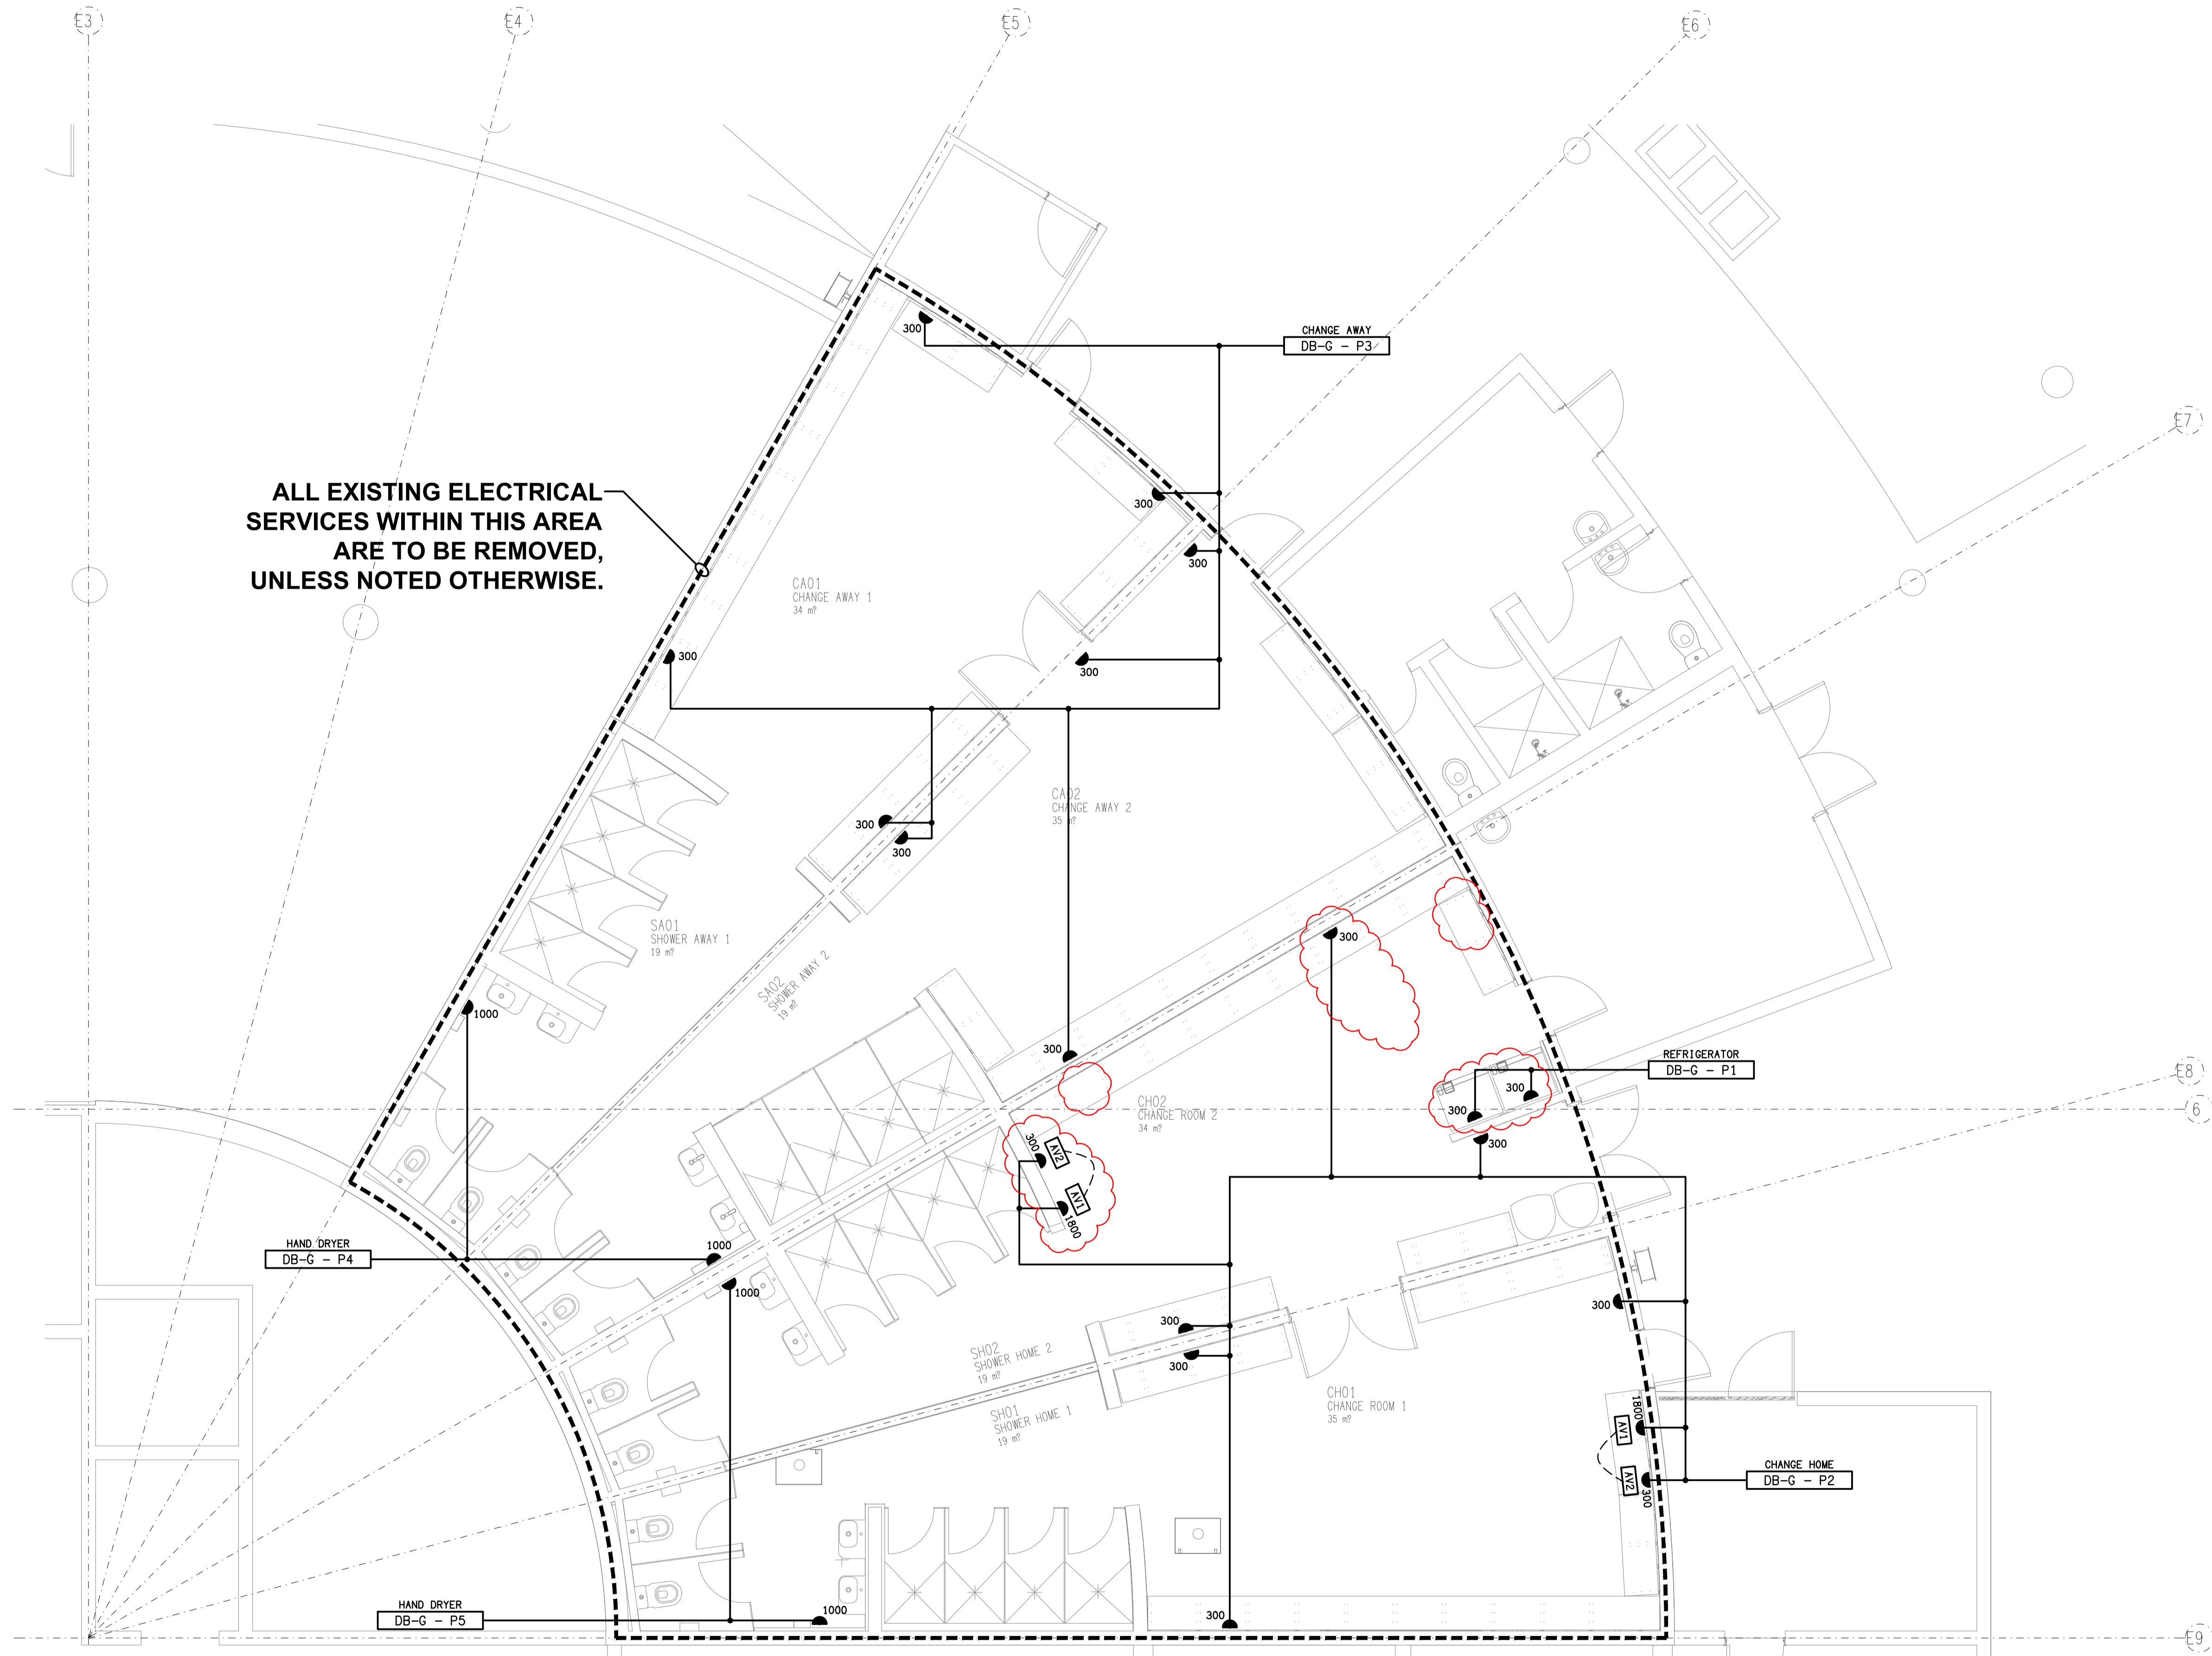

ELECTRICAL DESIGN GROUP BRISBANE  
PTY LTD  
ACN 092 710 793  
TRADING AS:  
ELECTRICAL DESIGN GROUP

THE COPYRIGHT OF THIS DRAWING  
REMAINS THE PROPERTY OF THE  
ELECTRICAL DESIGN GROUP.  
USE FIGURED DIMENSIONS  
IN PREFERENCE TO SCALE.  
ALL DIMENSIONS TO BE  
VERIFIED ONSITE.

**ELECTRICAL DESIGN GROUP**  
ELECTRICAL BUILDING SERVICES CONSULTANTS  
BRISBANE GOLD COAST  
P.O. Box 15, Sherwood Q.4075  
Phone: (07) 3278 4375  
Email: brisbane@edg.net.au  
Web: www.edg.net.au

PROJECT:  
**BROTHERS LEAGUES CLUB, IPSWICH  
CHANGE ROOM REFURBISHMENT**  
WILDEY STREET, IPSWICH

C	CONSTRUCTION	01/11/2024
REV:	DESCRIPTION:	DATE:
DRAWING: <b>ELECTRICAL SERVICES FLOOR PLAN</b>		
SCALE: 1:50	AT A1	PROJECT NO: <b>C3352a</b>
		DRAWING NO: <b>E02</b>
		REVISION: <b>C</b>