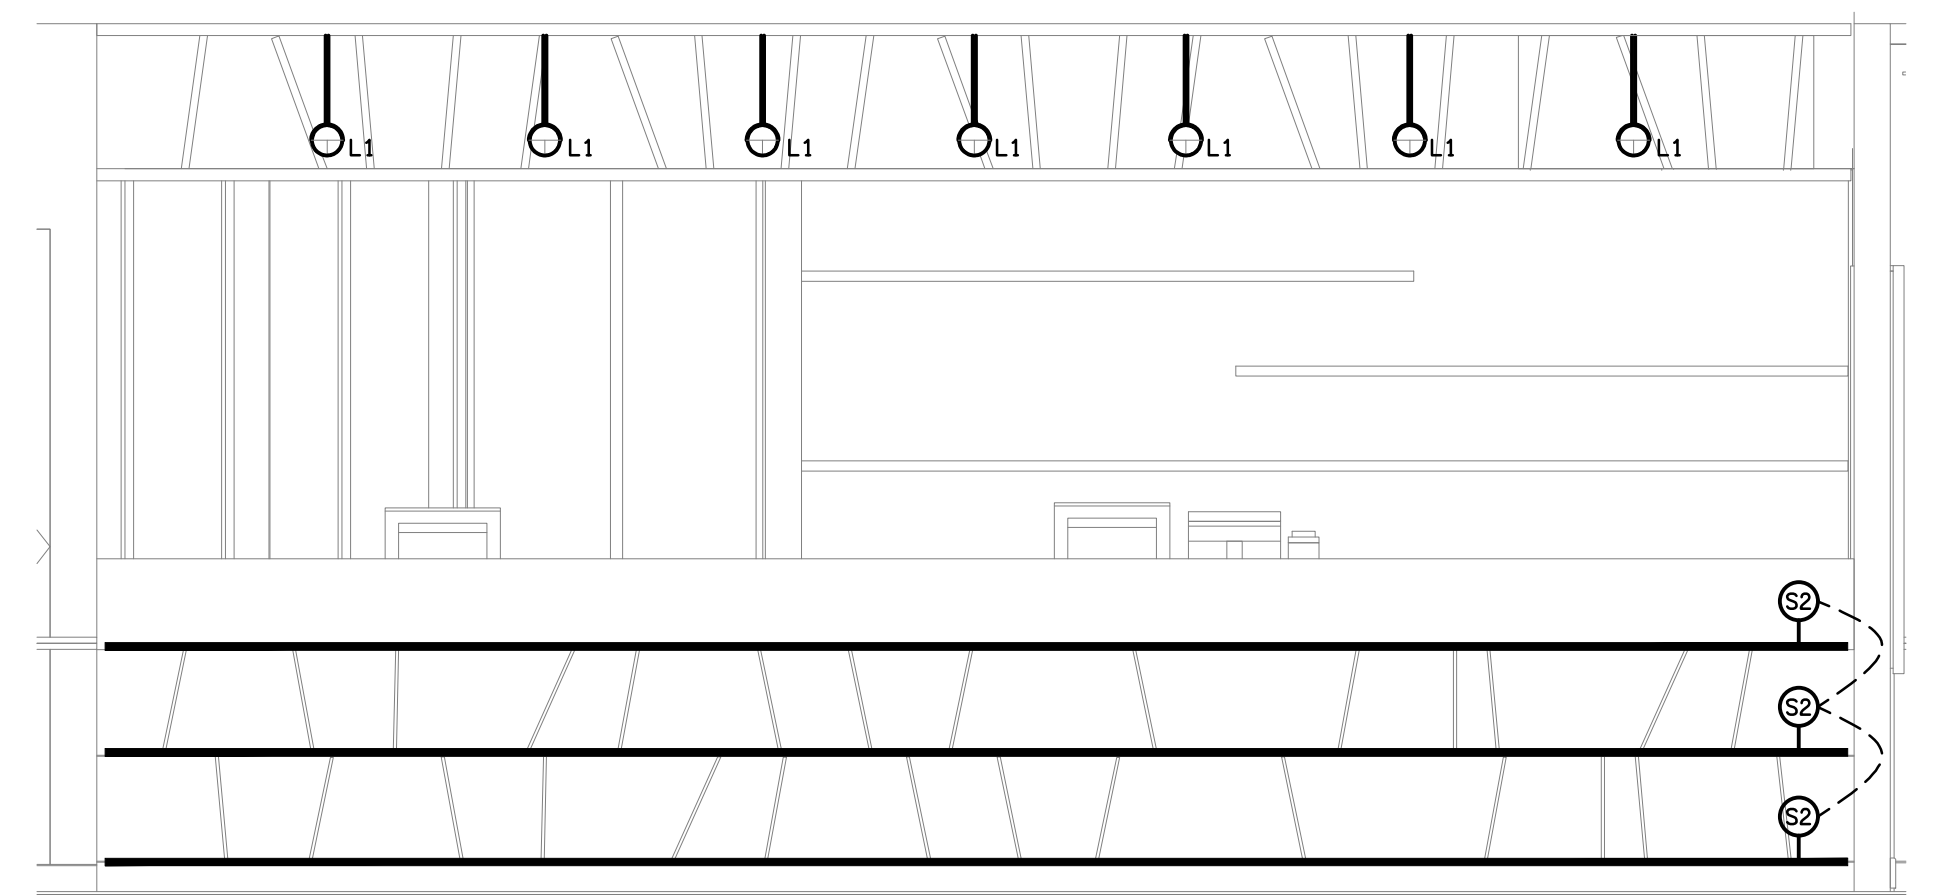
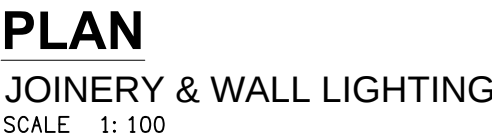


B	CONSTRUCTION	23/05/2025
REV:	DESCRIPTION:	DATE:
DRAWING:		
ELECTRICAL SERVICES JOINERY & WALL LIGHTING PLAN		
SCALE:	PROJECT NO:	DRAWING NO:
AS SHOWN	C3354a	E05
AT A1		REVISION:
		B