



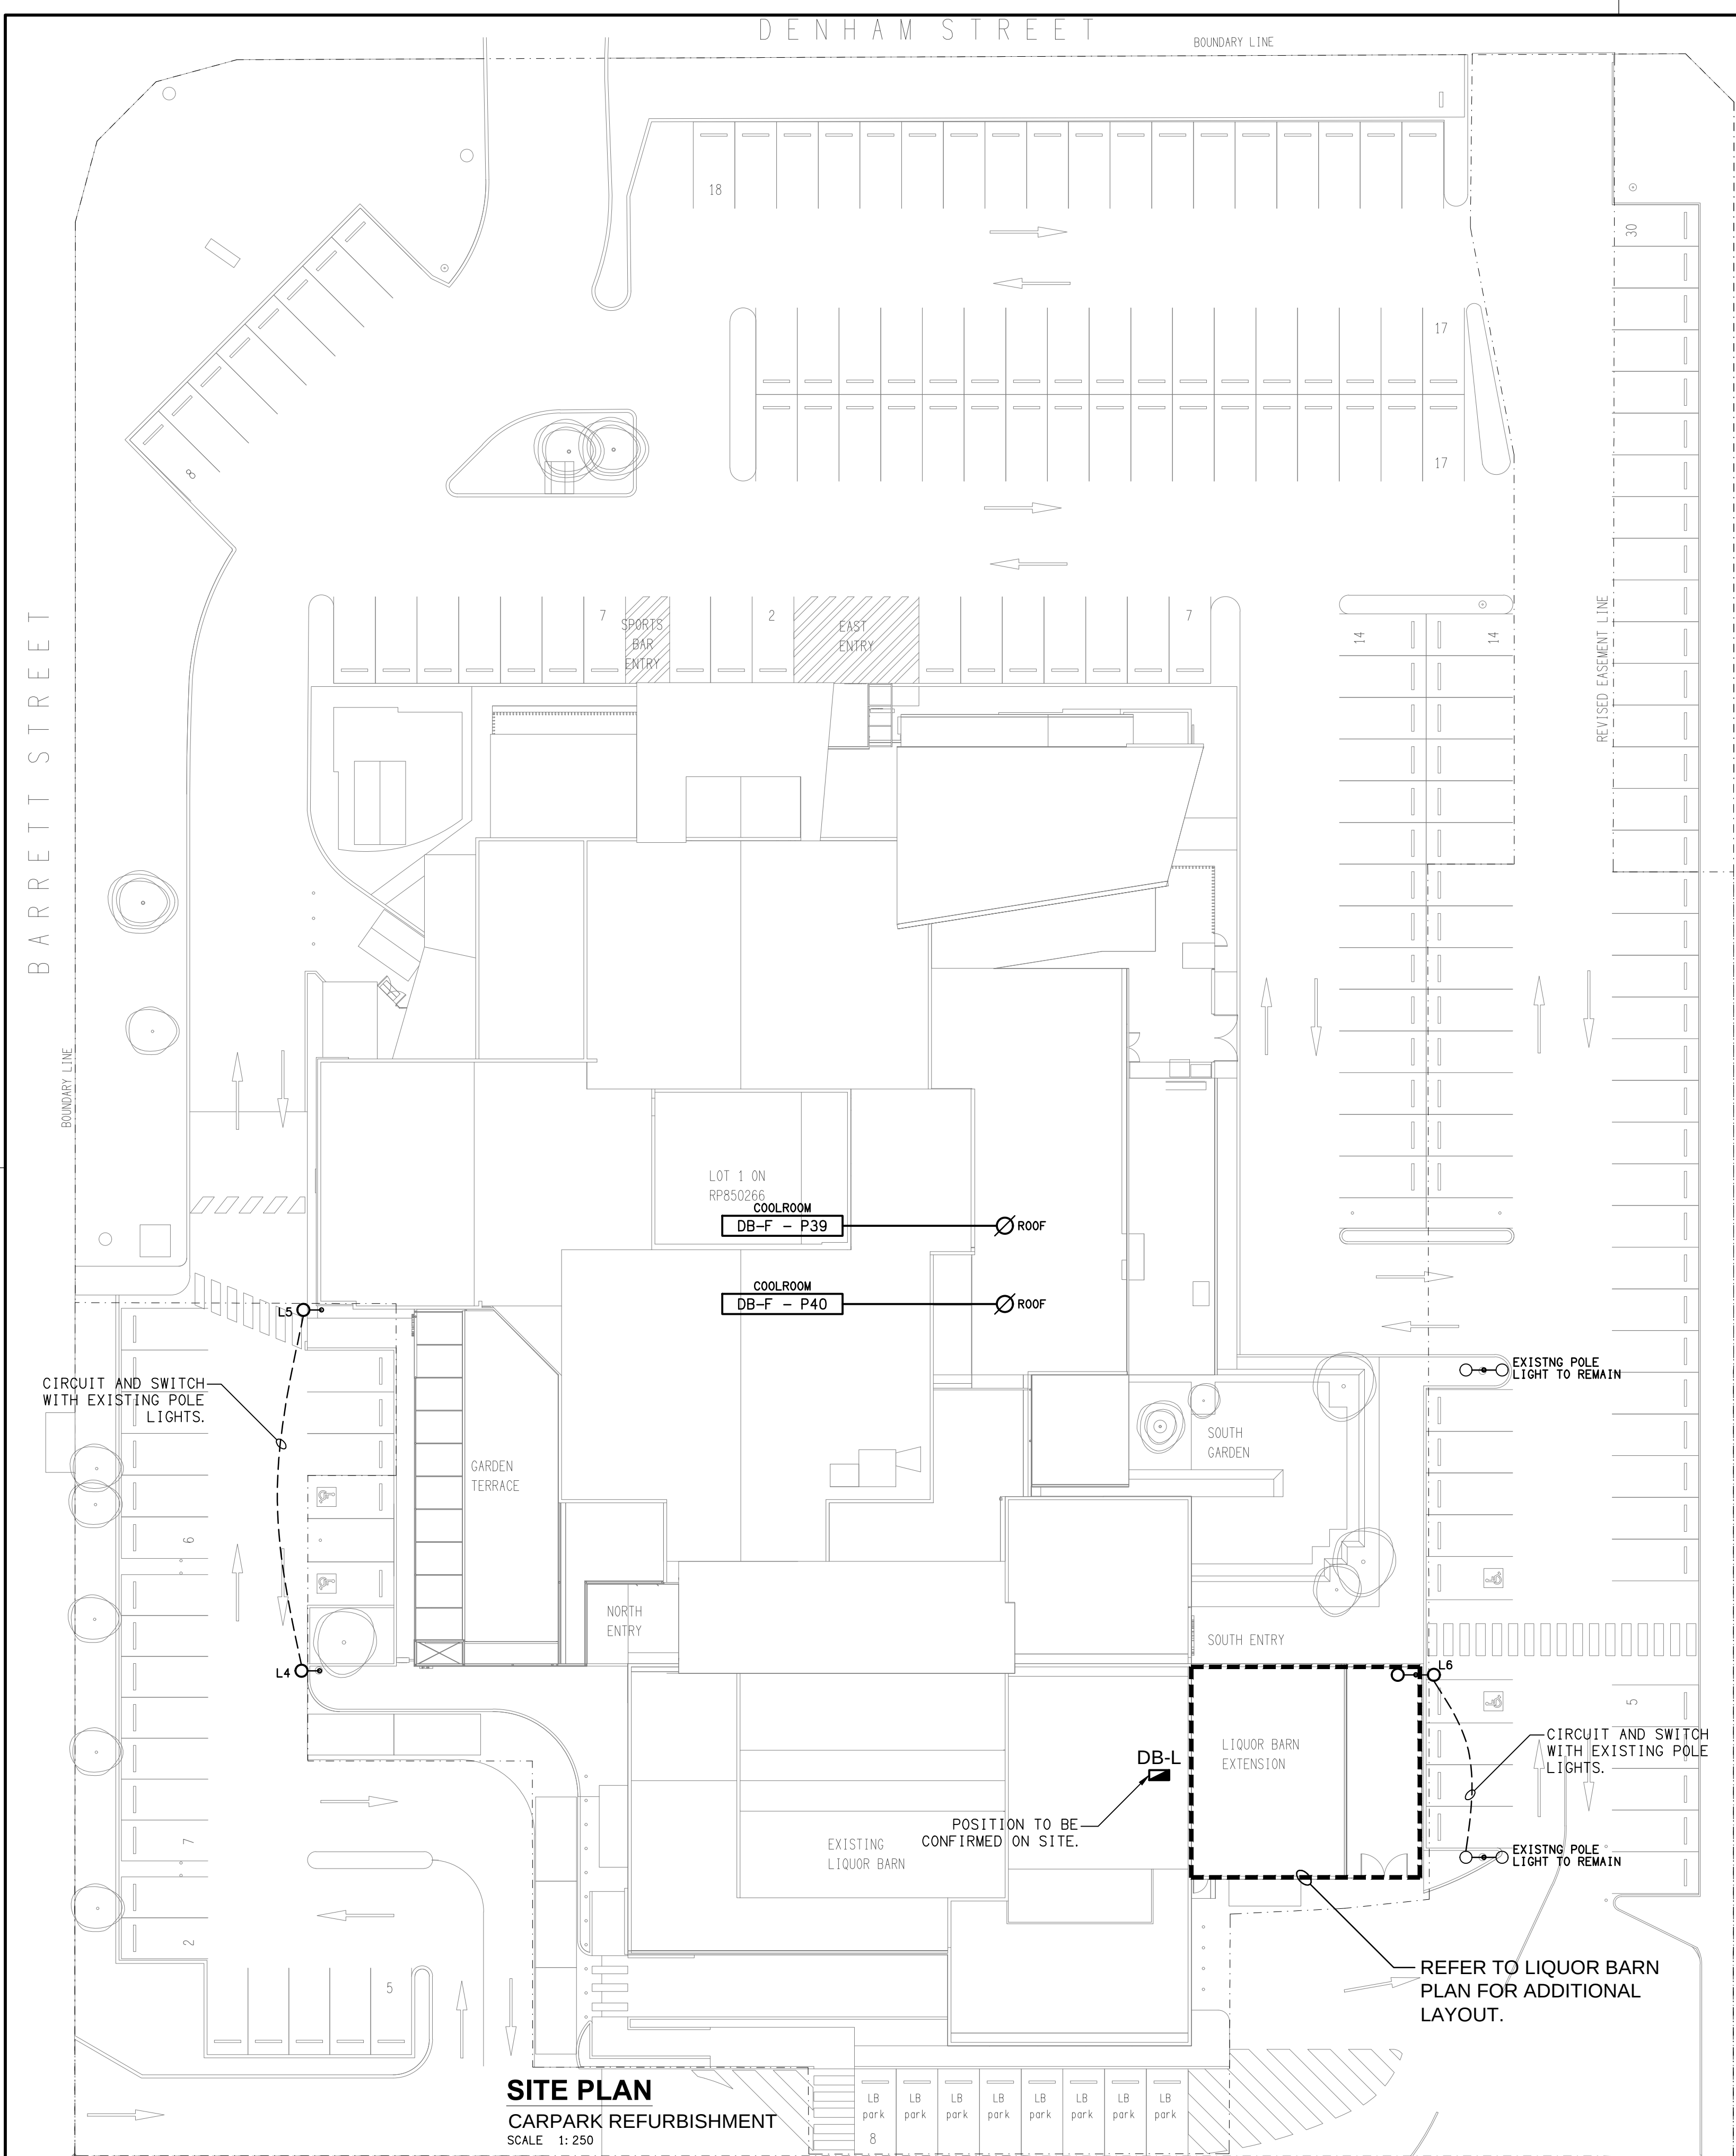

SITE PLAN
CARPARK REFURBISHMENT
SCALE 1: 250

- NOTES:**
- PROVIDE CIRCUIT DB-L - P1 AS A 3-PHASE, 20A MCB / RCD PROTECTED 2.5mm² CIRCUIT FROM DB-L.
 - PROVIDE CIRCUIT DB-L - P2 AS A 1-PHASE, 20A RCBO PROTECTED 2.5mm² CIRCUIT FROM DB-L.
 - PROVIDE CIRCUIT DB-L - L1 AS A 1-PHASE, 20A RCBO PROTECTED 2.5mm² CIRCUIT FROM DB-L.

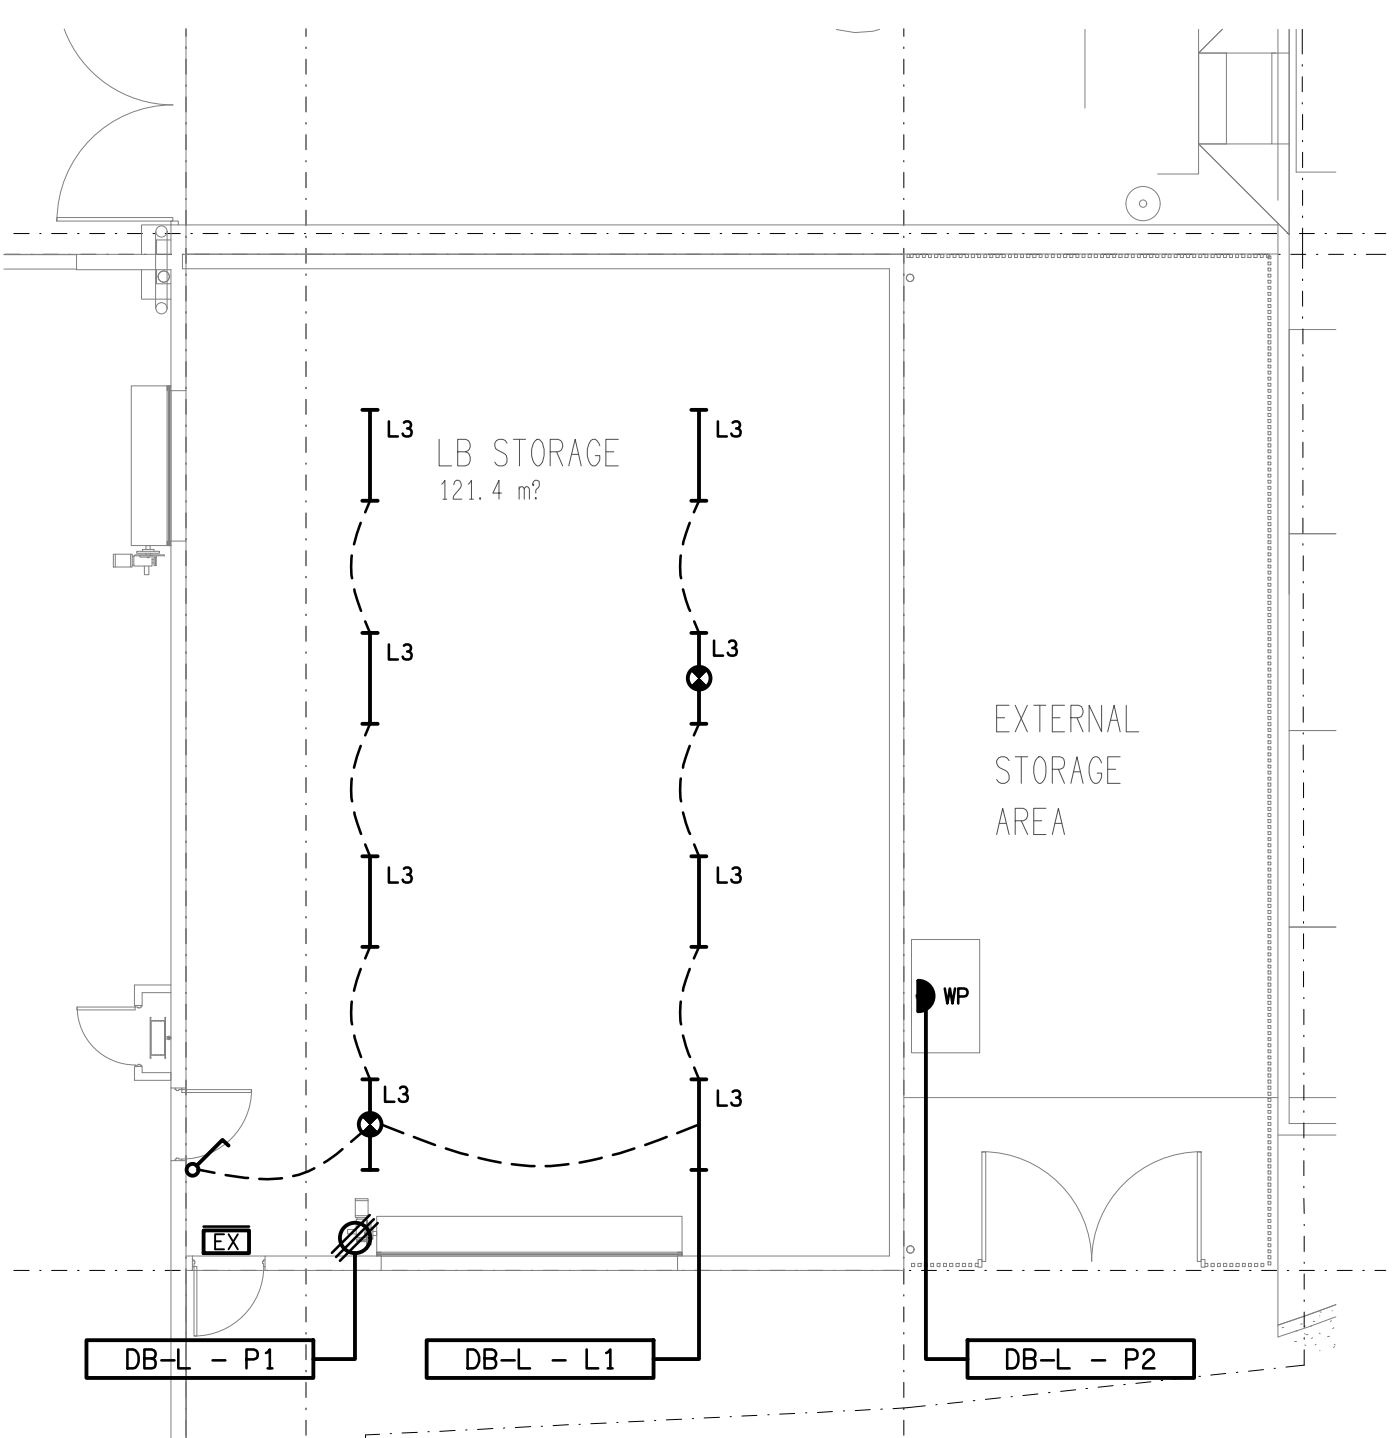

LIQUOR BARN
FLOOR / REFLECTED CEILING PLAN
SCALE 1: 100