




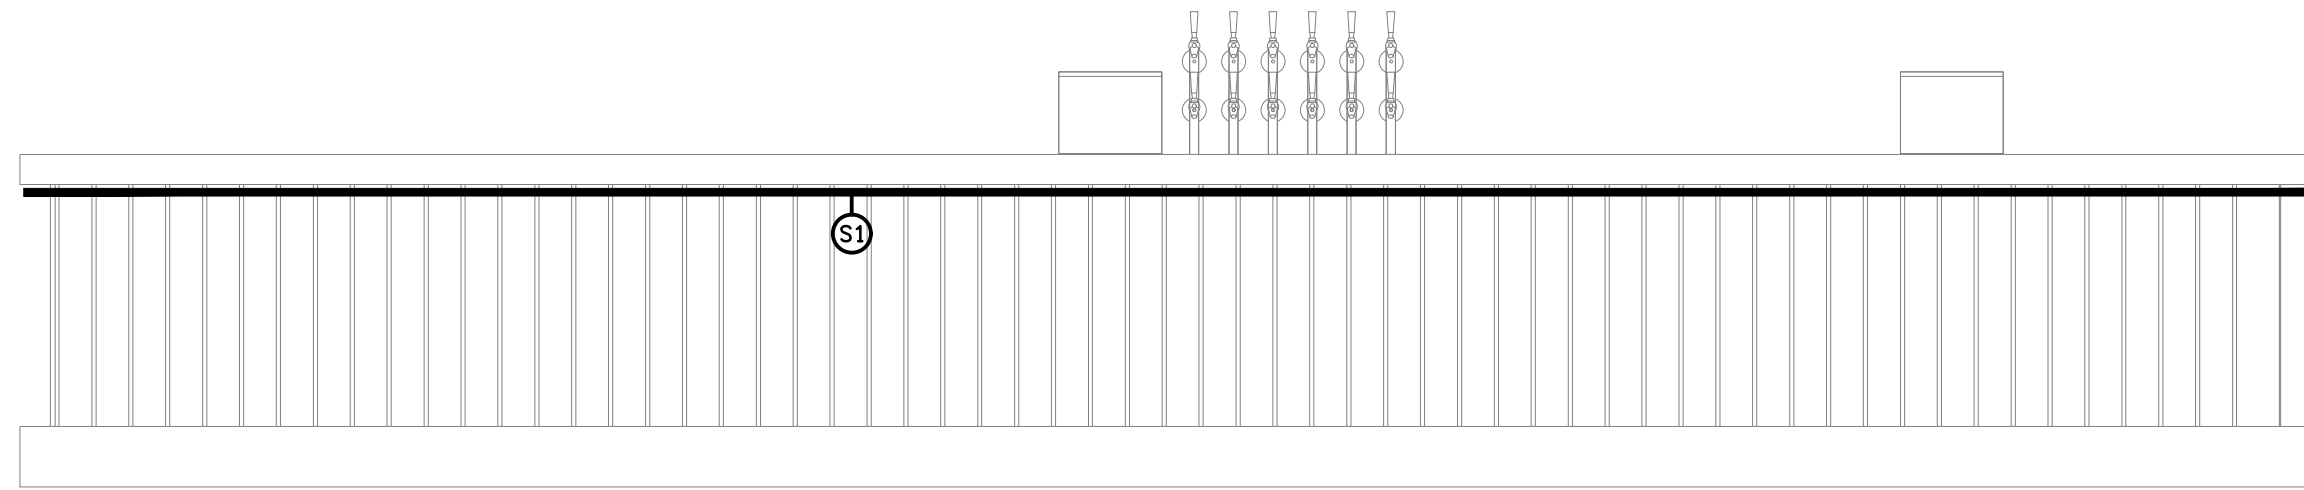

DETAIL B
SPORTS BAR FRONT COUNTER ELEVATION
SCALE 1:25

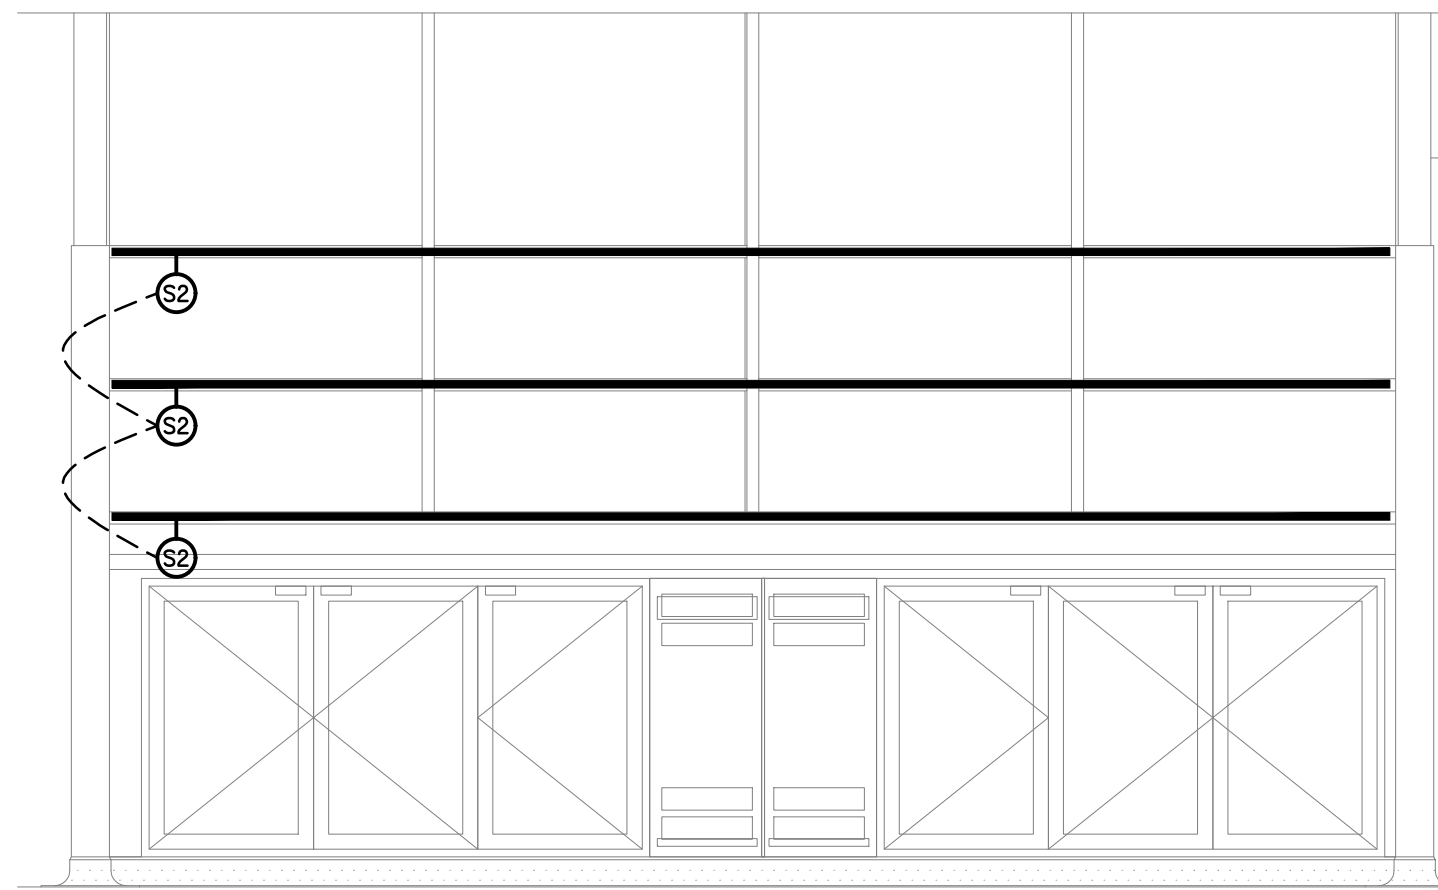

DETAIL C
SPORTS BAR REAR WALL ELEVATION
SCALE 1:25

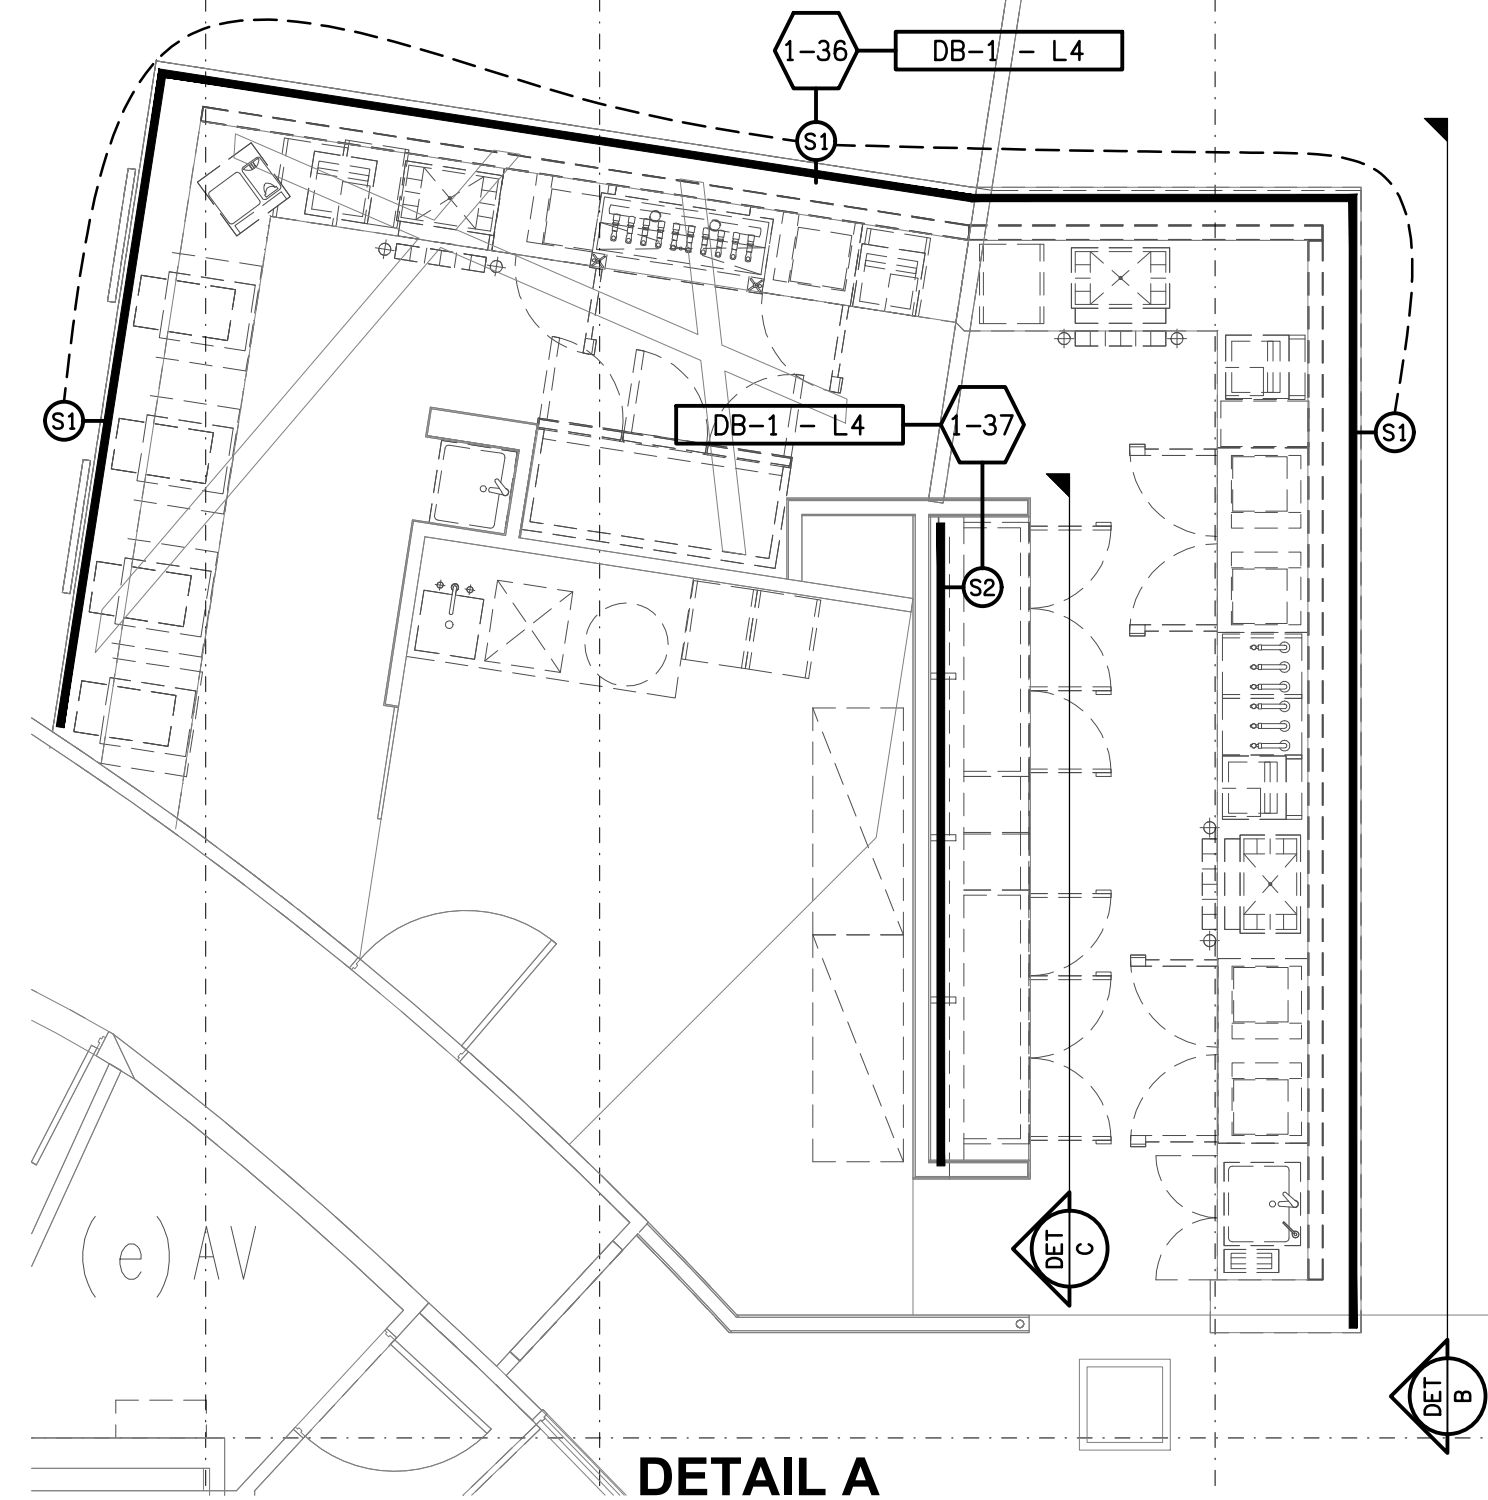

DETAIL A
SPORTS BAR LIGHTING PLAN
SCALE 1:50

