



EXISTING POWER

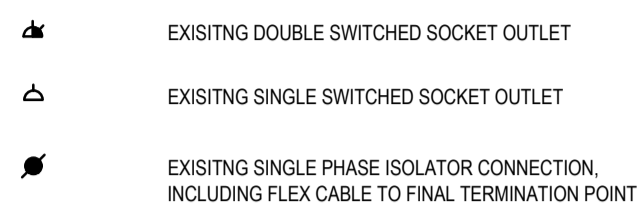


DEMOLITION POWER




PROPOSED POWER

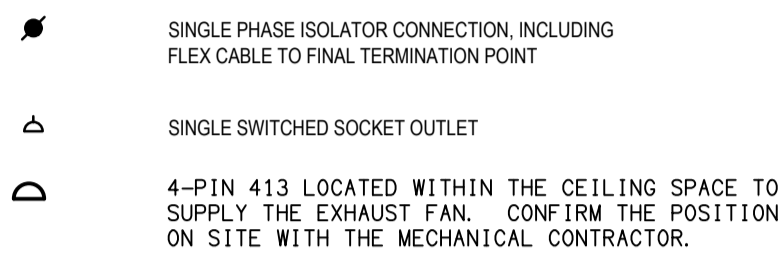


DEMOLITION LIGHTING

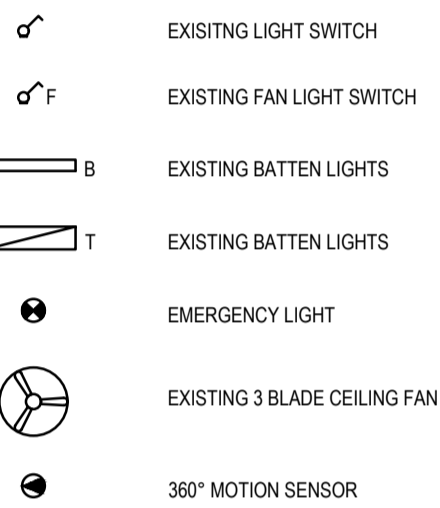

PROPOSED LIGHTING

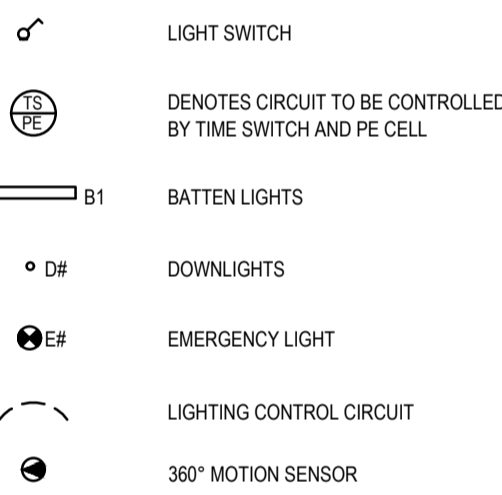



SCHEMATICS SYMBOLS

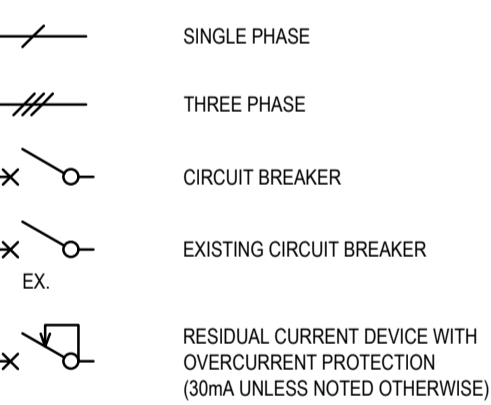


ABBREVIATIONS

AD	AUTOMATIC DOOR
CT	CHANGE TABLE
HD	HAND DRYER
HO	FUTURE HOIST
HWU	HOT WATER UNIT
IC	IN CEILING


COMMUNICATIONS

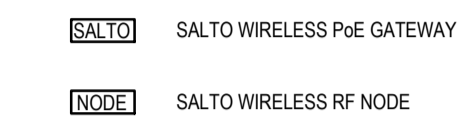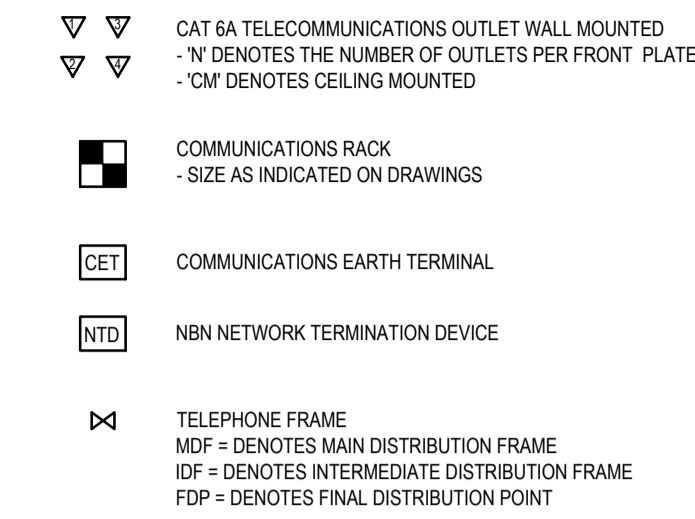


AUDIO VISUAL

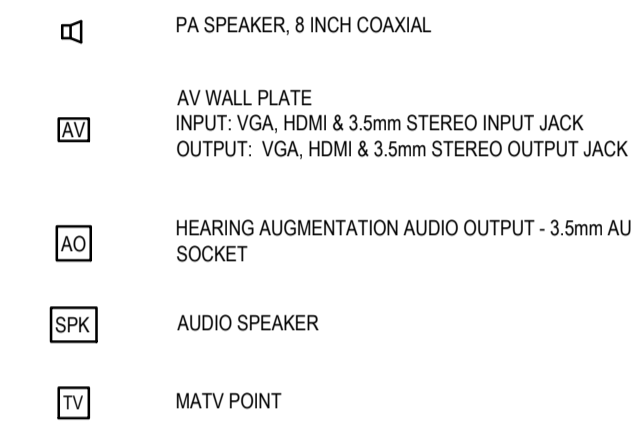

CABLE CONTAINMENT

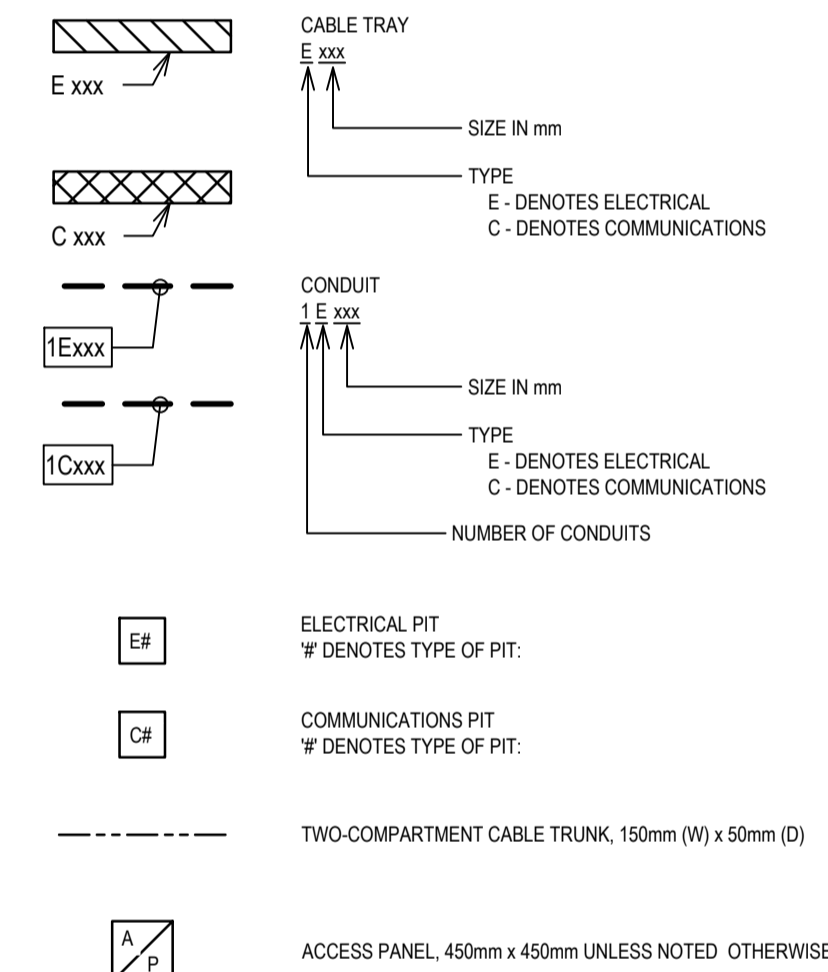

SECURITY

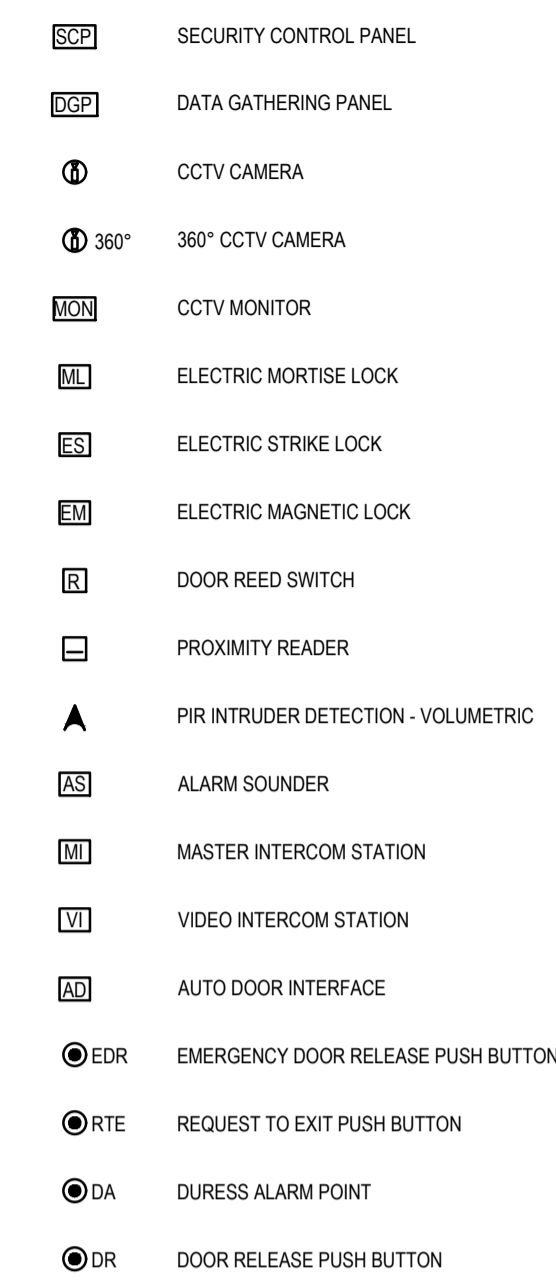

LUMINAIRE SCHEDULE

TYPE	DESCRIPTION	MANUFACTURER	PRODUCT	LIGHT SOURCE		FINISH	IP RATING	MOUNTING DETAILS/ OTHER
				Wattage	Colour Temp			
B	Batten Luminaire							
B1	1200mm Batten IK07	EVOLT	12138	40W	4000K	White	65	Surface Mounted
D	Downlights							
D1	Recessed Downlight	HANECO	HABITAT-FL-MINI	7 W	4000K	White	54	Recessed
D2	Recessed Downlight	HANECO	HABITAT-FL-TRI	10 W	4000K	White	54	Recessed
E	Emergency Luminaires							
E1	Recessed Emergency Light	EKTOR	11190		C90: D40 C0: D40	White	44	Recessed



SITE PLAN
AMENITIES UPGRADE
SCALE 1:1000 (APPROX.)

B	APPROVAL	11/10/2024
REV.	DESCRIPTION:	DATE:
DRAWING: ELECTRICAL SERVICES LEGEND & SITE PLAN		
SCALE: AS NOTED	AT A1	PROJECT NO: C3388a
		DRAWING NO: E01
		REVISION: B

ELECTRICAL DESIGN GROUP BRISBANE PTY LTD
ACN 092 710 793
TRADING AS:
ELECTRICAL DESIGN GROUP

THE COPYRIGHT OF THIS DRAWING REMAINS THE PROPERTY OF THE ELECTRICAL DESIGN GROUP.
USE FIGURED DIMENSIONS IN PREFERENCE TO SCALE.
ALL DIMENSIONS TO BE VERIFIED ONSITE.

ASW
ELECTRICAL
WIRED TO DELIVER

E: info@aswelectrical.com.au
M: 0450 440 569
www.aswelectrical.com.au

ELECTRICAL DESIGN GROUP
ELECTRICAL BUILDING SERVICES CONSULTANTS
BRISBANE GOLD COAST

P.O. Box 15, Sherwood Q.4075
Phone: (07) 3278 4375
Email: brisbane@edg.net.au
Web: www.edg.net.au

PROJECT:
**BOONAH STATE HIGH SCHOOL
AMENITIES UPGRADE**

32 MACQUARIE STREET, BOONAH, QUEENSLAND