


**EXISTING / DEMOLITION**  
LIGHTING LAYOUT  
SCALE 1: 50

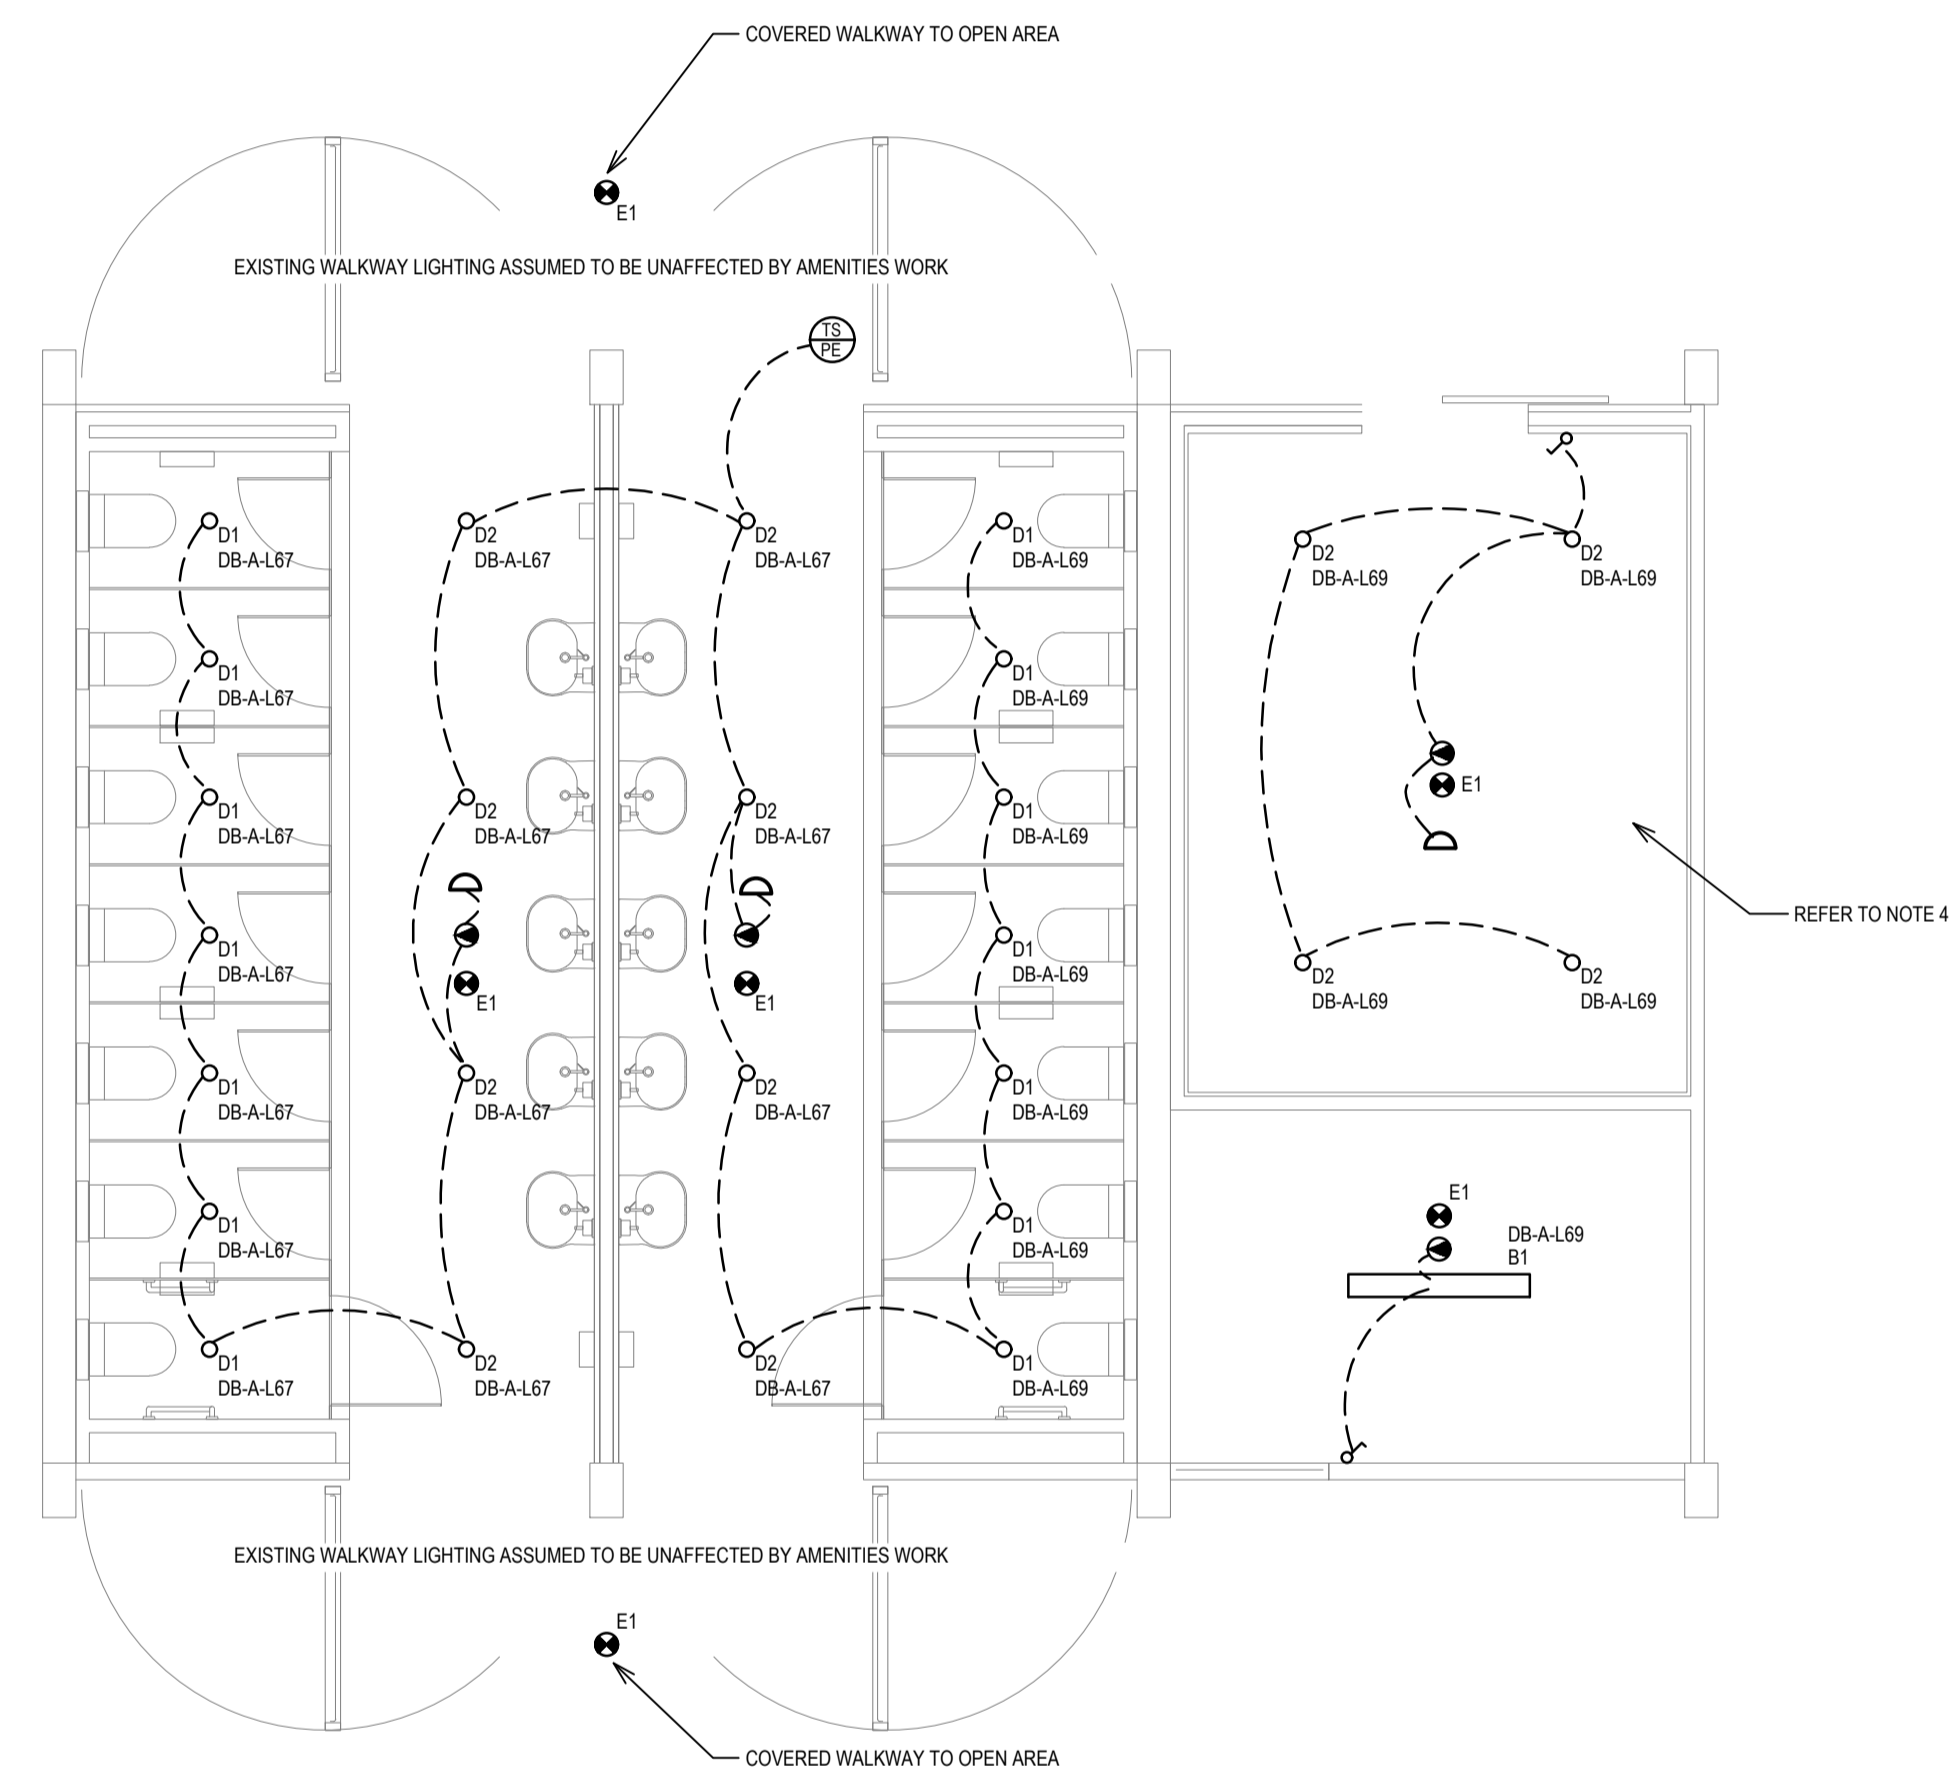

**PROPOSED**  
LIGHTING LAYOUT JUNIOR STUDENTS  
SCALE 1: 50

ELECTRICAL DESIGN GROUP BRISBANE  
PTY LTD  
ACN 092 710 793  
TRADING AS:  
ELECTRICAL DESIGN GROUP

THE COPYRIGHT OF THIS DRAWING  
REMAINS THE PROPERTY OF THE  
ELECTRICAL DESIGN GROUP.  
USE FIGURED DIMENSIONS  
IN PREFERENCE TO SCALE.  
ALL DIMENSIONS TO BE  
VERIFIED ONSITE.



E: info@aswelectrical.com.au  
M: 0450 440 569  
www.aswelectrical.com.au

**ELECTRICAL DESIGN GROUP**  
ELECTRICAL BUILDING SERVICES CONSULTANTS  
BRISBANE GOLD COAST

P.O. Box 15, Sherwood Q.4075  
Phone: (07) 3278 4375  
Email: brisbane@edg.net.au  
Web: www.edg.net.au

PROJECT:  
**BOONAH STATE HIGH SCHOOL  
AMENITIES UPGRADE**  
32 MACQUARIE STREET, BOONAH, QUEENSLAND

B	APPROVAL	11/10/2024
REV:	DESCRIPTION:	DATE:

DRAWING: <b>ELECTRICAL SERVICES BLOCK A - AMENITIES JUNIOR LIGHTING LAYOUTS</b>			
SCALE: 1:50	AT A1	PROJECT NO: <b>C3388a</b>	DRAWING NO: <b>E02</b>
		REVISION: <b>B</b>	