


EXISTING / DEMOLITION
 LIGHTING LAYOUT
 SCALE 1: 50

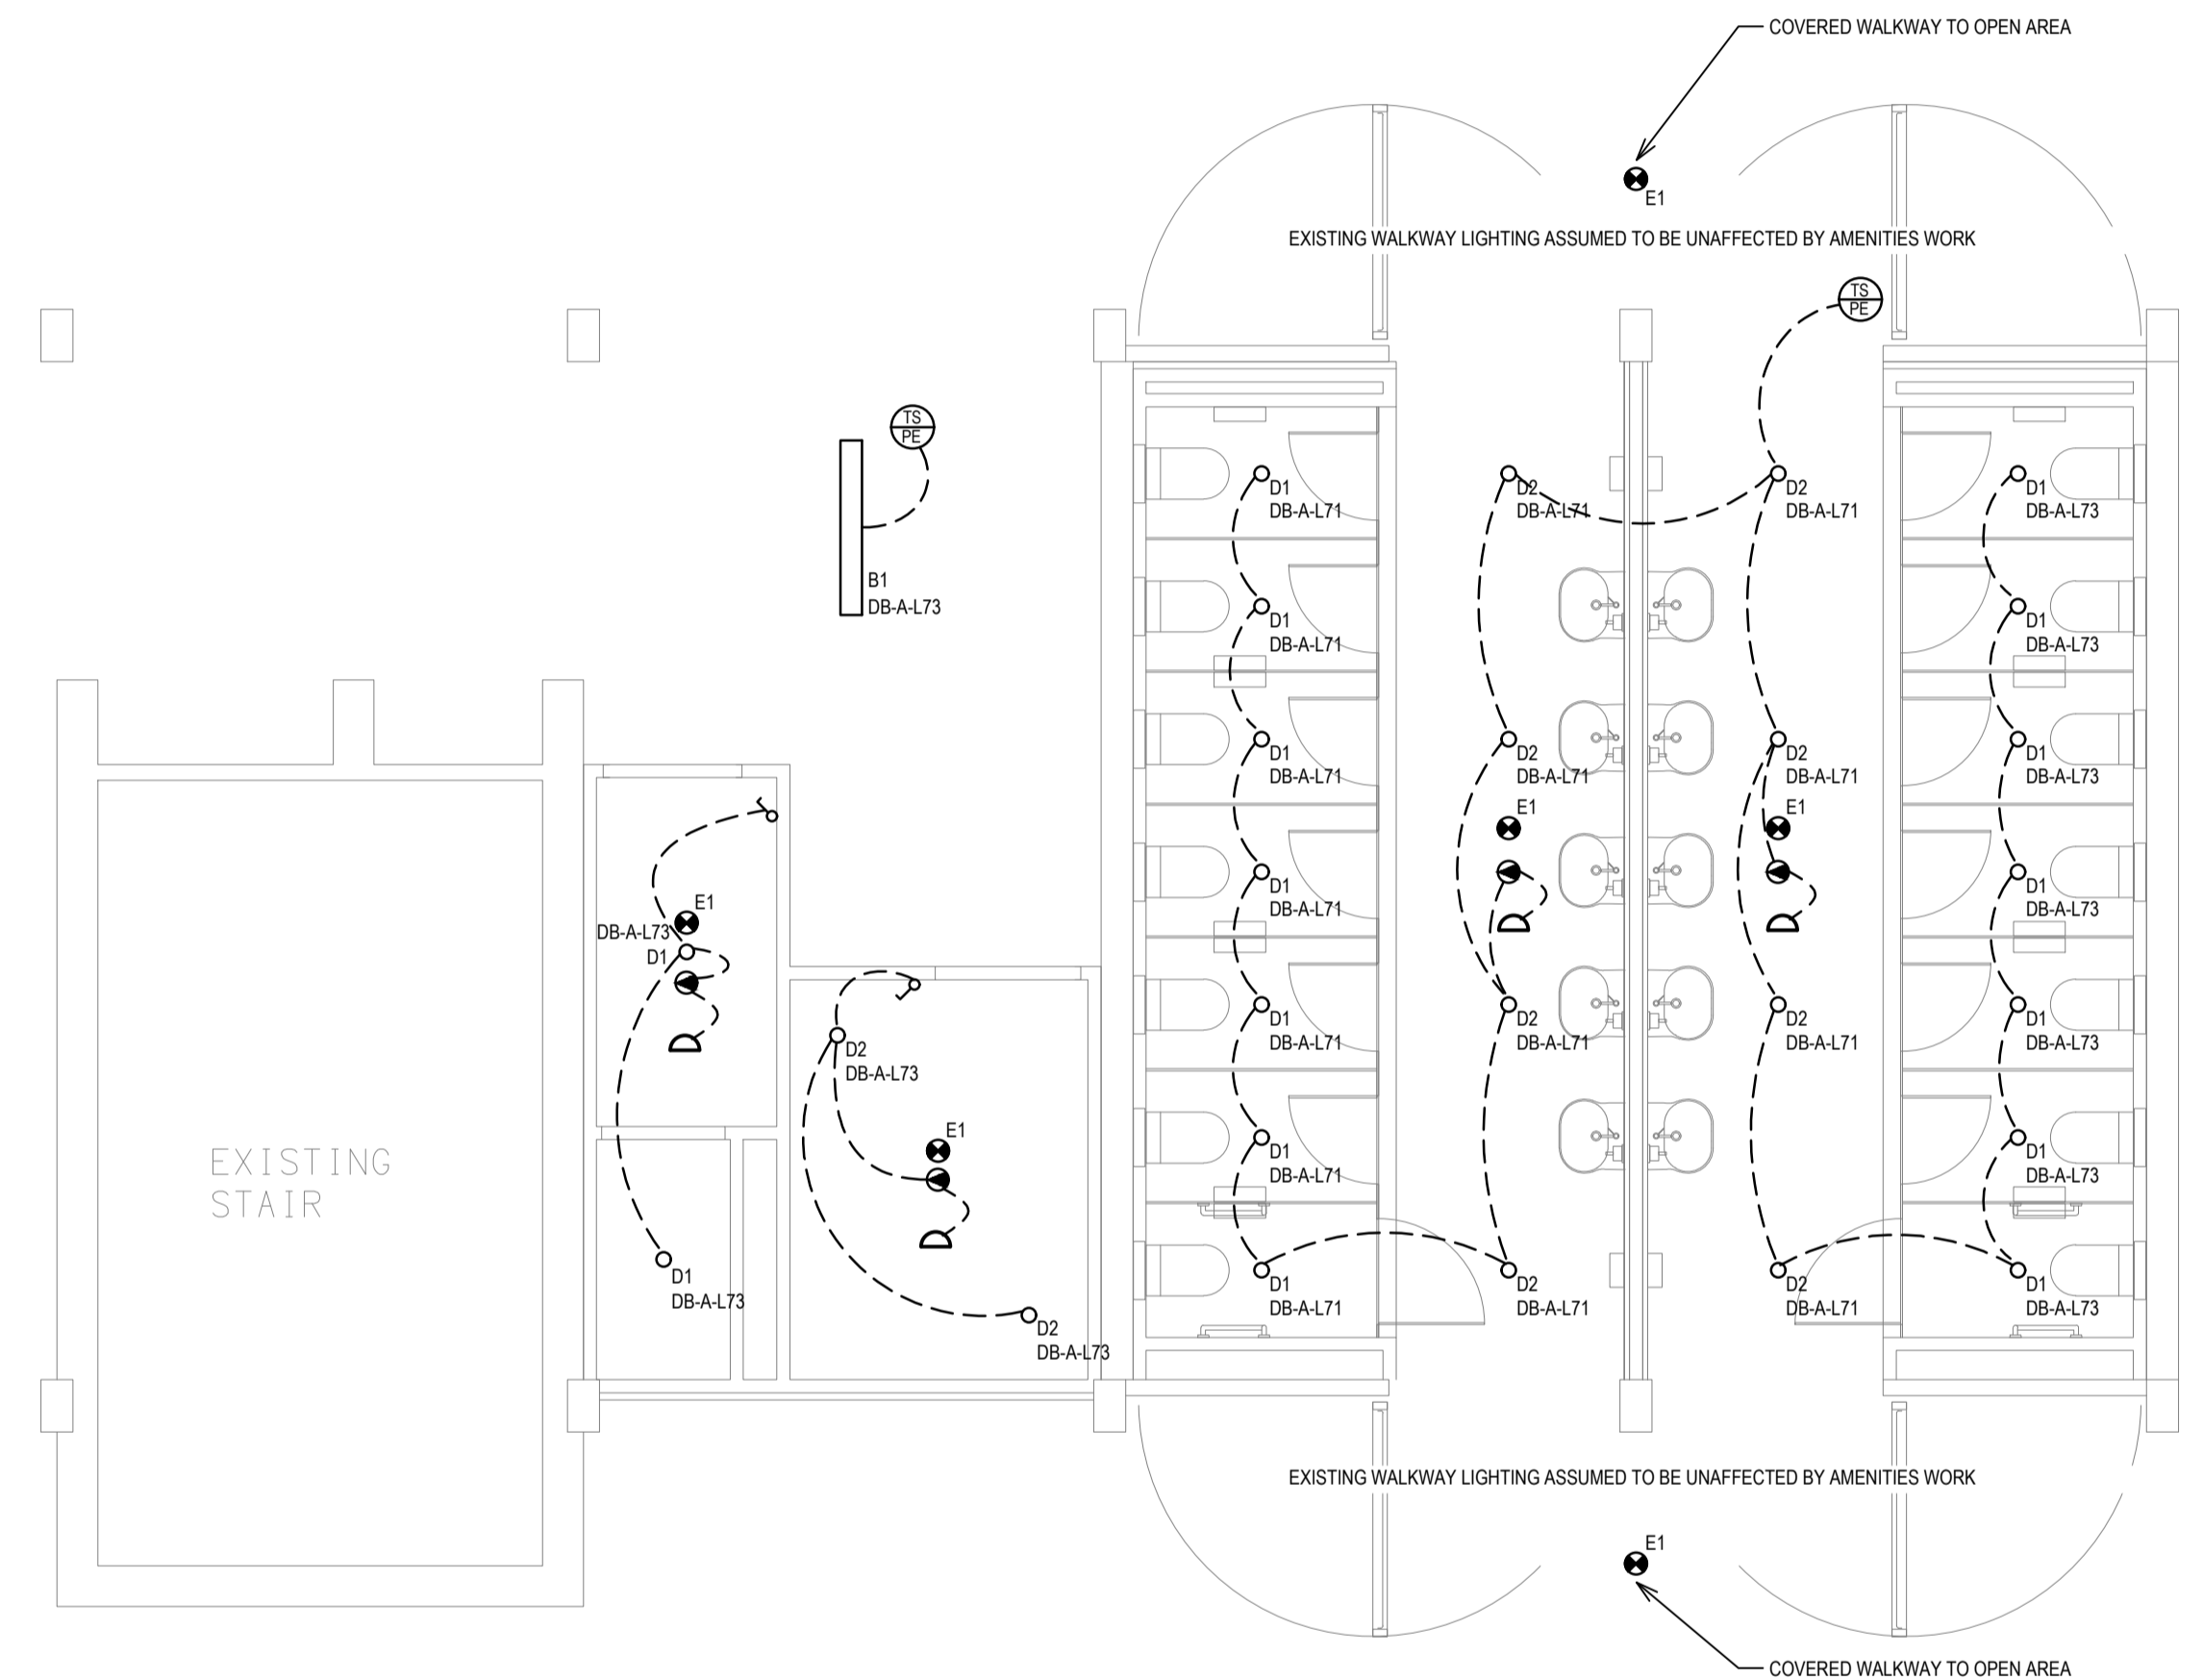

PROPOSED
 LIGHTING LAYOUT SENIOR STUDENTS
 SCALE 1: 50

ELECTRICAL DESIGN GROUP BRISBANE
 PTY LTD
 ACN 092 710 793
 TRADING AS:
 ELECTRICAL DESIGN GROUP

THE COPYRIGHT OF THIS DRAWING
 REMAINS THE PROPERTY OF THE
 ELECTRICAL DESIGN GROUP.
 USE FIGURED DIMENSIONS
 IN PREFERENCE TO SCALE.
 ALL DIMENSIONS TO BE
 VERIFIED ONSITE.



E: info@aswelectrical.com.au
 M: 0450 440 569
 www.aswelectrical.com.au

ELECTRICAL DESIGN GROUP
 ELECTRICAL BUILDING SERVICES CONSULTANTS
 BRISBANE GOLD COAST

P.O. Box 15, Sherwood Q.4075
 Phone: (07) 3278 4375
 Email: brisbane@edg.net.au
 Web: www.edg.net.au

PROJECT:
**BOONAH STATE HIGH SCHOOL
 AMENITIES UPGRADE**
 32 MACQUARIE STREET, BOONAH, QUEENSLAND

B	APPROVAL	11/10/2024
REV:	DESCRIPTION:	DATE:
DRAWING: ELECTRICAL SERVICES BLOCK B - AMENITIES SENIOR LIGHTING LAYOUTS		
SCALE: 1:50	PROJECT NO: C3388a	DRAWING NO: E03
AT A1	REVISION: B	