


EXISTING / DEMOLITION
POWER & COMMUNICATIONS LAYOUT
SCALE 1: 50

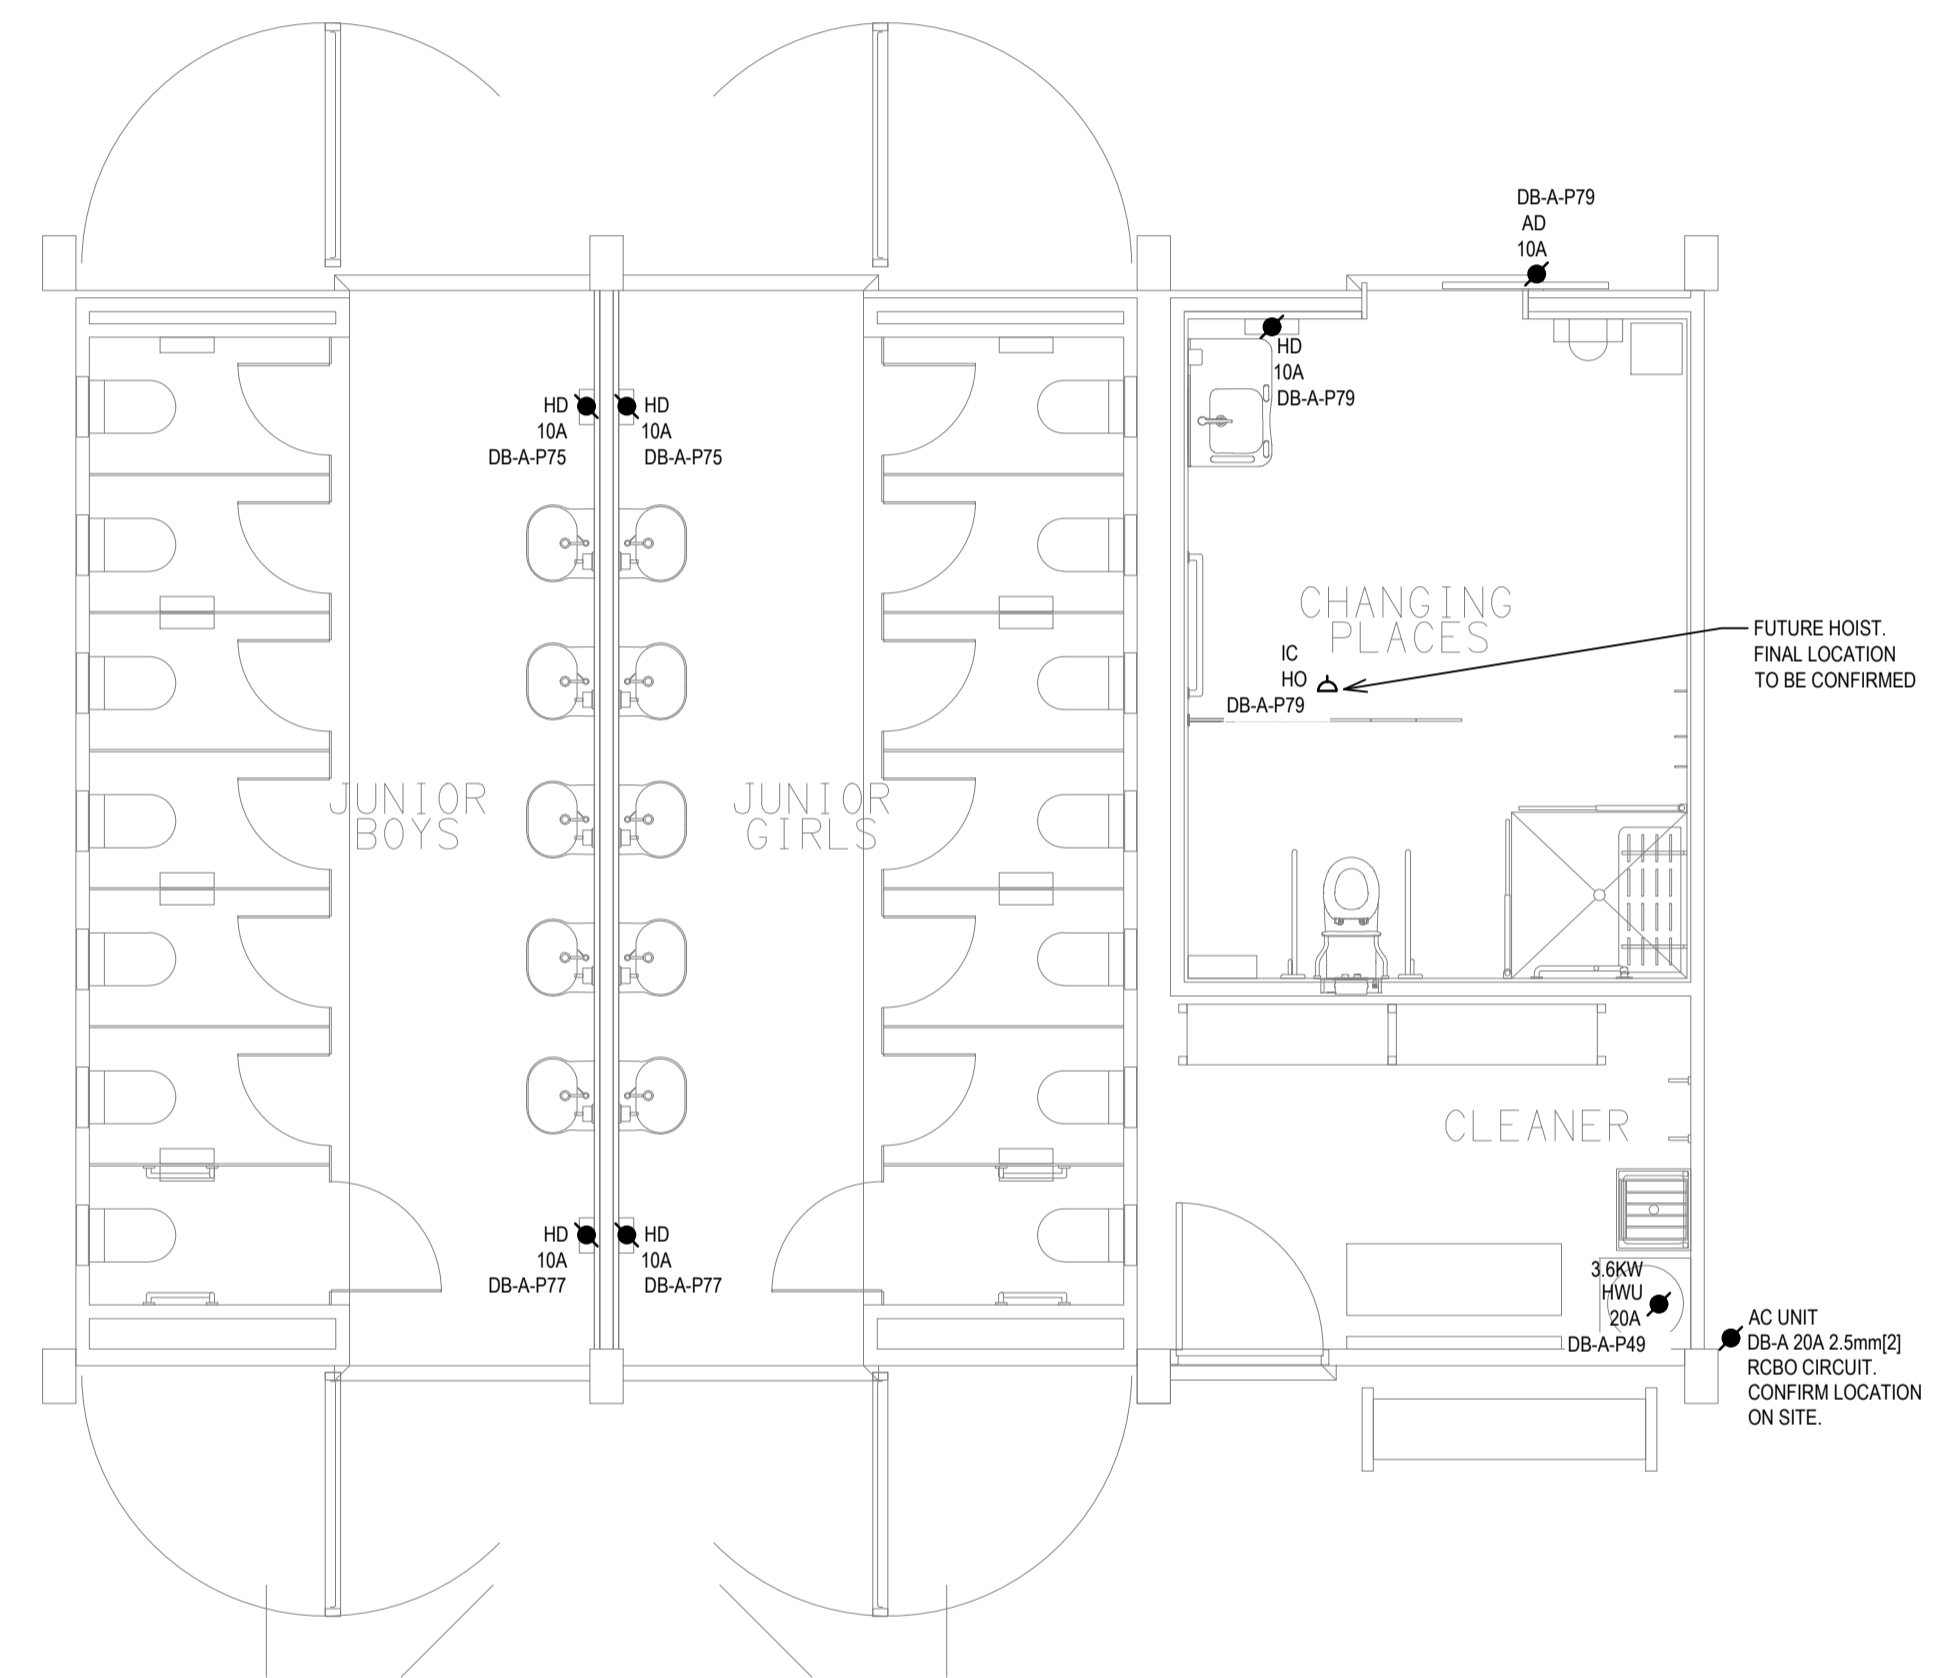

PROPOSED
POWER & COMMUNICATIONS LAYOUT JUNIOR STUDENTS
SCALE 1: 50

ELECTRICAL DESIGN GROUP BRISBANE
PTY LTD
ACN 092 710 793
TRADING AS:
ELECTRICAL DESIGN GROUP

THE COPYRIGHT OF THIS DRAWING
REMAINS THE PROPERTY OF THE
ELECTRICAL DESIGN GROUP.

USE FIGURED DIMENSIONS
IN PREFERENCE TO SCALE.

ALL DIMENSIONS TO BE
VERIFIED ONSITE.



E: info@aswelectrical.com.au
M: 0450 440 569
www.aswelectrical.com.au

ELECTRICAL DESIGN GROUP
ELECTRICAL BUILDING SERVICES CONSULTANTS
BRISBANE GOLD COAST

P.O.Box 15, Sherwood Q.4075
Phone: (07) 3278 4375
Email: brisbane@edg.net.au
Web: www.edg.net.au

PROJECT:
**BOONAH STATE HIGH SCHOOL
AMENITIES UPGRADE**

32 MACQUARIE STREET, BOONAH, QUEENSLAND

| | | |
|------|--------------|------------|
| B | APPROVAL | 11/10/2024 |
| REV: | DESCRIPTION: | DATE: |

DRAWING:
**ELECTRICAL SERVICES
BLOCK A - AMENITIES JUNIOR POWER &
COMMUNICATIONS LAYOUTS**

| | | | | |
|----------------|-------|------------------------------|---------------------------|-----------------------|
| SCALE: 1:50 | AT A1 | PROJECT NO: C3388a | DRAWING NO: E04 | REVISION: B |
|----------------|-------|------------------------------|---------------------------|-----------------------|