


**EXISTING / DEMOLITION**  
 POWER & COMMUNICATIONS LAYOUT  
 SCALE 1:50

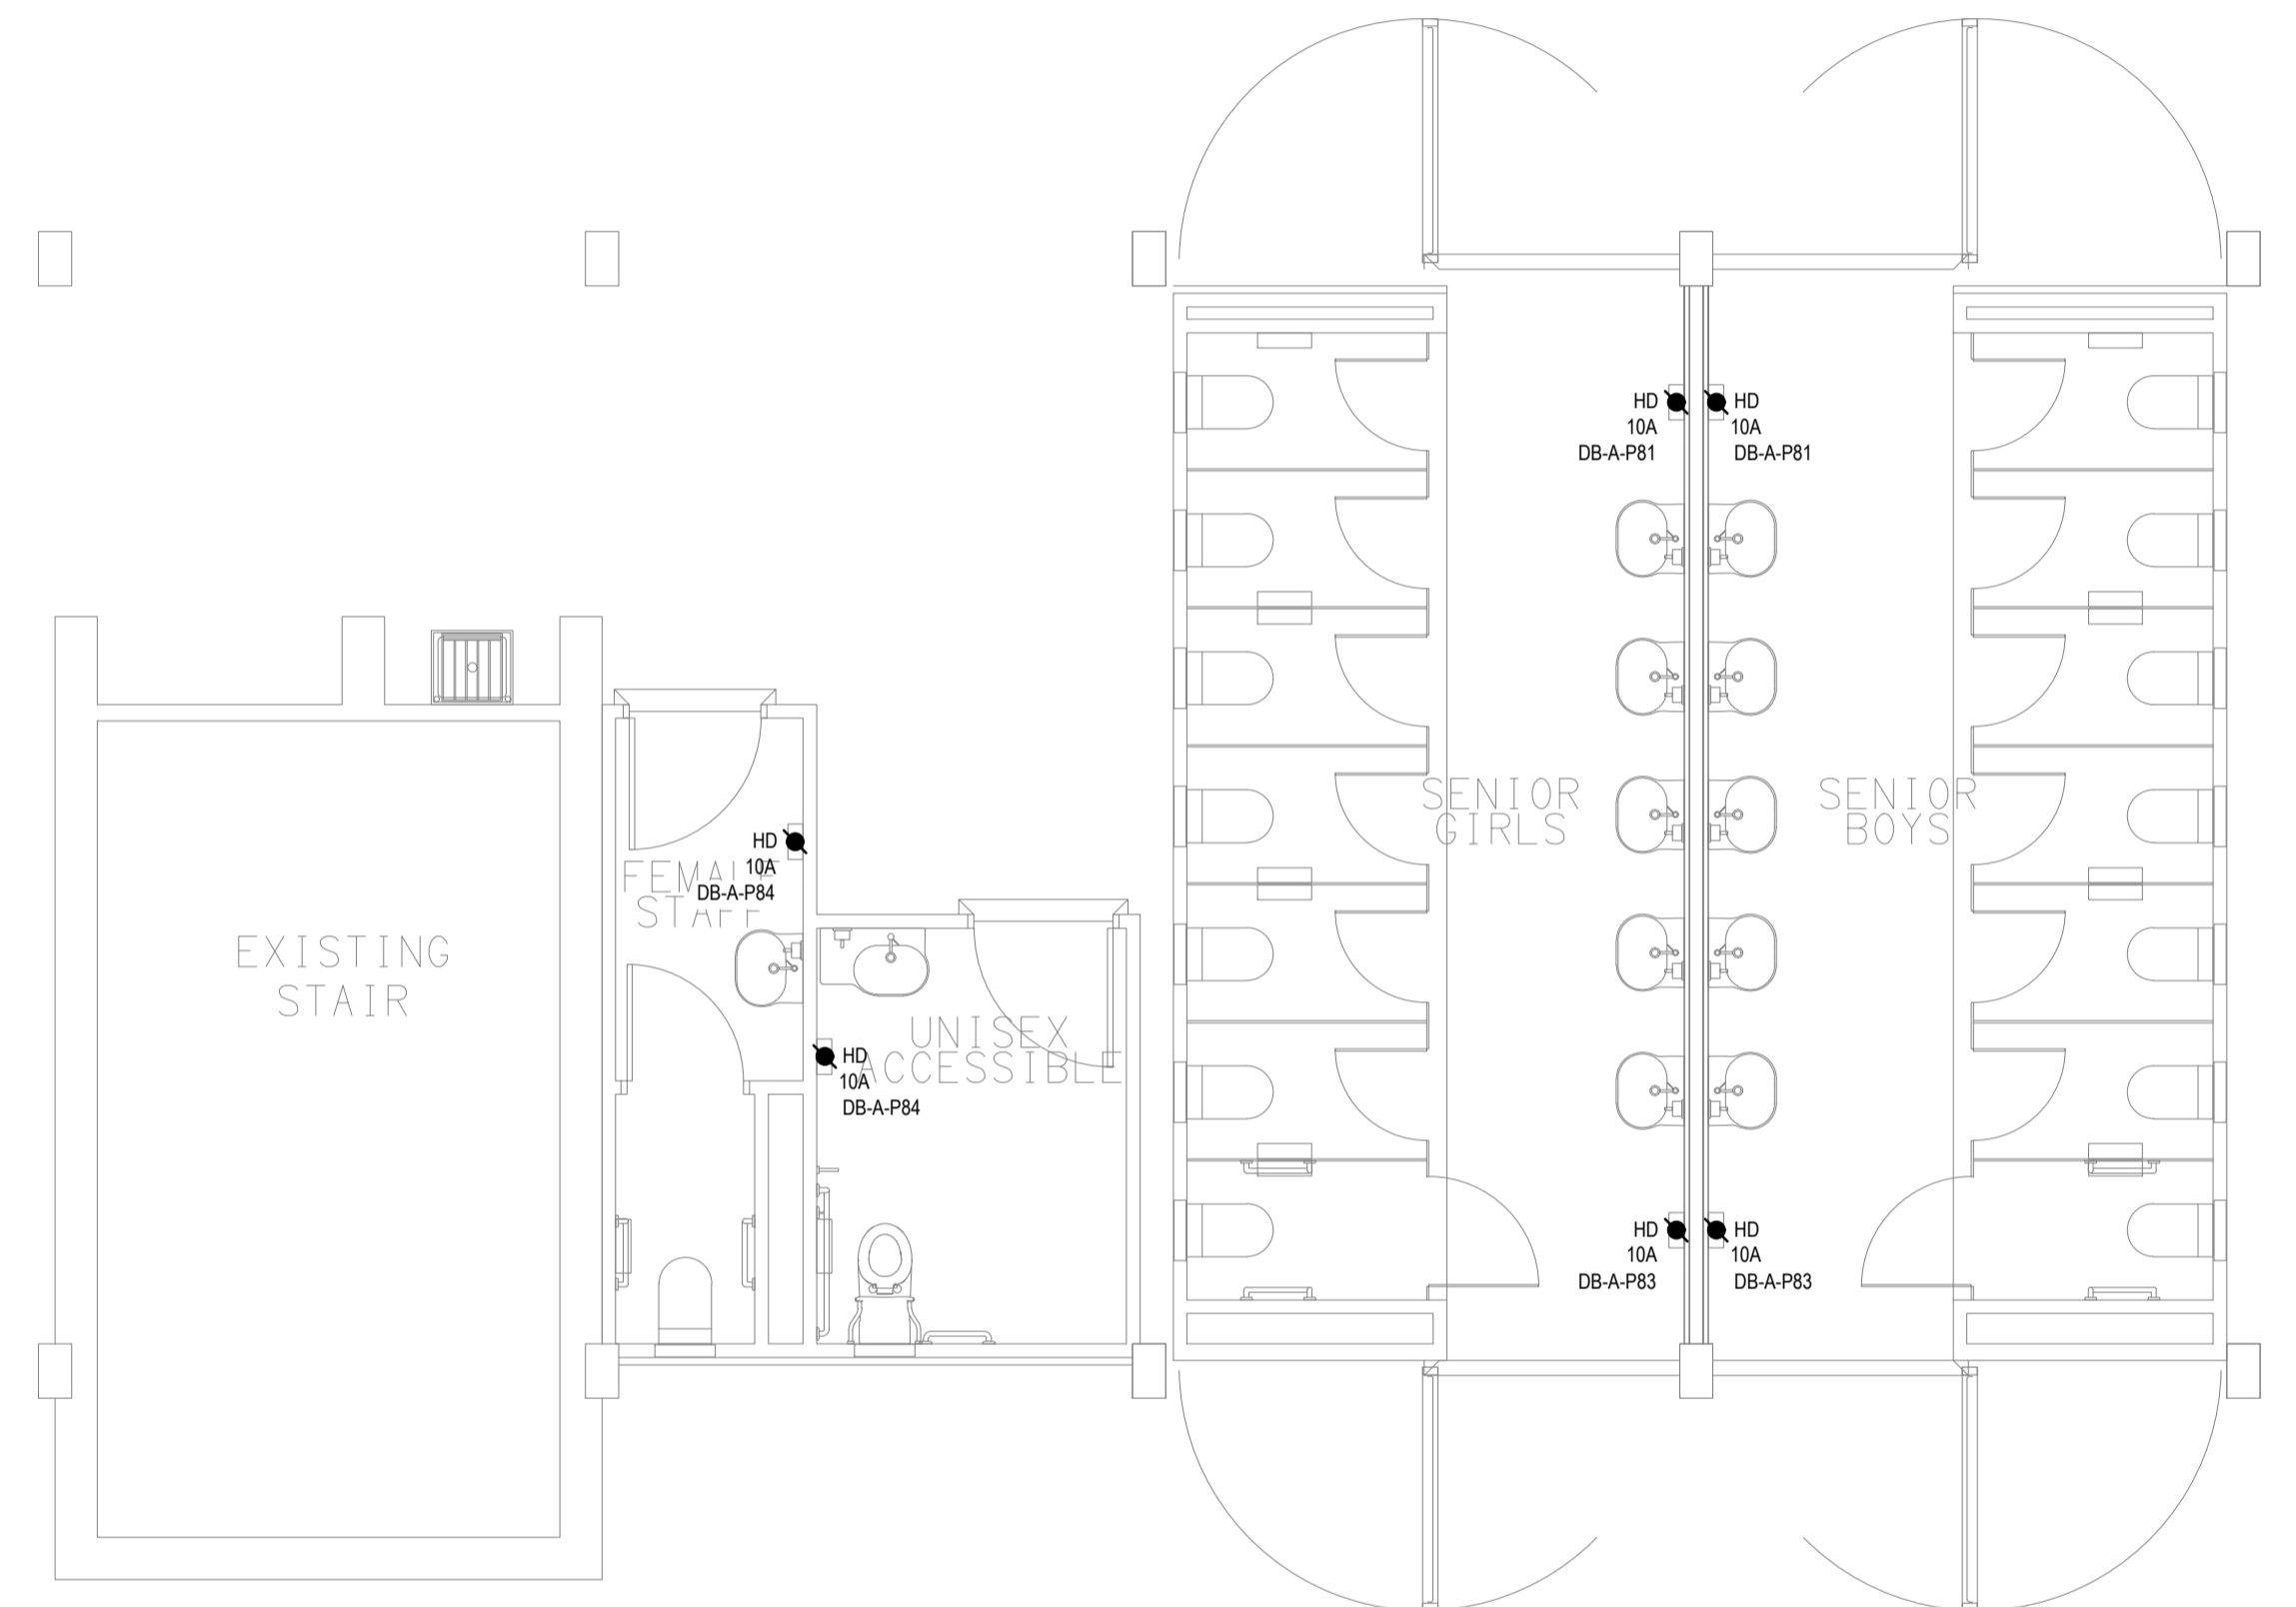

**PROPOSED**  
 POWER & COMMUNICATIONS LAYOUT SENIOR STUDENTS  
 SCALE 1:50

ELECTRICAL DESIGN GROUP BRISBANE  
 PTY LTD  
 ACN 092 710 793  
 TRADING AS:  
 ELECTRICAL DESIGN GROUP

THE COPYRIGHT OF THIS DRAWING  
 REMAINS THE PROPERTY OF THE  
 ELECTRICAL DESIGN GROUP.  
 USE FIGURED DIMENSIONS  
 IN PREFERENCE TO SCALE.  
 ALL DIMENSIONS TO BE  
 VERIFIED ONSITE.



E: info@aswelectrical.com.au  
 M: 0450 440 569  
 www.aswelectrical.com.au

**ELECTRICAL DESIGN GROUP**  
 ELECTRICAL BUILDING SERVICES CONSULTANTS  
 BRISBANE GOLD COAST

P.O. Box 15, Sherwood Q.4075  
 Phone: (07) 3278 4375  
 Email: brisbane@edg.net.au  
 Web: www.edg.net.au

PROJECT:  
**BOONAH STATE HIGH SCHOOL  
 AMENITIES UPGRADE**  
 32 MACQUARIE STREET, BOONAH, QUEENSLAND

B	APPROVAL	11/10/2024
REV:	DESCRIPTION:	DATE:
DRAWING: <b>ELECTRICAL SERVICES    BLOCK B - AMENITIES SENIOR POWER &amp;    COMMUNICATIONS LAYOUTS</b>		
SCALE: 1:50	PROJECT NO: <b>C3388a</b>	DRAWING NO: <b>E05</b>
AT A1	REVISION: <b>B</b>	