


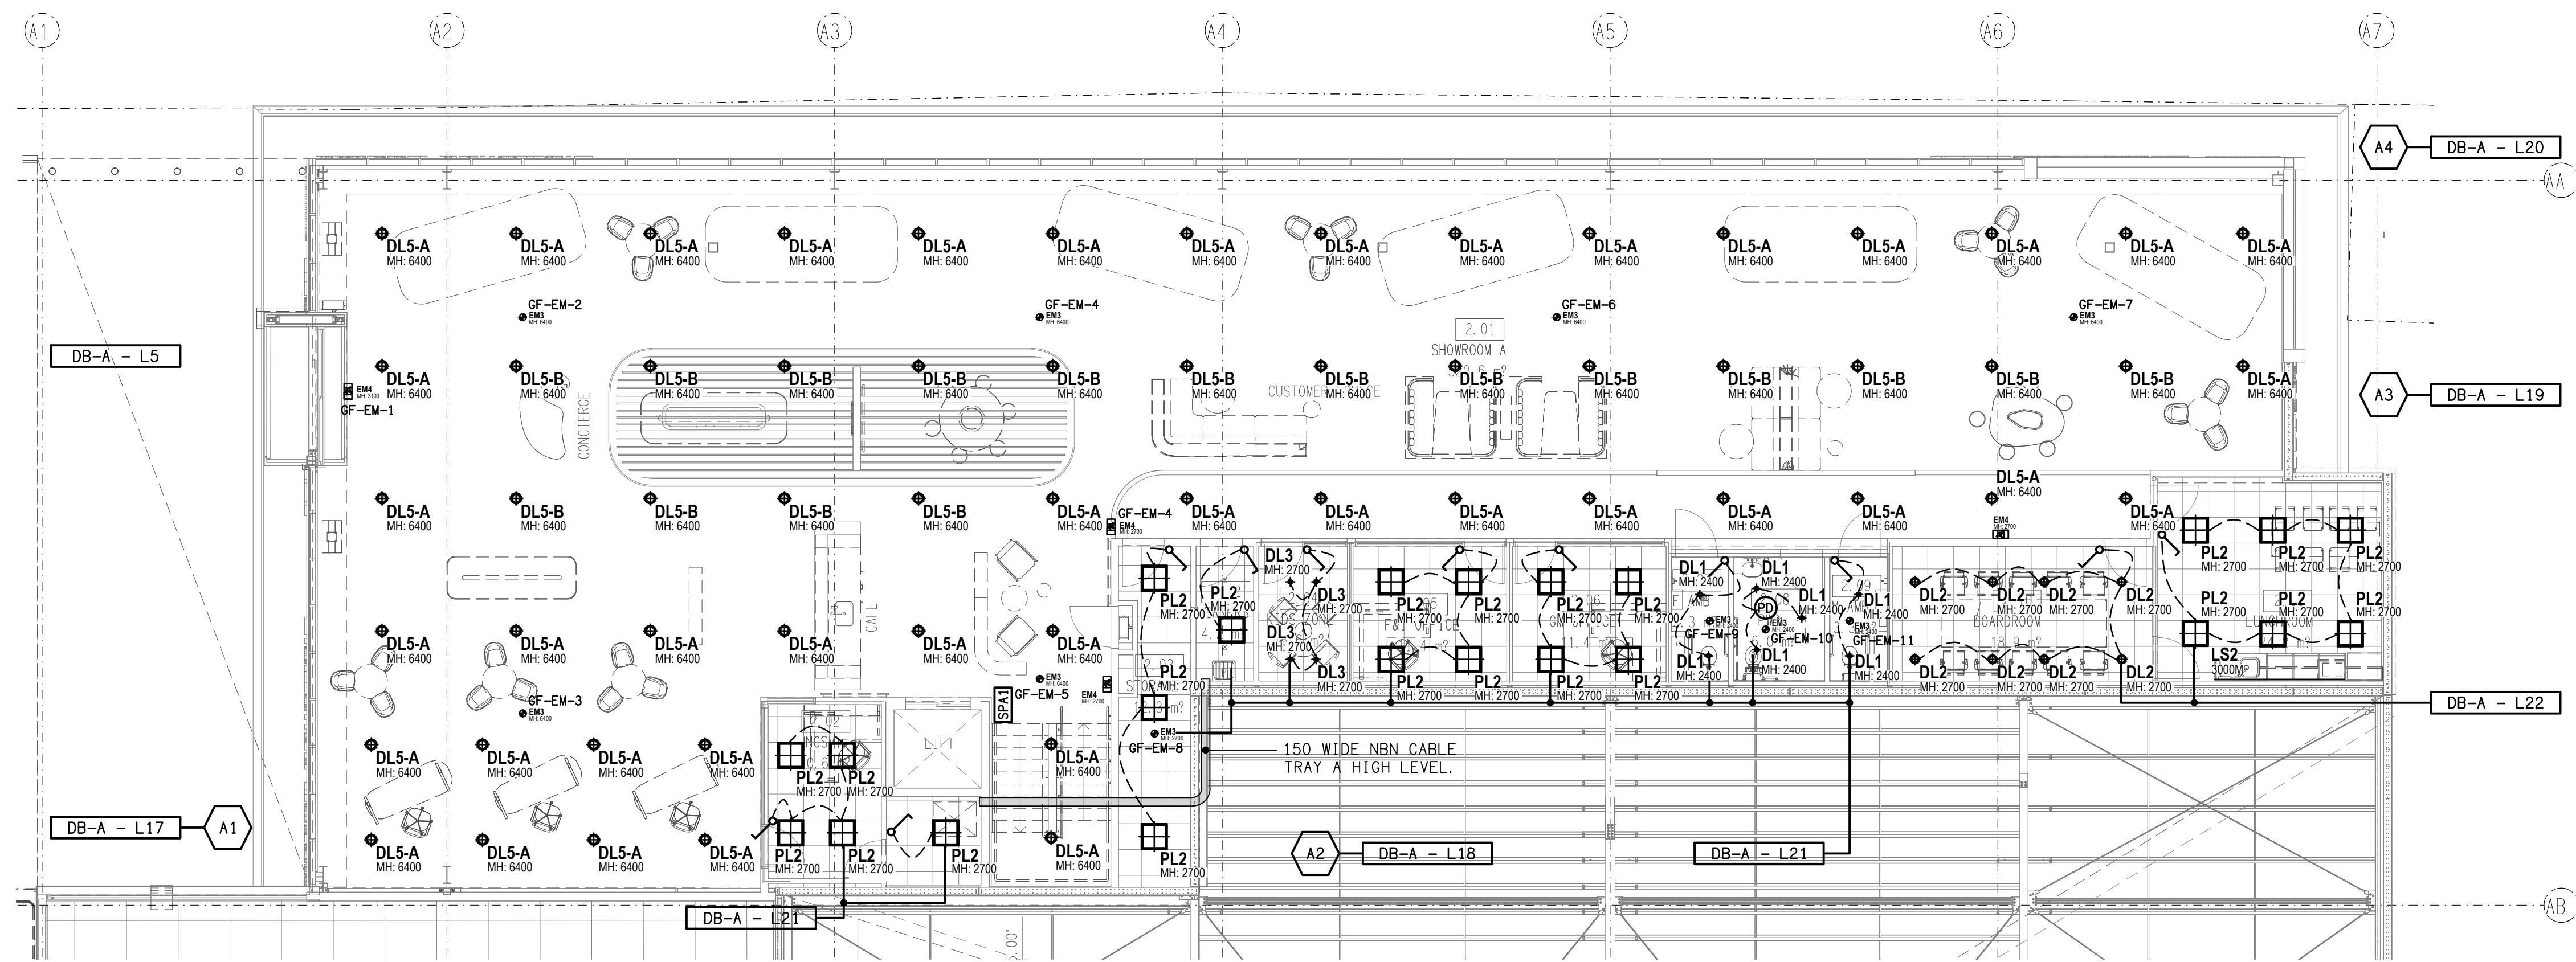


REFLECTED CEILING PLAN

GROUND LEVEL

SCALE 1: 100

NOTE:


ALL CS BLIND CIRCUITS HAVE BEEN DISCONNECTED IN BOARD AND ARE PROVISIONS ONLY FOR FUTURE BLINDS.
THE CS BLIND POWER JUNCTION BOXES ARE LOCATED NEAR THE CLOSEST DOWNLIGHT.

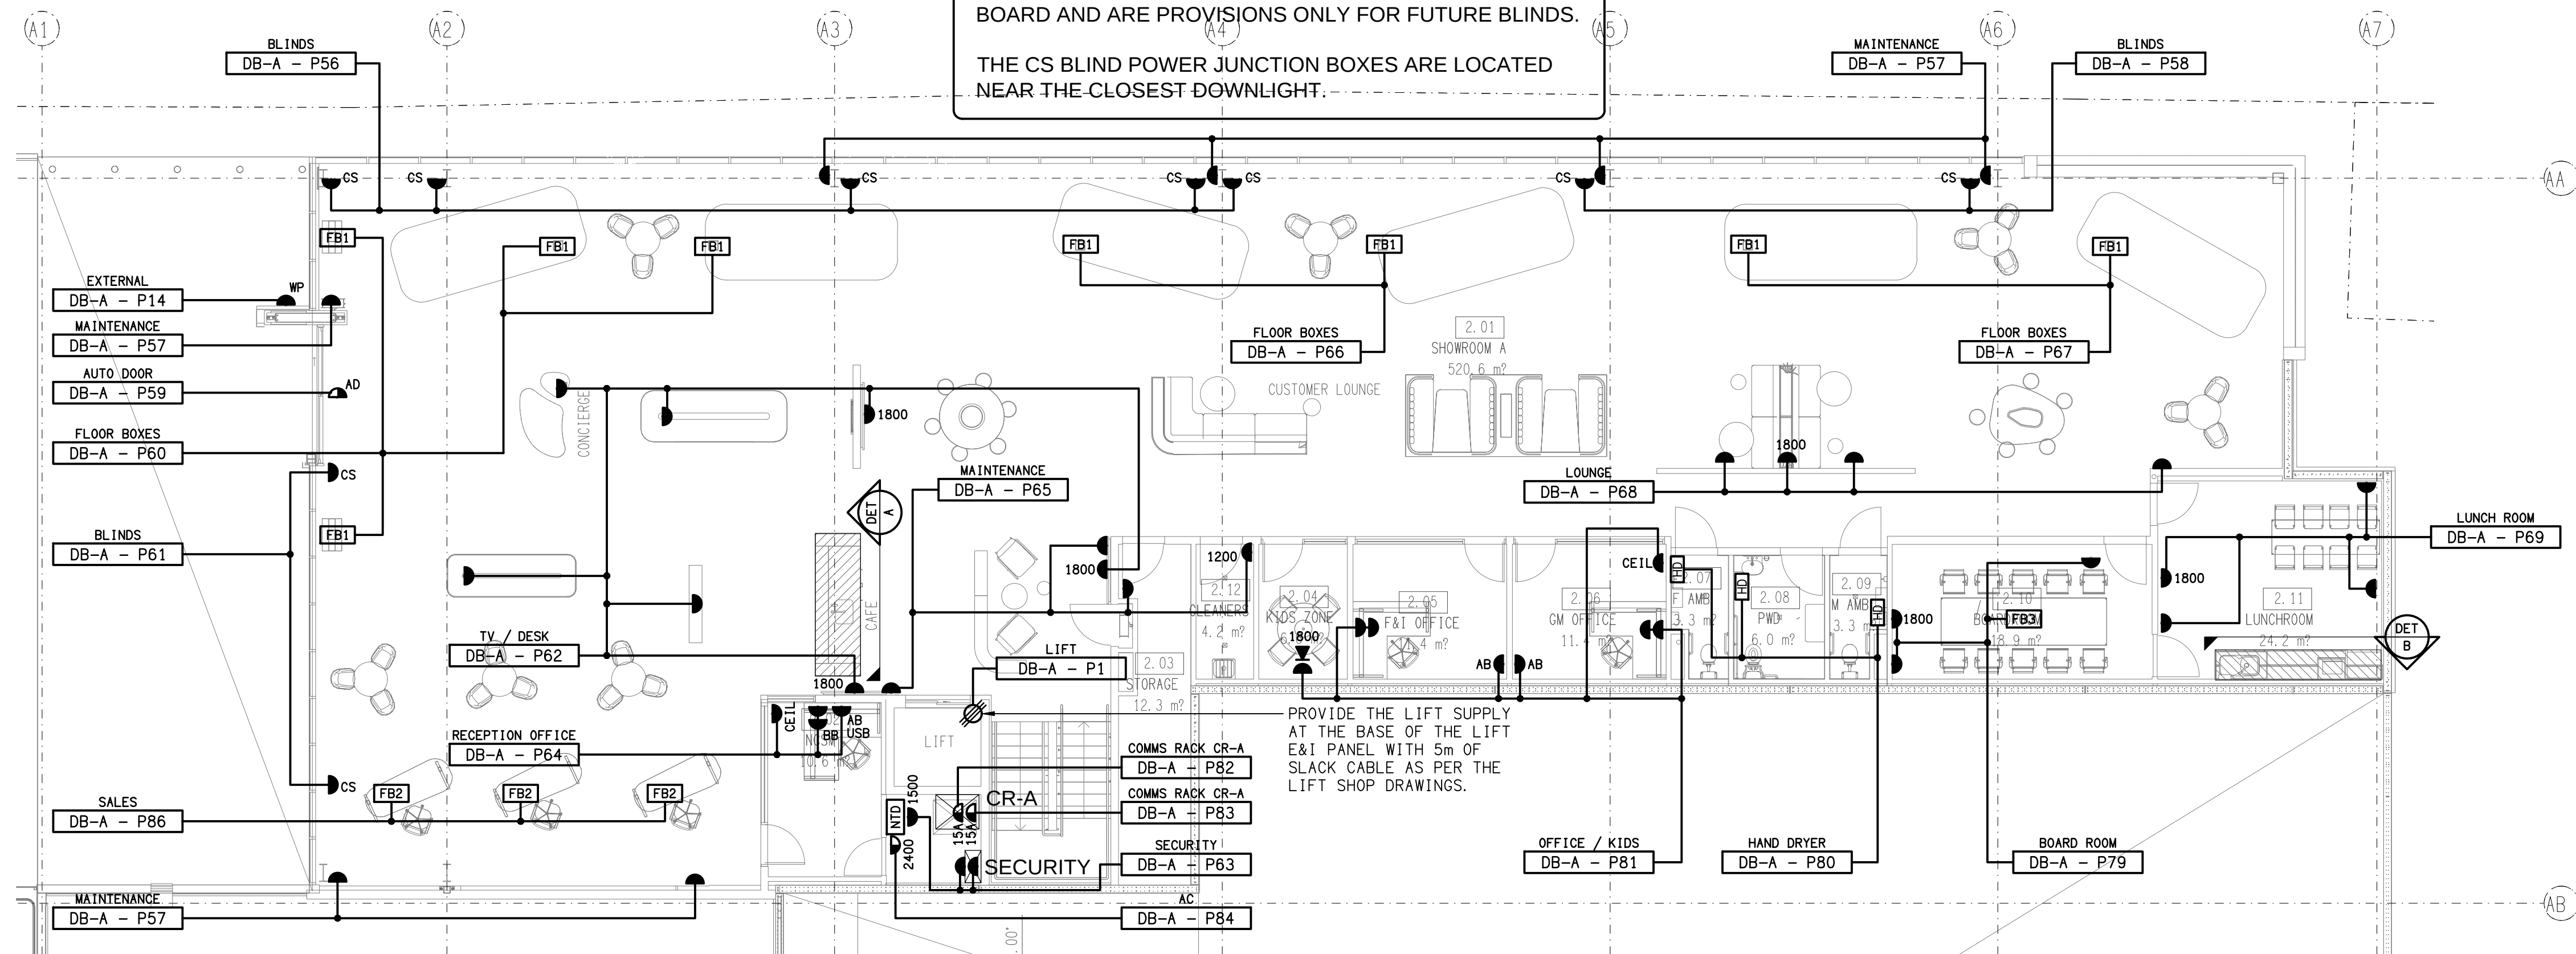

FLOOR PLAN

GROUND LEVEL


SCALE 1: 100

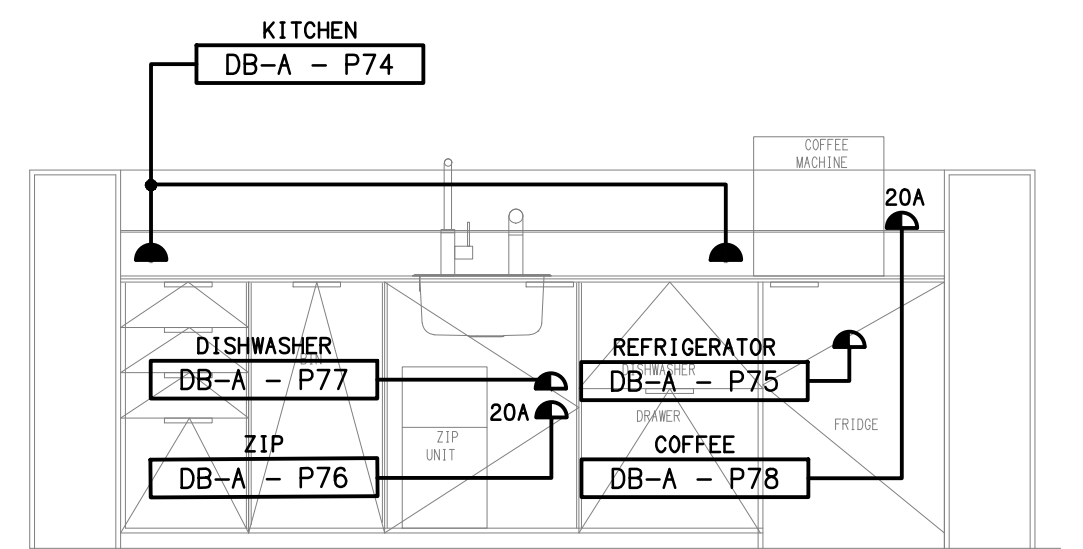

DETAIL A

CUSTOMER CAFE KITCHENETTE

SCALE 1: 25

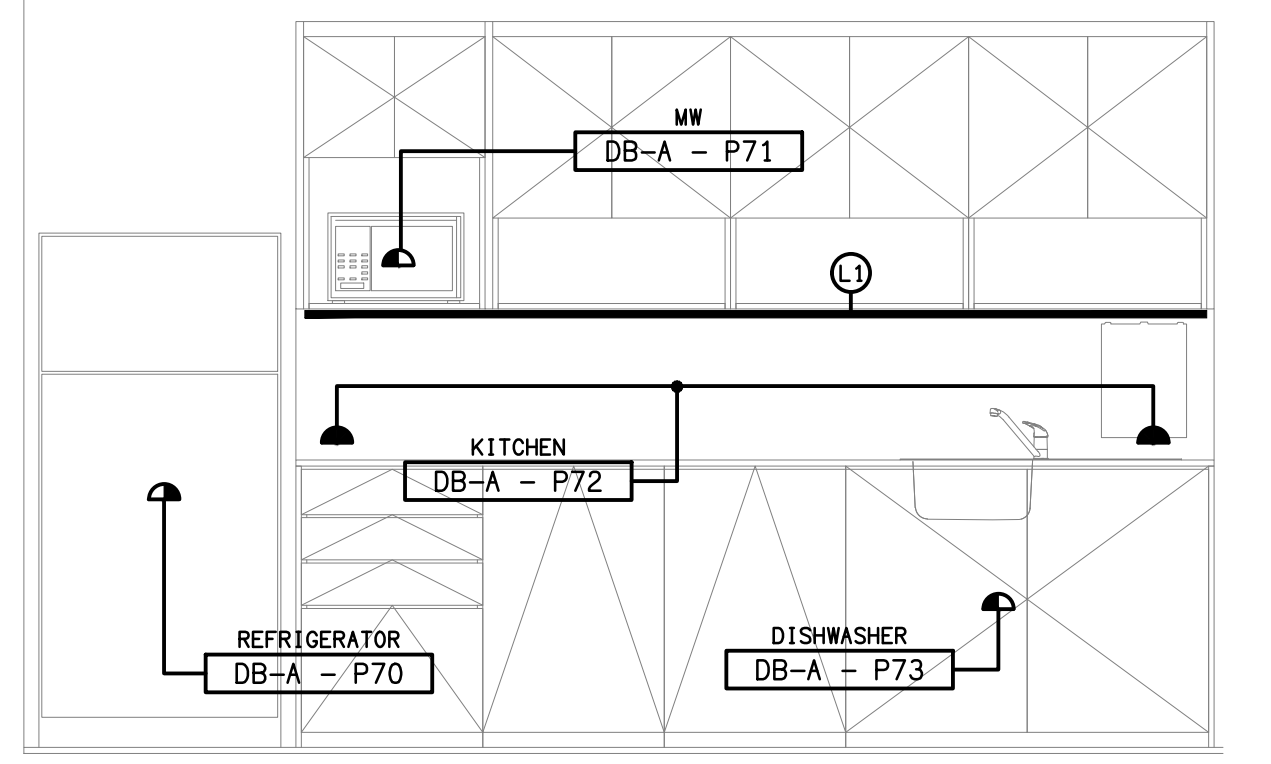

DETAIL B

LUNCH ROOM KITCHENETTE

SCALE 1: 25

ELECTRICAL DESIGN GROUP BRISBANE
PTY LTD
ACN 092 710 793
TRADING AS:
ELECTRICAL DESIGN GROUP

THE COPYRIGHT OF THIS DRAWING
REMAINS THE PROPERTY OF THE
ELECTRICAL DESIGN GROUP.
USE FIGURED DIMENSIONS
IN PREFERENCE TO SCALE.
ALL DIMENSIONS TO BE
VERIFIED ON SITE.



Rohrig (Qld) Pty Ltd
ABN 67 093 753 970
QBSA LIC NO 740842
250 Abbotsford Road, Bowen Hills Qld 4006
PO Box 86 Albion DC Qld 4010
T+61 (7) 3257 4411 F+61 (7) 3257 2211
www.rohrig.com.au



ELECTRICAL DESIGN GROUP
ELECTRICAL BUILDING SERVICES CONSULTANTS
BRISBANE GOLD COAST

P.O. Box 15, Sherwood Q. 4075
Phone: (07) 3278 4375
Email: brisbane@edg.net.au
Web: www.edg.net.au

PROJECT:
LLEWELLYN MOTORS SPRINGFIELD - LOT 34

LOT 34 AUGUSTA PARKWAY, AUGUSTINE HEIGHTS

3	AS CONSTRUCTED	14/07/2026
REV:	DESCRIPTION:	DATE:

DRAWING: ELECTRICAL SERVICES GROUND LEVEL FLOOR & REFLECTED CEILING PLAN	PROJECT NO: C3396a	DRAWING NO: E06	REVISION: 3
SCALE: 1:100 UNO	AT A1		