




REFLECTED CEILING PLAN
GROUND LEVEL
SCALE 1:100

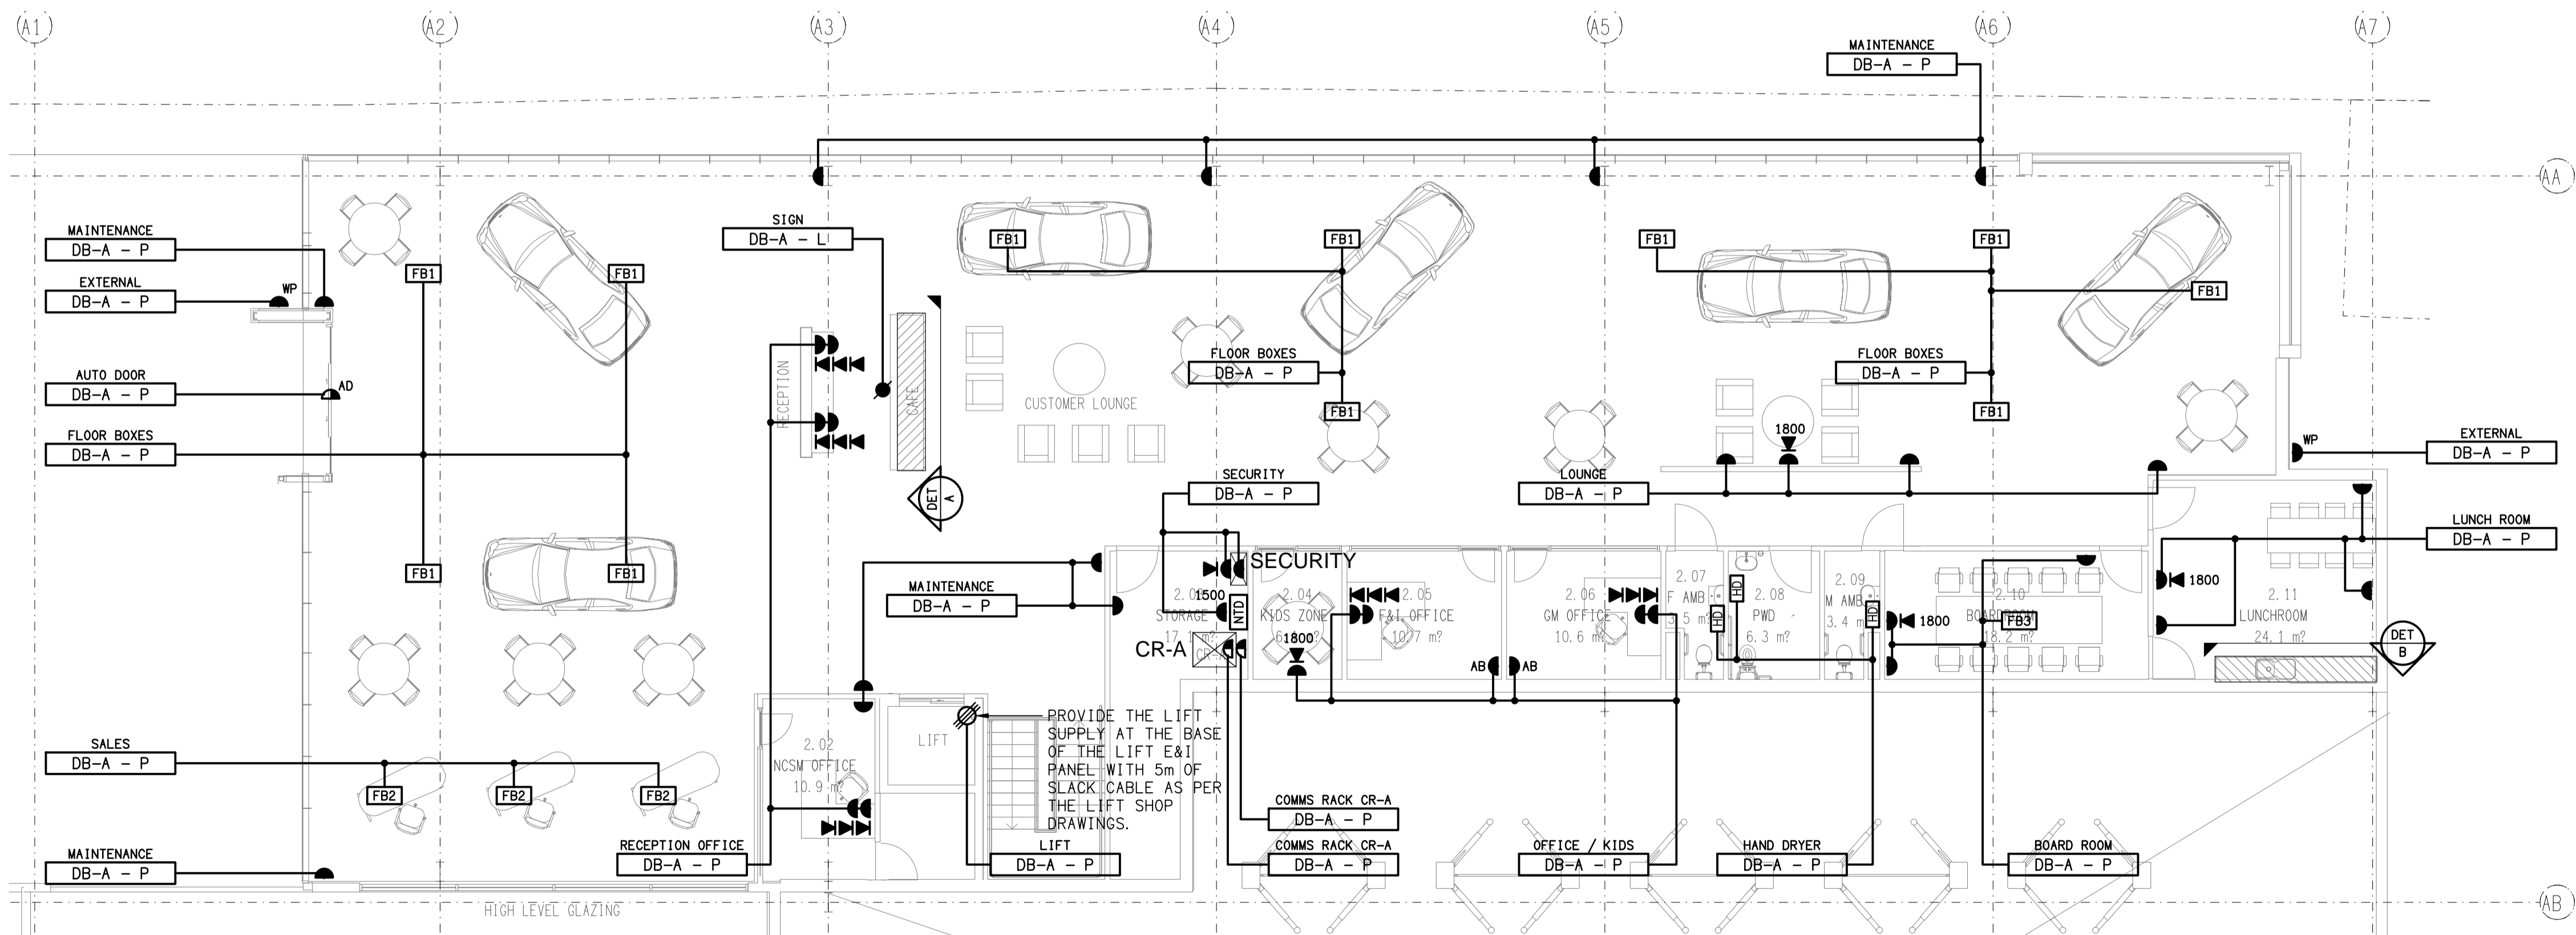

FLOOR PLAN
GROUND LEVEL
SCALE 1:100

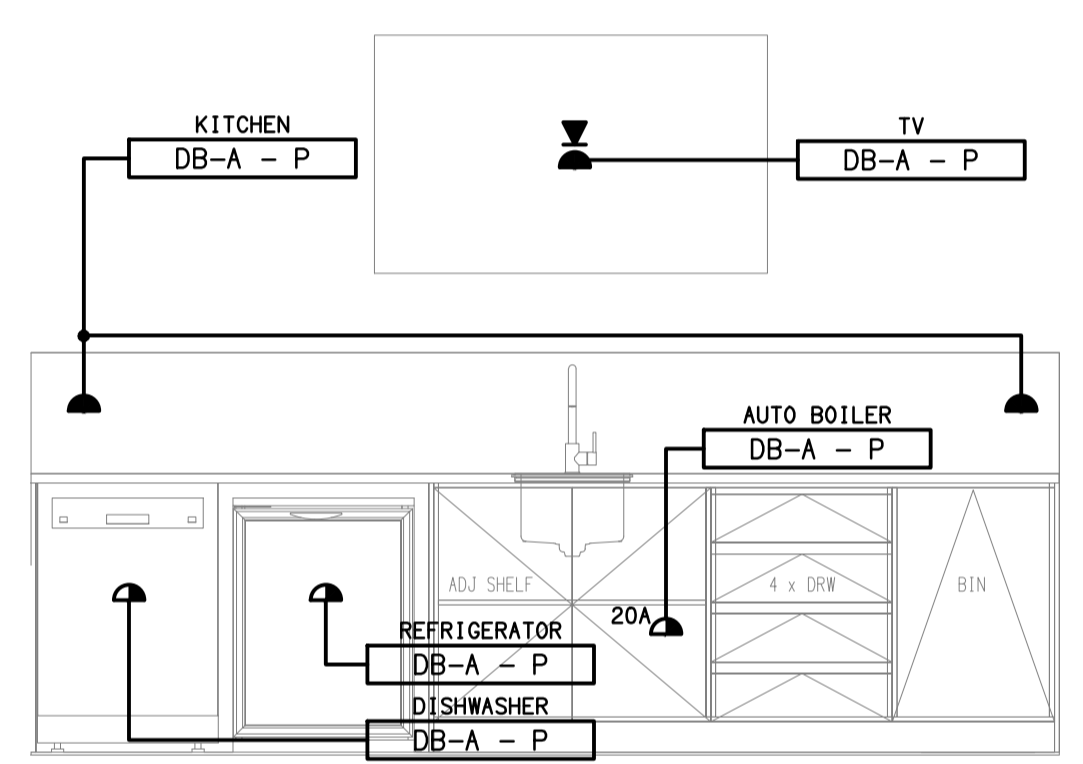

DETAIL A
CUSTOMER CAFE KITCHENETTE
SCALE 1:25

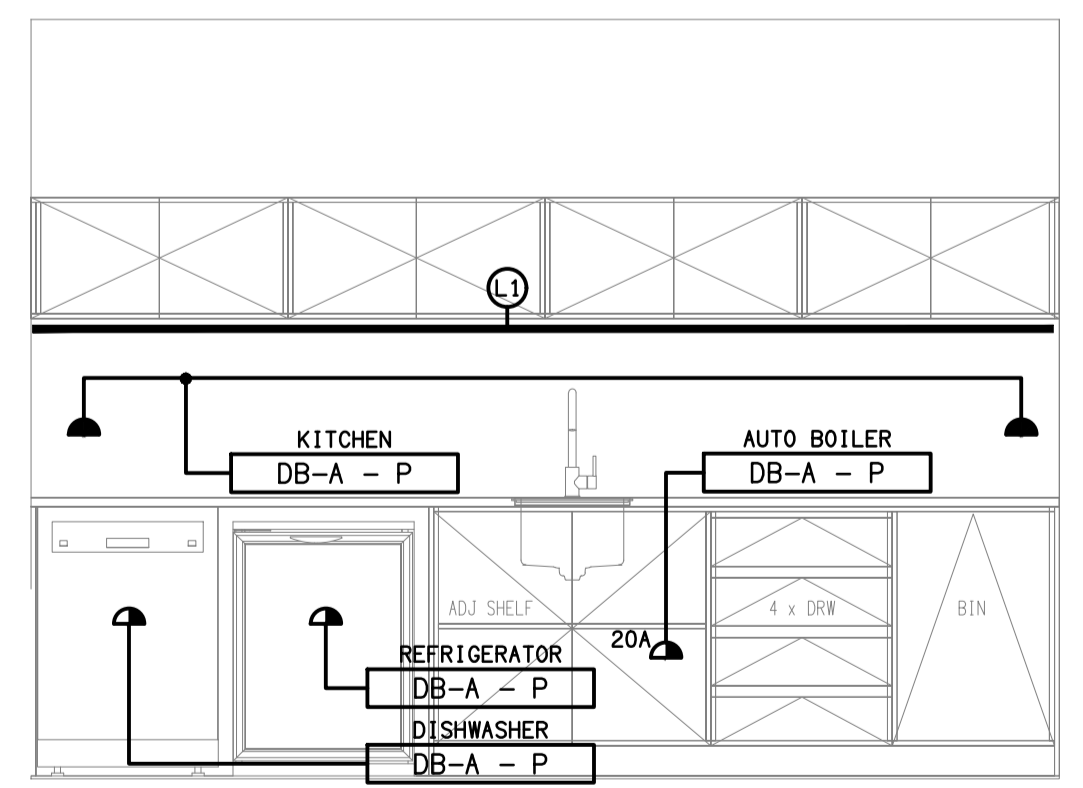

DETAIL B
LUNCH ROOM KITCHENETTE
SCALE 1:25

ELECTRICAL DESIGN GROUP BRISBANE PTY LTD ACN 092 710 793 TRADING AS: ELECTRICAL DESIGN GROUP	THE COPYRIGHT OF THIS DRAWING REMAINS THE PROPERTY OF THE ELECTRICAL DESIGN GROUP. USE FIGURED DIMENSIONS IN PREFERENCE TO SCALE. ALL DIMENSIONS TO BE VERIFIED ONSITE.		Rohrig (Qld) Pty Ltd ABN 67 093 753 970 QBSA LIC NO 740842 250 Abbotsford Road, Bowen Hills Qld 4006 PO Box 86 Albion DC Qld 4010 T+61 (7) 3257 4411 F+61 (7) 3257 2211 www.rohrig.com.au	ELECTRICAL BUILDING SERVICES CONSULTANTS BRISBANE GOLD COAST P.O. Box 15, Sherwood Q.4075 Phone: (07) 3278 4375 Email: brisbane@edg.net.au Web: www.edg.net.au	PROJECT: LLEWELLYN MOTORS SPRINGFIELD - LOT 34	A PRELIMINARY REV: DESCRIPTION: DATE:
					PROJECT: LOT 34 AUGUSTA PARKWAY, AUGUSTINE HEIGHTS	DRAWING: ELECTRICAL SERVICES GROUND LEVEL FLOOR & REFLECTED CEILING PLAN SCALE: 1:100 UNO AT A1 PROJECT NO: C3396a DRAWING NO: E06 REVISION: A