



LEVEL 1
PROPOSED FLOOR PLAN
SCALE 1:100

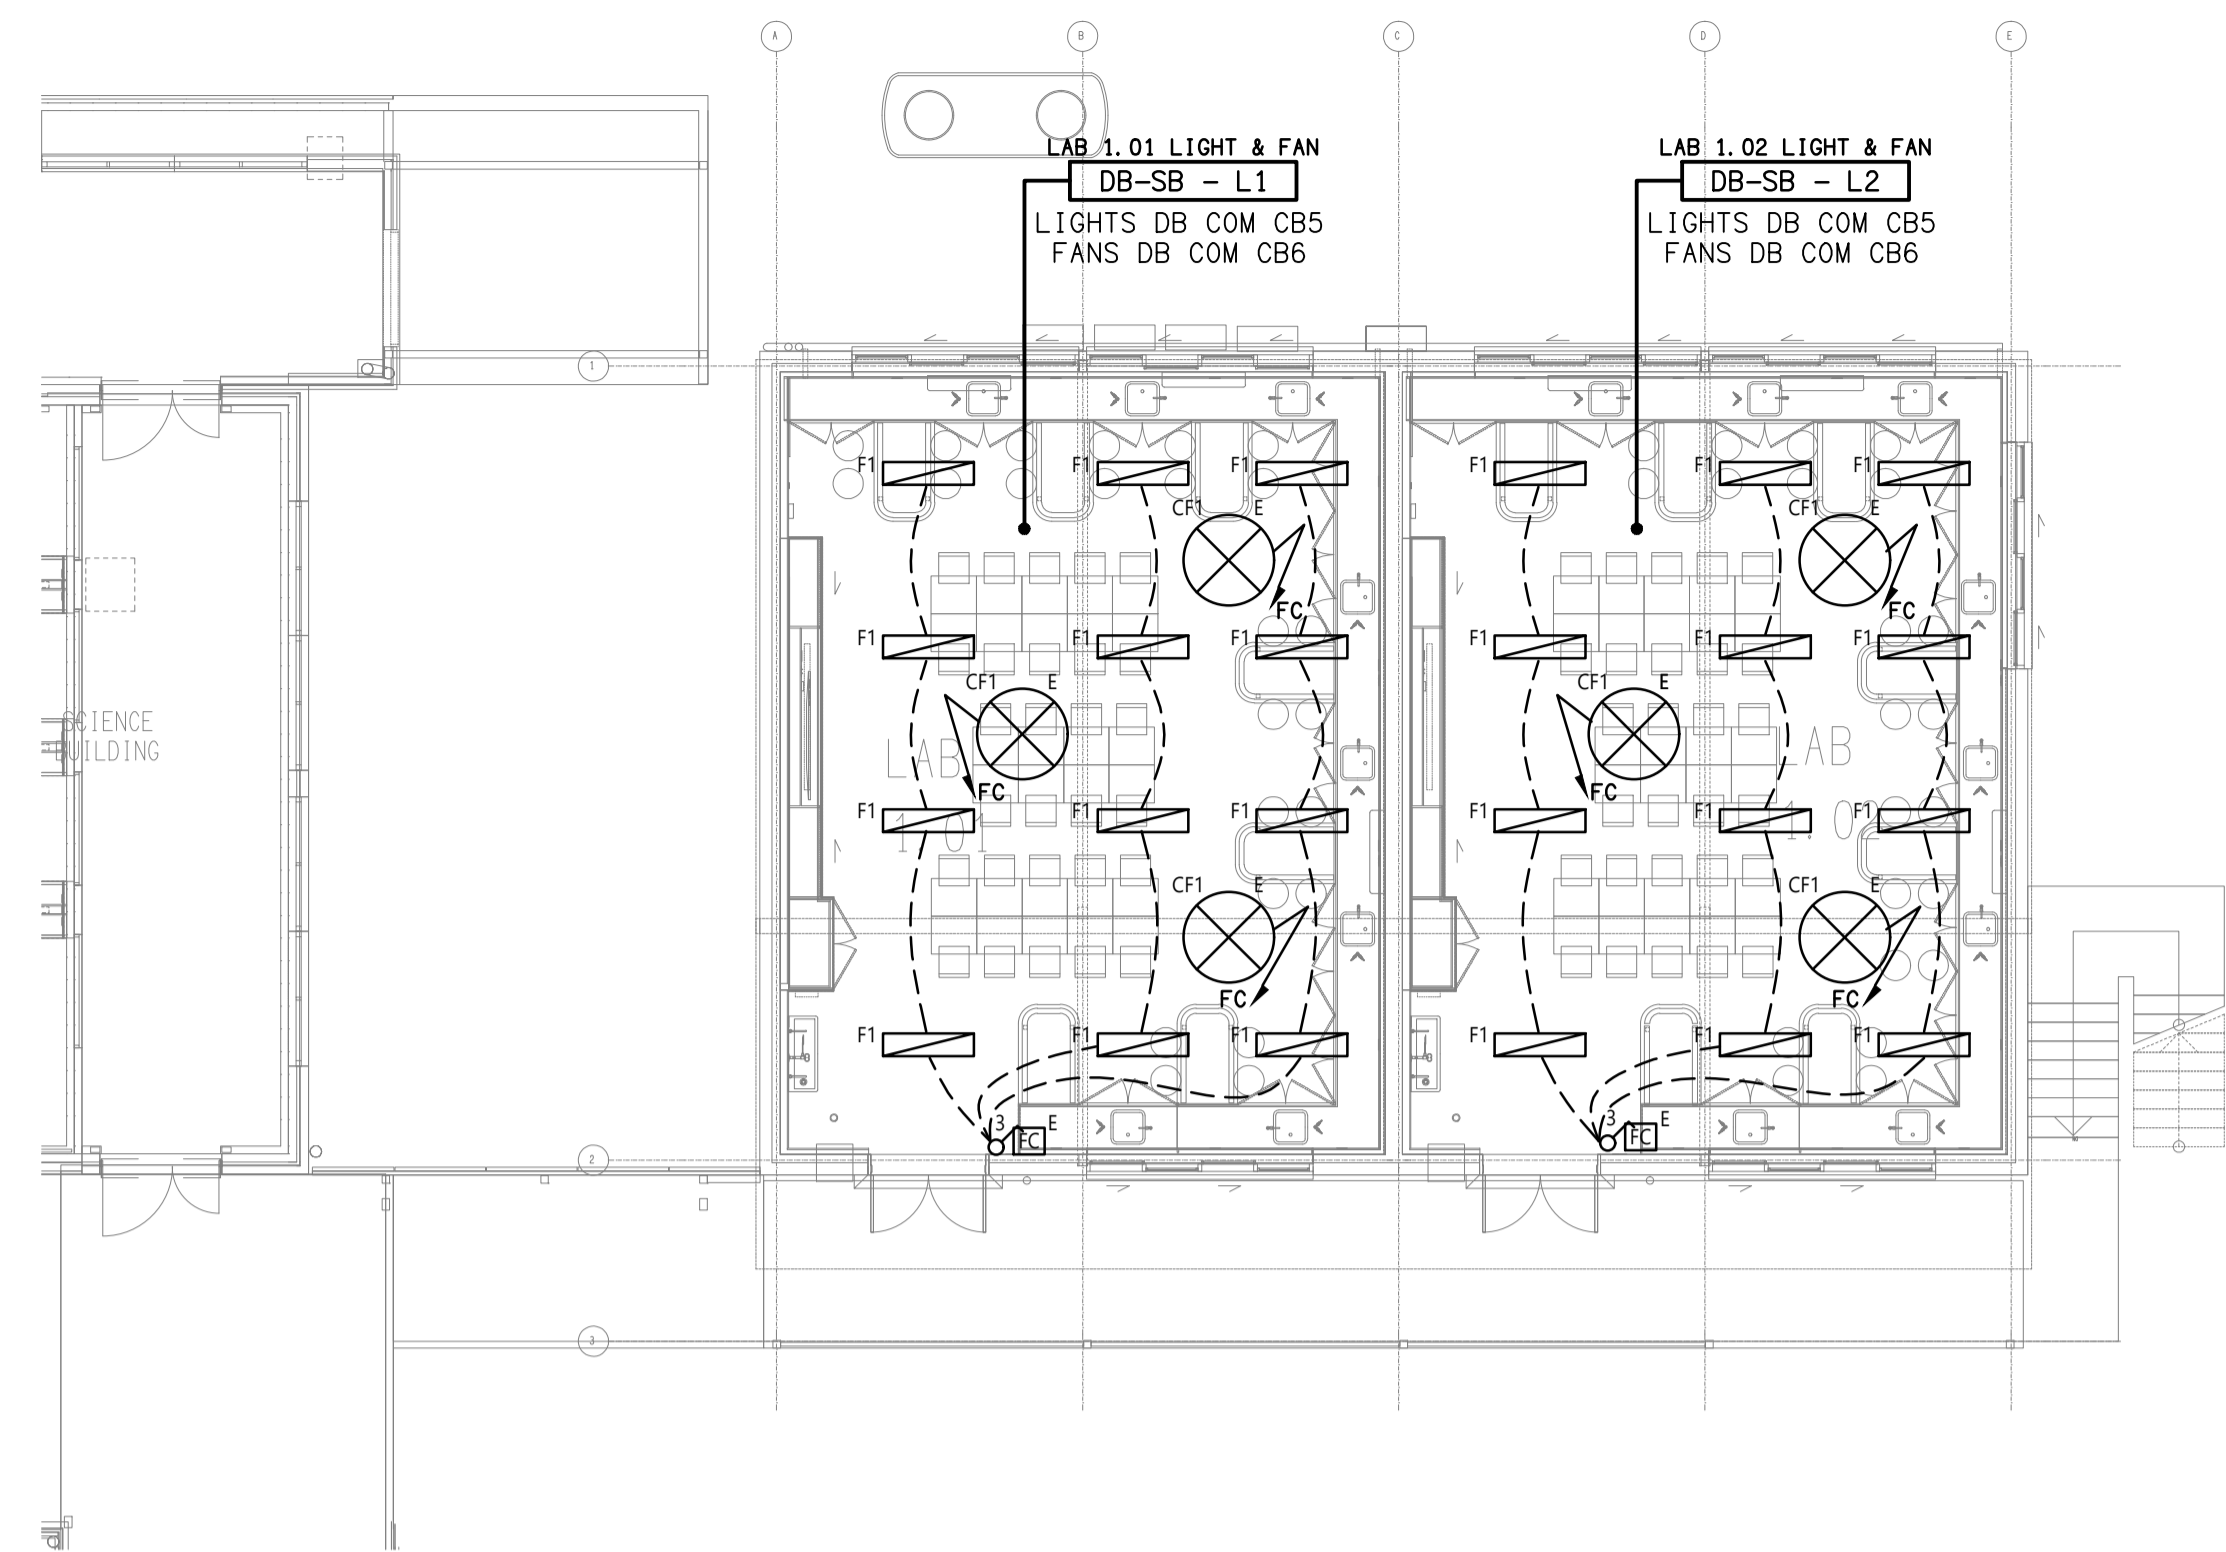

LEVEL 1
PROPOSED REFLECTED CEILING PLAN
SCALE 1:100

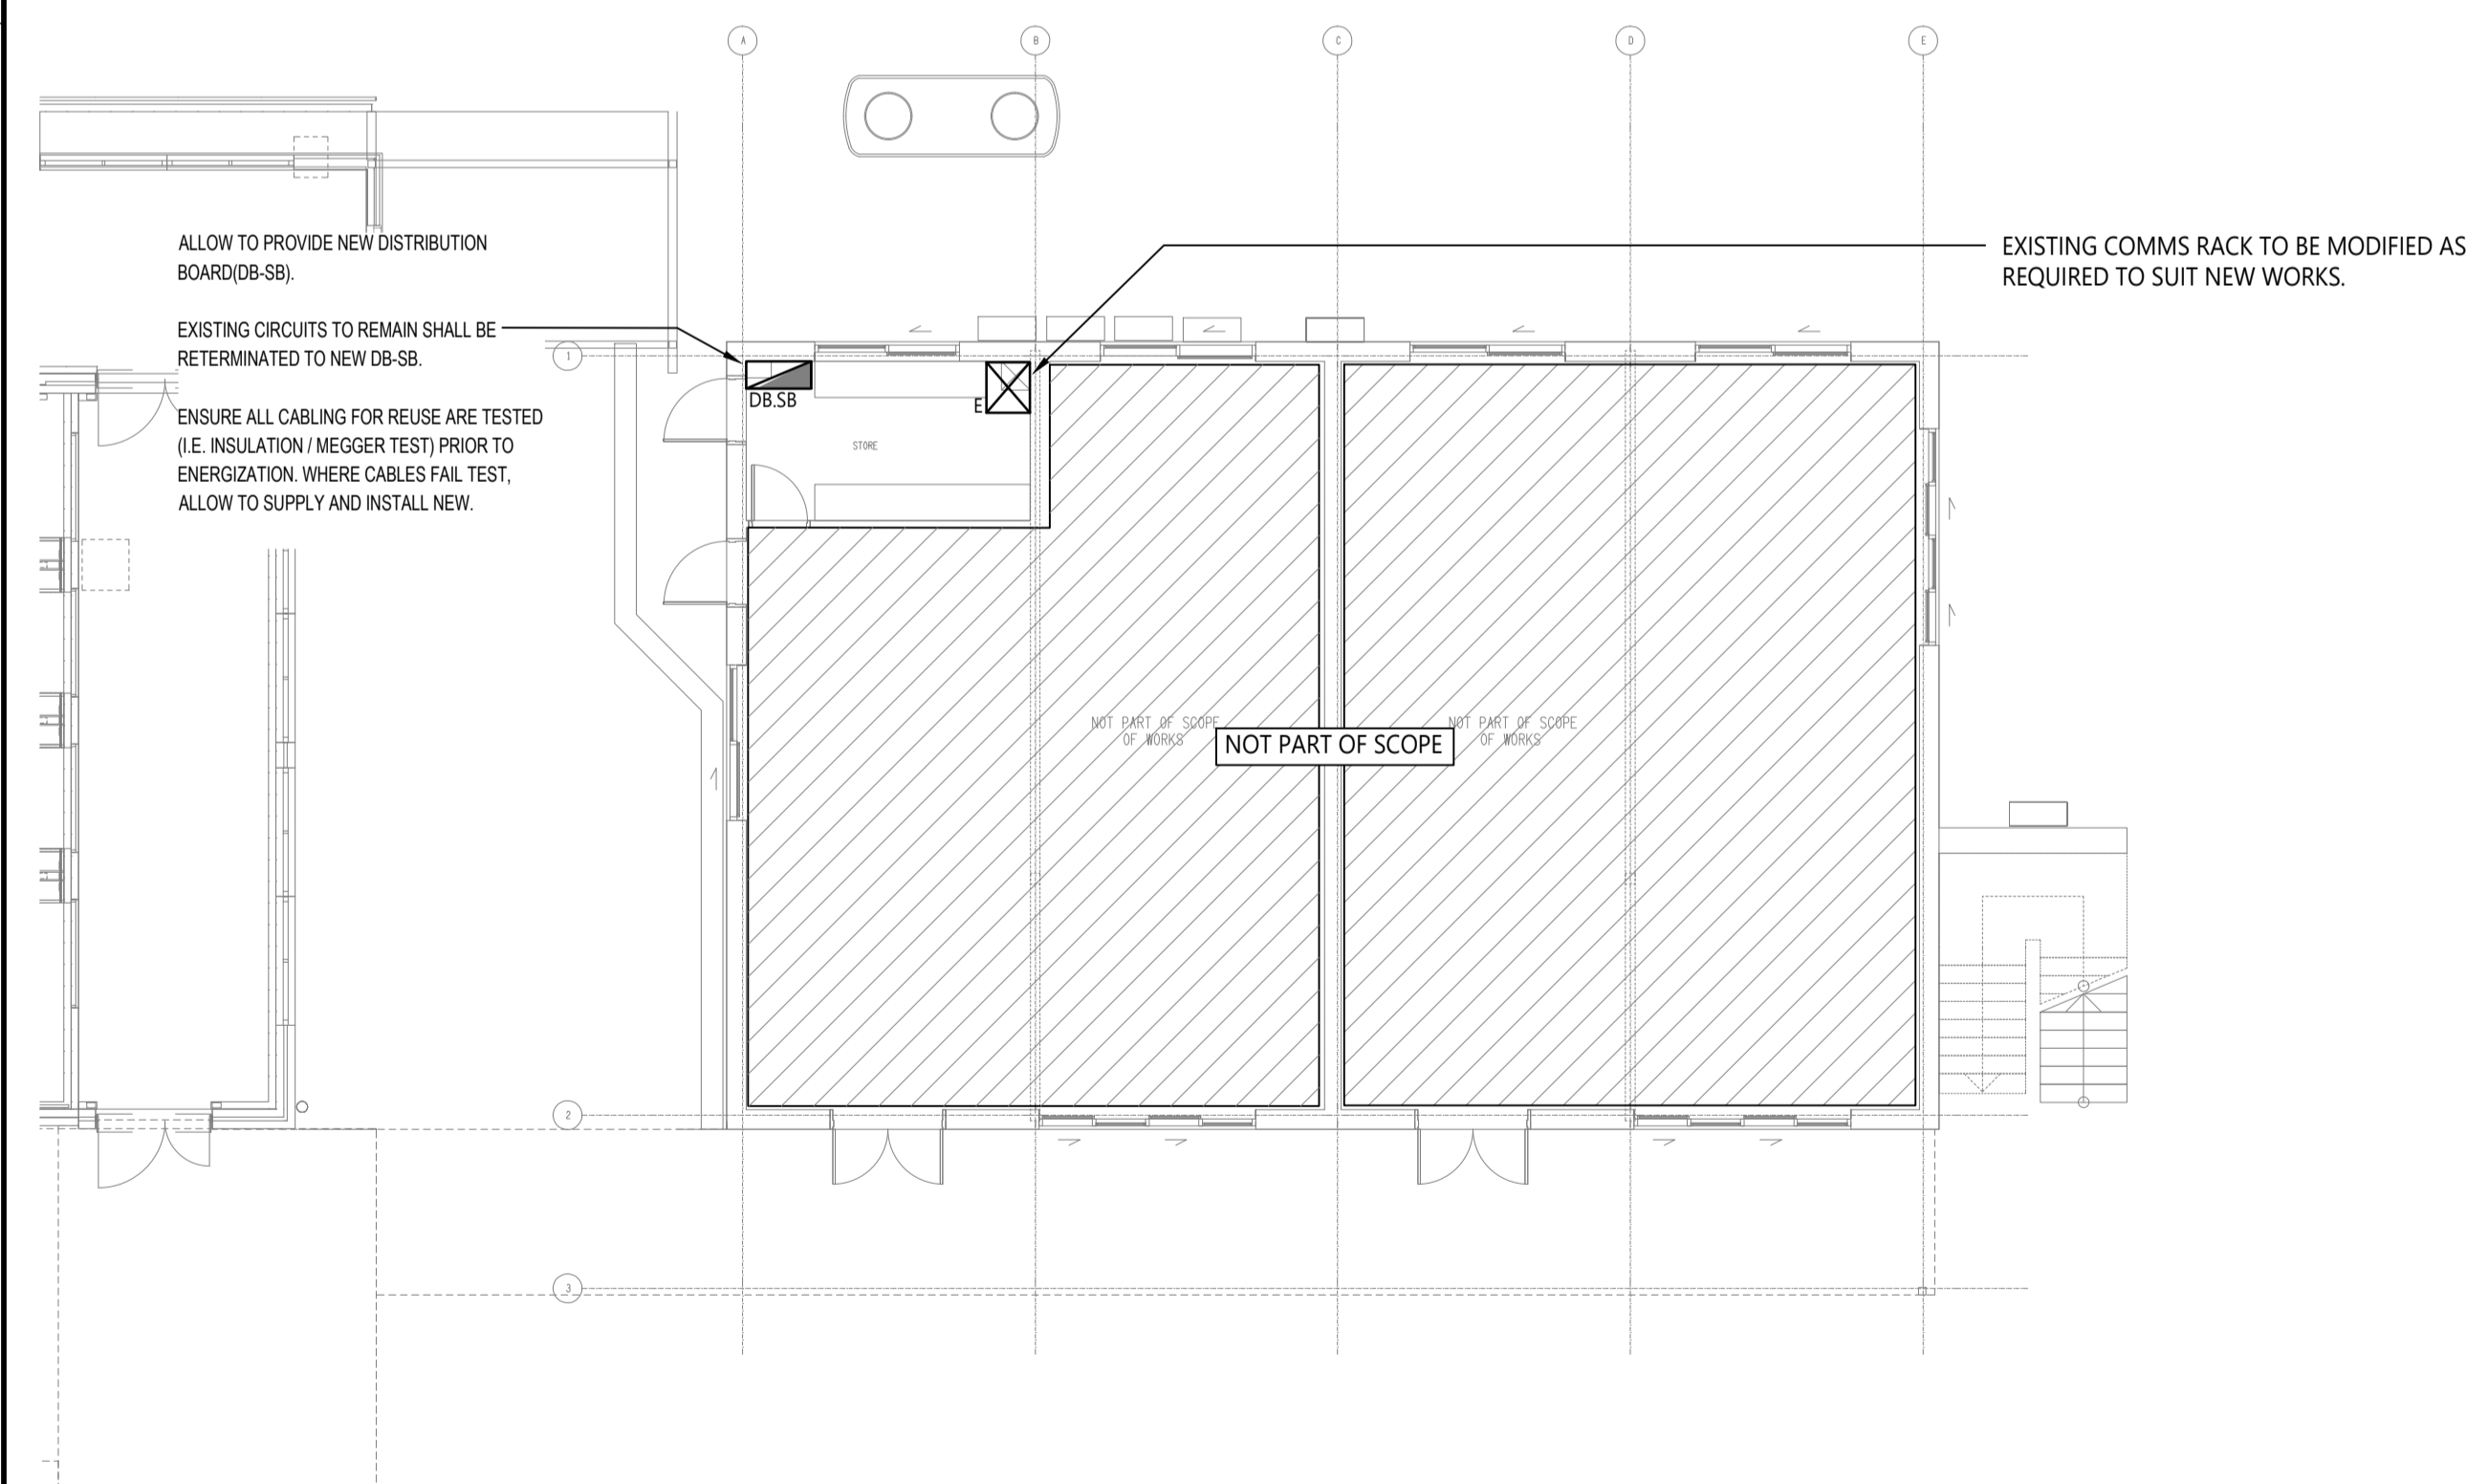

GROUND LEVEL
PROPOSED PLAN
SCALE 1:100

ELECTRICAL DESIGN GROUP BRISBANE PTY LTD
ACN 092 710 793
TRADING AS:
ELECTRICAL DESIGN GROUP

THE COPYRIGHT OF THIS DRAWING REMAINS THE PROPERTY OF THE ELECTRICAL DESIGN GROUP.
USE FIGURED DIMENSIONS IN PREFERENCE TO SCALE.
ALL DIMENSIONS TO BE VERIFIED ONSITE.

ASW
ELECTRICAL
WIRED TO DELIVER

E: info@aswelectrical.com.au
M: 0450 440 569
www.aswelectrical.com.au

ELECTRICAL DESIGN GROUP
ELECTRICAL BUILDING SERVICES CONSULTANTS
BRISBANE GOLD COAST

P.O.Box 15, Sherwood Q.4075
Phone: (07) 3278 4375
Email: brisbane@edg.net.au
Web: www.edg.net.au

PROJECT:
**JOHN PAUL COLLEGE
SCIENCE CLASSES**
125 JOHN PAUL DRIVE, DAISY HILL, QUEENSLAND

B	AS CONSTRUCTED	14/01/2025
REV:	DESCRIPTION:	DATE:
DRAWING: ELECTRICAL SERVICES PROPOSED PLANS		
SCALE: 1:100	PROJECT NO: C3406a	DRAWING NO: E05
AT A1	REVISION: B	