


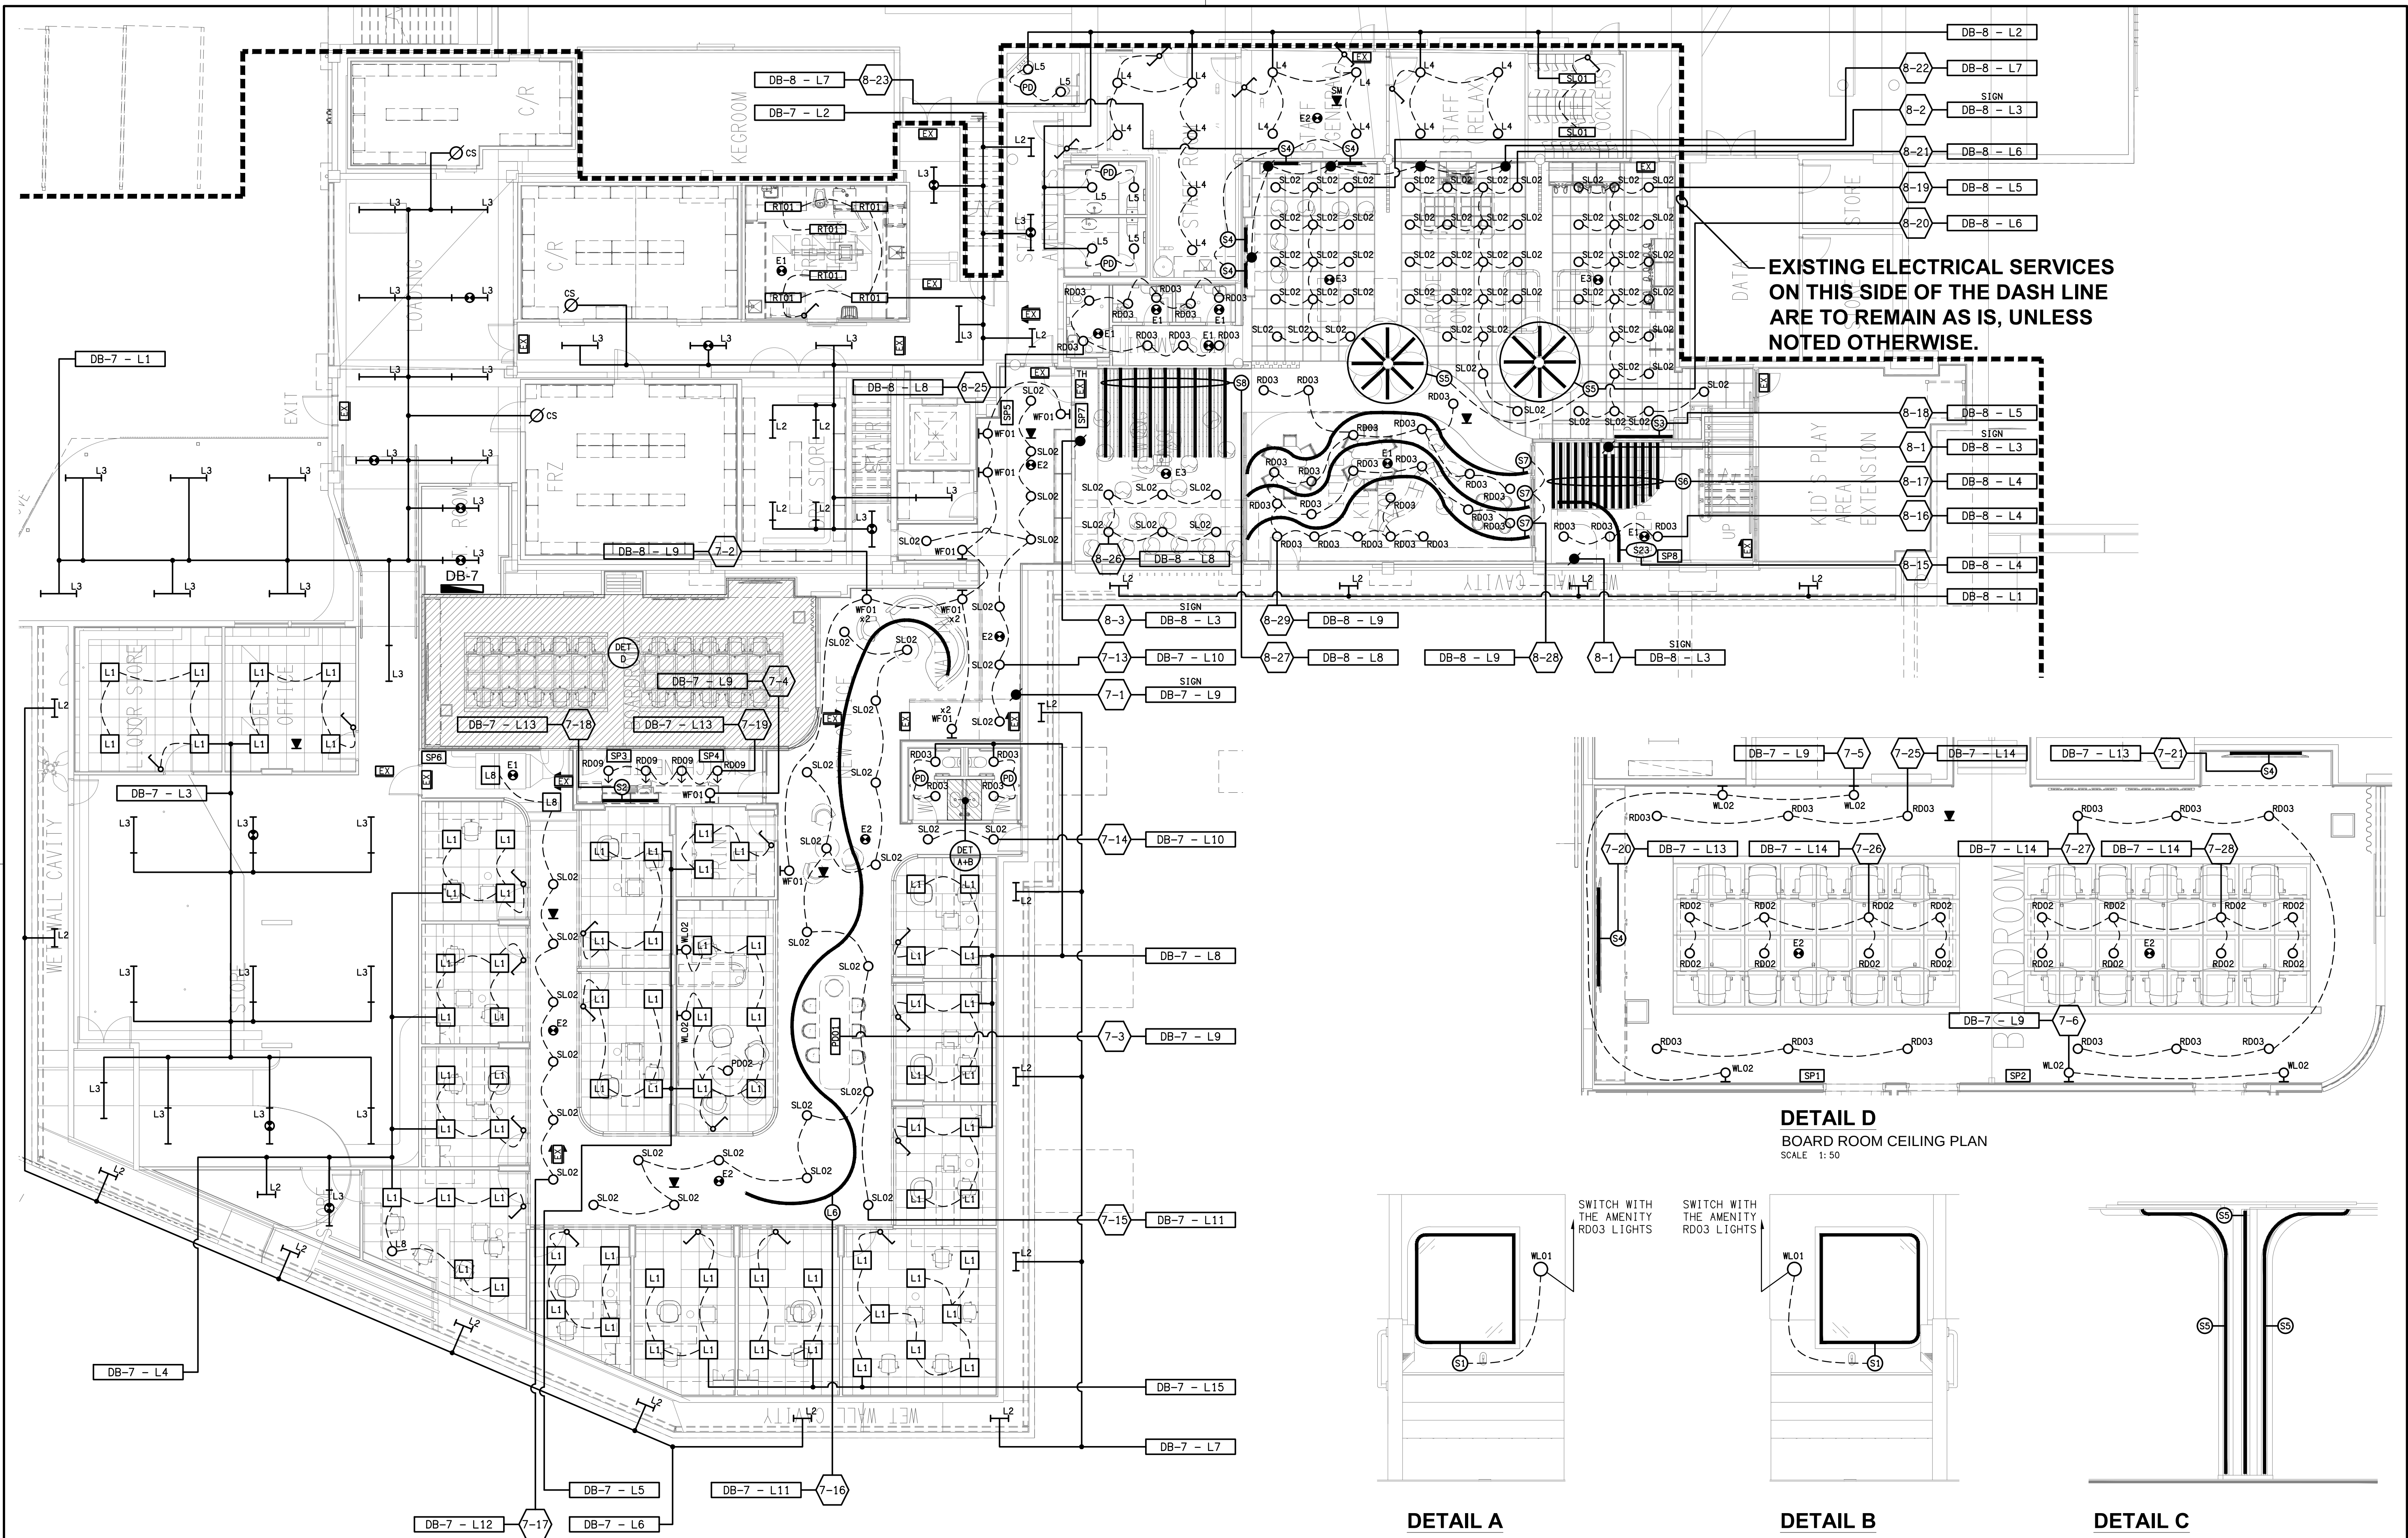

DETAIL A

AMENITY 1 ELEVATION

SCALE 1:25

DETAIL B
AMENITY 2 ELEVATION
SCALE 1:25

DETAIL C

TYPICAL S5 COLUMN LIGHT ELEVATION

SCALE 1:25

B	TENDER	29/06/2026	
REV:	DESCRIPTION:	DATE:	
DRAWING:			
ELECTRICAL SERVICES BASEMENT LEVEL REFLECTED CEILING PLAN			
SCALE:		PROJECT NO:	DRAWING NO:
1:100 UNO AT A1		C3457a	E06
			REVISION:
			B