



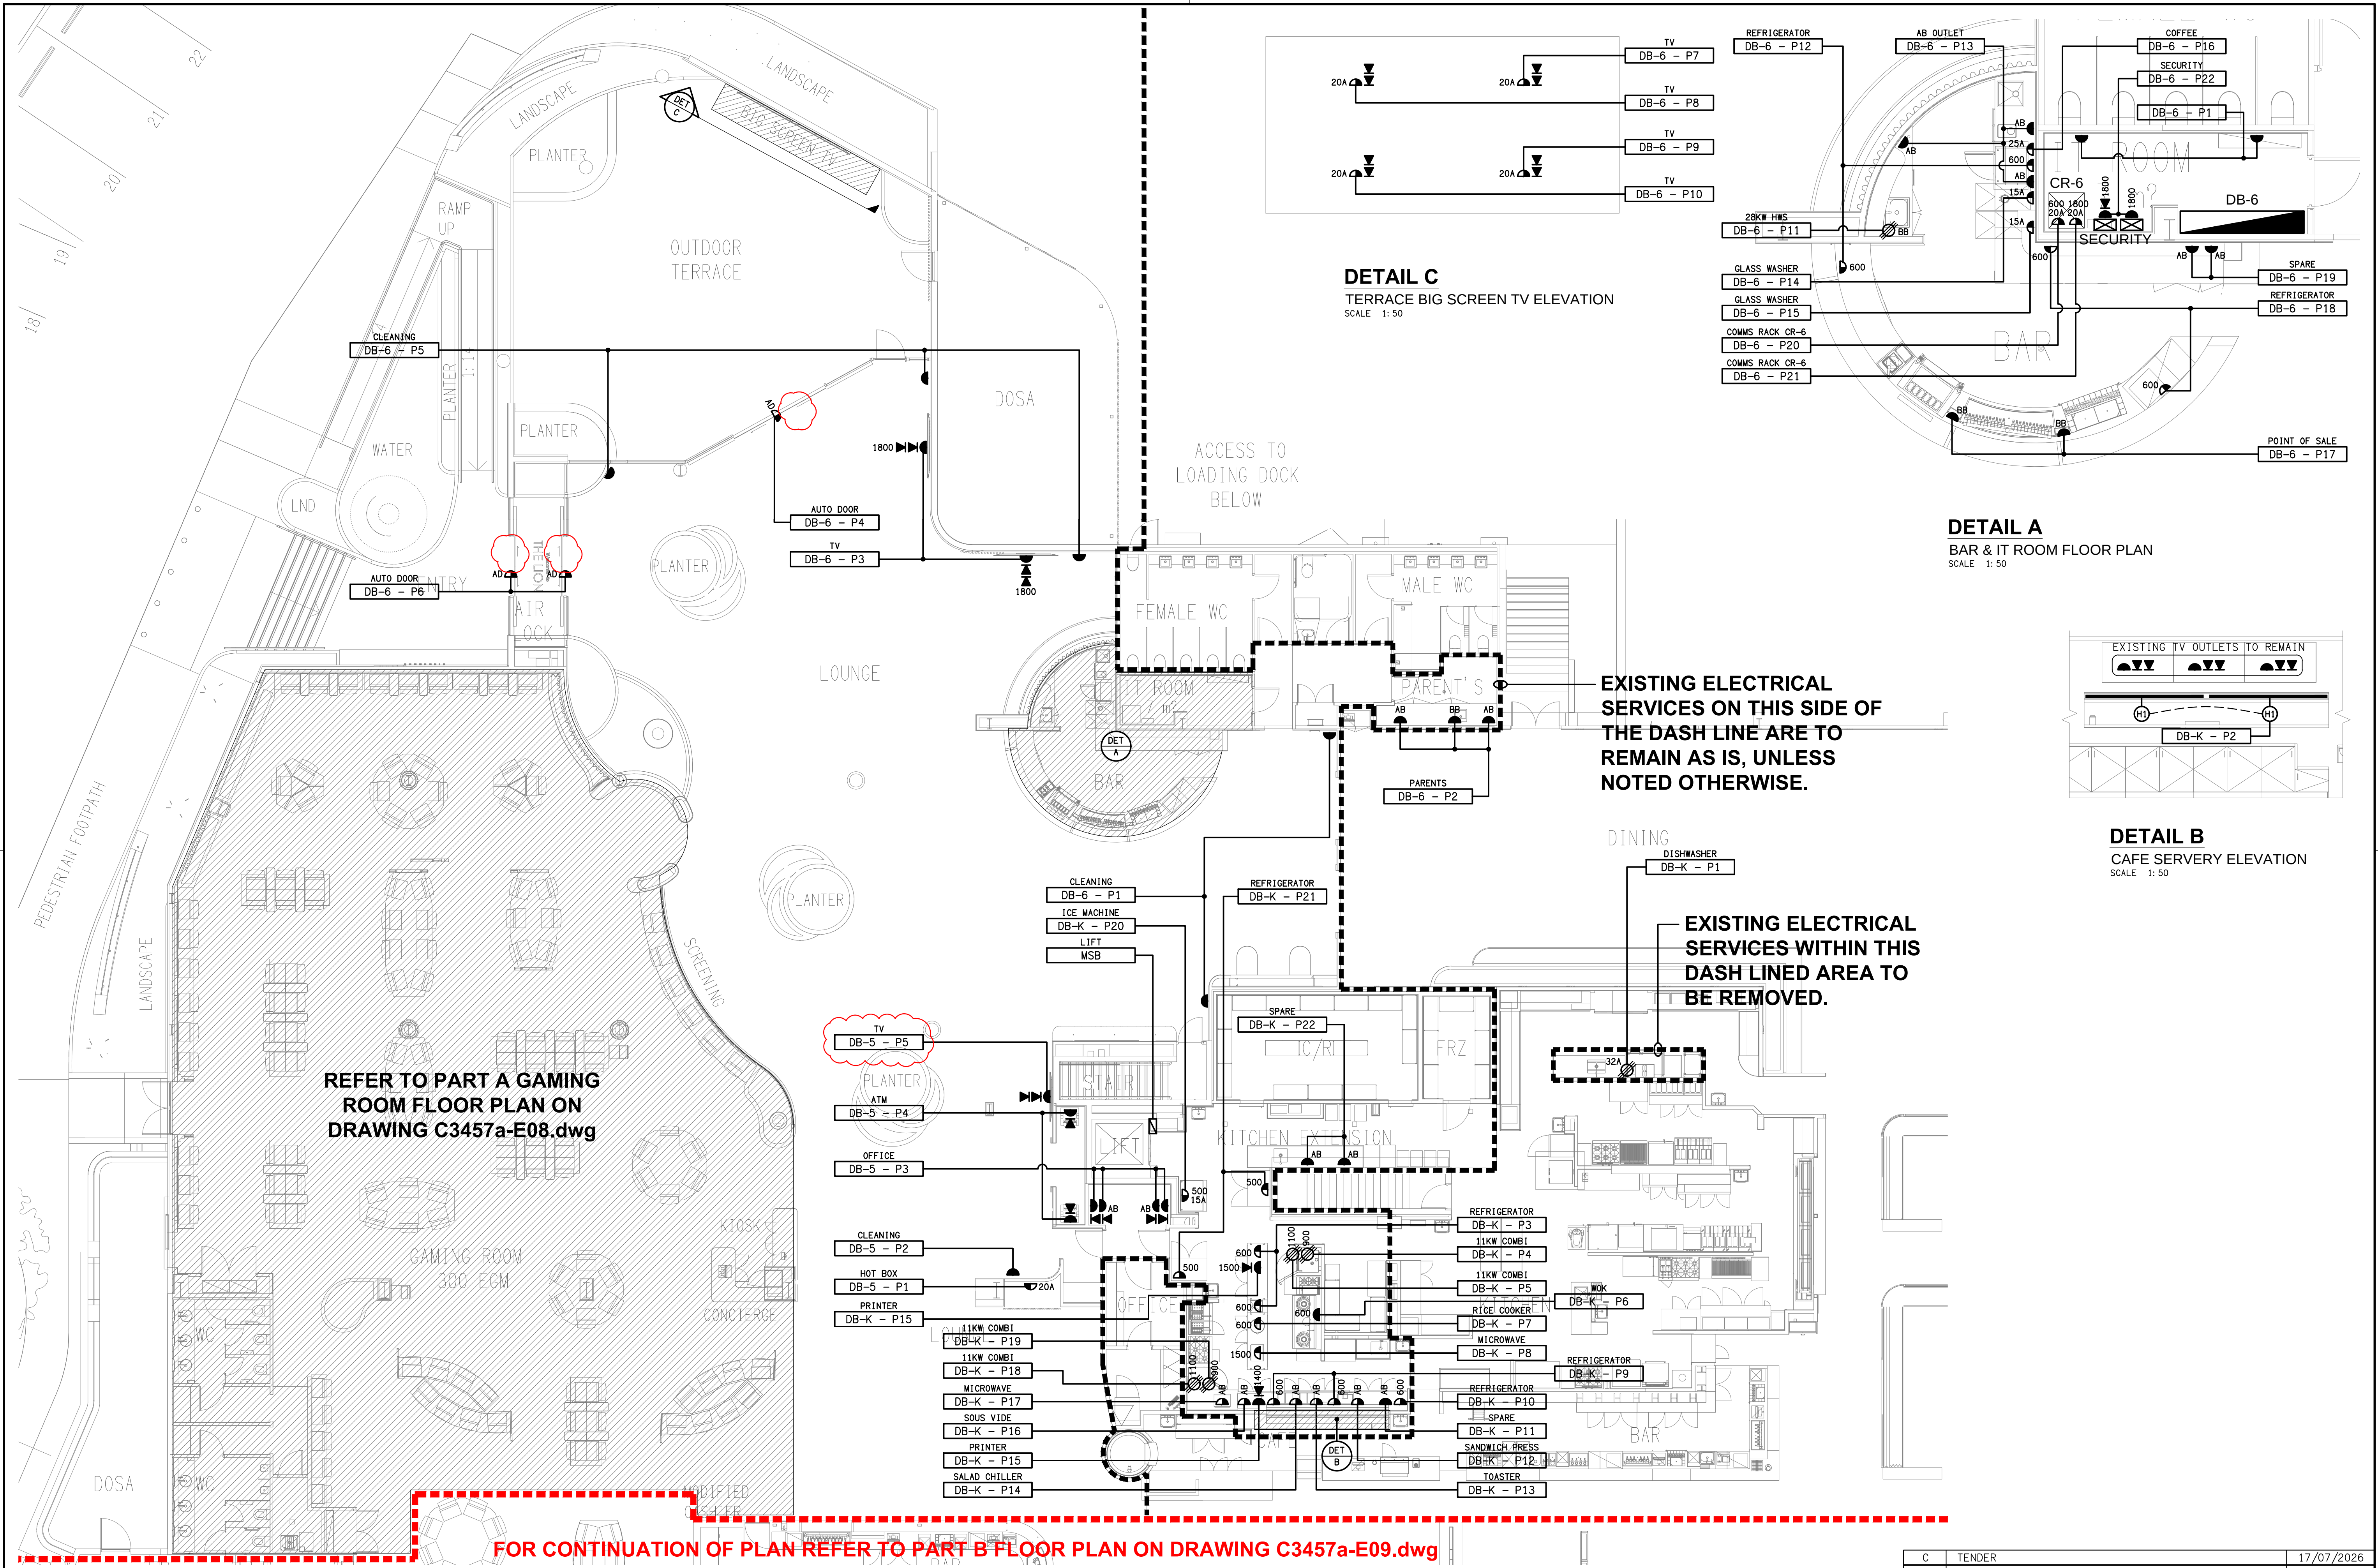

DETAIL C
TERRACE BIG SCREEN TV ELEVATION
SCALE 1:50

DETAIL A
BAR & IT ROOM FLOOR PLAN
SCALE 1:50

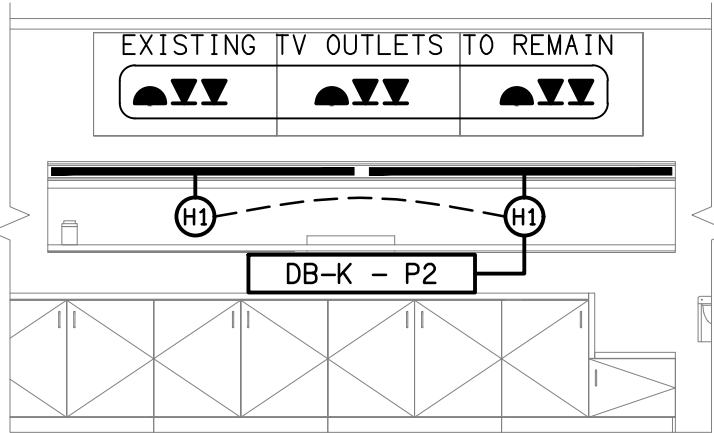

DETAIL B
CAFE SERVERY ELEVATION
SCALE 1:50

REFER TO PART A GAMING
ROOM FLOOR PLAN ON
DRAWING C3457a-E08.dwg

FOR CONTINUATION OF PLAN REFER TO PART B FLOOR PLAN ON DRAWING C3457a-E09.dwg

ELECTRICAL DESIGN GROUP BRISBANE
PTY LTD
ACN 092 710 793
TRADING AS:
ELECTRICAL DESIGN GROUP

THE COPYRIGHT OF THIS DRAWING
REMAINS THE PROPERTY OF THE
ELECTRICAL DESIGN GROUP.
USE FIGURED DIMENSIONS
IN PREFERENCE TO SCALE.
ALL DIMENSIONS TO BE
VERIFIED ONSITE.

ELECTRICAL DESIGN GROUP
ELECTRICAL BUILDING SERVICES CONSULTANTS
BRISBANE GOLD COAST

P.O. Box 15, Sherwood Q.4075
Phone: (07) 3278 4375
Email: brisbane@edg.net.au
Web: www.edg.net.au

PROJECT:
THE LION RICHLANDS - STAGE 2

133 PINE ROAD, RICHLANDS

C	TENDER	17/07/2026
REV:	DESCRIPTION:	DATE:

DRAWING:
**ELECTRICAL SERVICES
GROUND LEVEL PART A
FLOOR PLAN**

SCALE:
1:100 UNO AT A1

PROJECT NO:
C3457a

DRAWING NO:
E07

REVISION:
C