


**NOTE:**

REFER TO DRAWING C3457a-E16.dwg  
FOR THE GAMING FIBRE PLAN.

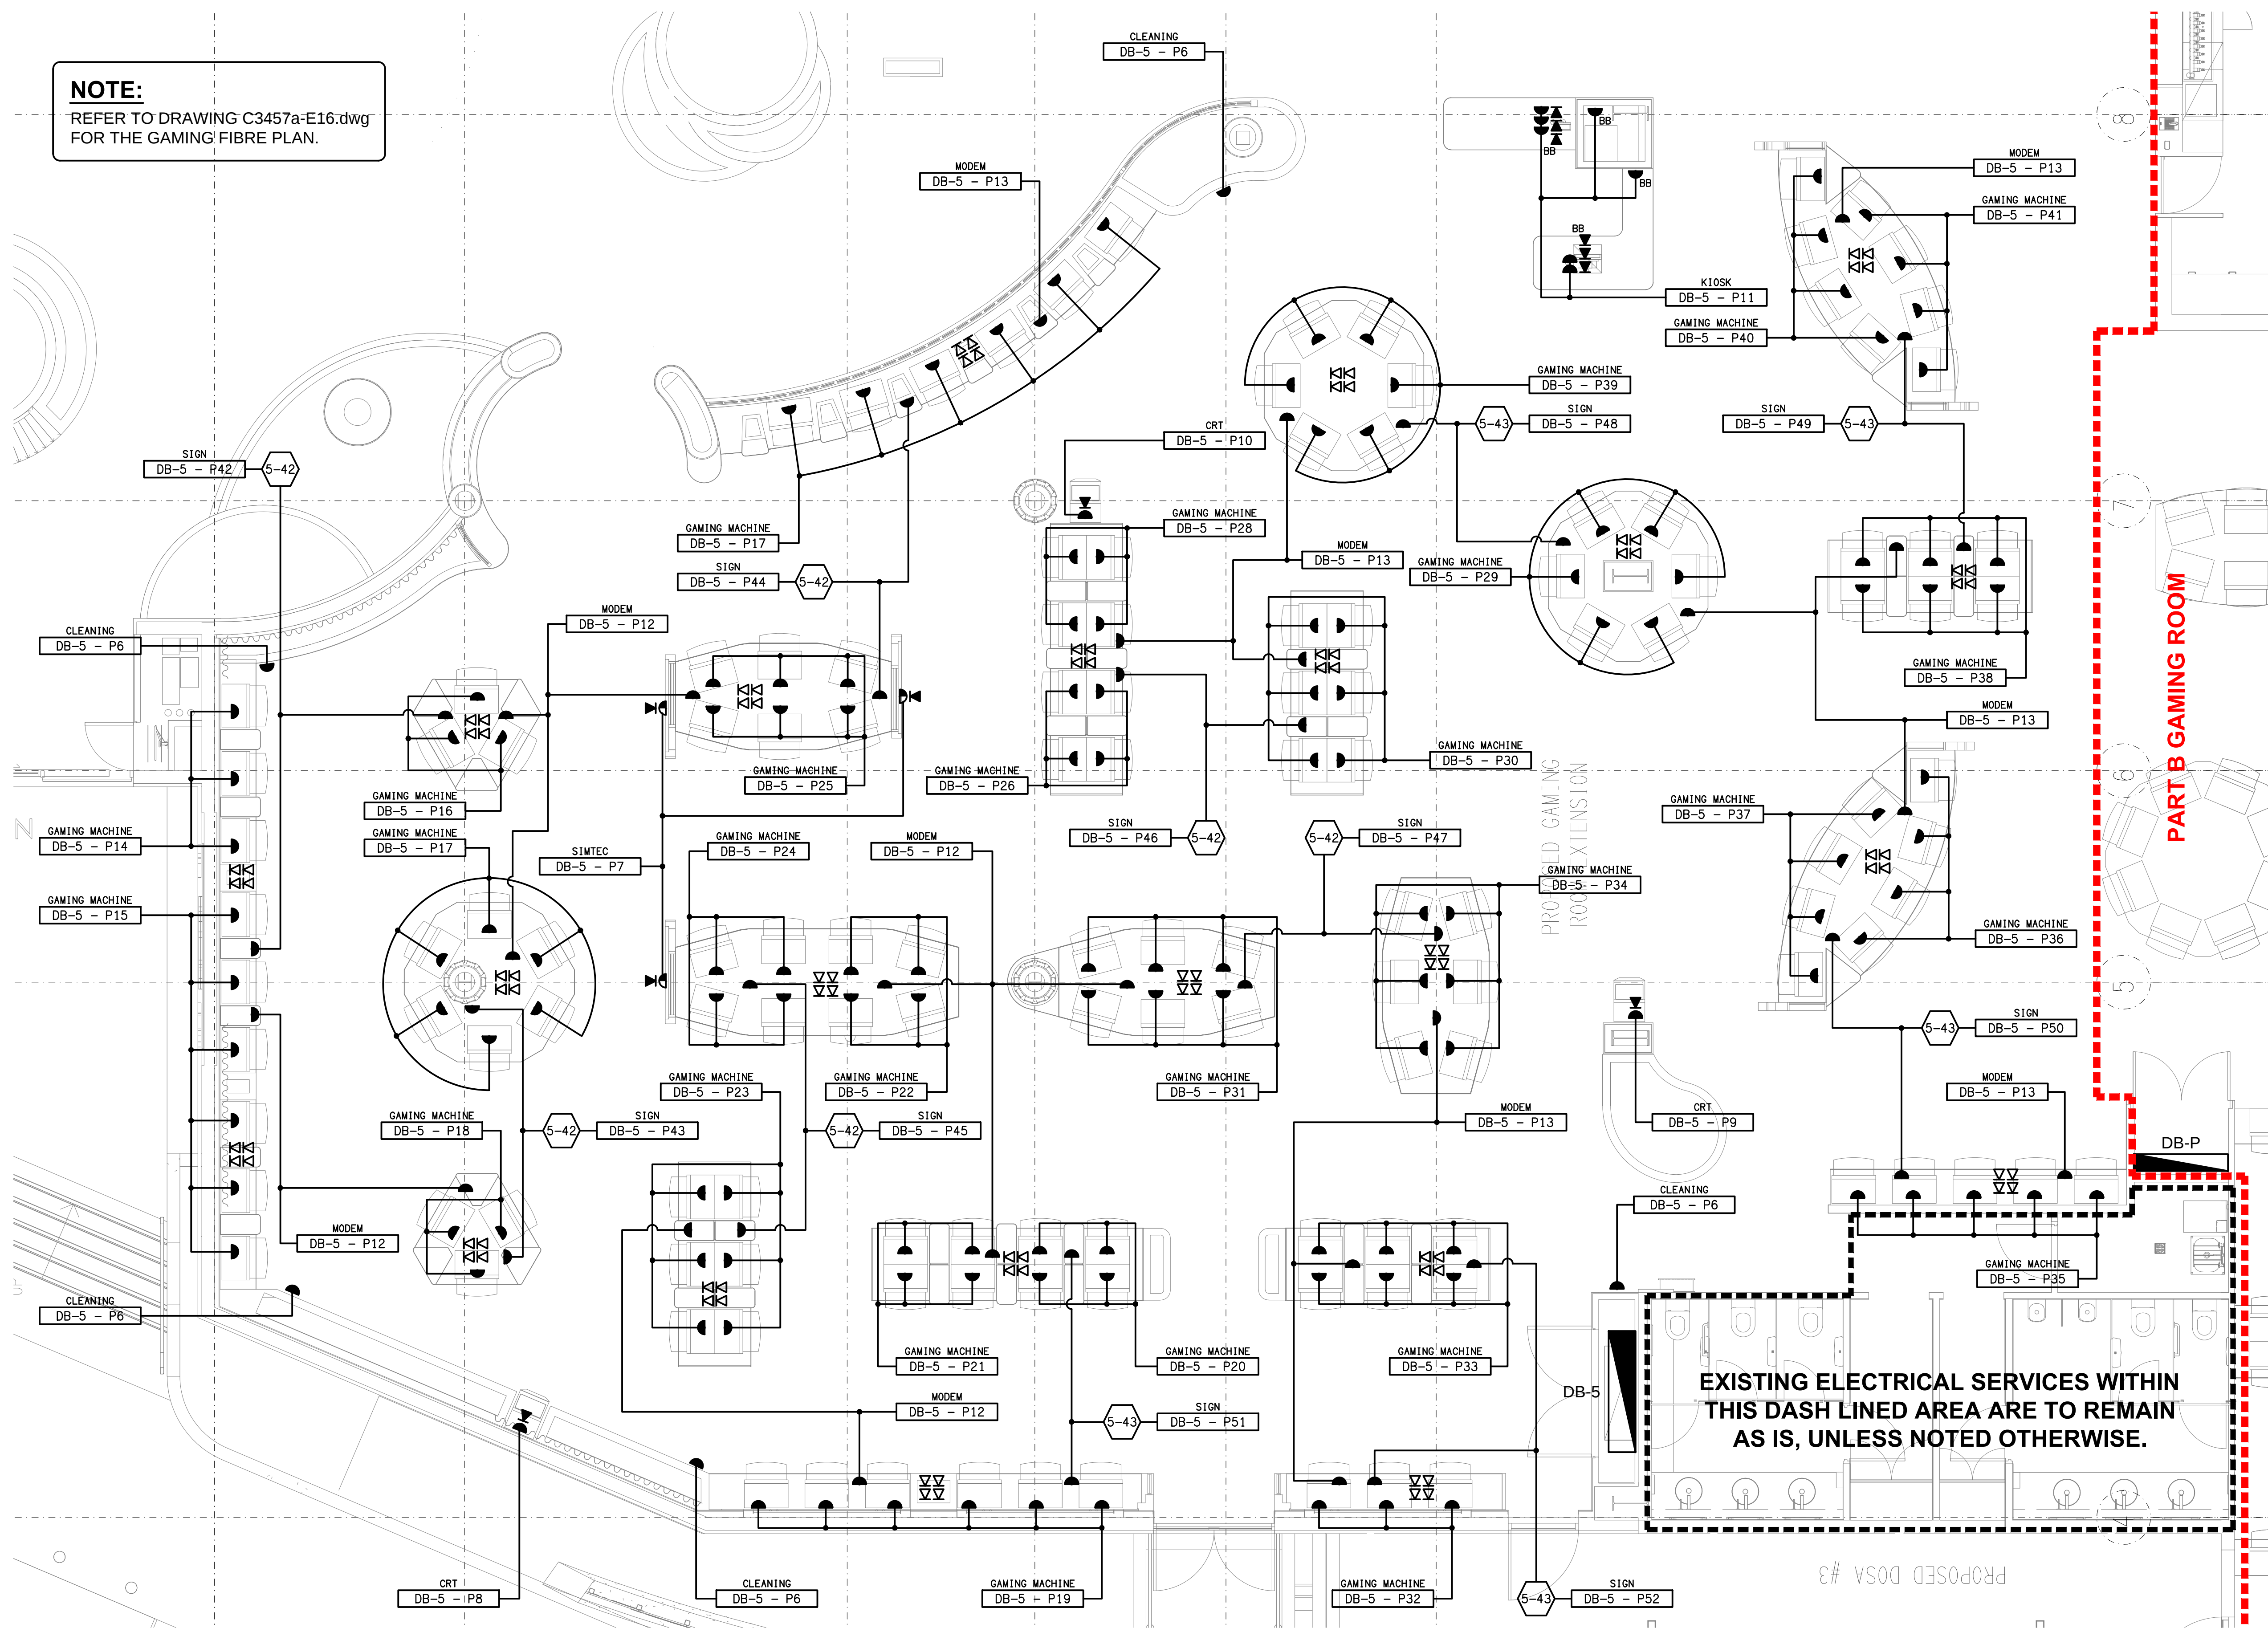

EXISTING ELECTRICAL SERVICES WITHIN  
THIS DASH LINED AREA ARE TO REMAIN  
AS IS, UNLESS NOTED OTHERWISE.

PART B GAMING ROOM

PROPOSED DOSA #3

ELECTRICAL DESIGN GROUP BRISBANE  
PTY LTD  
ACN 092 710 793  
TRADING AS:  
ELECTRICAL DESIGN GROUP

THE COPYRIGHT OF THIS DRAWING  
REMAINS THE PROPERTY OF THE  
ELECTRICAL DESIGN GROUP.  
USE FIGURED DIMENSIONS  
IN PREFERENCE TO SCALE.  
ALL DIMENSIONS TO BE  
VERIFIED ONSITE.

**ELECTRICAL DESIGN GROUP**  
ELECTRICAL BUILDING SERVICES CONSULTANTS  
BRISBANE GOLD COAST

P.O. Box 15, Sherwood Q. 4075  
Phone: (07) 3278 4375  
Email: brisbane@edg.net.au  
Web: www.edg.net.au

PROJECT:  
THE LION RICHLANDS - STAGE 2

133 PINE ROAD, RICHLANDS

|      |              |            |
|------|--------------|------------|
| D    | CONSTRUCTION | 16/09/2026 |
| REV. | DESCRIPTION: | DATE:      |

|                                                                                           |       |                              |                           |                       |
|-------------------------------------------------------------------------------------------|-------|------------------------------|---------------------------|-----------------------|
| DRAWING:<br><b>ELECTRICAL SERVICES<br/>GROUND LEVEL PART A<br/>GAMING ROOM FLOOR PLAN</b> |       | PROJECT NO:<br><b>C3457a</b> | DRAWING NO:<br><b>E08</b> | REVISION:<br><b>D</b> |
| SCALE:<br>1:50                                                                            | AT A1 |                              |                           |                       |