


NOTE:
REFER TO DRAWING C3457a-E12.dwg FOR
ADDITIONAL CEILING STRIP LIGHTING PLAN.
REFER TO DRAWING C3457a-E13.dwg FOR
ADDITIONAL JOINERY & WALL LIGHTING PLAN.

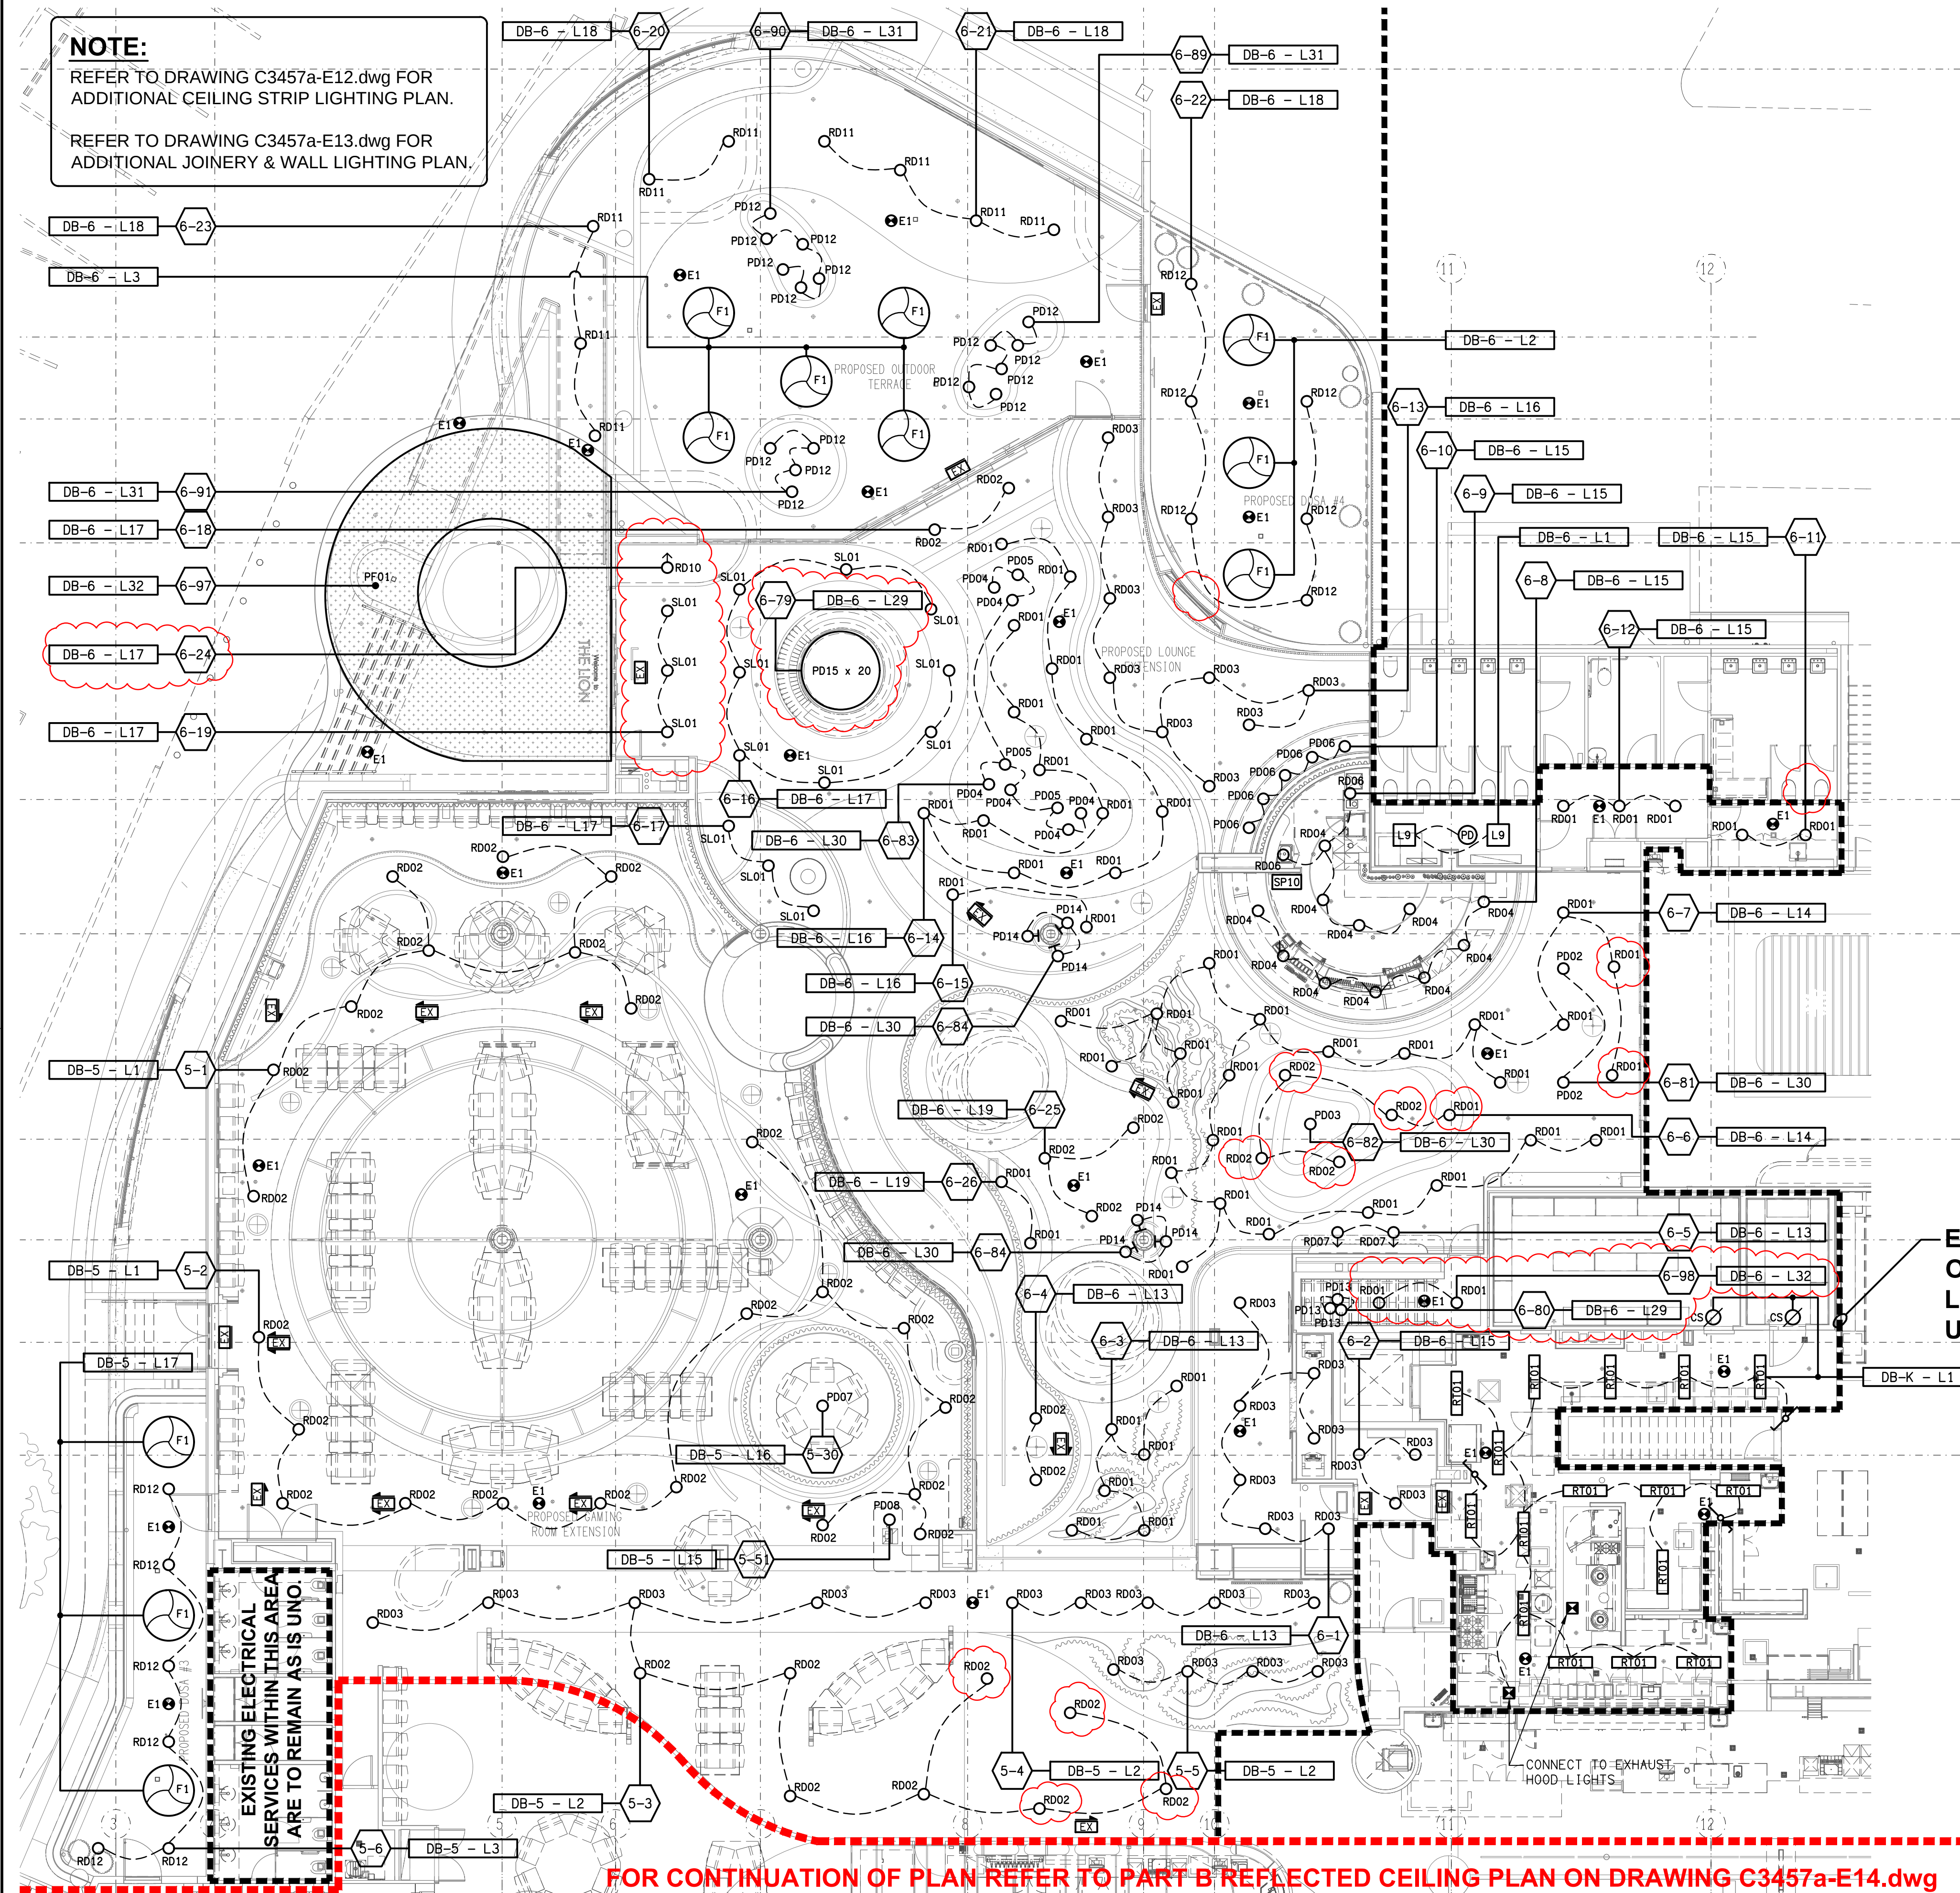

EXISTING ELECTRICAL SERVICES
ON THIS SIDE OF THE DASHED
LINE ARE TO REMAIN AS IS,
UNLESS NOTED OTHERWISE.

FOR CONTINUATION OF PLAN REFER TO PART B REFLECTED CEILING PLAN ON DRAWING C3457a-E14.dwg

ELECTRICAL DESIGN GROUP BRISBANE
PTY LTD
ACN 092 710 793
TRADING AS:
ELECTRICAL DESIGN GROUP

THE COPYRIGHT OF THIS DRAWING
REMAINS THE PROPERTY OF THE
ELECTRICAL DESIGN GROUP.
USE FIGURED DIMENSIONS
IN PREFERENCE TO SCALE.
ALL DIMENSIONS TO BE
VERIFIED ON SITE.

ELECTRICAL DESIGN GROUP
ELECTRICAL BUILDING SERVICES CONSULTANTS
BRISBANE GOLD COAST

P.O. Box 15, Sherwood Q. 4075
Phone: (07) 3278 4375
Email: brisbane@edg.net.au
Web: www.edg.net.au

PROJECT:
THE LION RICHLANDS - STAGE 2

133 PINE ROAD, RICHLANDS

C	CONSTRUCTION	16/09/2026
REV.	DESCRIPTION:	DATE:

DRAWING:
**ELECTRICAL SERVICES
GROUND LEVEL PART A
REFLECTED CEILING PLAN**

SCALE: 1:100 UNO	PROJECT NO: C3457a	DRAWING NO: E11	REVISION: C
---------------------	-----------------------	--------------------	----------------