

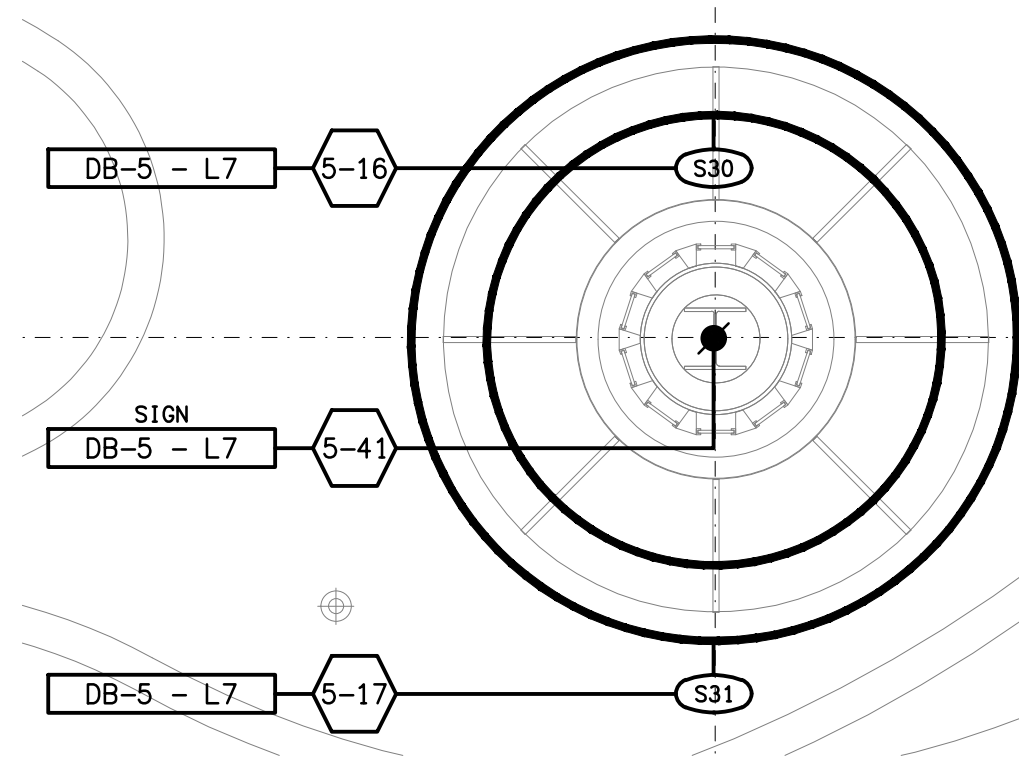


NOTE:
REFER TO DRAWING C3457a-E13.dwg FOR
ADDITIONAL JOINERY & WALL LIGHTING PLAN.

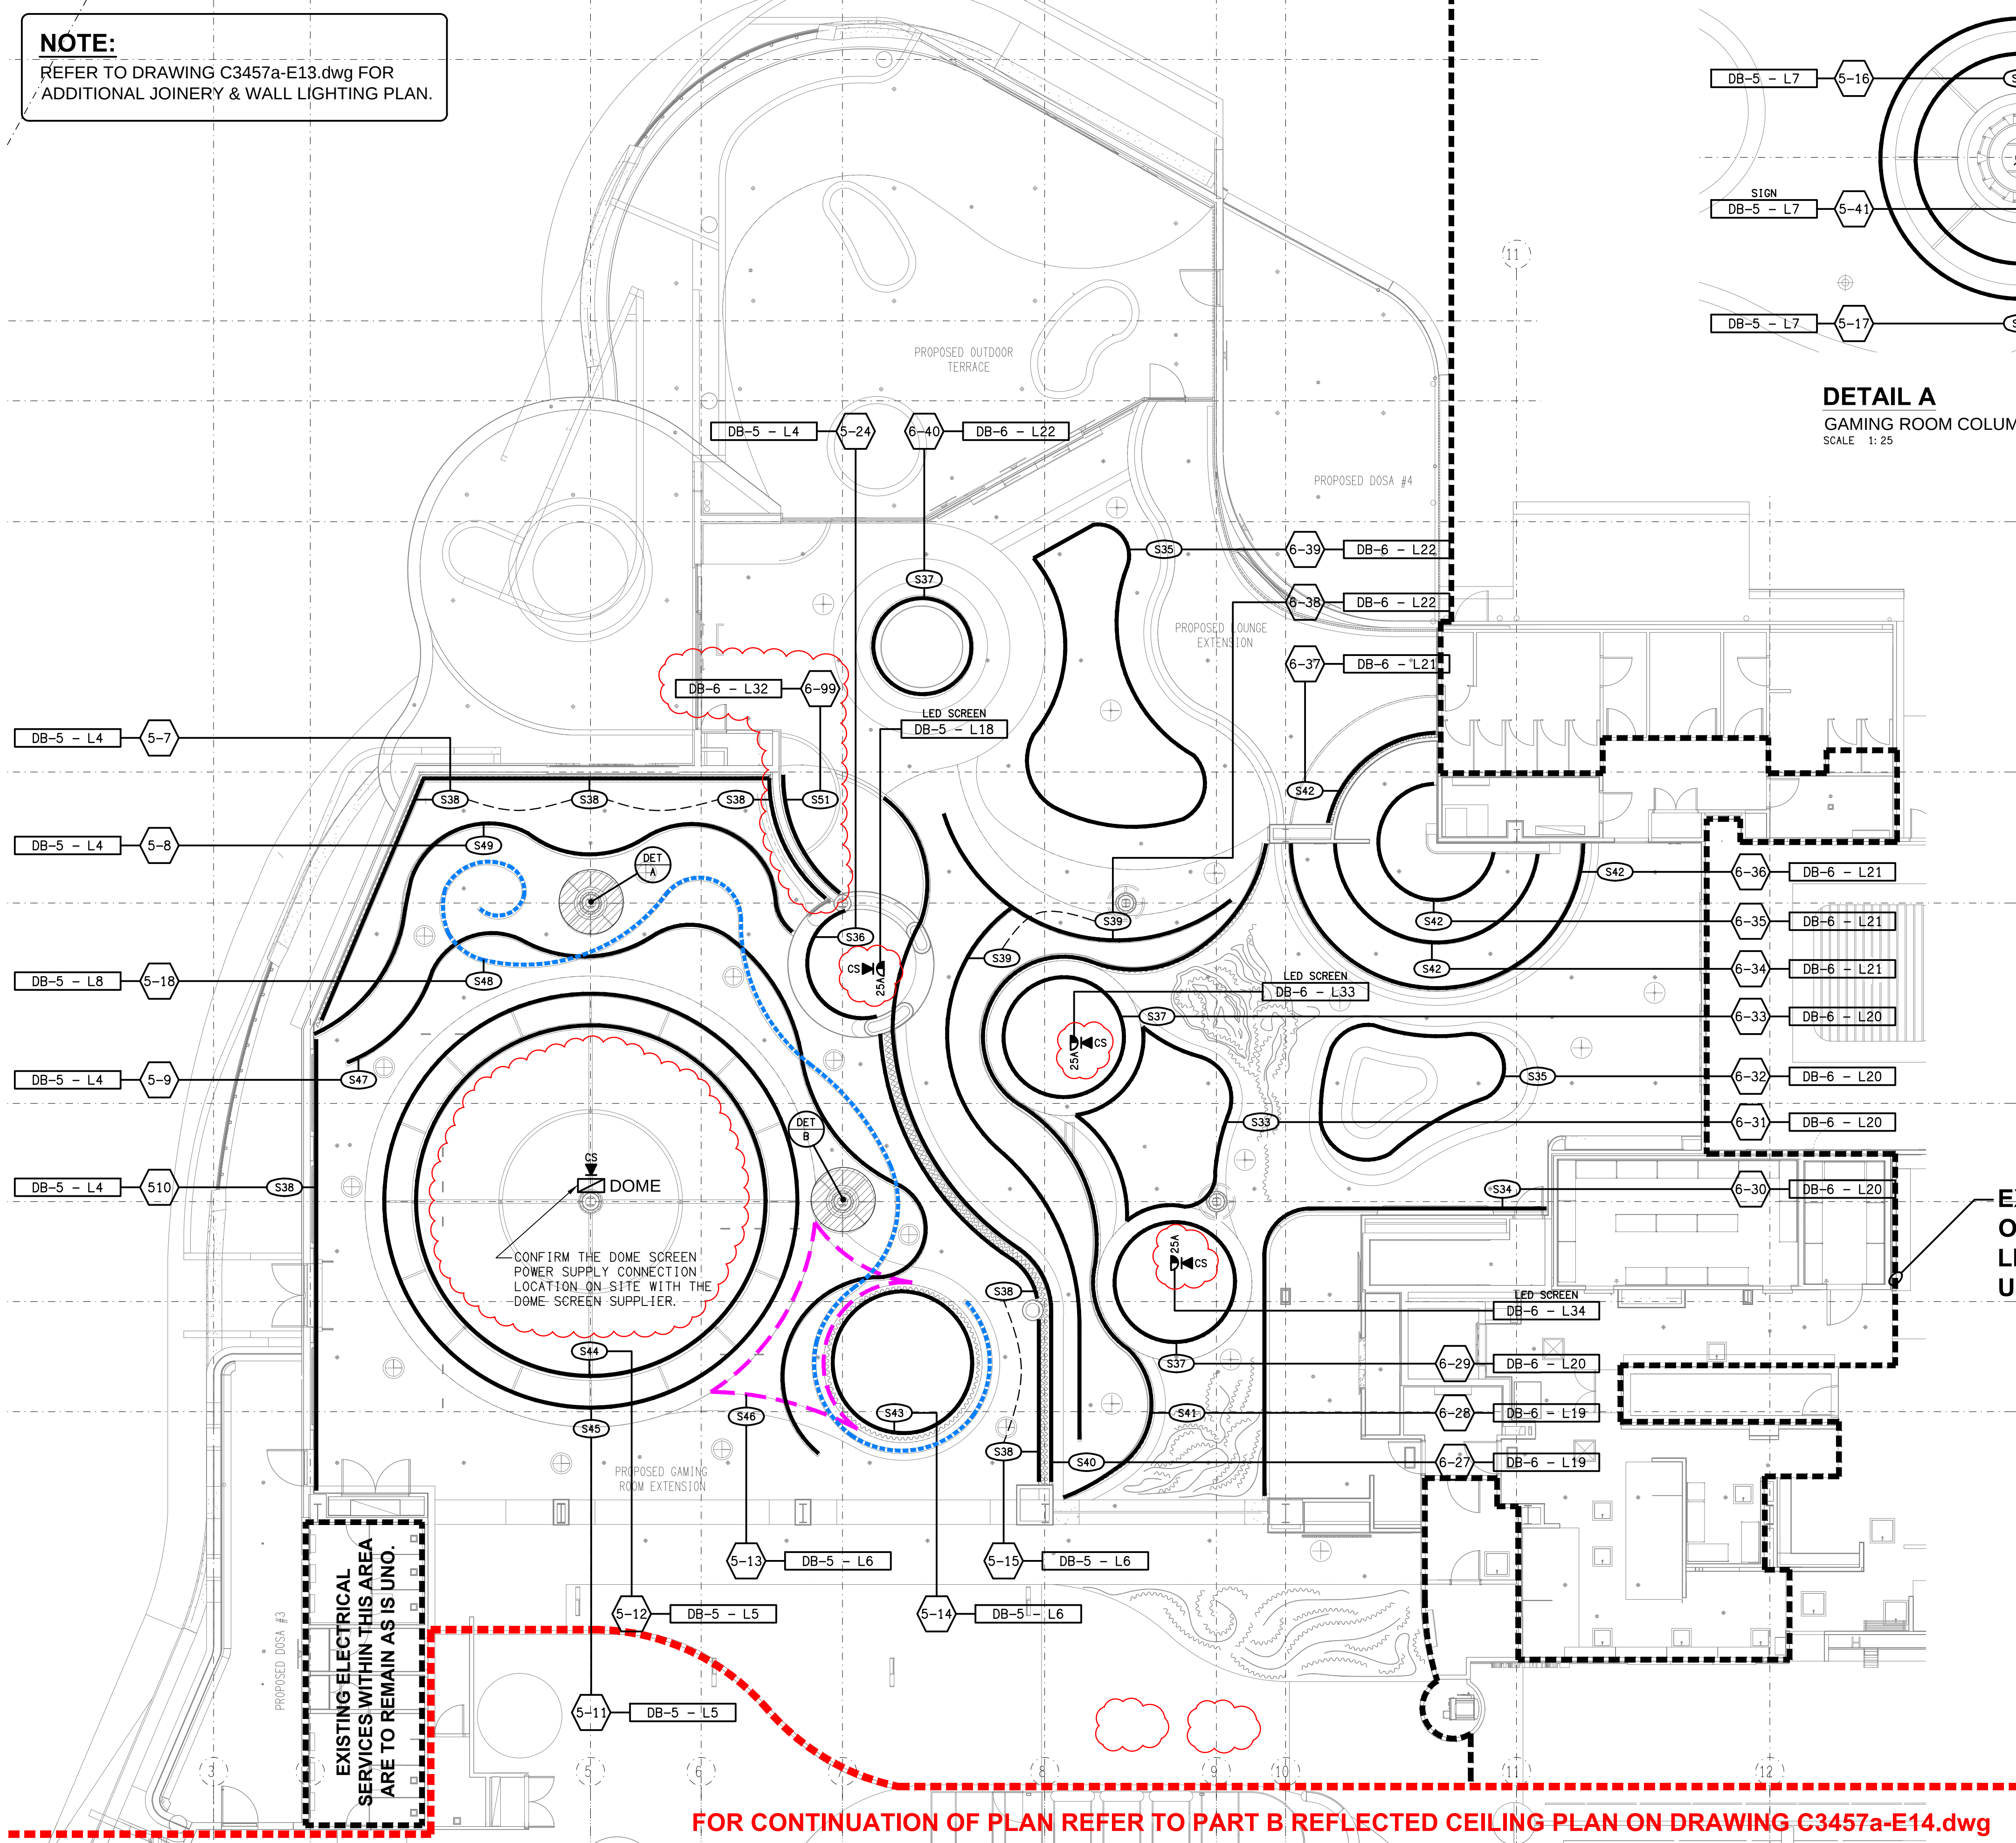

DETAIL A
GAMING ROOM COLUMN 1
SCALE 1: 25

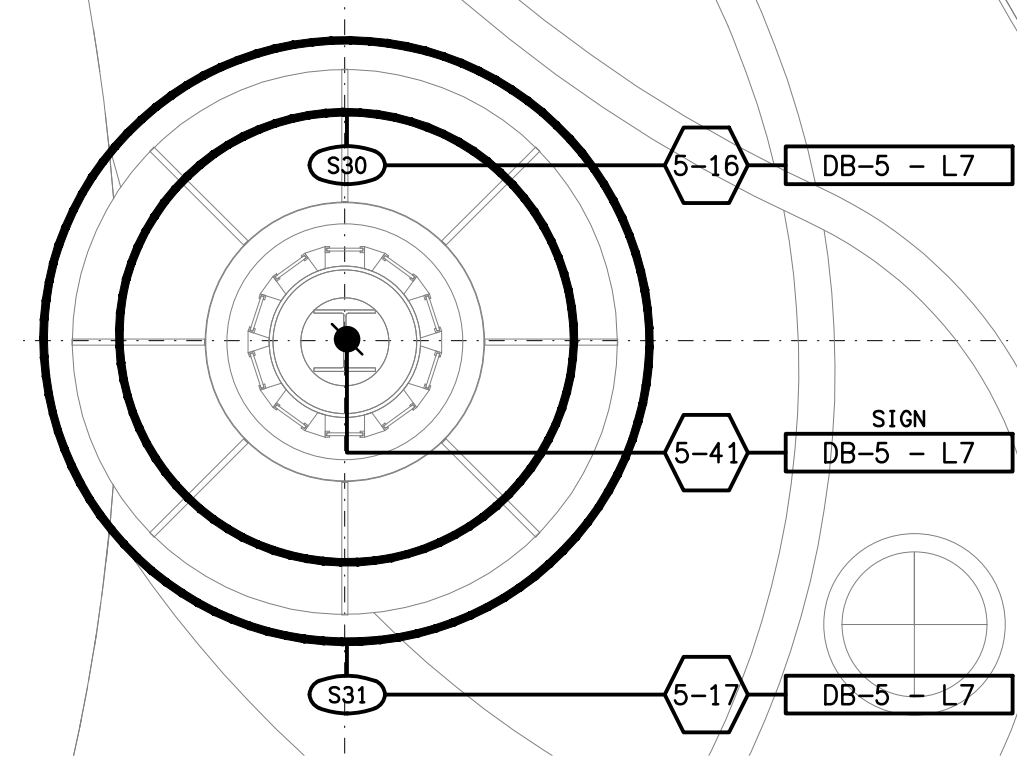

DETAIL B
GAMING ROOM COLUMN 2
SCALE 1: 25

EXISTING ELECTRICAL SERVICES
ON THIS SIDE OF THE DASHED
LINE ARE TO REMAIN AS IS,
UNLESS NOTED OTHERWISE.