
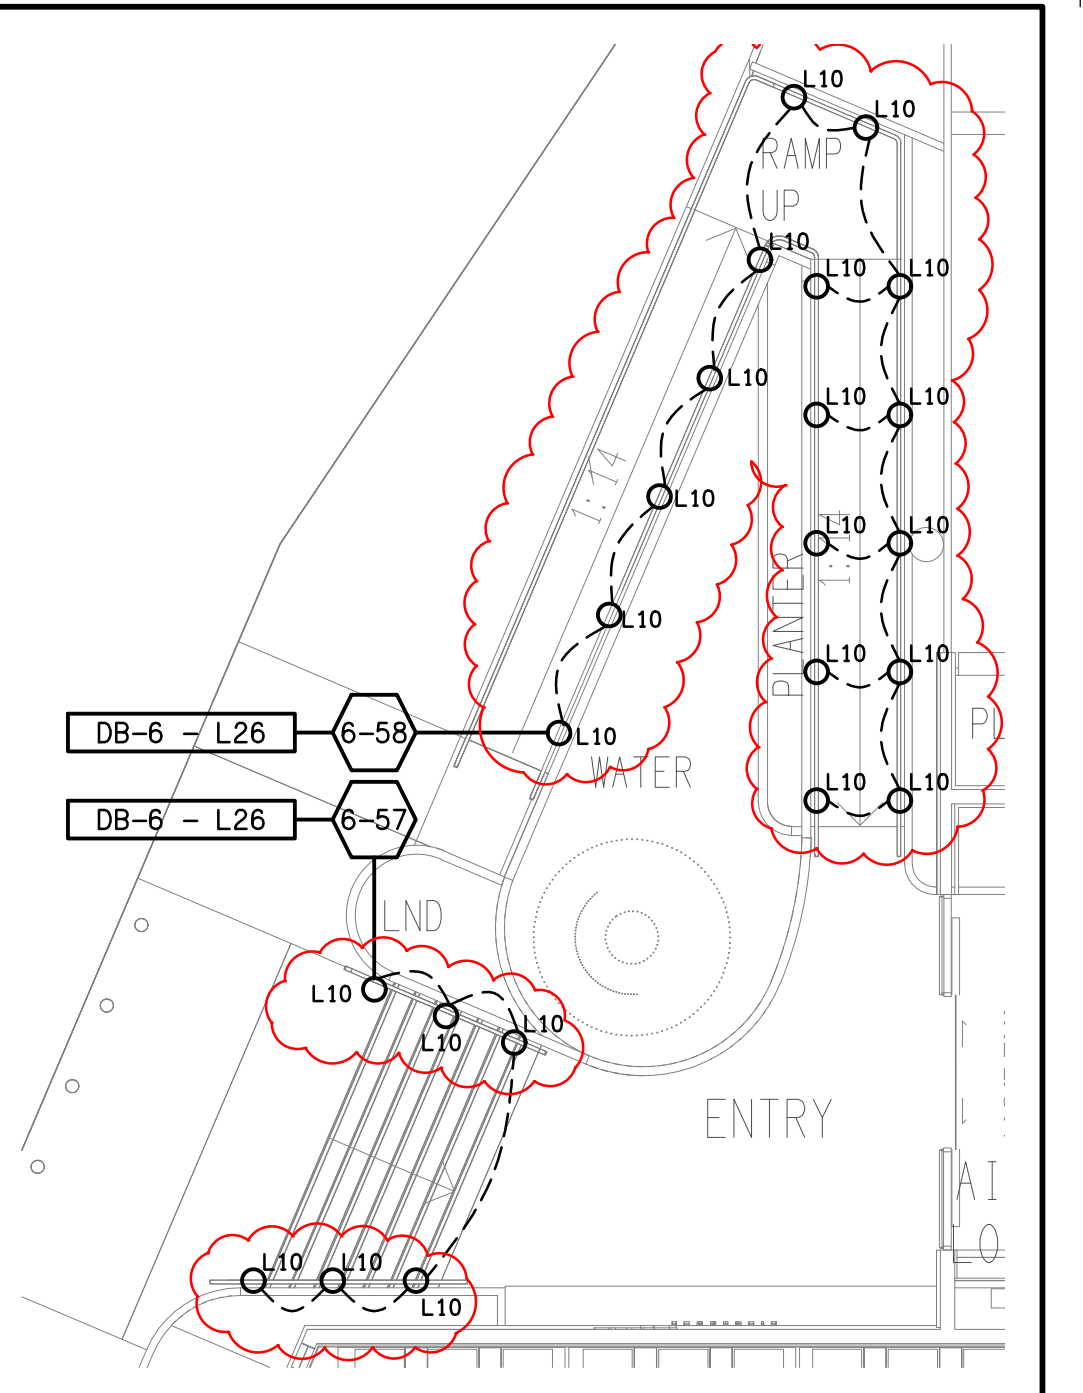


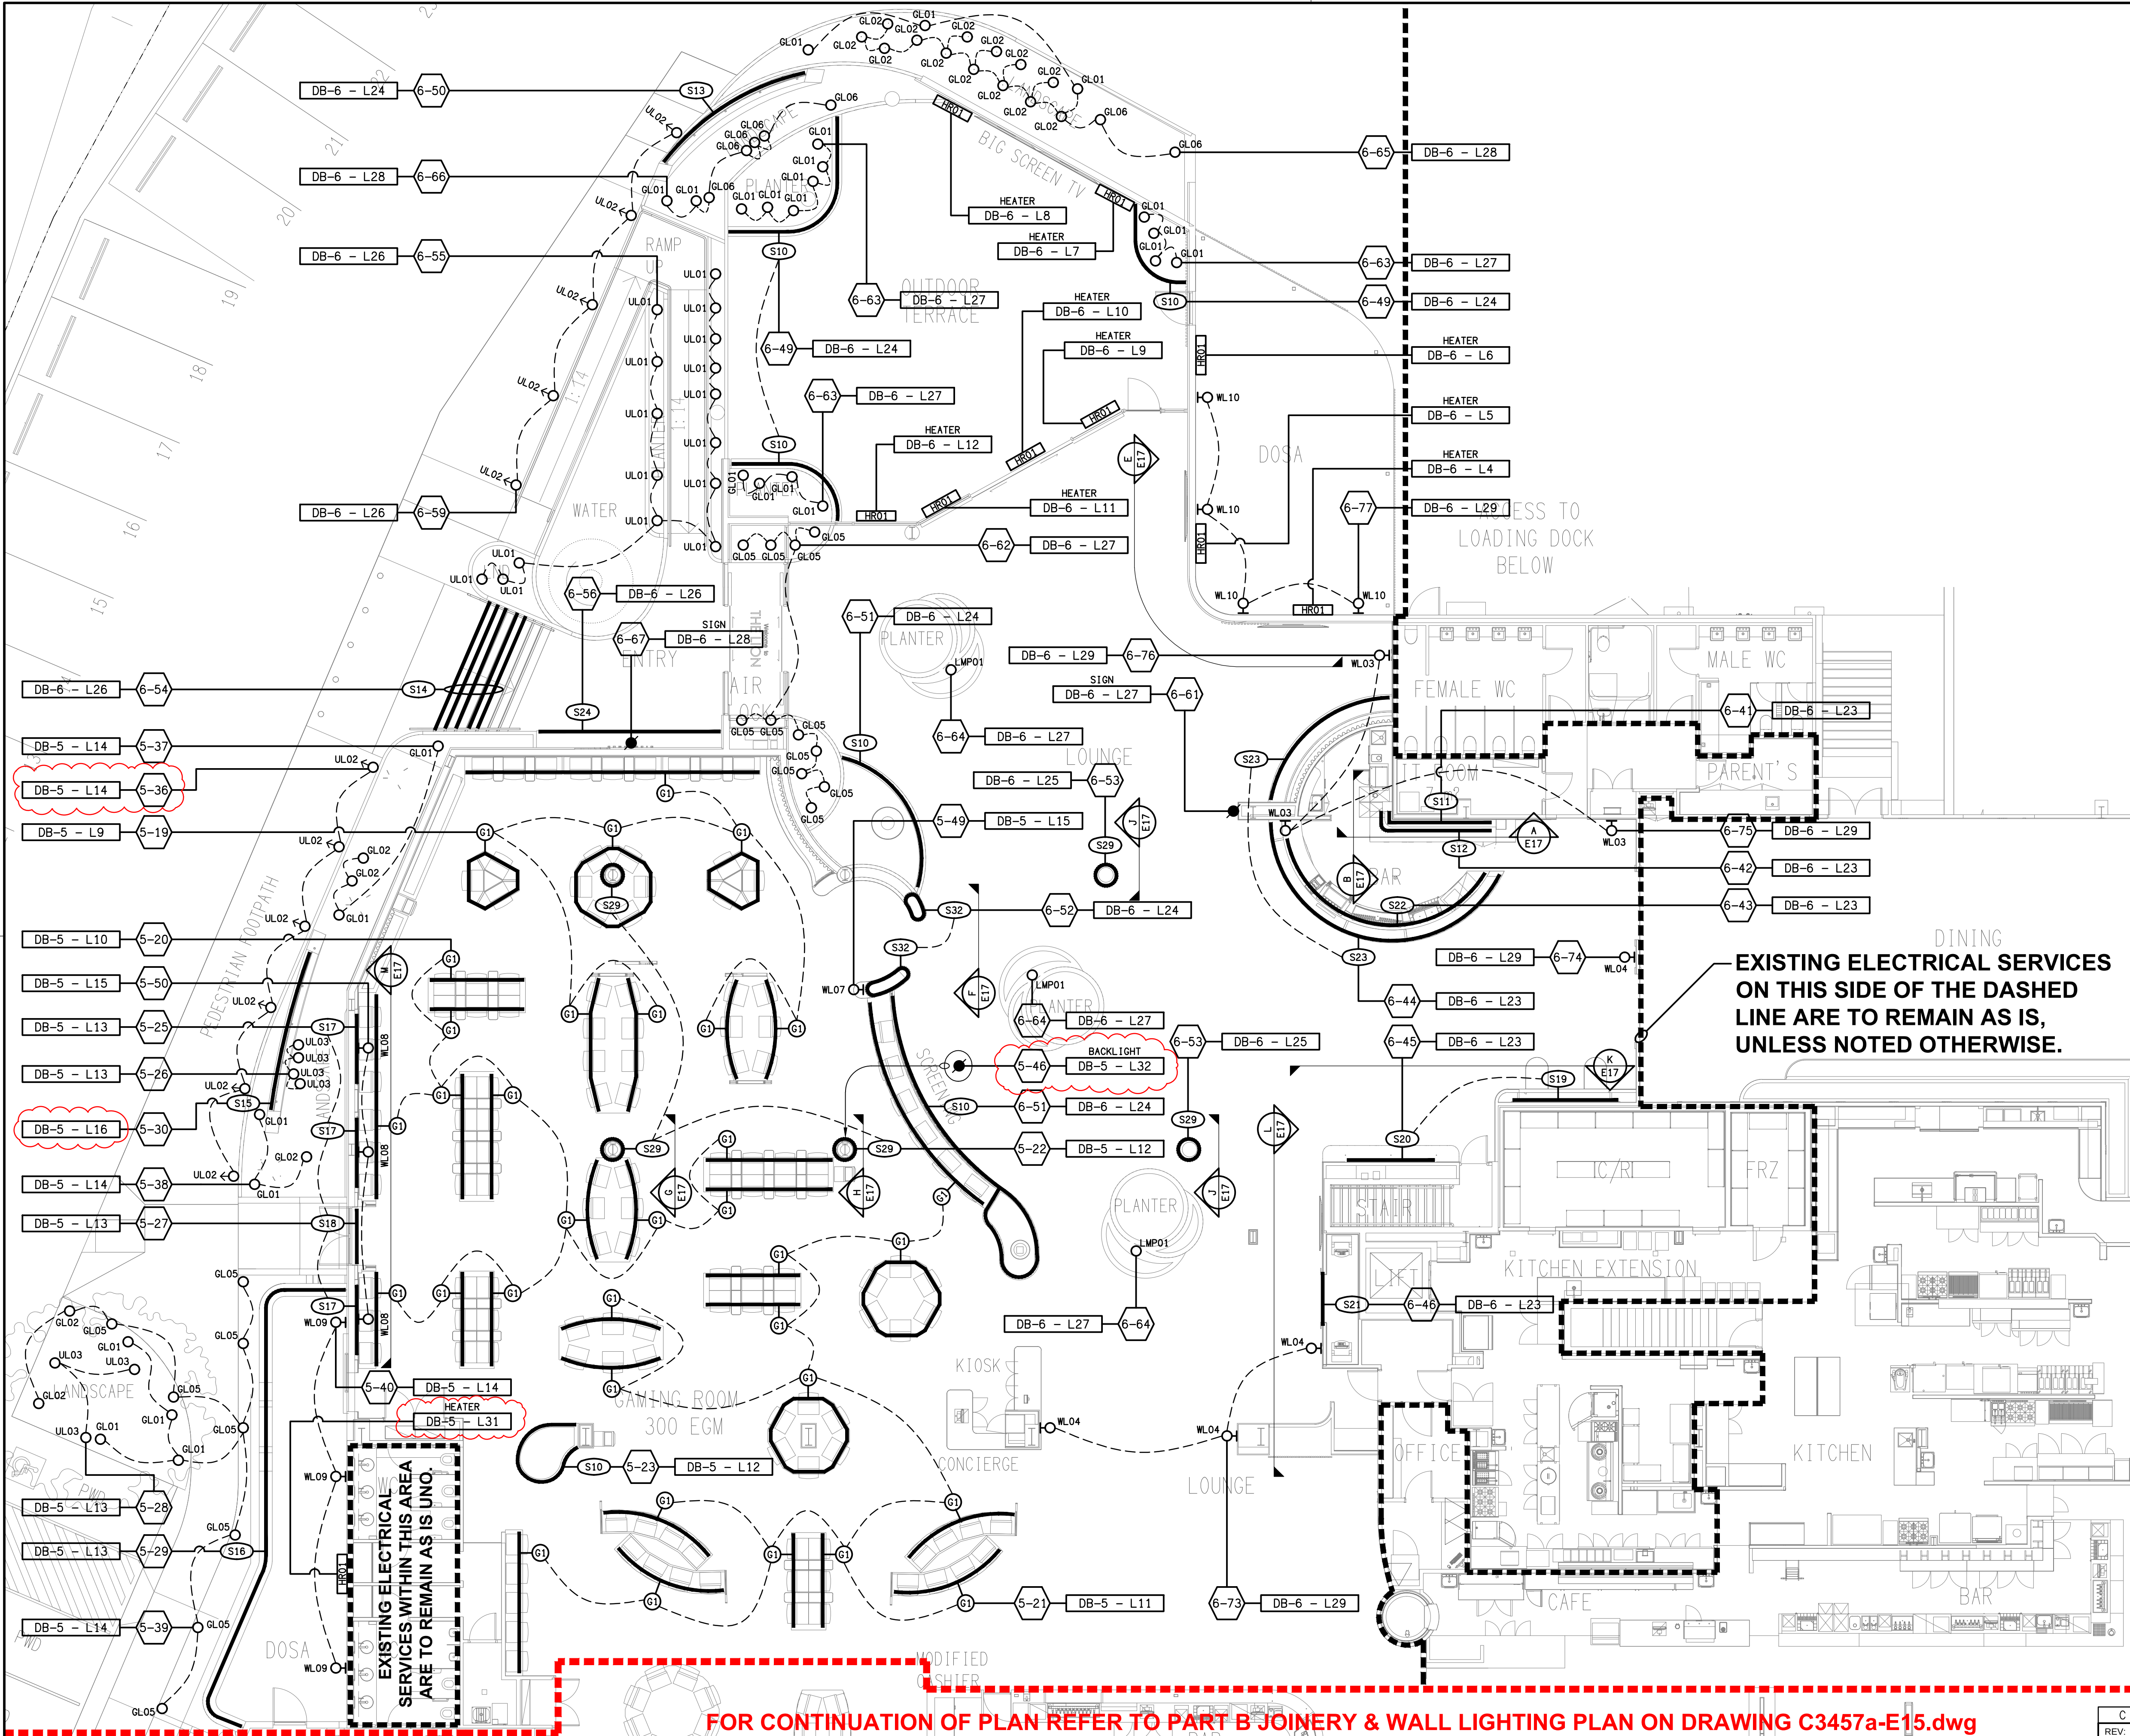

DETAIL
HANDRAIL LIGHTING PLAN
SCALE 1:100

EXISTING ELECTRICAL SERVICES
ON THIS SIDE OF THE DASHED
LINE ARE TO REMAIN AS IS,
UNLESS NOTED OTHERWISE.

FOR CONTINUATION OF PLAN REFER TO PART B JOINERY & WALL LIGHTING PLAN ON DRAWING C3457a-E15.dwg