



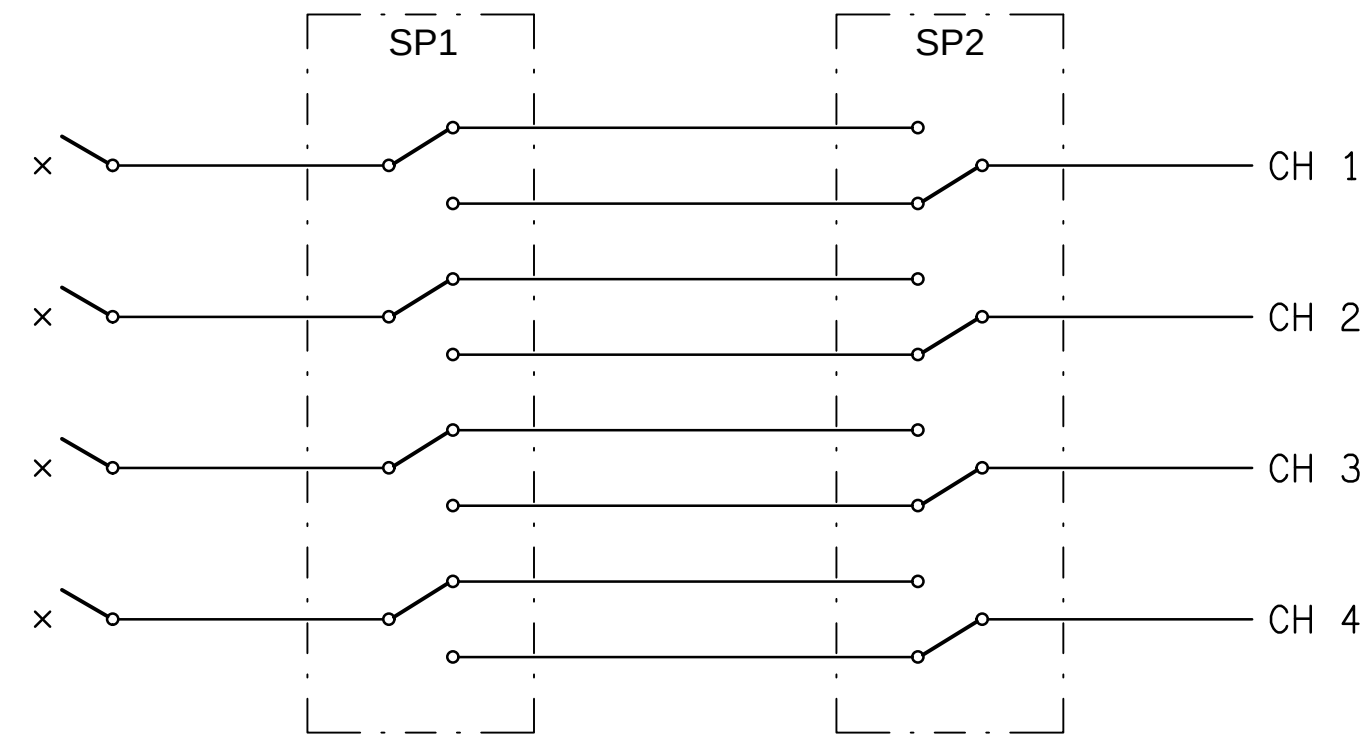

SCHEMATIC
SWITCH PANEL SP1 / SP2 CONFIGURATION
NOT TO SCALE

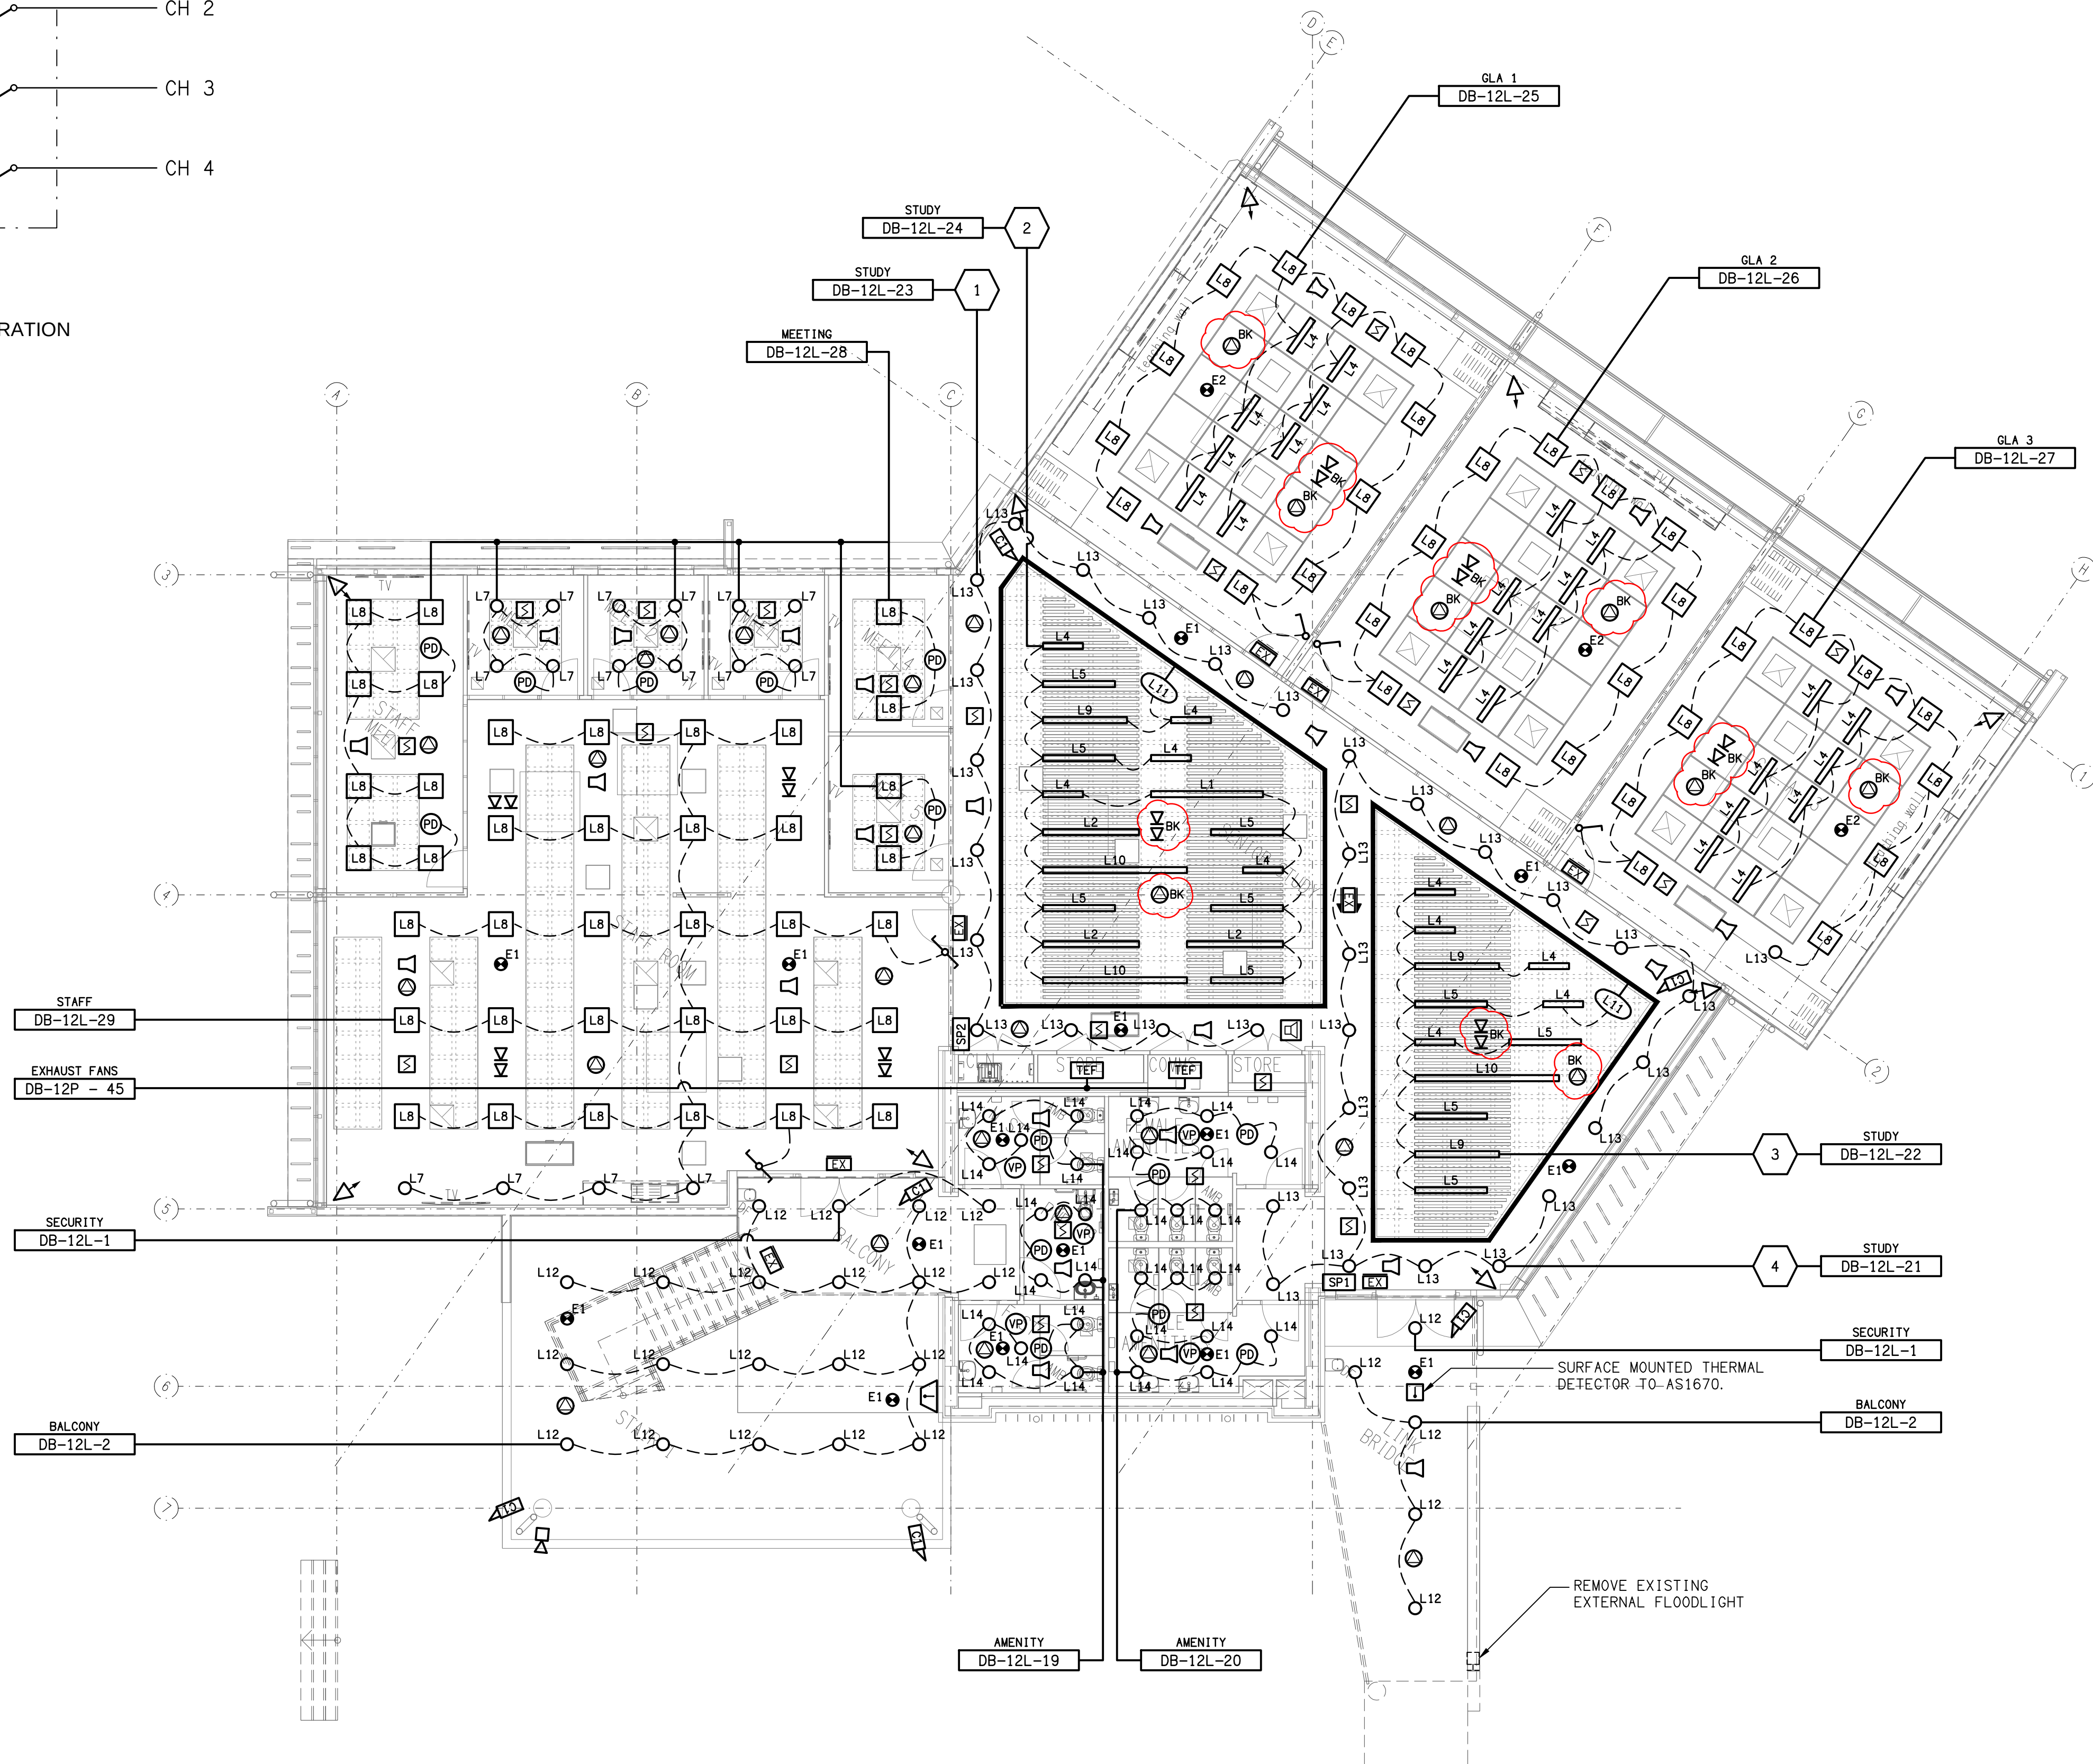

ELECTRICAL DESIGN GROUP BRISBANE
PTY LTD
ACN 092 710 793
TRADING AS:
ELECTRICAL DESIGN GROUP

THE COPYRIGHT OF THIS DRAWING
REMAINS THE PROPERTY OF THE
ELECTRICAL DESIGN GROUP.
USE FIGURED DIMENSIONS
IN PREFERENCE TO SCALE.
ALL DIMENSIONS TO BE
VERIFIED ONSITE.

ELECTRICAL DESIGN GROUP
ELECTRICAL BUILDING SERVICES CONSULTANTS
BRISBANE GOLD COAST

P.O. Box 15, Sherwood Q.4075
Phone: (07) 3278 4375
Email: brisbane@edg.net.au
Web: www.edg.net.au

PROJECT:
**KINGS CHRISTIAN COLLEGE
CHAMBERS FLAT, SENIOR SCHOOL CHA12**

38-112 ANZAC AVENUE, CHAMBERS FLAT

F	CONSTRUCTION	05/08/2026
REV.	DESCRIPTION:	DATE:

DRAWING: ELECTRICAL SERVICES LEVEL 2 REFLECTED CEILING PLAN		PROJECT NO:	DRAWING NO:	REVISION:
SCALE: 1:100		AT A1	C3474a E10	F