




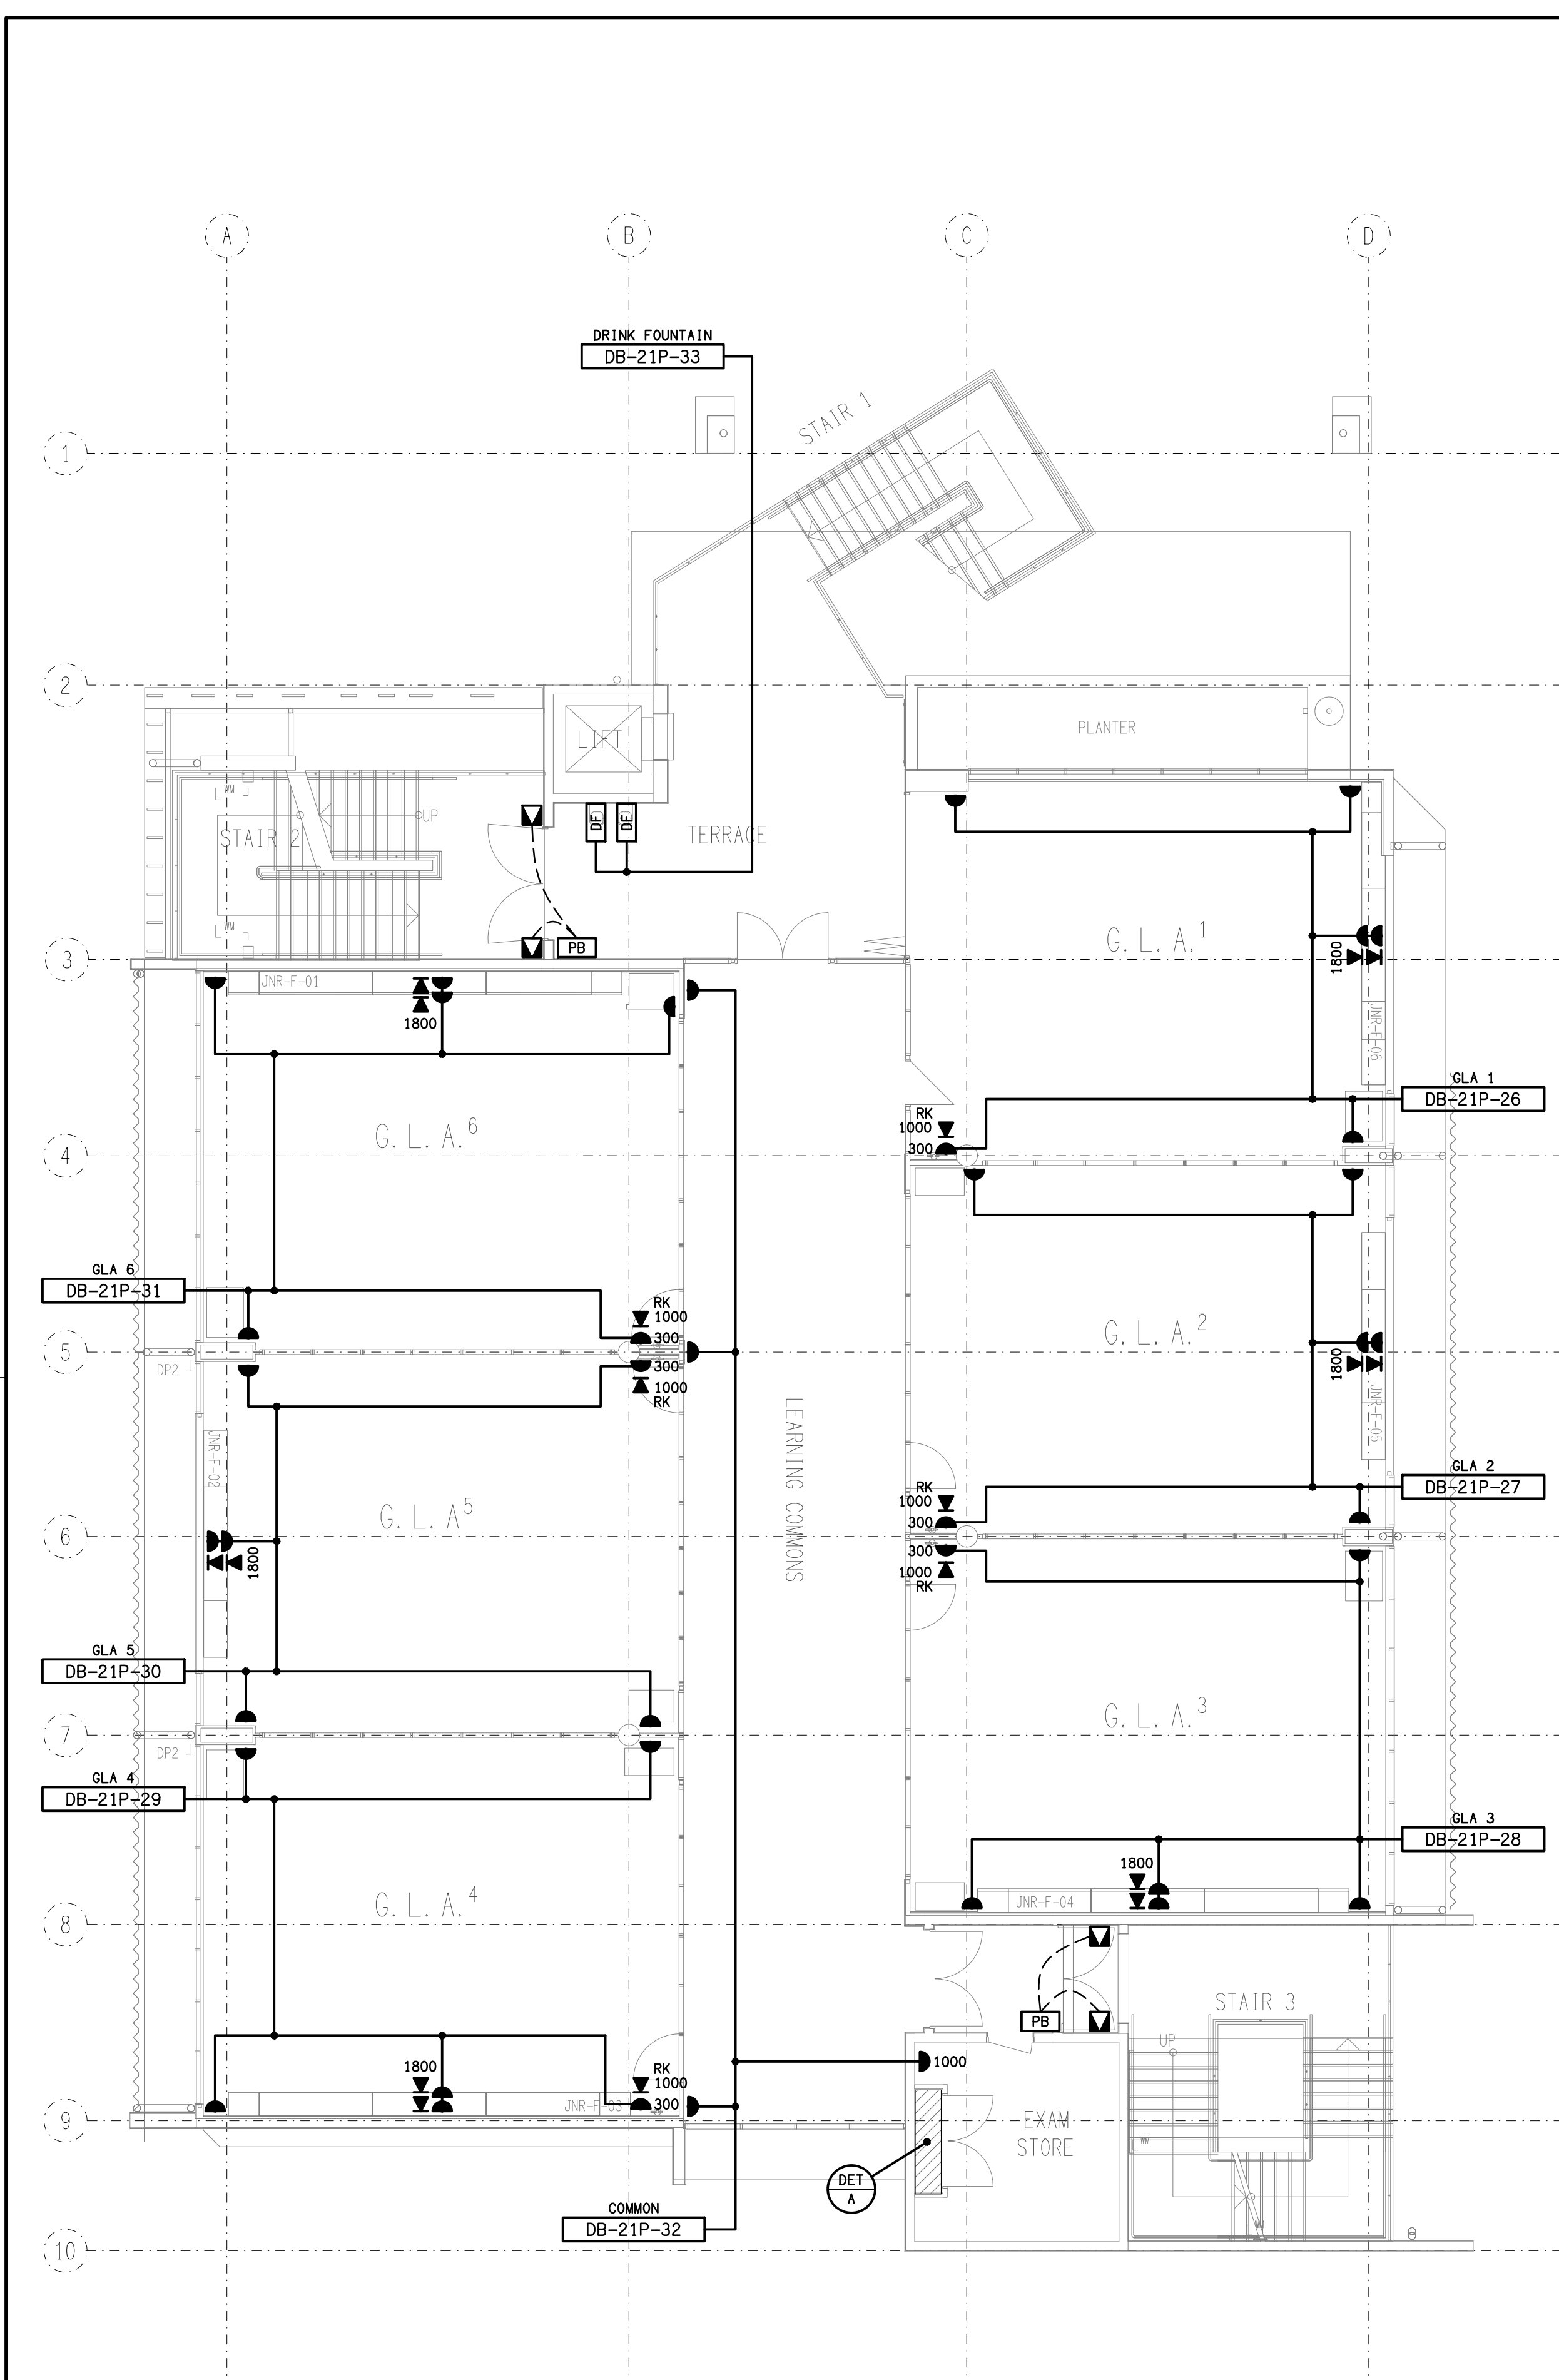

FLOOR PLAN
LEVEL 1
SCALE 1: 100

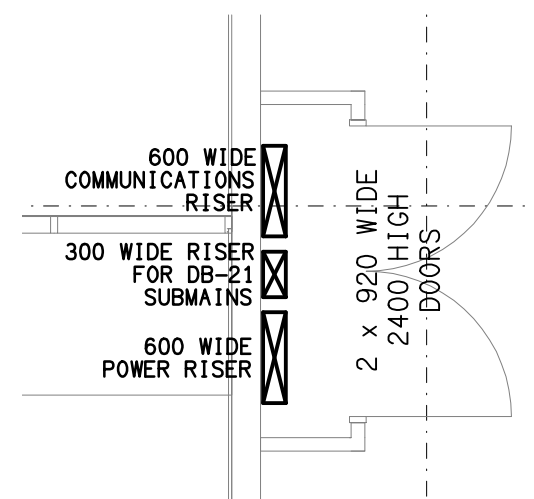

DETAIL A
LEVEL 1 ELECTRICAL RISER CUPBOARD
SCALE 1: 50

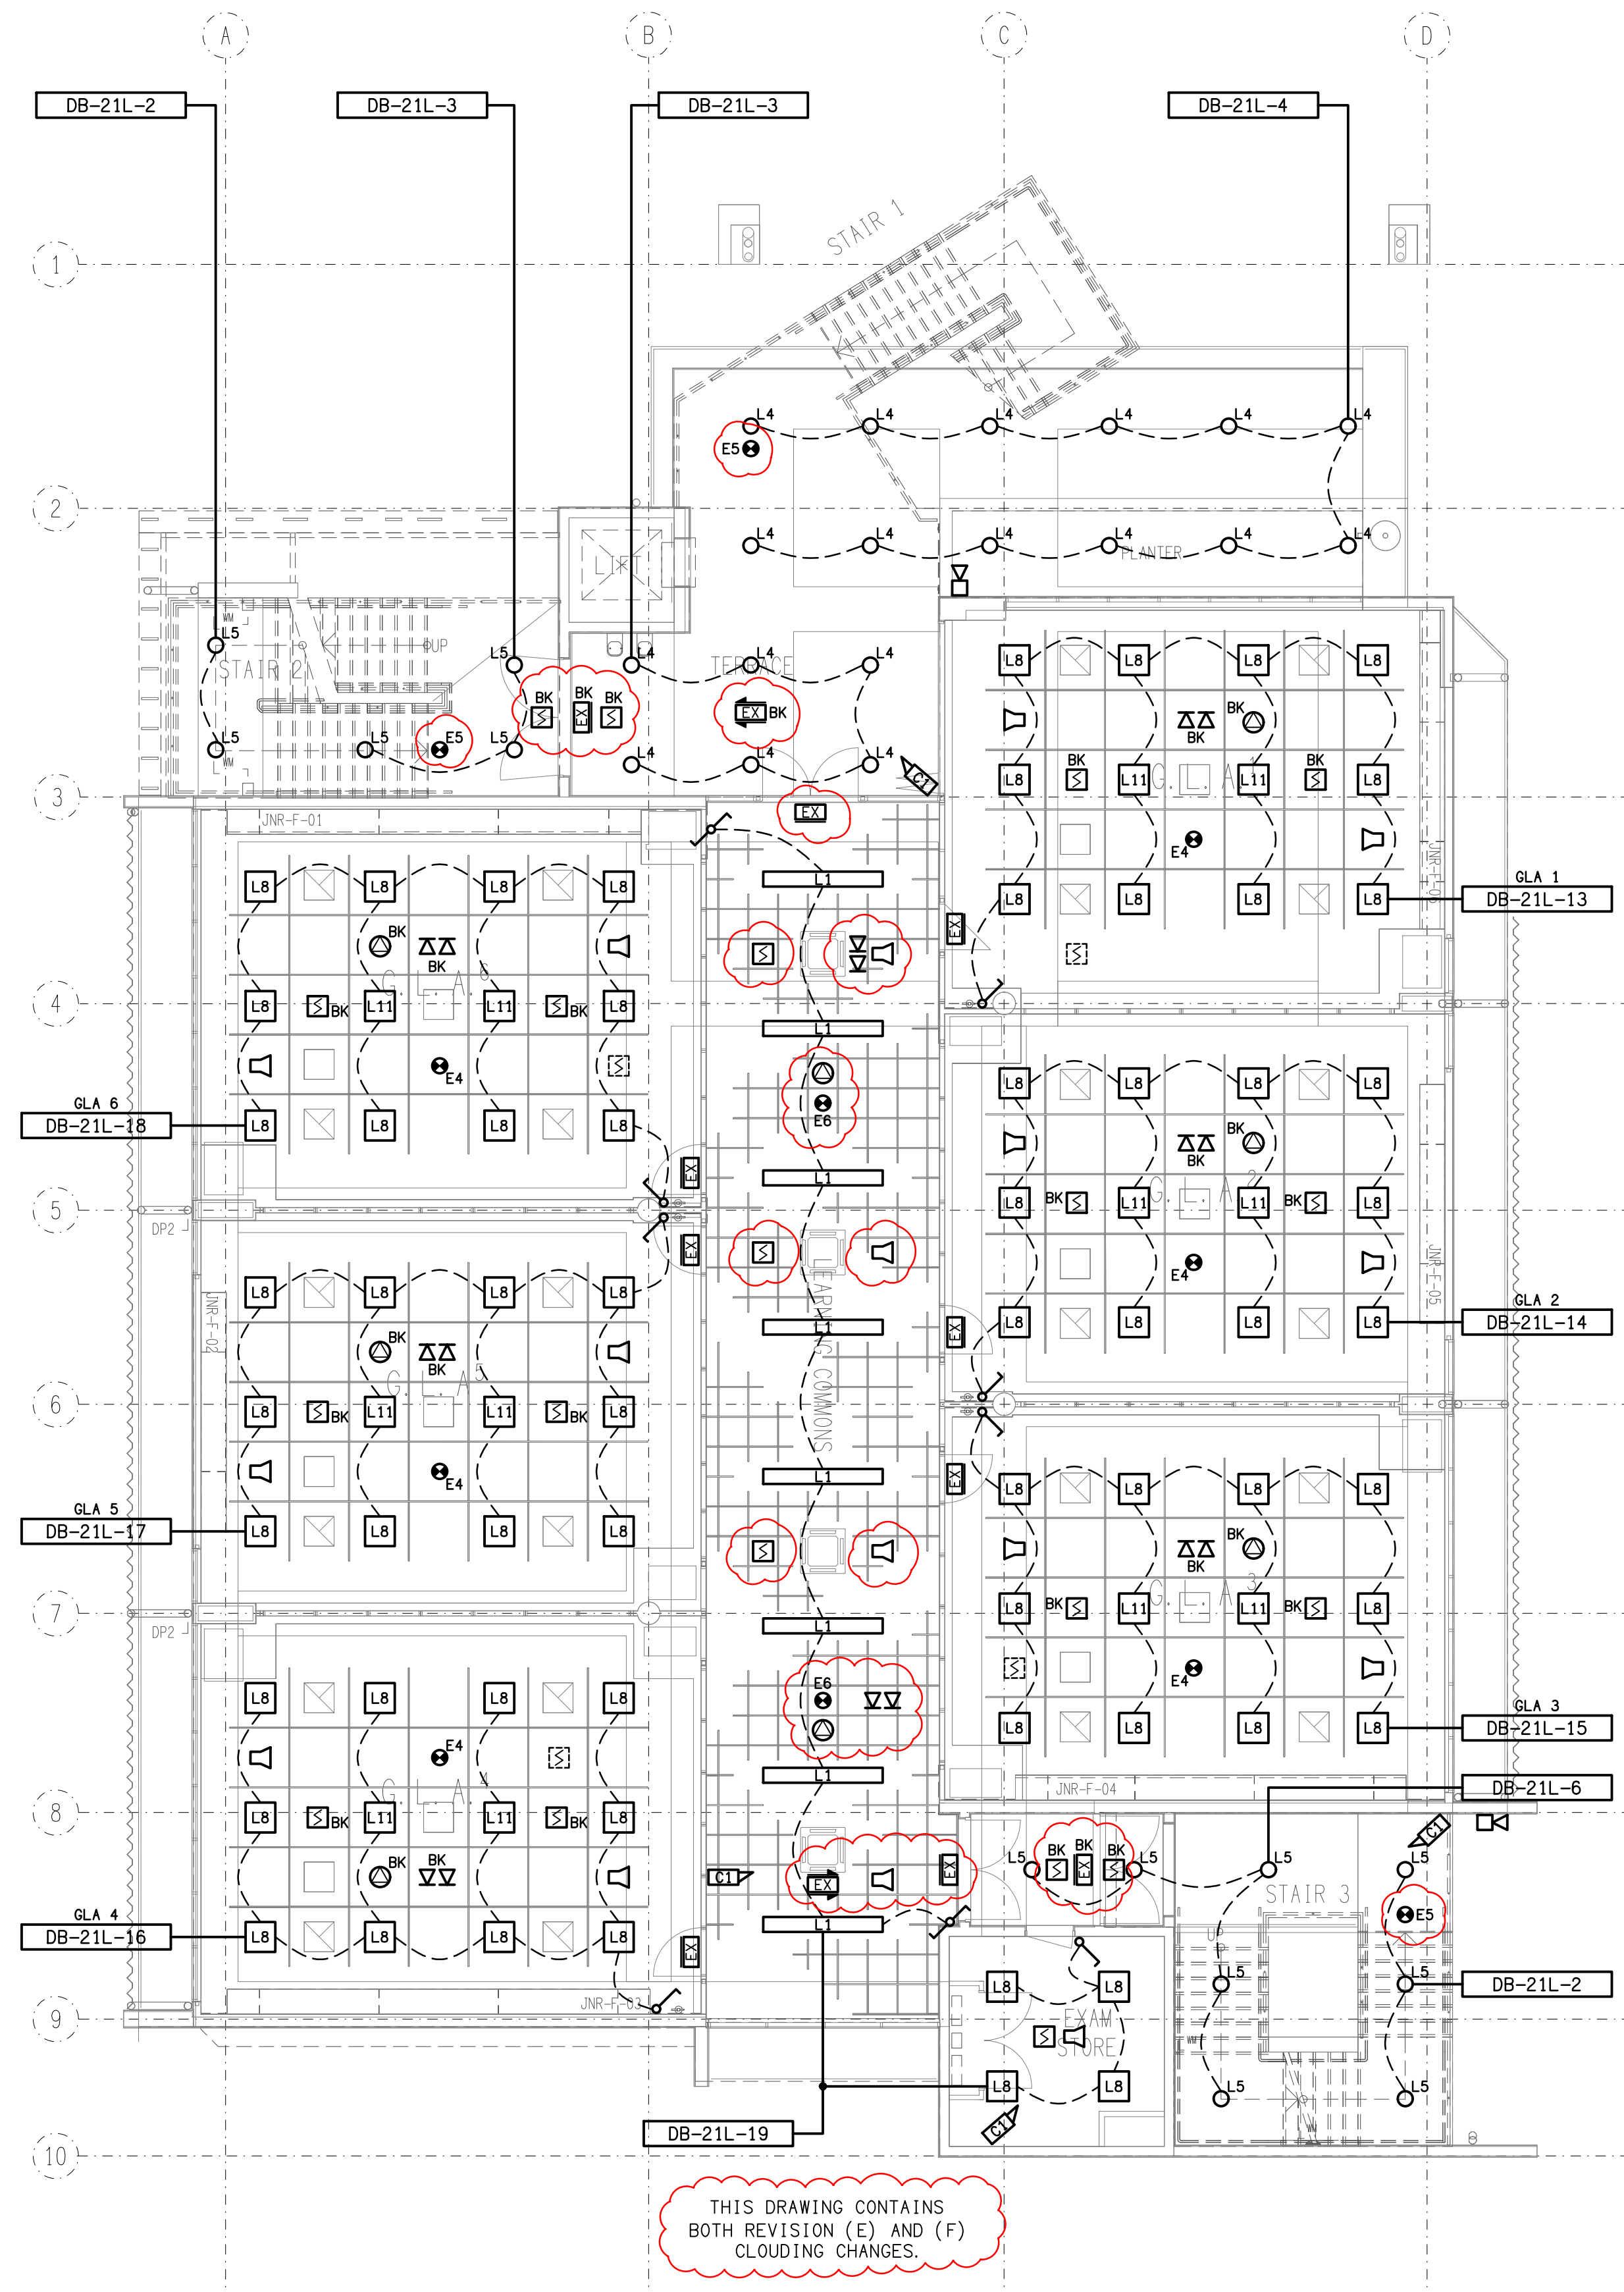

REFLECTED CEILING PLAN
LEVEL 1
SCALE 1: 100

THIS DRAWING CONTAINS BOTH REVISION (E) AND (F) CLOUDING CHANGES.