


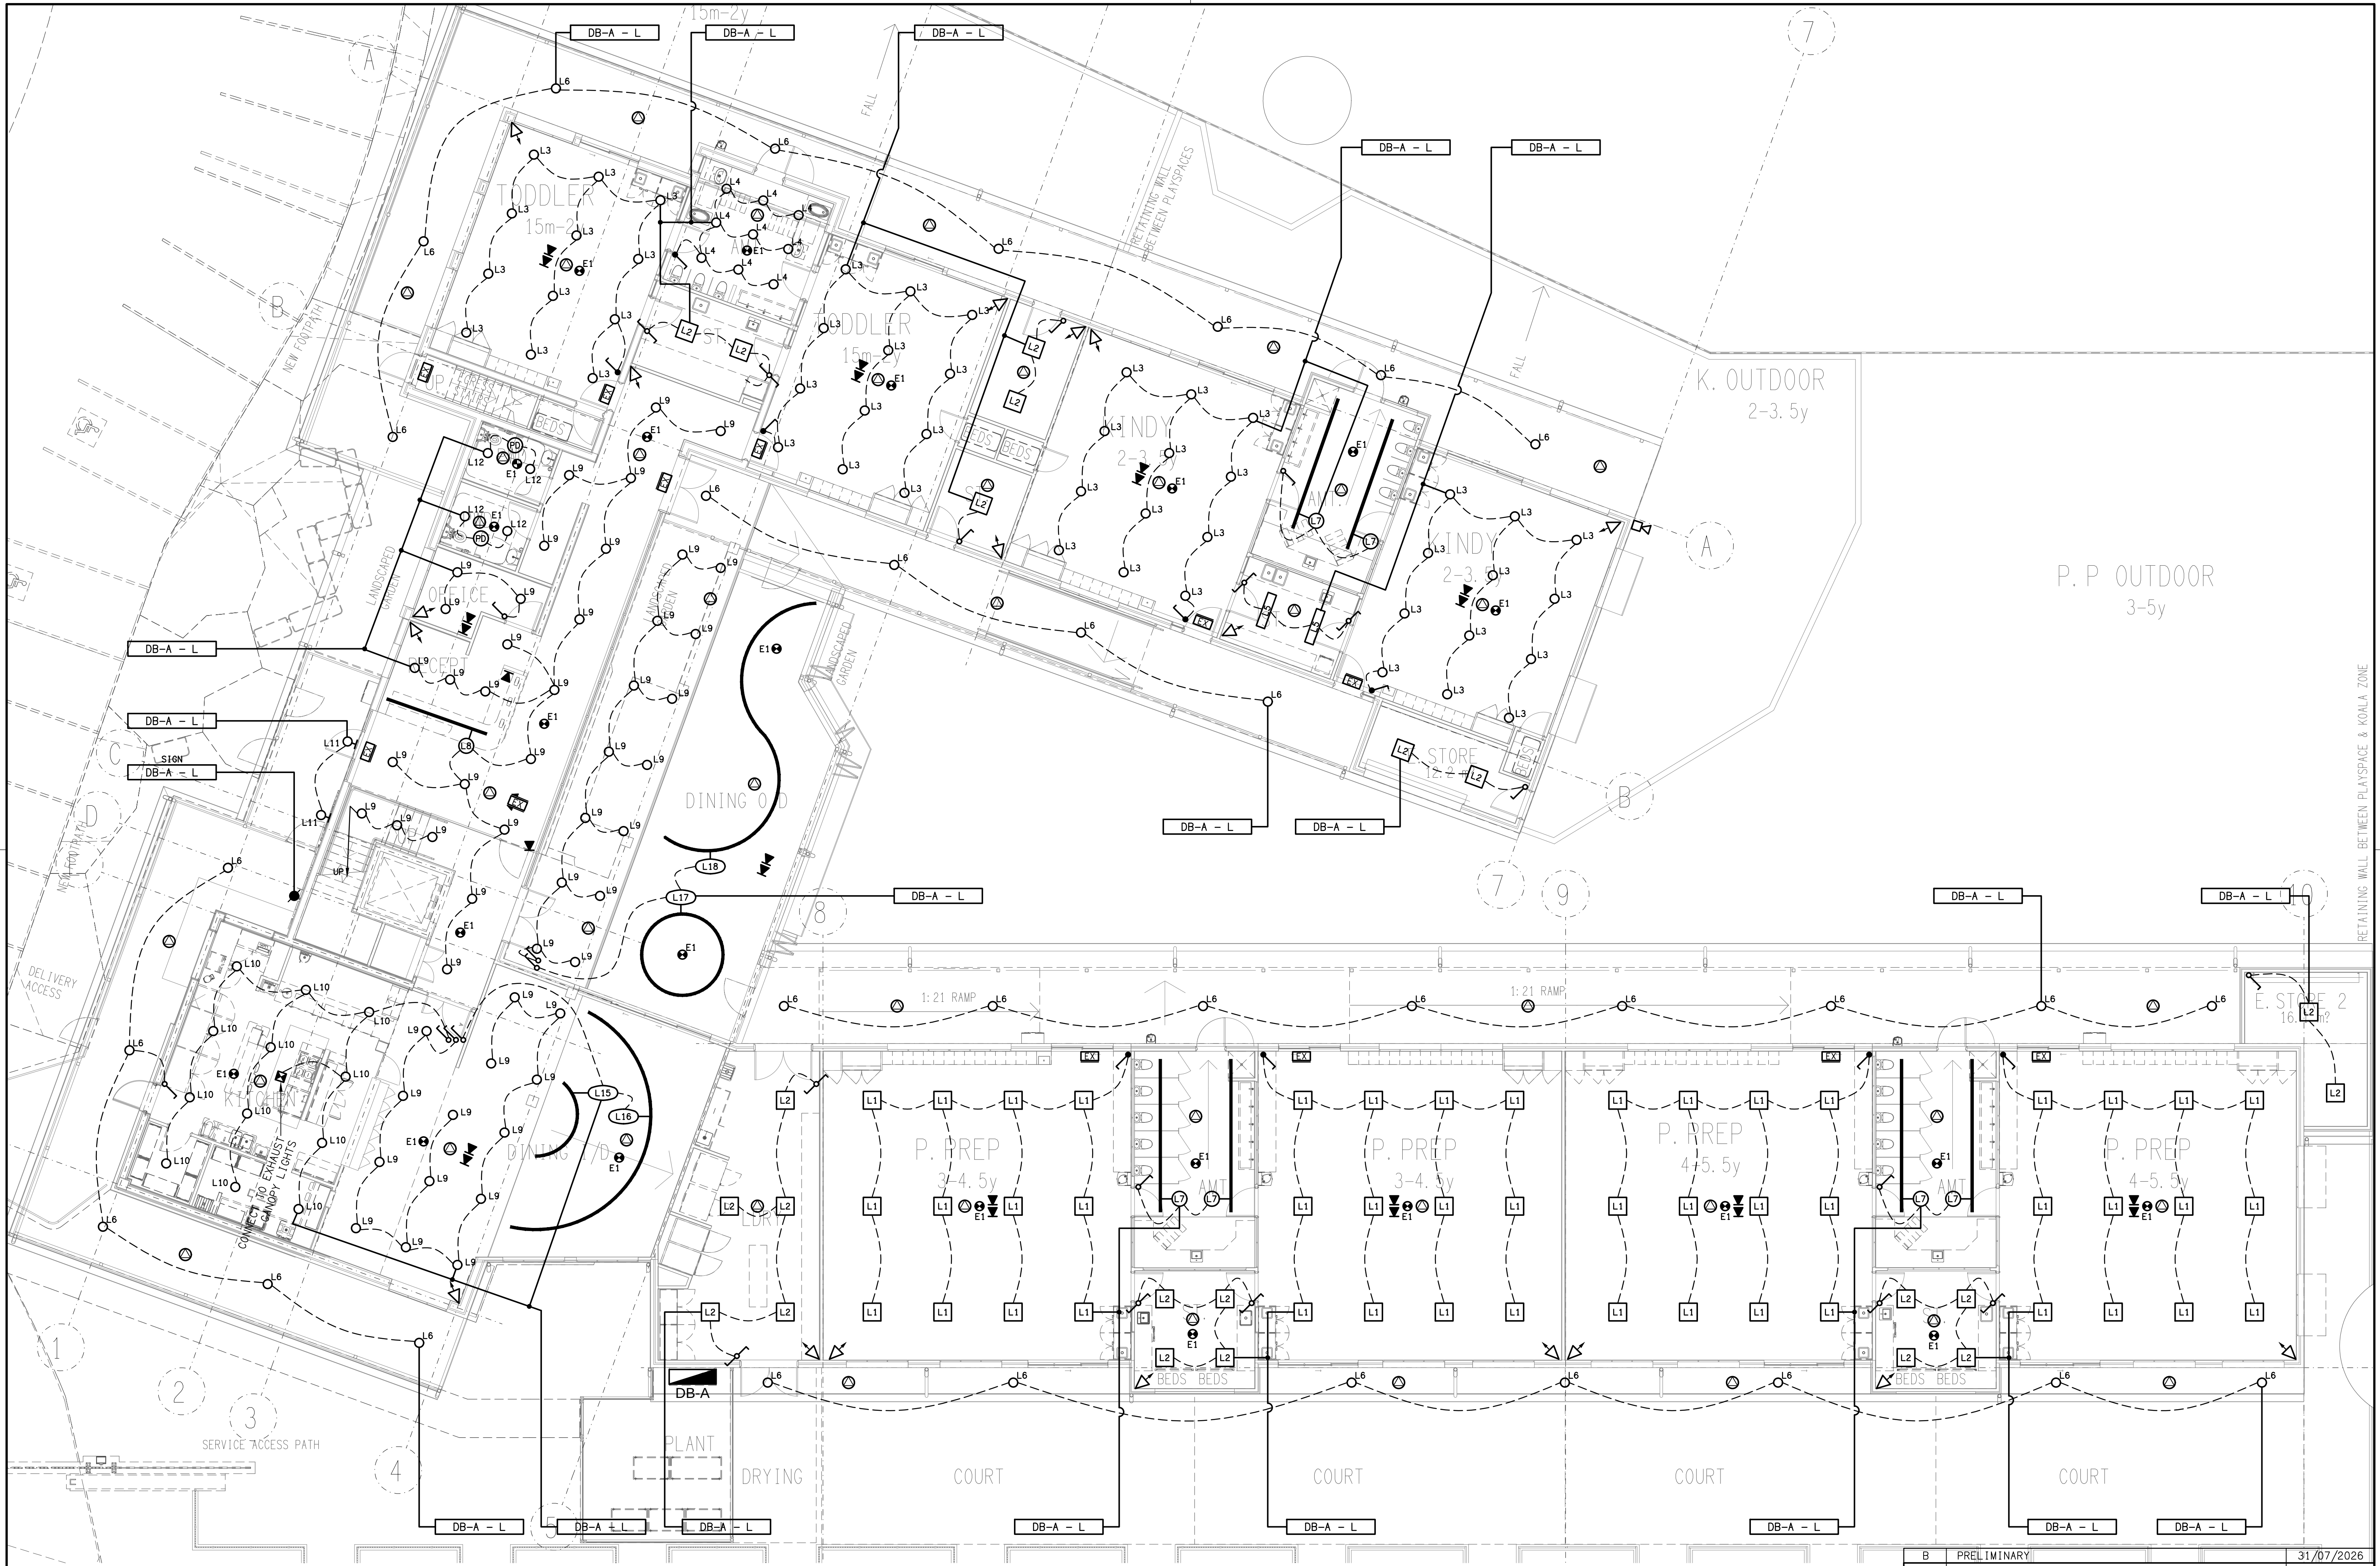

ELECTRICAL DESIGN GROUP BRISBANE
PTY LTD
ACN 092 710 793
TRADING AS:
ELECTRICAL DESIGN GROUP

THE COPYRIGHT OF THIS DRAWING
REMAINS THE PROPERTY OF THE
ELECTRICAL DESIGN GROUP.
USE FIGURED DIMENSIONS
IN PREFERENCE TO SCALE.
ALL DIMENSIONS TO BE
VERIFIED ONSITE.

ELECTRICAL DESIGN GROUP
ELECTRICAL BUILDING SERVICES CONSULTANTS
BRISBANE GOLD COAST

P.O. Box 15, Sherwood Q. 4075
Phone: (07) 3278 4375
Email: brisbane@edg.net.au
Web: www.edg.net.au

PROJECT:
**ORMISTON COLLEGE
EARLY LEARNING CENTRE**

168 DUNDAS STREET WEST, ORMISTON

REV.	DESCRIPTION	DATE
B	PRELIMINARY	31/07/2026

DRAWING:
**ELECTRICAL SERVICES
GROUND LEVEL REFLECTED CEILING PLAN**

SCALE:	AT	PROJECT NO:	DRAWING NO:	REVISION:
1:100	A1	C3514a	E05	B