



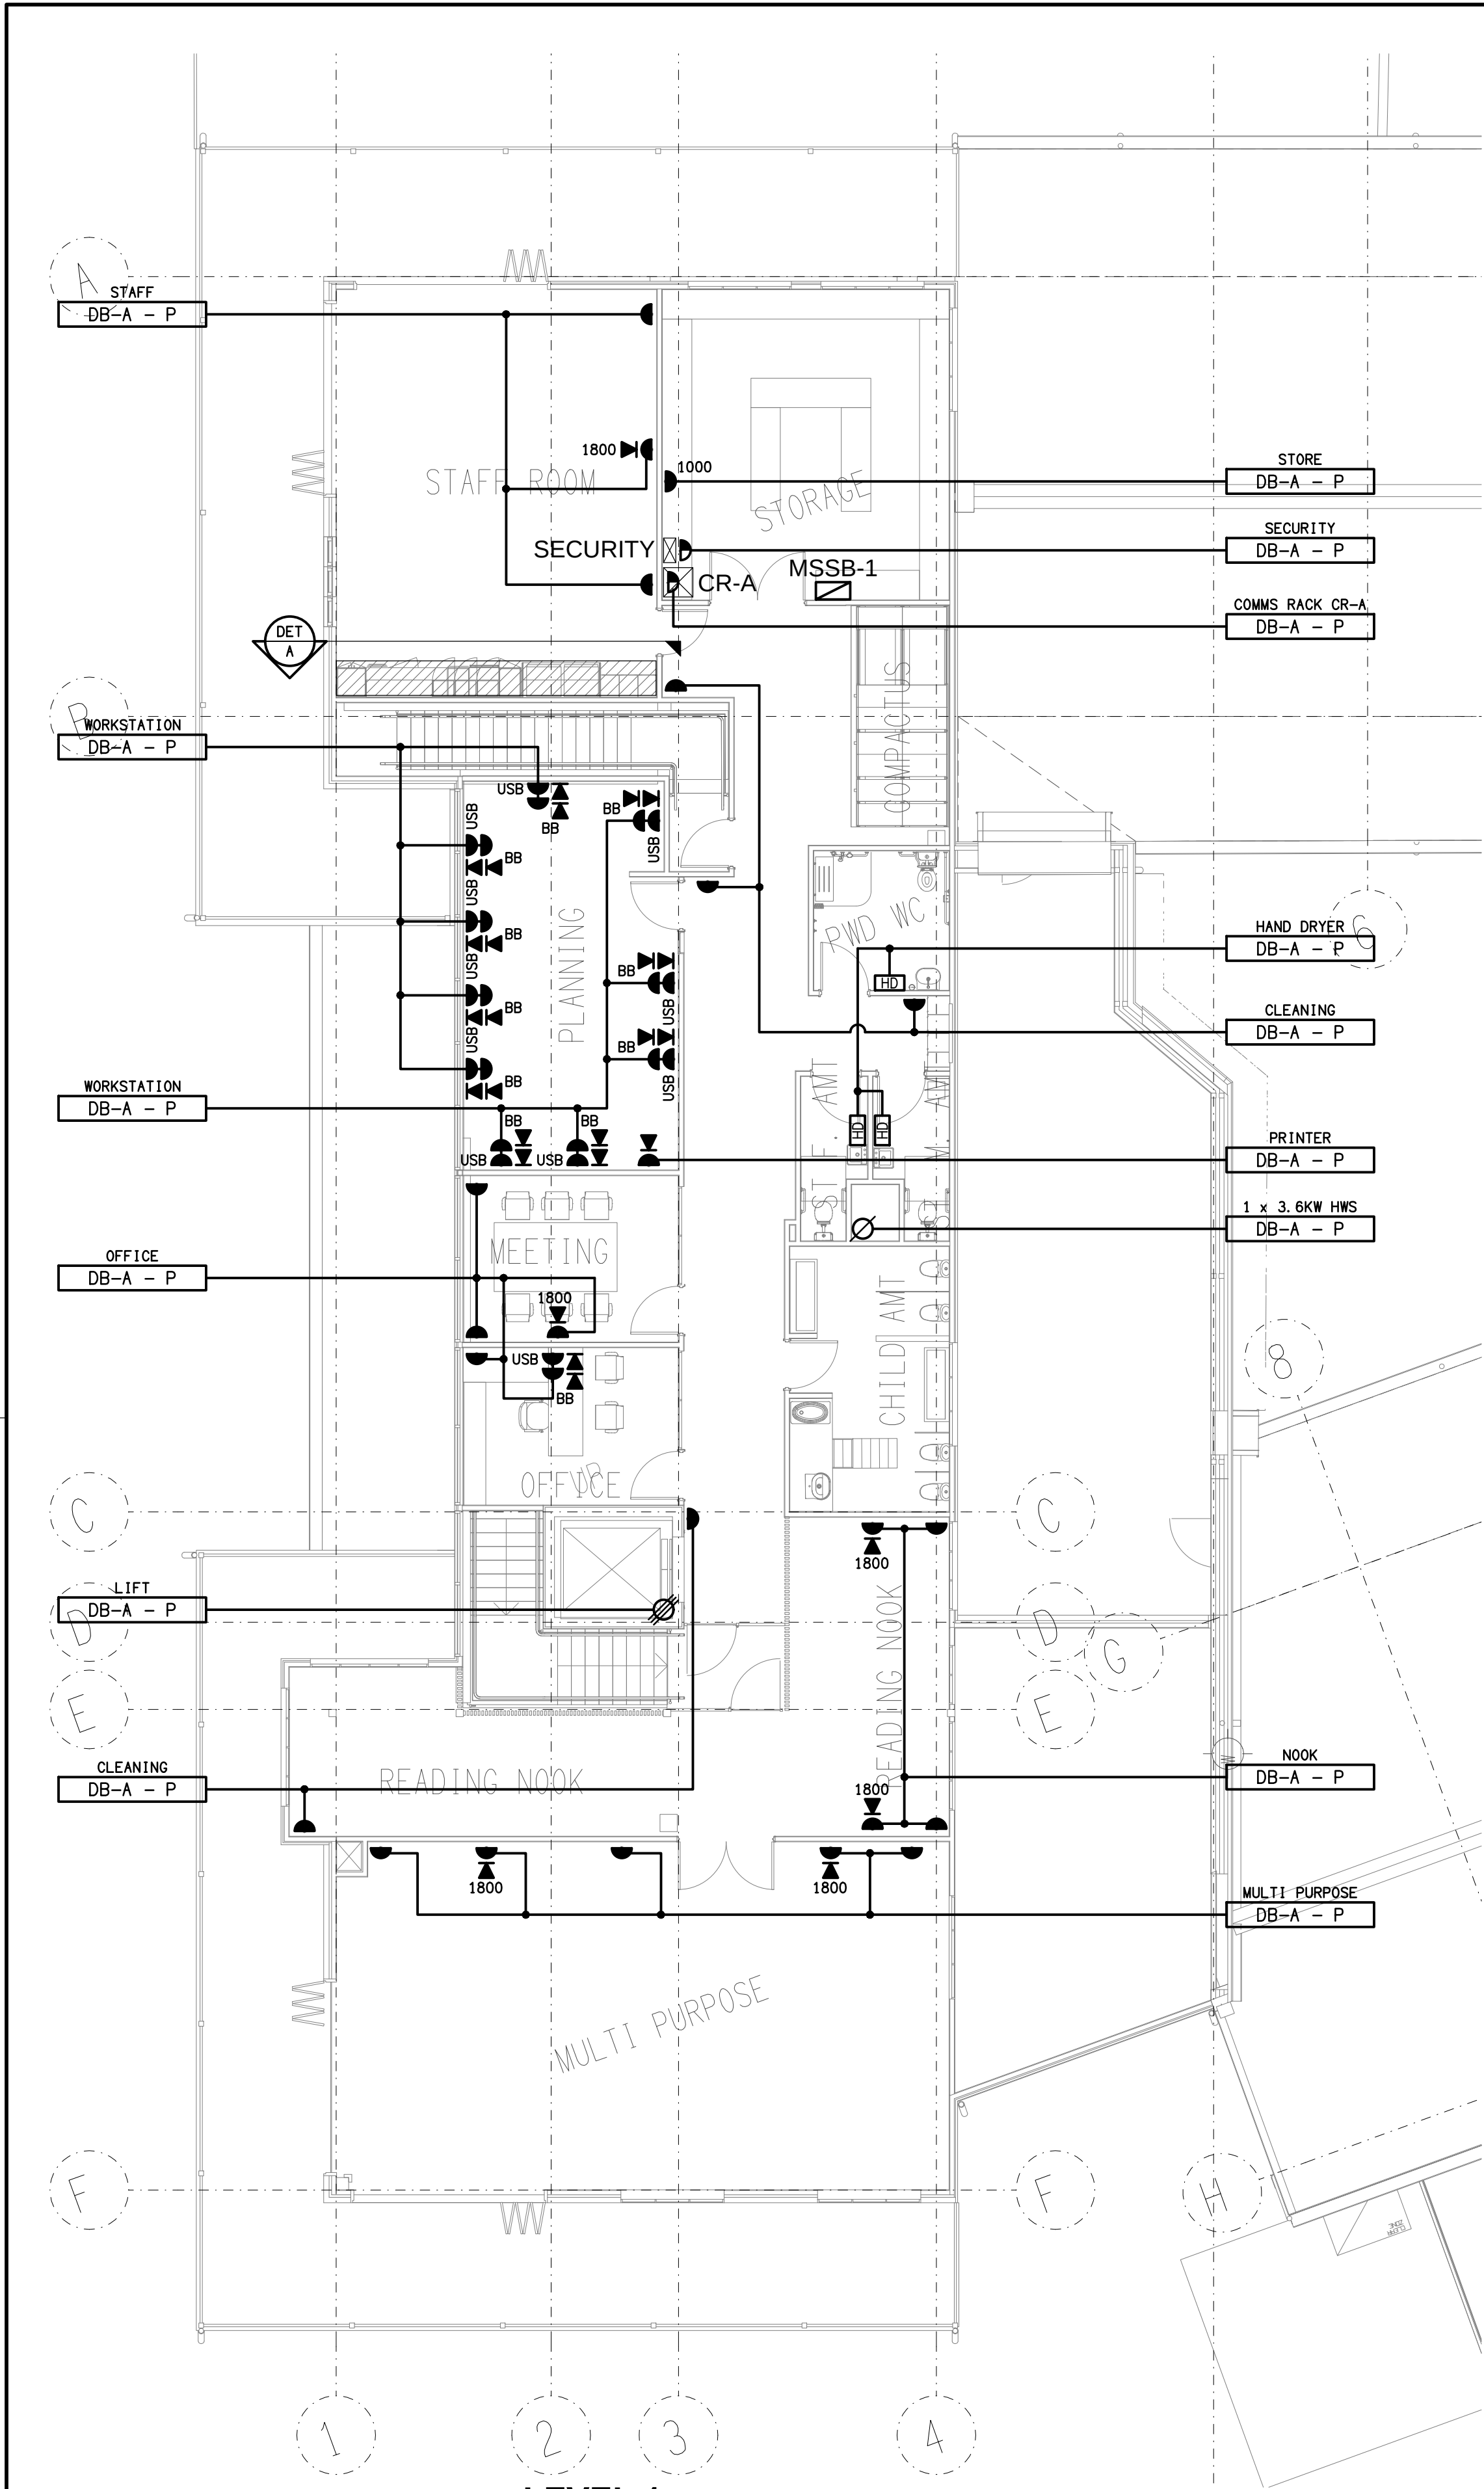

LEVEL 1
FLOOR PLAN
SCALE 1: 100

ELECTRICAL LAYOUT PENDING RECEIPT OF ELEVATION

DETAIL A
STAFF KITCHENETTE ELEVATION
SCALE 1: 50

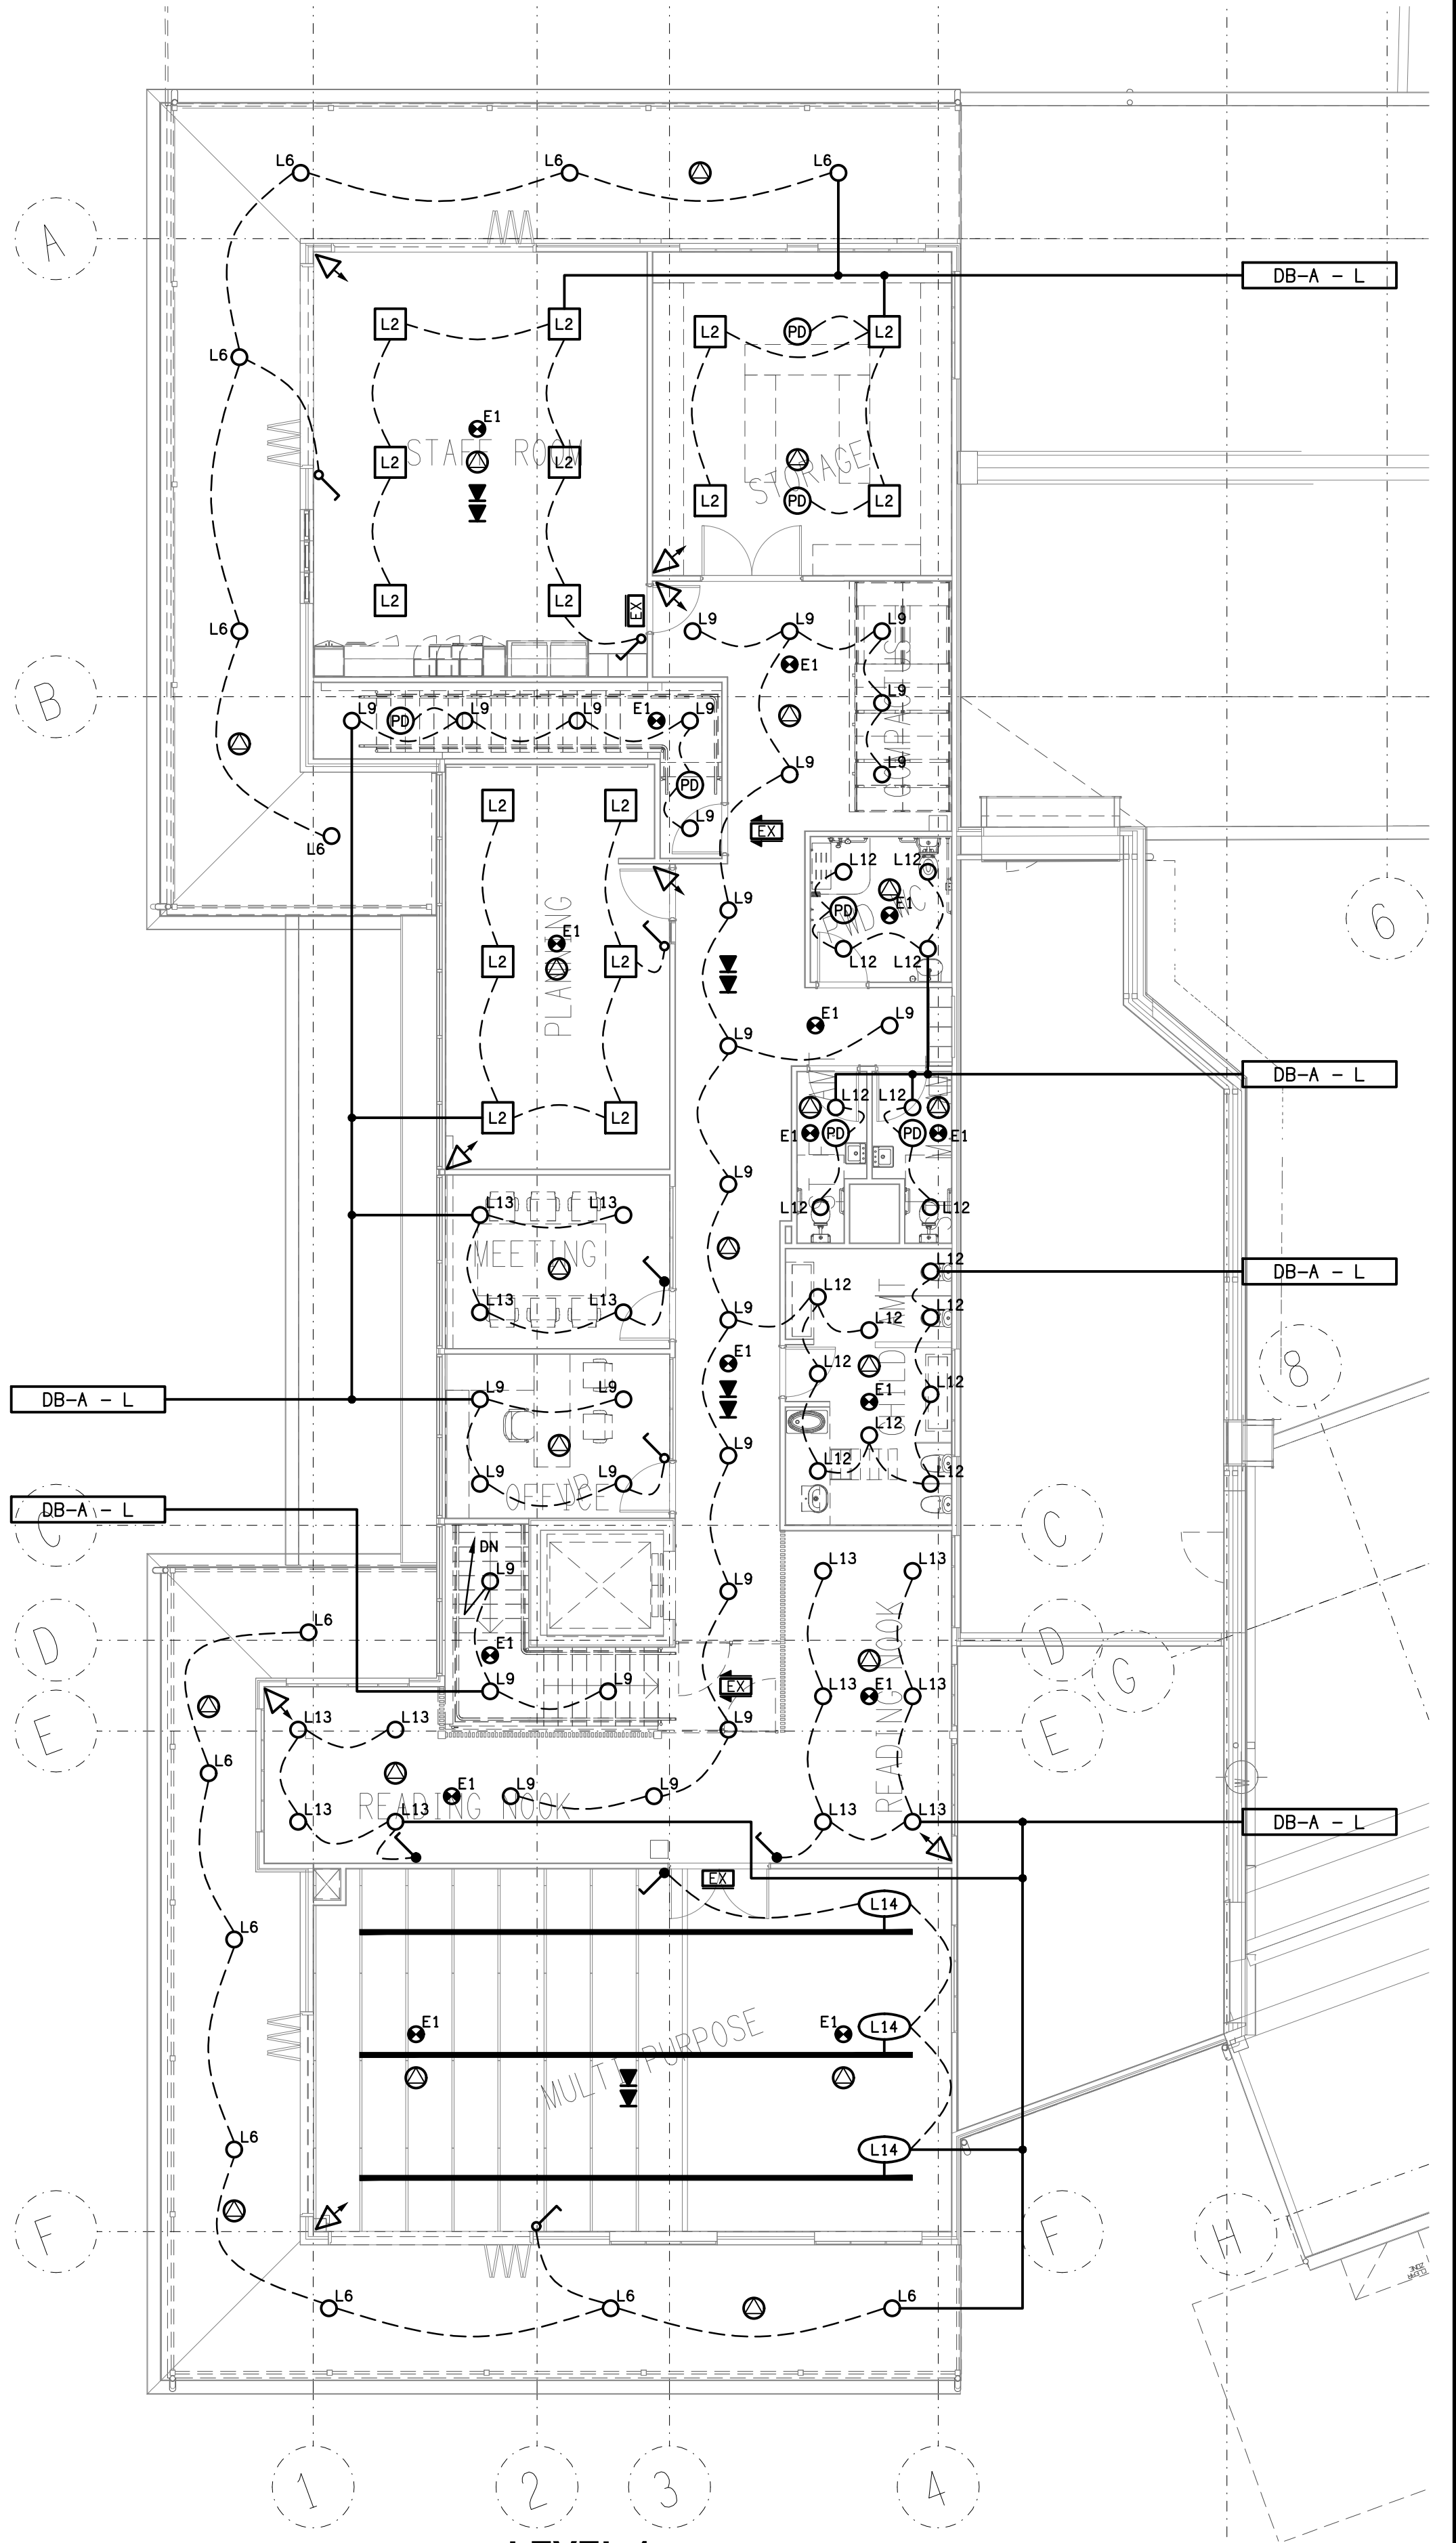

LEVEL 1
REFLECTED CEILING PLAN
SCALE 1: 100