
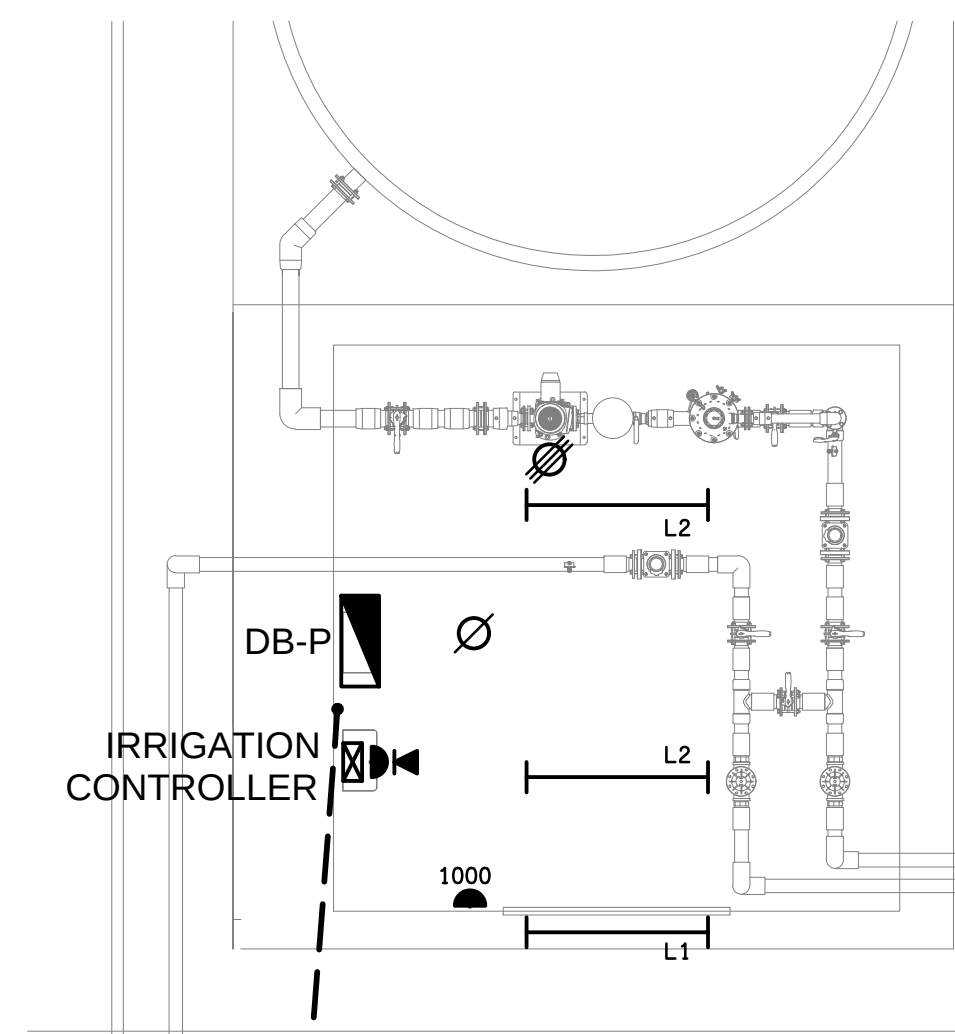


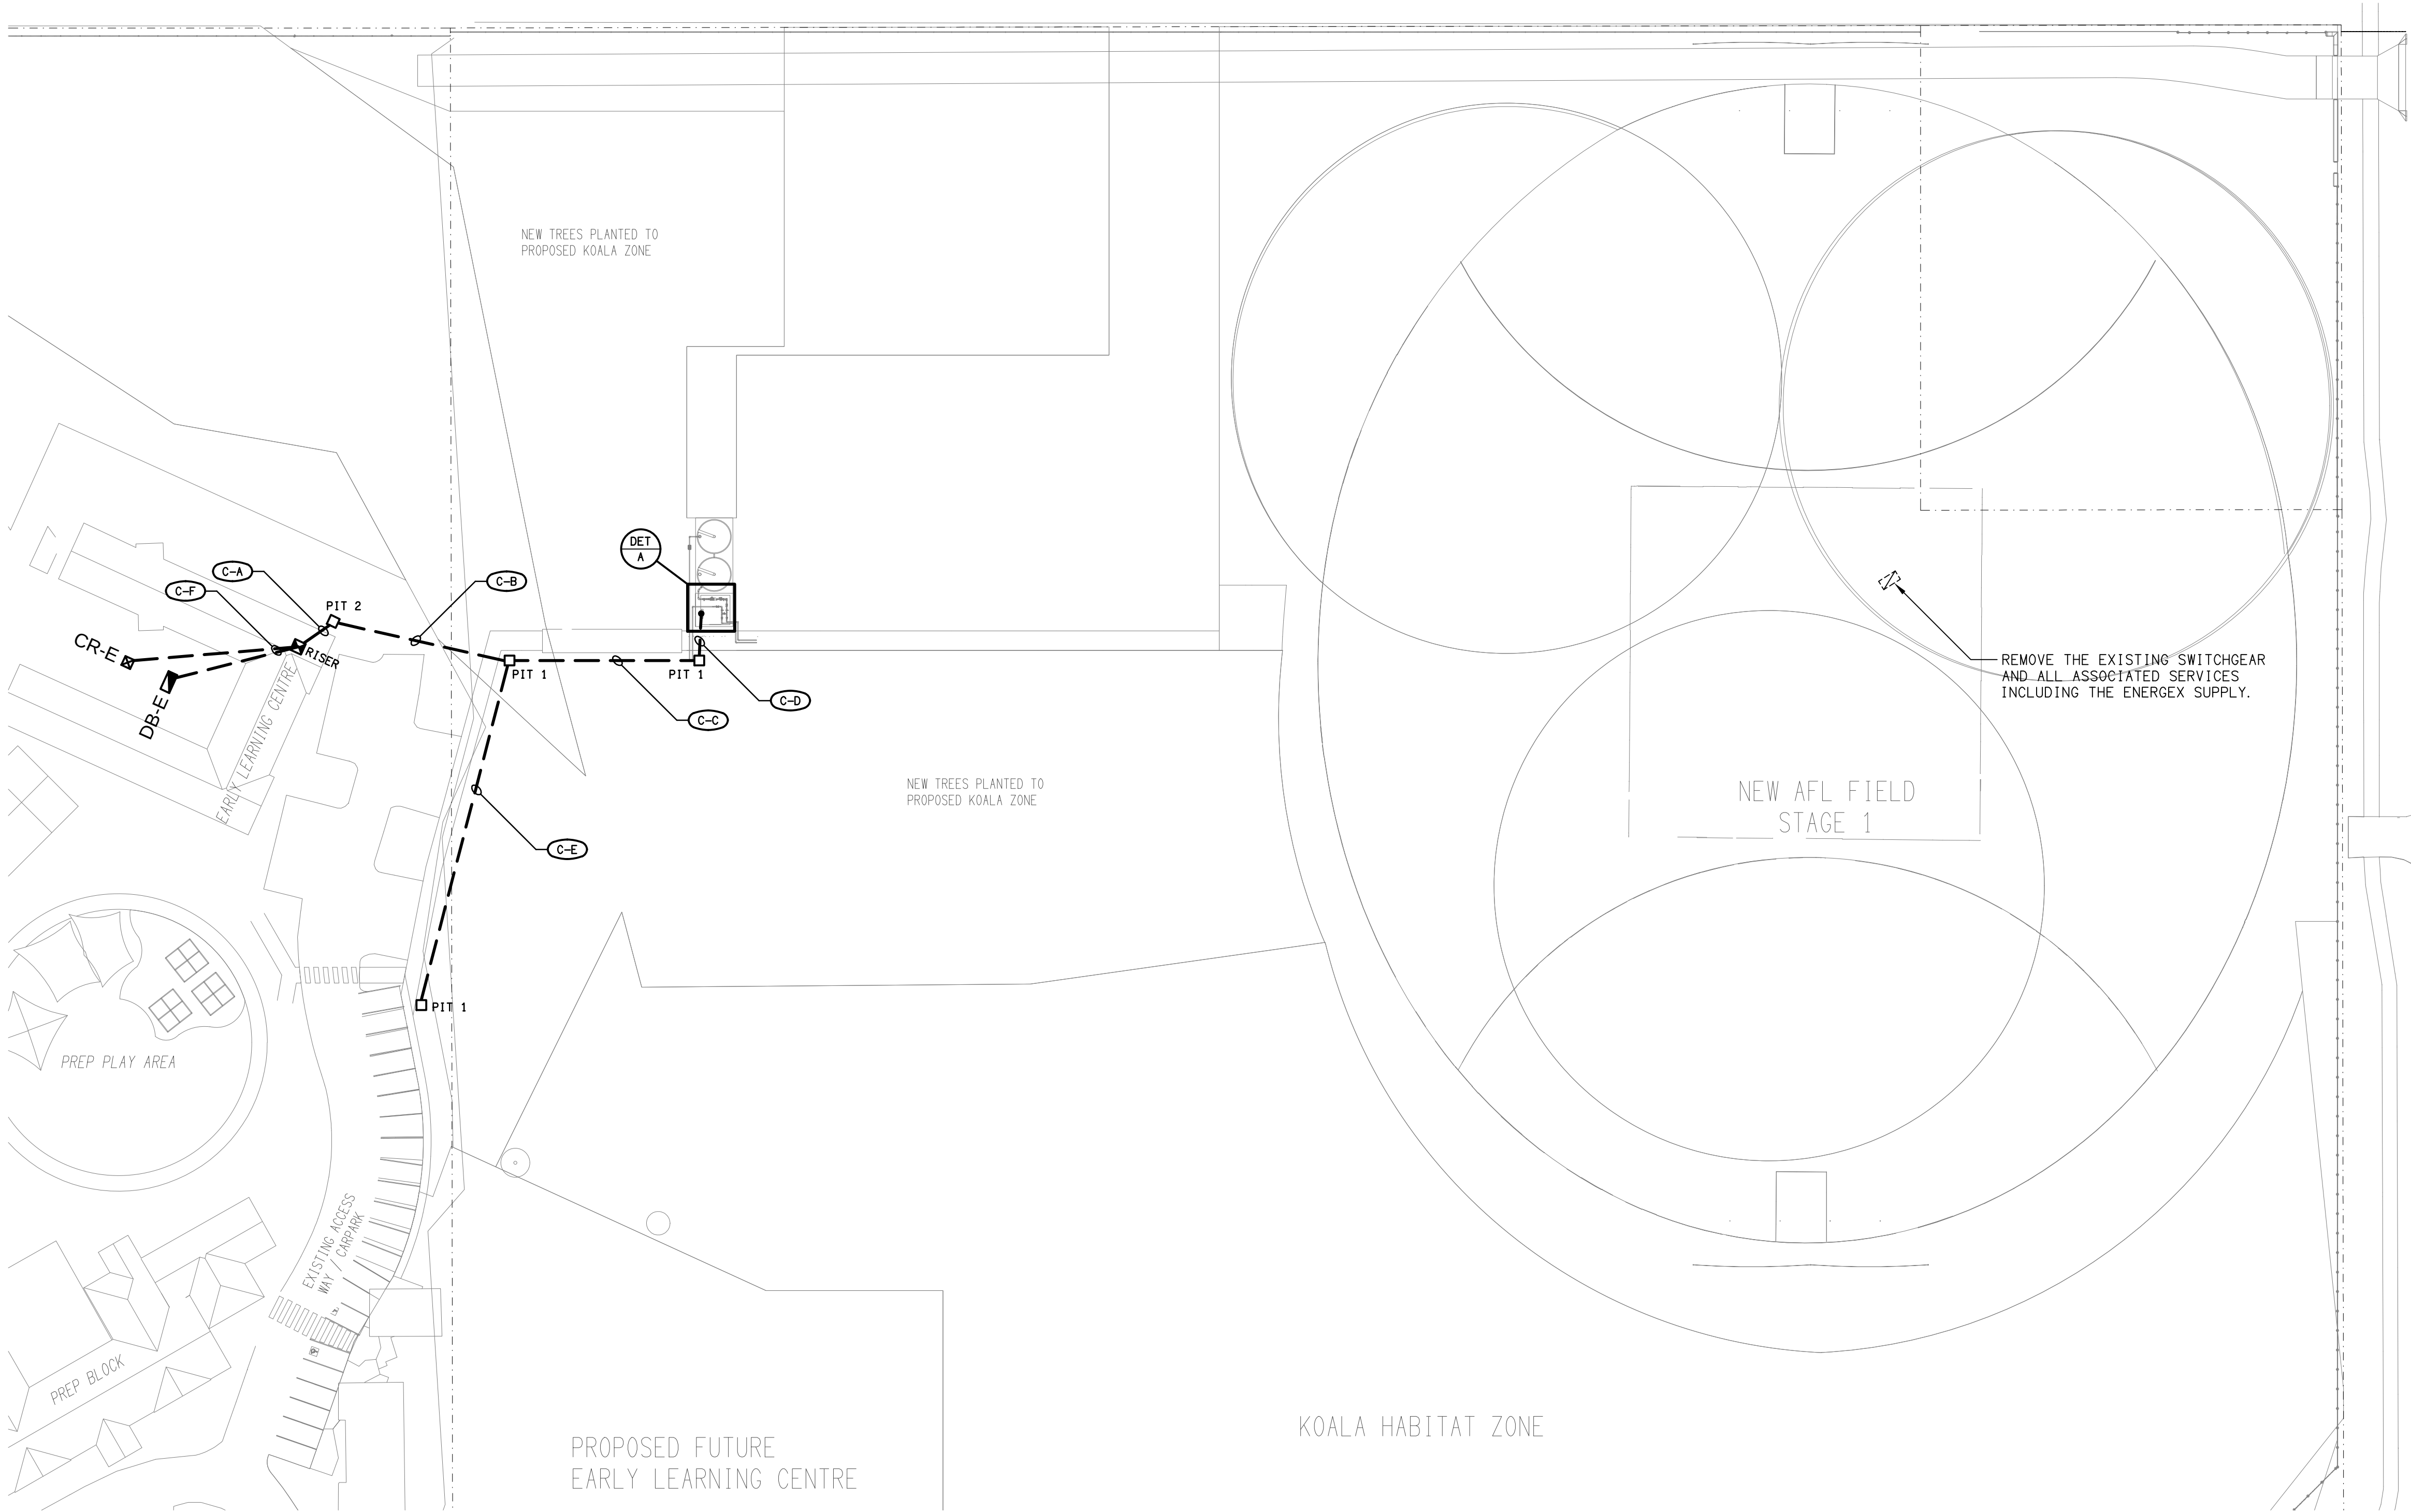

DETAIL A
PUMP SHED PLAN
SCALE 1:50

PART SITE PLAN
MEADOWLANDS JUNIOR SPORTS PRECINCT
SCALE 1:500