




**BURGER URGE**

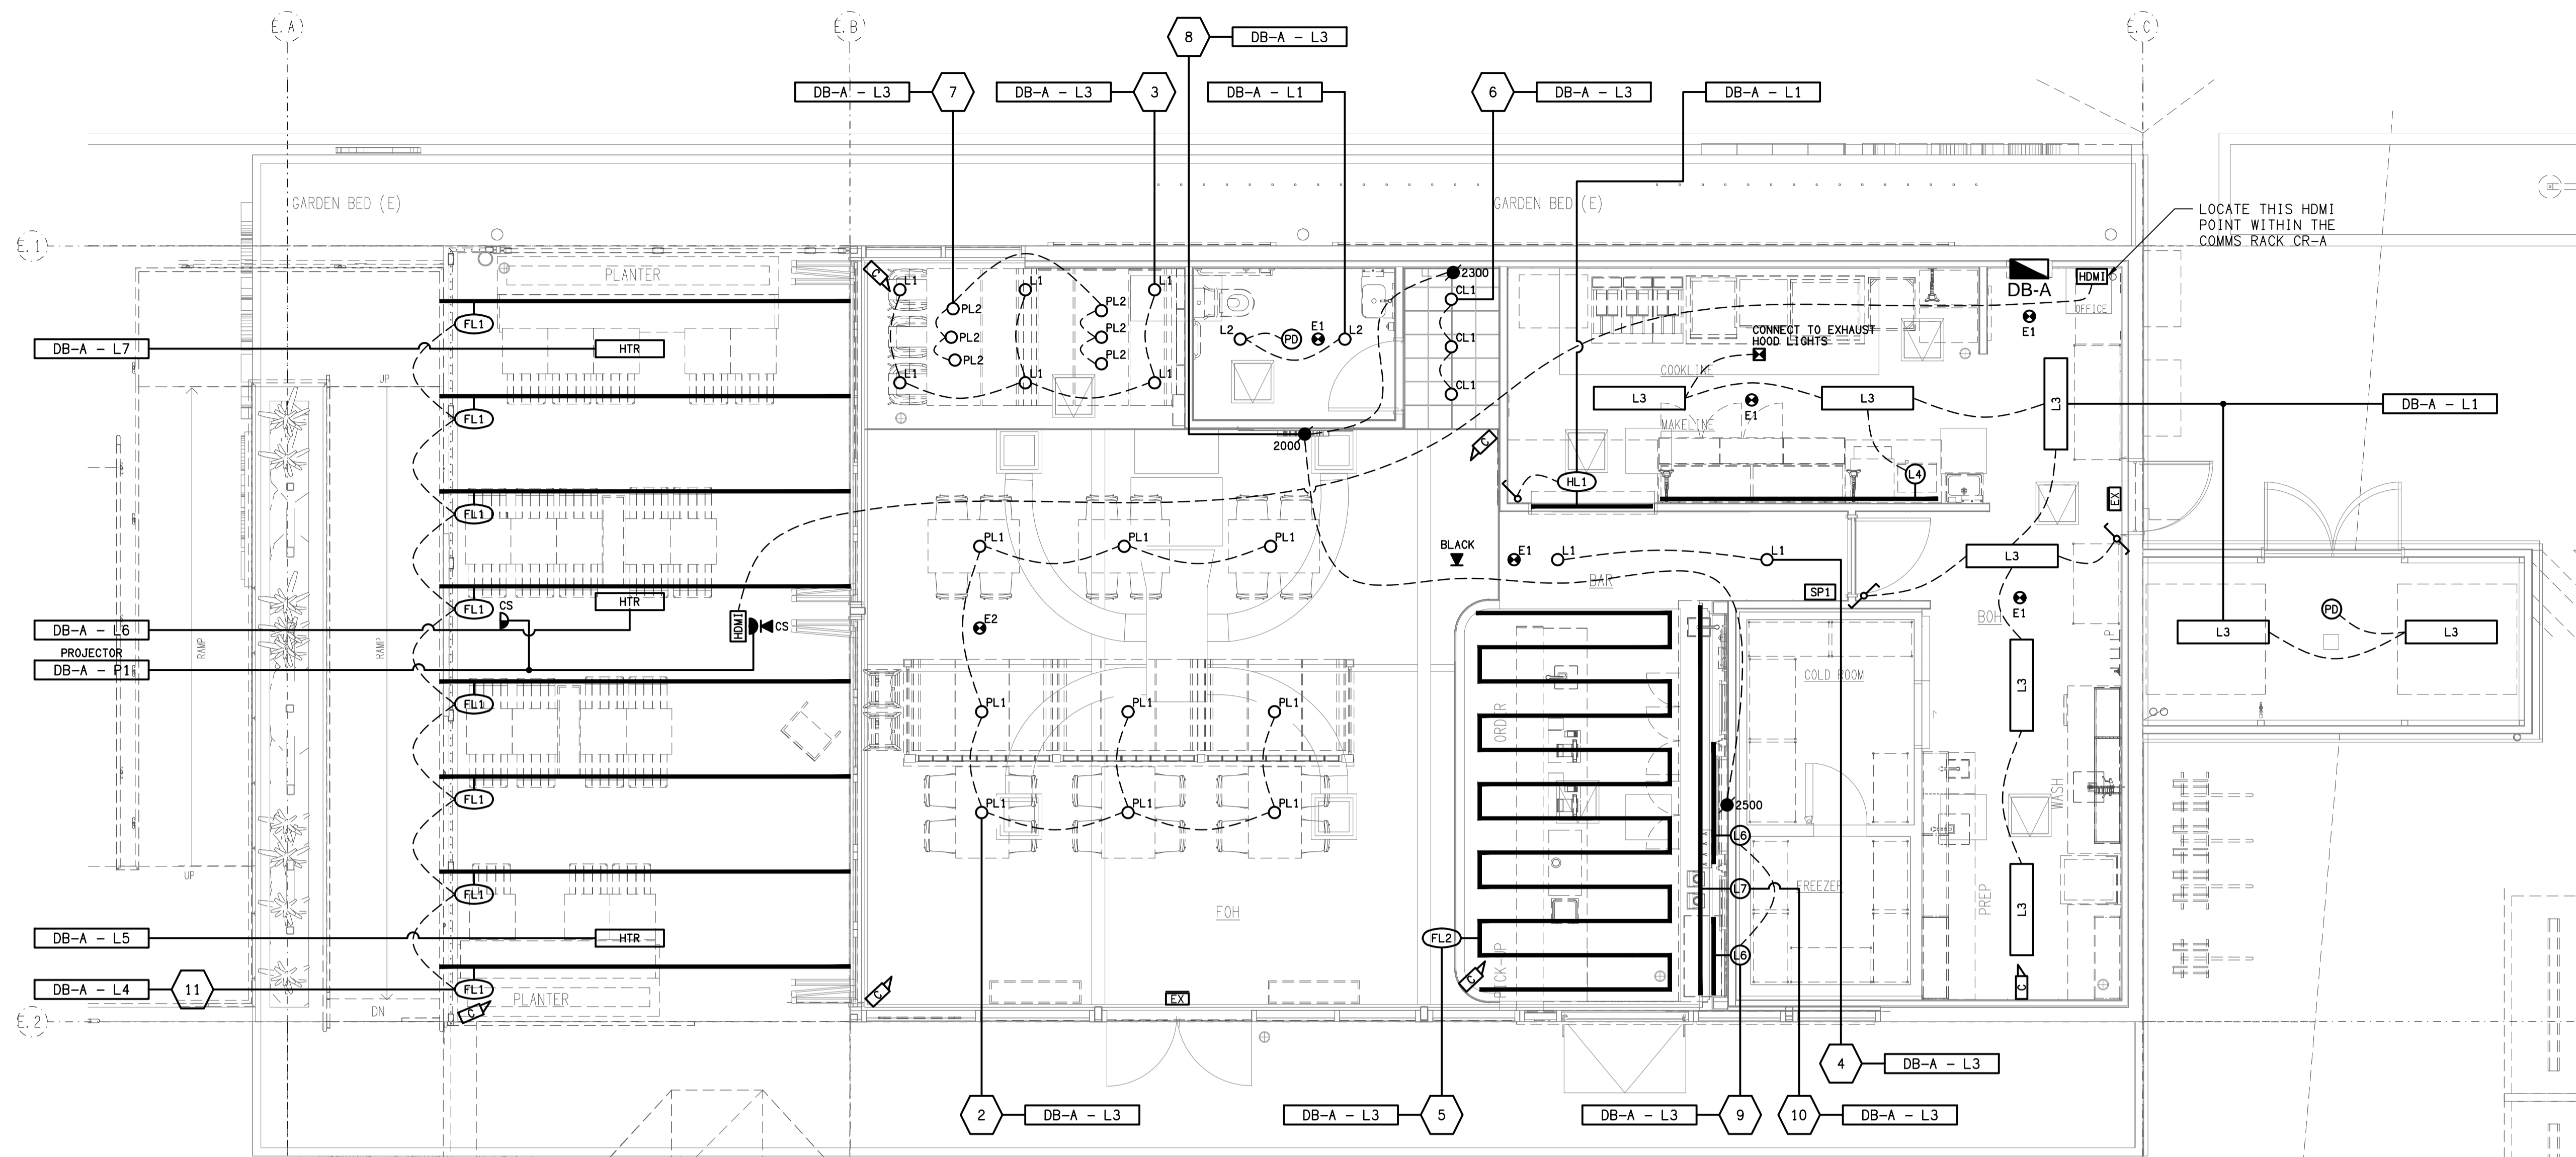


**REFLECTED CEILING PLAN**  
BURGER URGE TENANCY  
SCALE 1:50

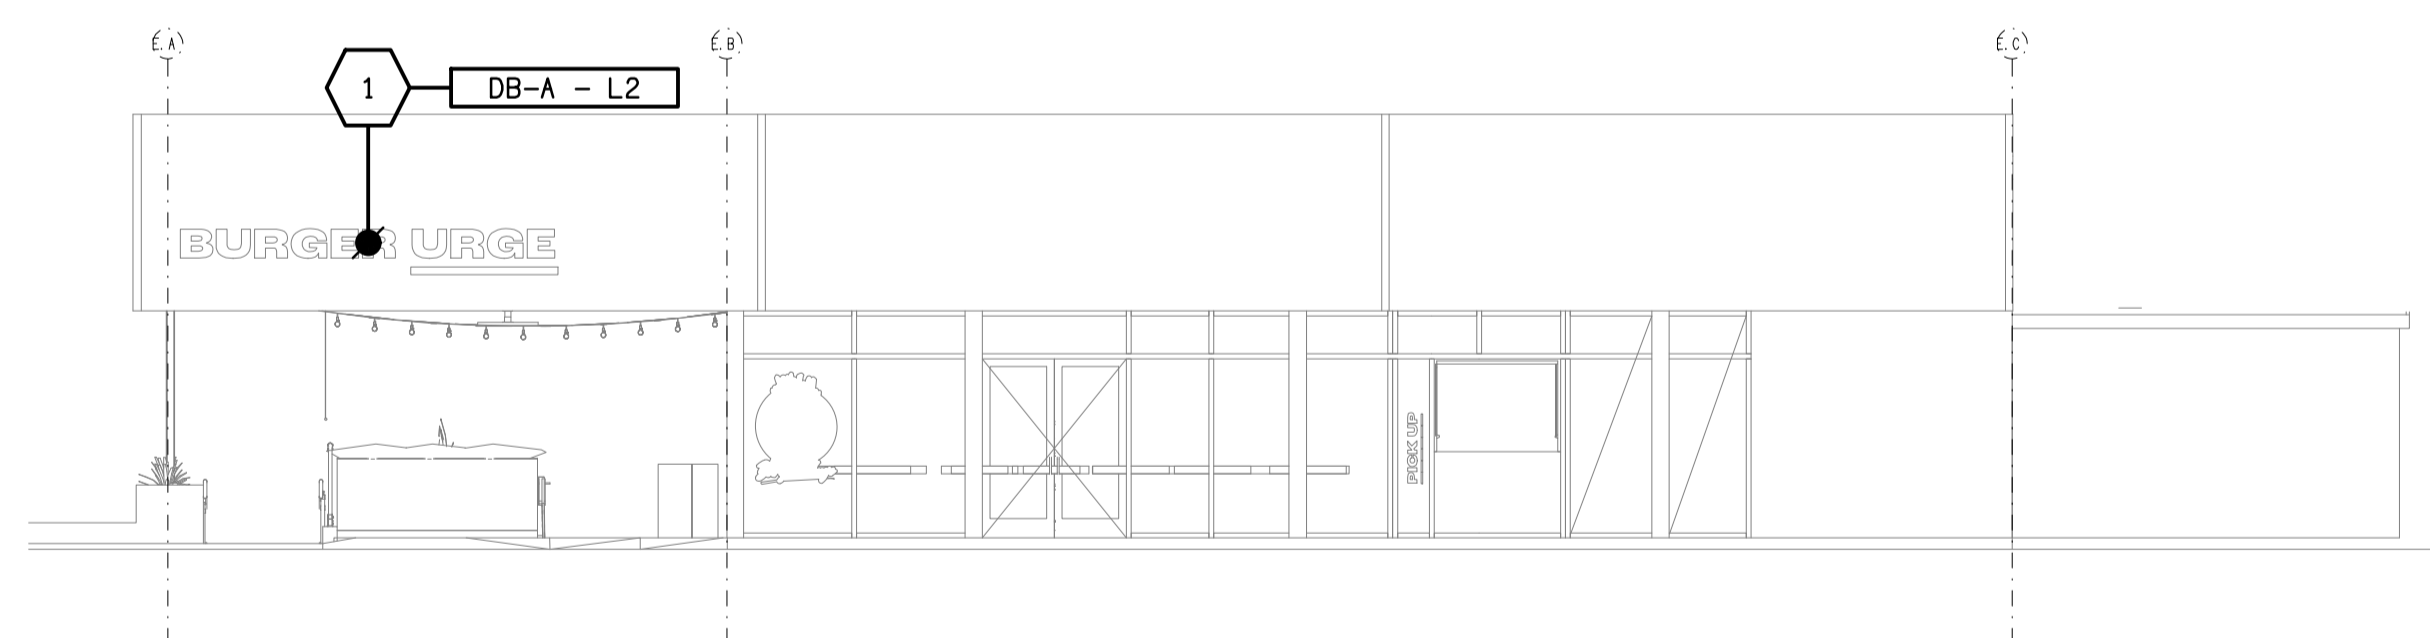


**SOUTH**  
EXTERNAL BUILDING ELEVATION  
SCALE 1:100

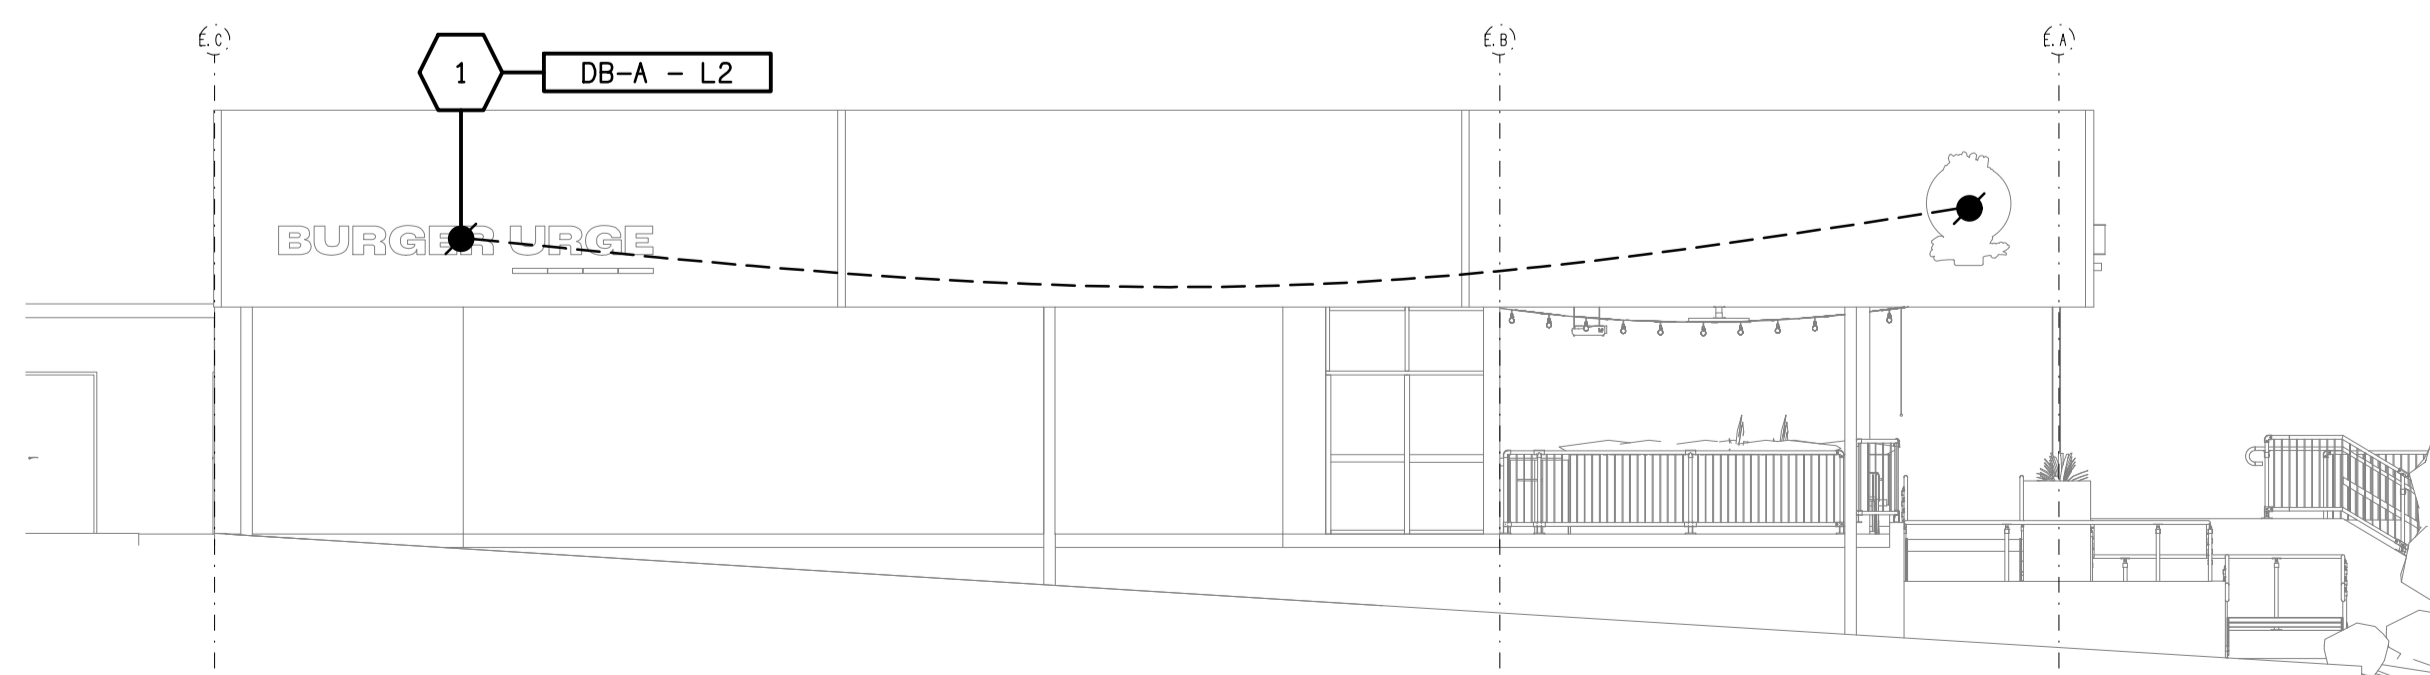

**NORTH**  
EXTERNAL BUILDING ELEVATION  
SCALE 1:100

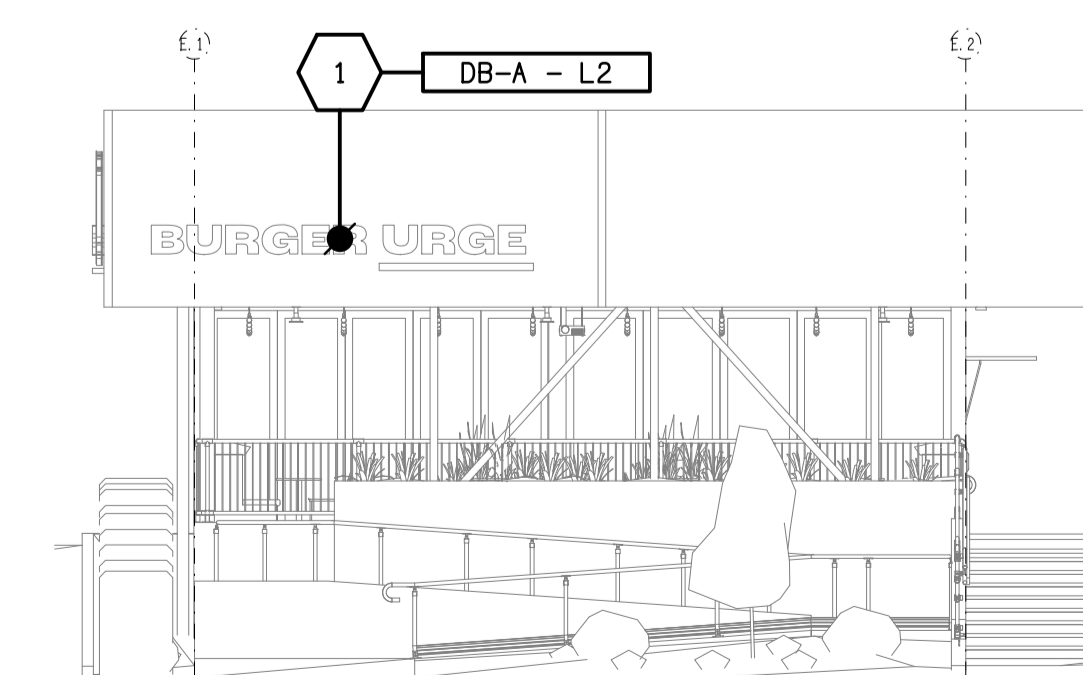

**WEST**  
EXTERNAL BUILDING ELEVATION  
SCALE 1:100

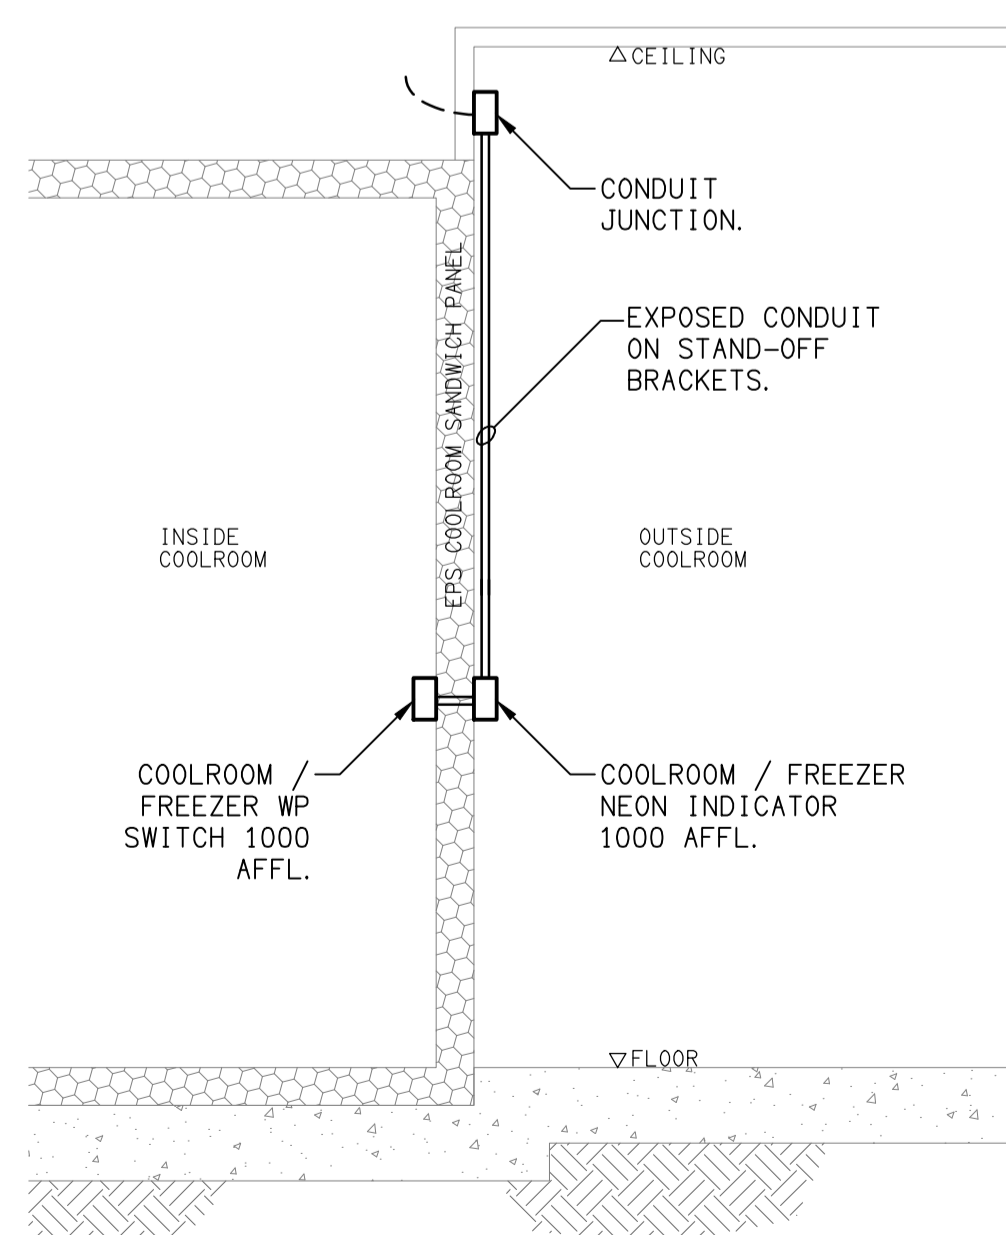

**DETAIL A**  
COOLROOM / FREEZER LIGHTING CONTROL  
NOT TO SCALE

B	PRELIMINARY	27/06/2025
REV:	DESCRIPTION:	DATE:

**ELECTRICAL DESIGN GROUP**  
ELECTRICAL BUILDING SERVICES CONSULTANTS

BRISBANE: P.O. Box 15 Sherwood Qld 4075  
Phone: (07) 3278 4375  
Email: brisbane@edg.net.au  
Web: www.edg.net.au

ELECTRICAL DESIGN GROUP BRISBANE PTY LTD  
ACN 092 710 793

TRADING AS:  
ELECTRICAL DESIGN GROUP

PROJECT:  
**BURGER URGE WILSONTON**

SITE ADDRESS:  
CORNER BRIDGE STREET &  
RICHMOND DRIVE, WILSONTON,  
QUEENSLAND

SCALE: 1:50 SHEET SIZE: A1  
AT

DRAWING TITLE:  
**ELECTRICAL SERVICES REFLECTED CEILING PLAN**

PROJECT NO. DRAWING NO. REVISION:  
**C3520a E04 B**