

BURGER URGE

NOTE

ALL ELECTRICAL PENETRATIONS THROUGH THE ROOF SHEETING ARE TO BE IN LINE WITH THE STRUCTURAL OR MECHANICAL SERVICES PENETRATIONS TO AVOID DEDICATED FLASHINGS FOR THE ELECTRICAL SERVICES.

NOTE:


ALL MECHANICAL SERVICES ROOF OUTLET LOCATIONS ARE TO BE CONFIRMED ON SITE WITH THE MECHANICAL SUBCONTRACTOR.

- AC
- DB-A - P40
- EXHAUST FAN
- DB-A - P39
- TOILET EXHAUST
- DB-A - P38
- COLDROOM COMPRESSOR
- DB-A - P37
- COLDROOM COMPRESSOR
- DB-A - P36

MECHANICAL PLANT LAYOUT AND THE ASSOCIATED ELECTRICAL OUTLET LOCATIONS STILL TO BE CONFIRMED.

ROOF PLAN

BURGER URGE TENANCY
SCALE 1:100

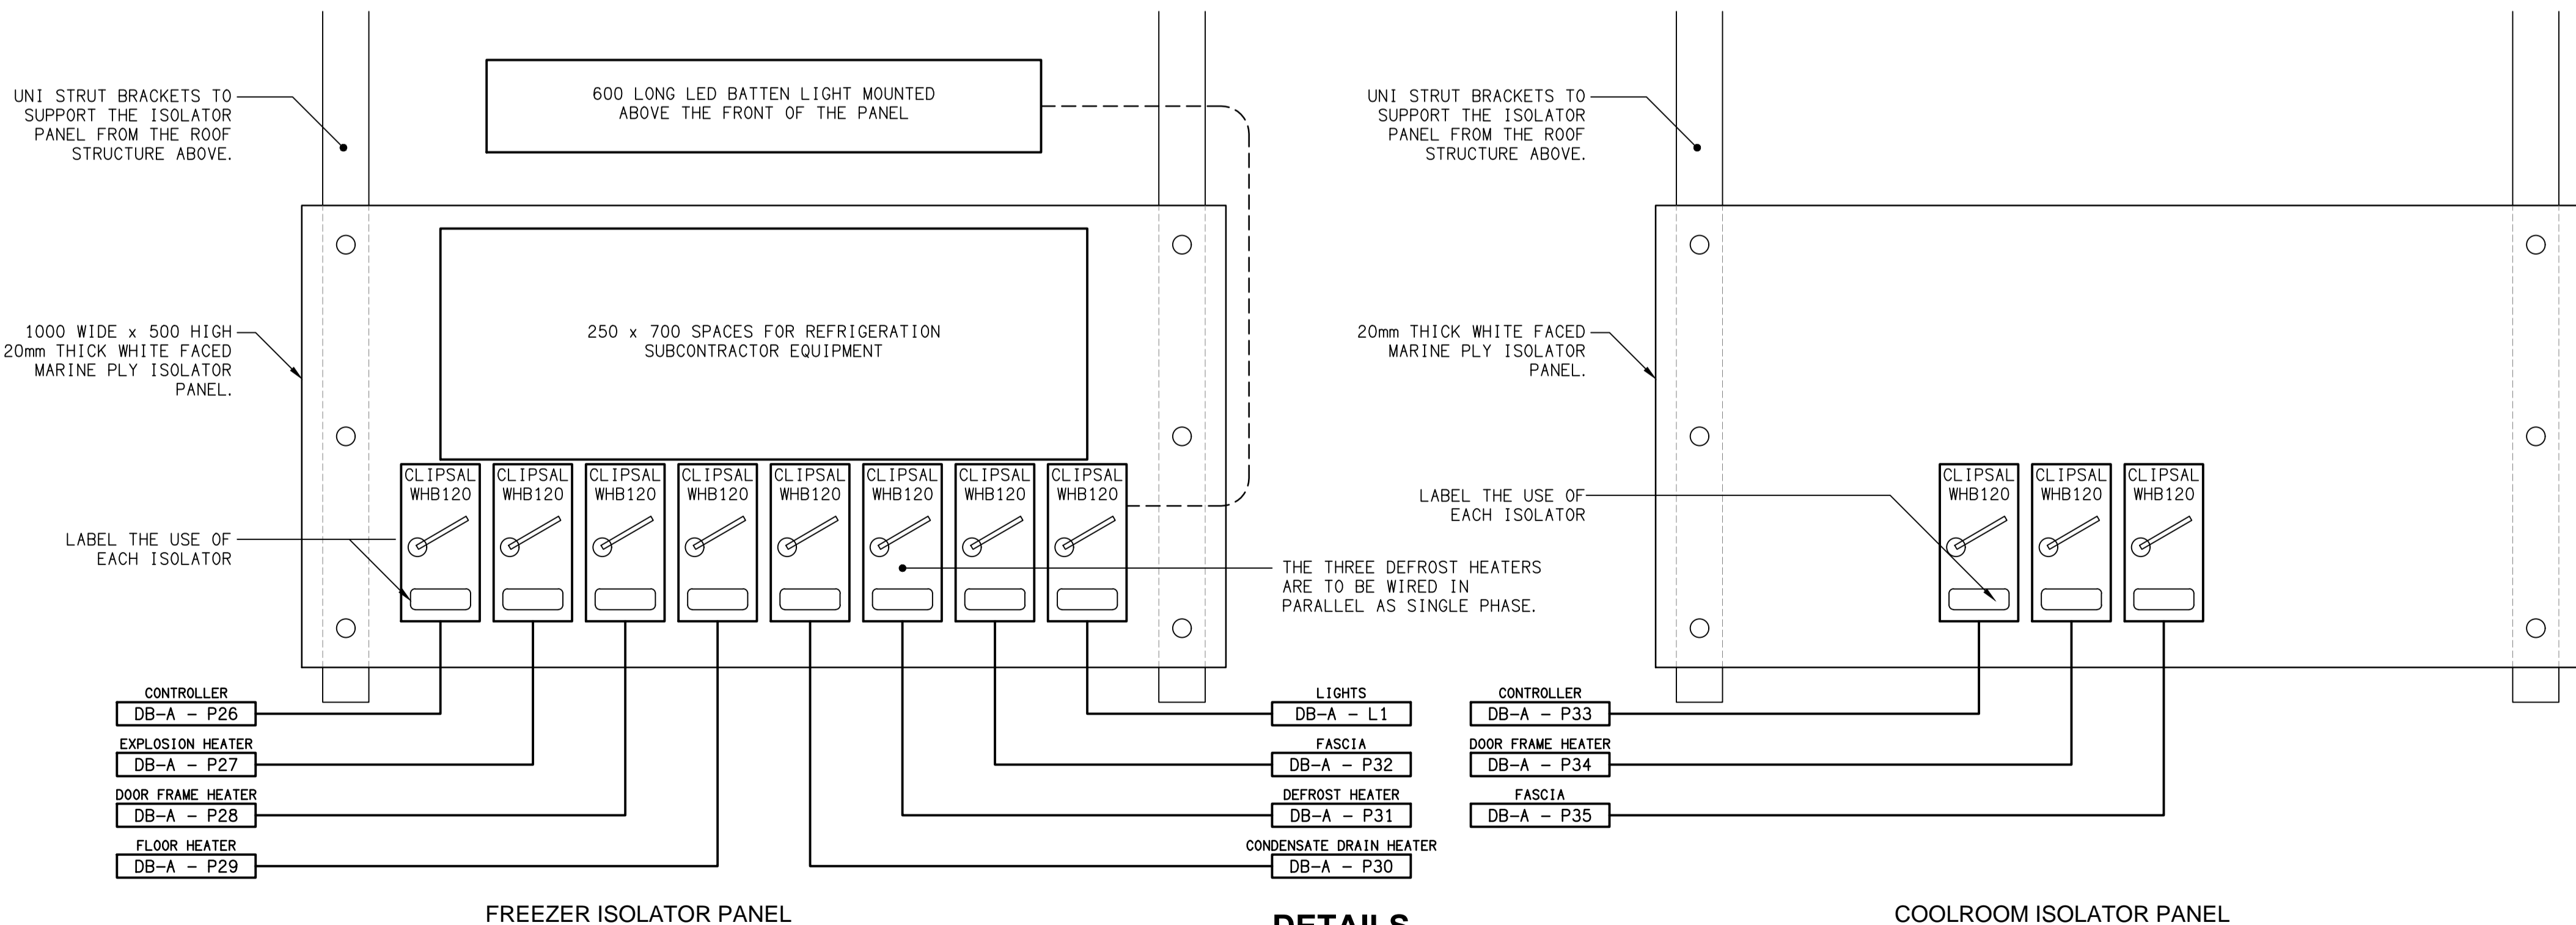

NOTE:

LOCATE THE ELECTRICAL ISOLATOR PANELS IN THE CEILING SPACE ABOVE THE ENTRY DOORS OF THE FREEZER AND COOLROOMS. CEILING ACCESS PANEL TO BE PROVIDED BY THE BUILDER.

DETAILS

ISOLATOR PANEL ELEVATIONS
NOT TO SCALE

B	PRELIMINARY	27/06/2025
REV:	DESCRIPTION:	DATE:

ELECTRICAL DESIGN GROUP
ELECTRICAL BUILDING SERVICES CONSULTANTS

BRISBANE: P.O. Box 15, Sherwood Qld 4075
Phone: (07) 3278 4375
Email: brisbane@edg.net.au
Web: www.edg.net.au

ELECTRICAL DESIGN GROUP BRISBANE PTY LTD
ACN 092 710 793

TRADING AS:
ELECTRICAL DESIGN GROUP

PROJECT:

BURGER URGE WILSONTON

SITE ADDRESS:

CORNER BRIDGE STREET & RICHMOND DRIVE, WILSONTON, QUEENSLAND

SCALE: SHEET SIZE:

1:100 UNO AT A1

DRAWING TITLE:

ELECTRICAL SERVICES ROOF PLAN & DETAILS

PROJECT NO: DRAWING NO: REVISION:

C3520a E06 B