




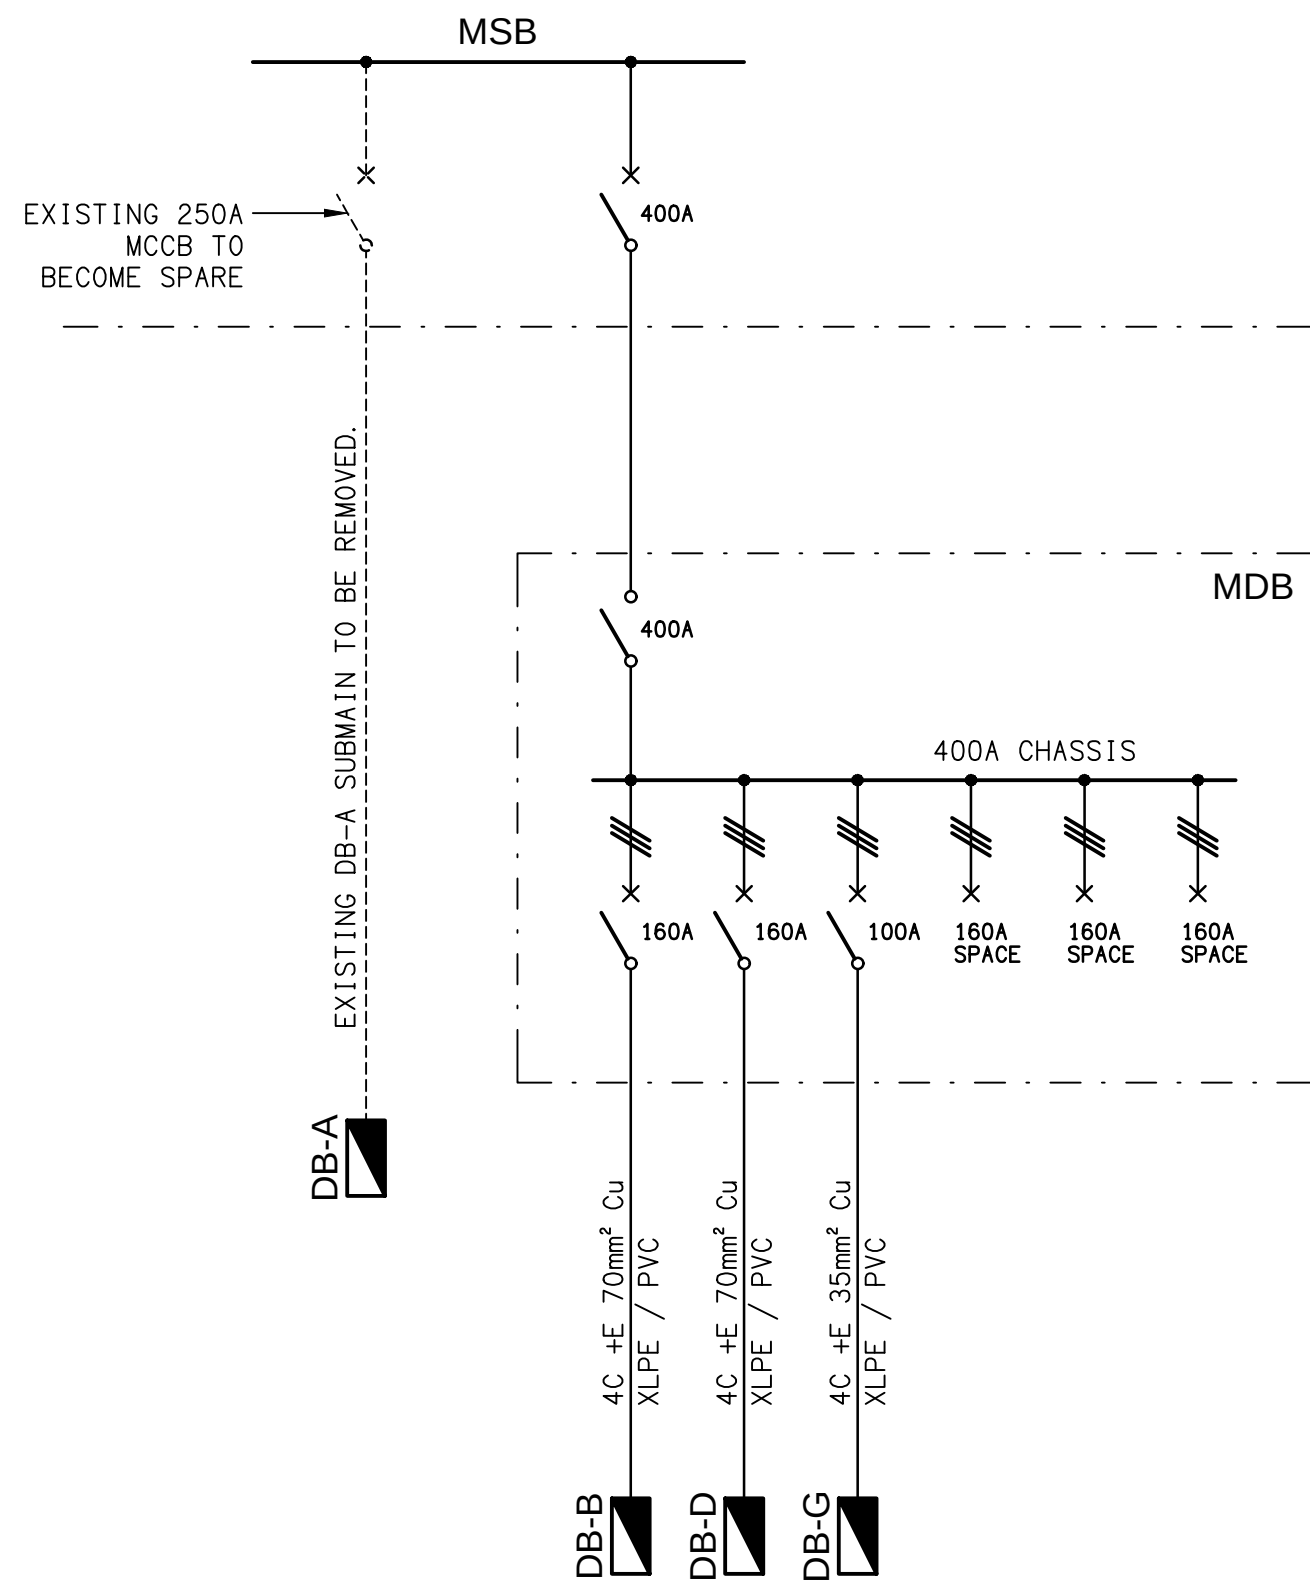

SCHEMATIC
POWER CONFIGURTION
NOT TO SCALE

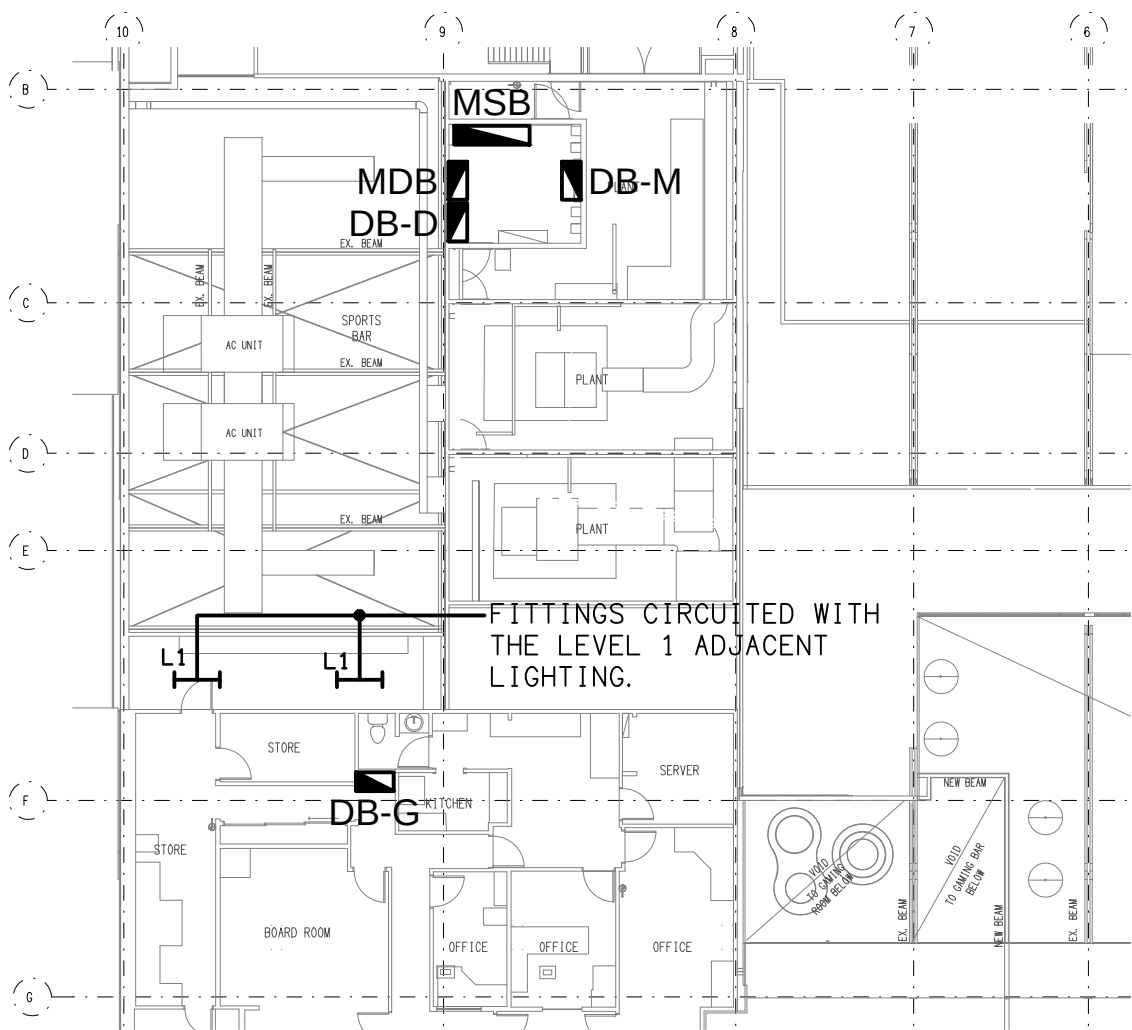

MEZZANINE LEVEL
PART FLOOR PLAN
SCALE 1: 200

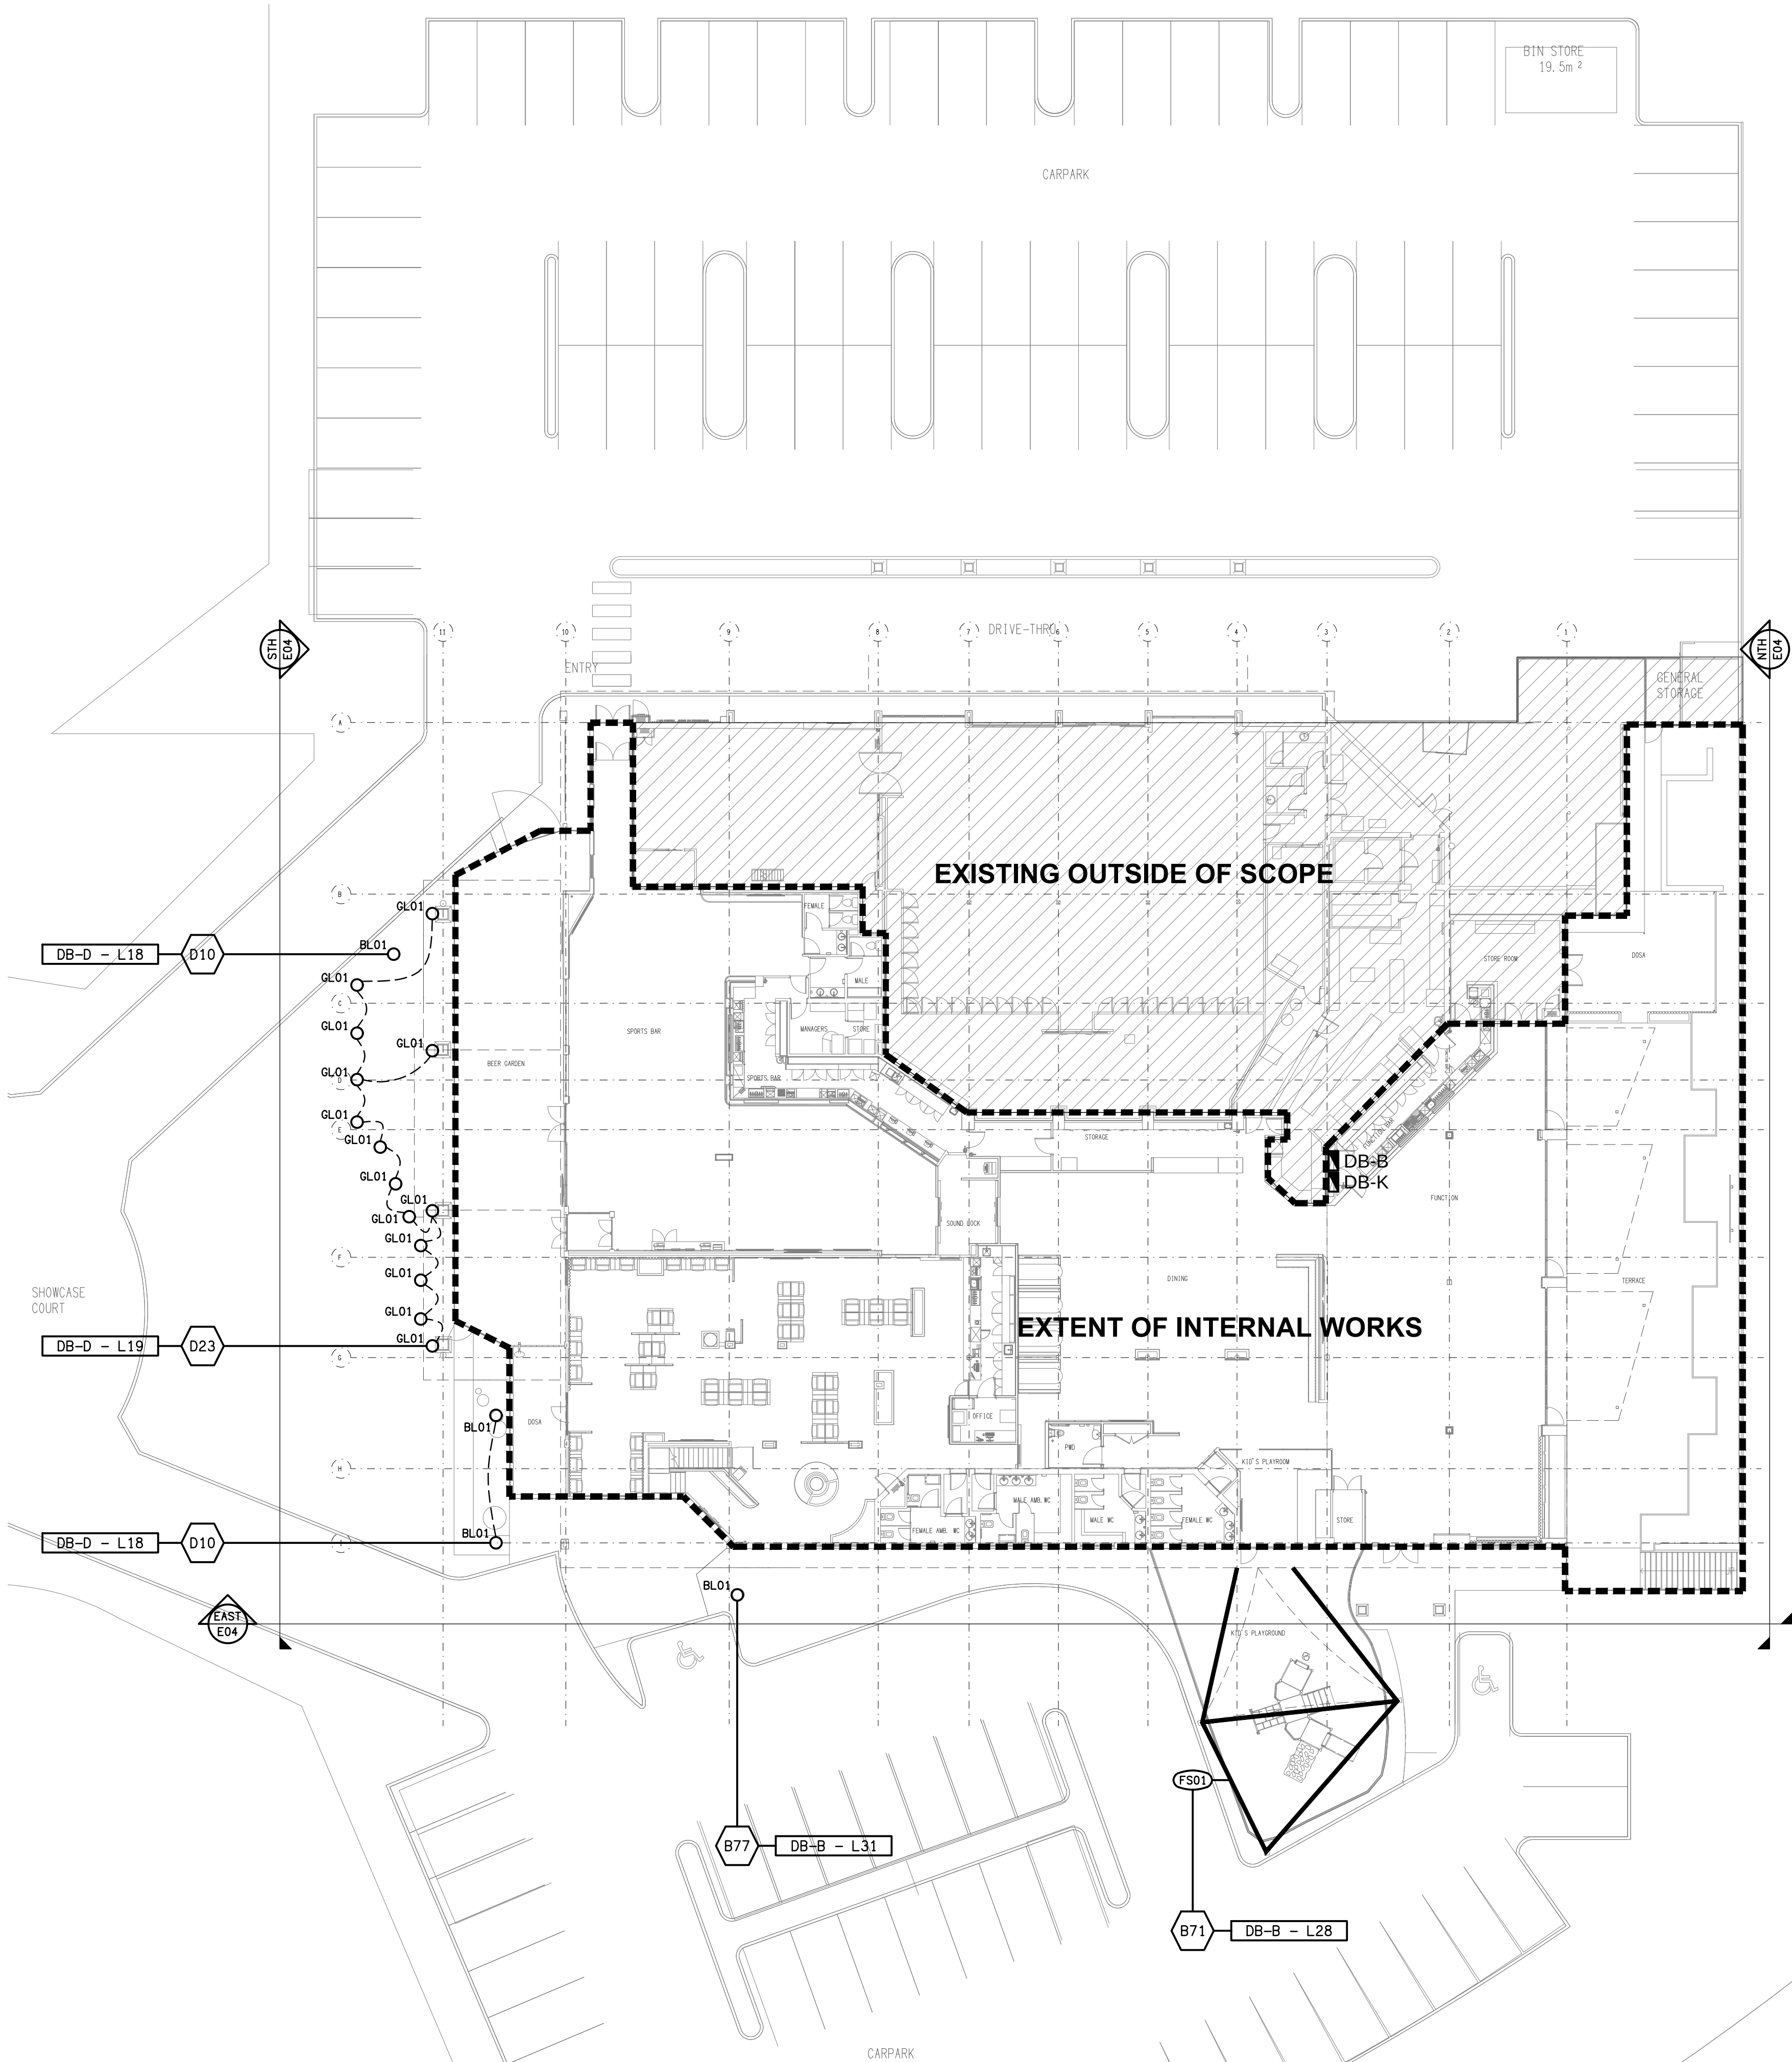

THE COPYRIGHT OF THIS DRAWING REMAINS THE PROPERTY OF THE ELECTRICAL DESIGN GROUP.

USE FIGURED DIMENSIONS IN PREFERENCE TO SCALE.

ALL DIMENSIONS TO BE VERIFIED ONSITE.



F	AS CONSTRUCTED	02/07/2026
REV:	DESCRIPTION:	DATE:

ELECTRICAL DESIGN GROUP
ELECTRICAL BUILDING SERVICES CONSULTANTS

BRISBANE: P.O. Box 15 Sherwood Qld 4075
Phone: (07) 3278 4375
Email: brisbane@edg.net.au
Web: www.edg.net.au

ELECTRICAL DESIGN GROUP BRISBANE PTY LTD
ACN 092 710 793

TRADING AS:
ELECTRICAL DESIGN GROUP

PROJECT:

BENOWA TAVERN

SITE ADDRESS:

117 ASHMORE ROAD, BENOWA
GOLD COAST

SCALE: SHEET SIZE:

1:200 AT A1

DRAWING TITLE:

ELECTRICAL SERVICES
SITE PLAN &
POWER SCHEMATIC

PROJECT NO: DRAWING NO: REVISION:

C3600a E03 F