



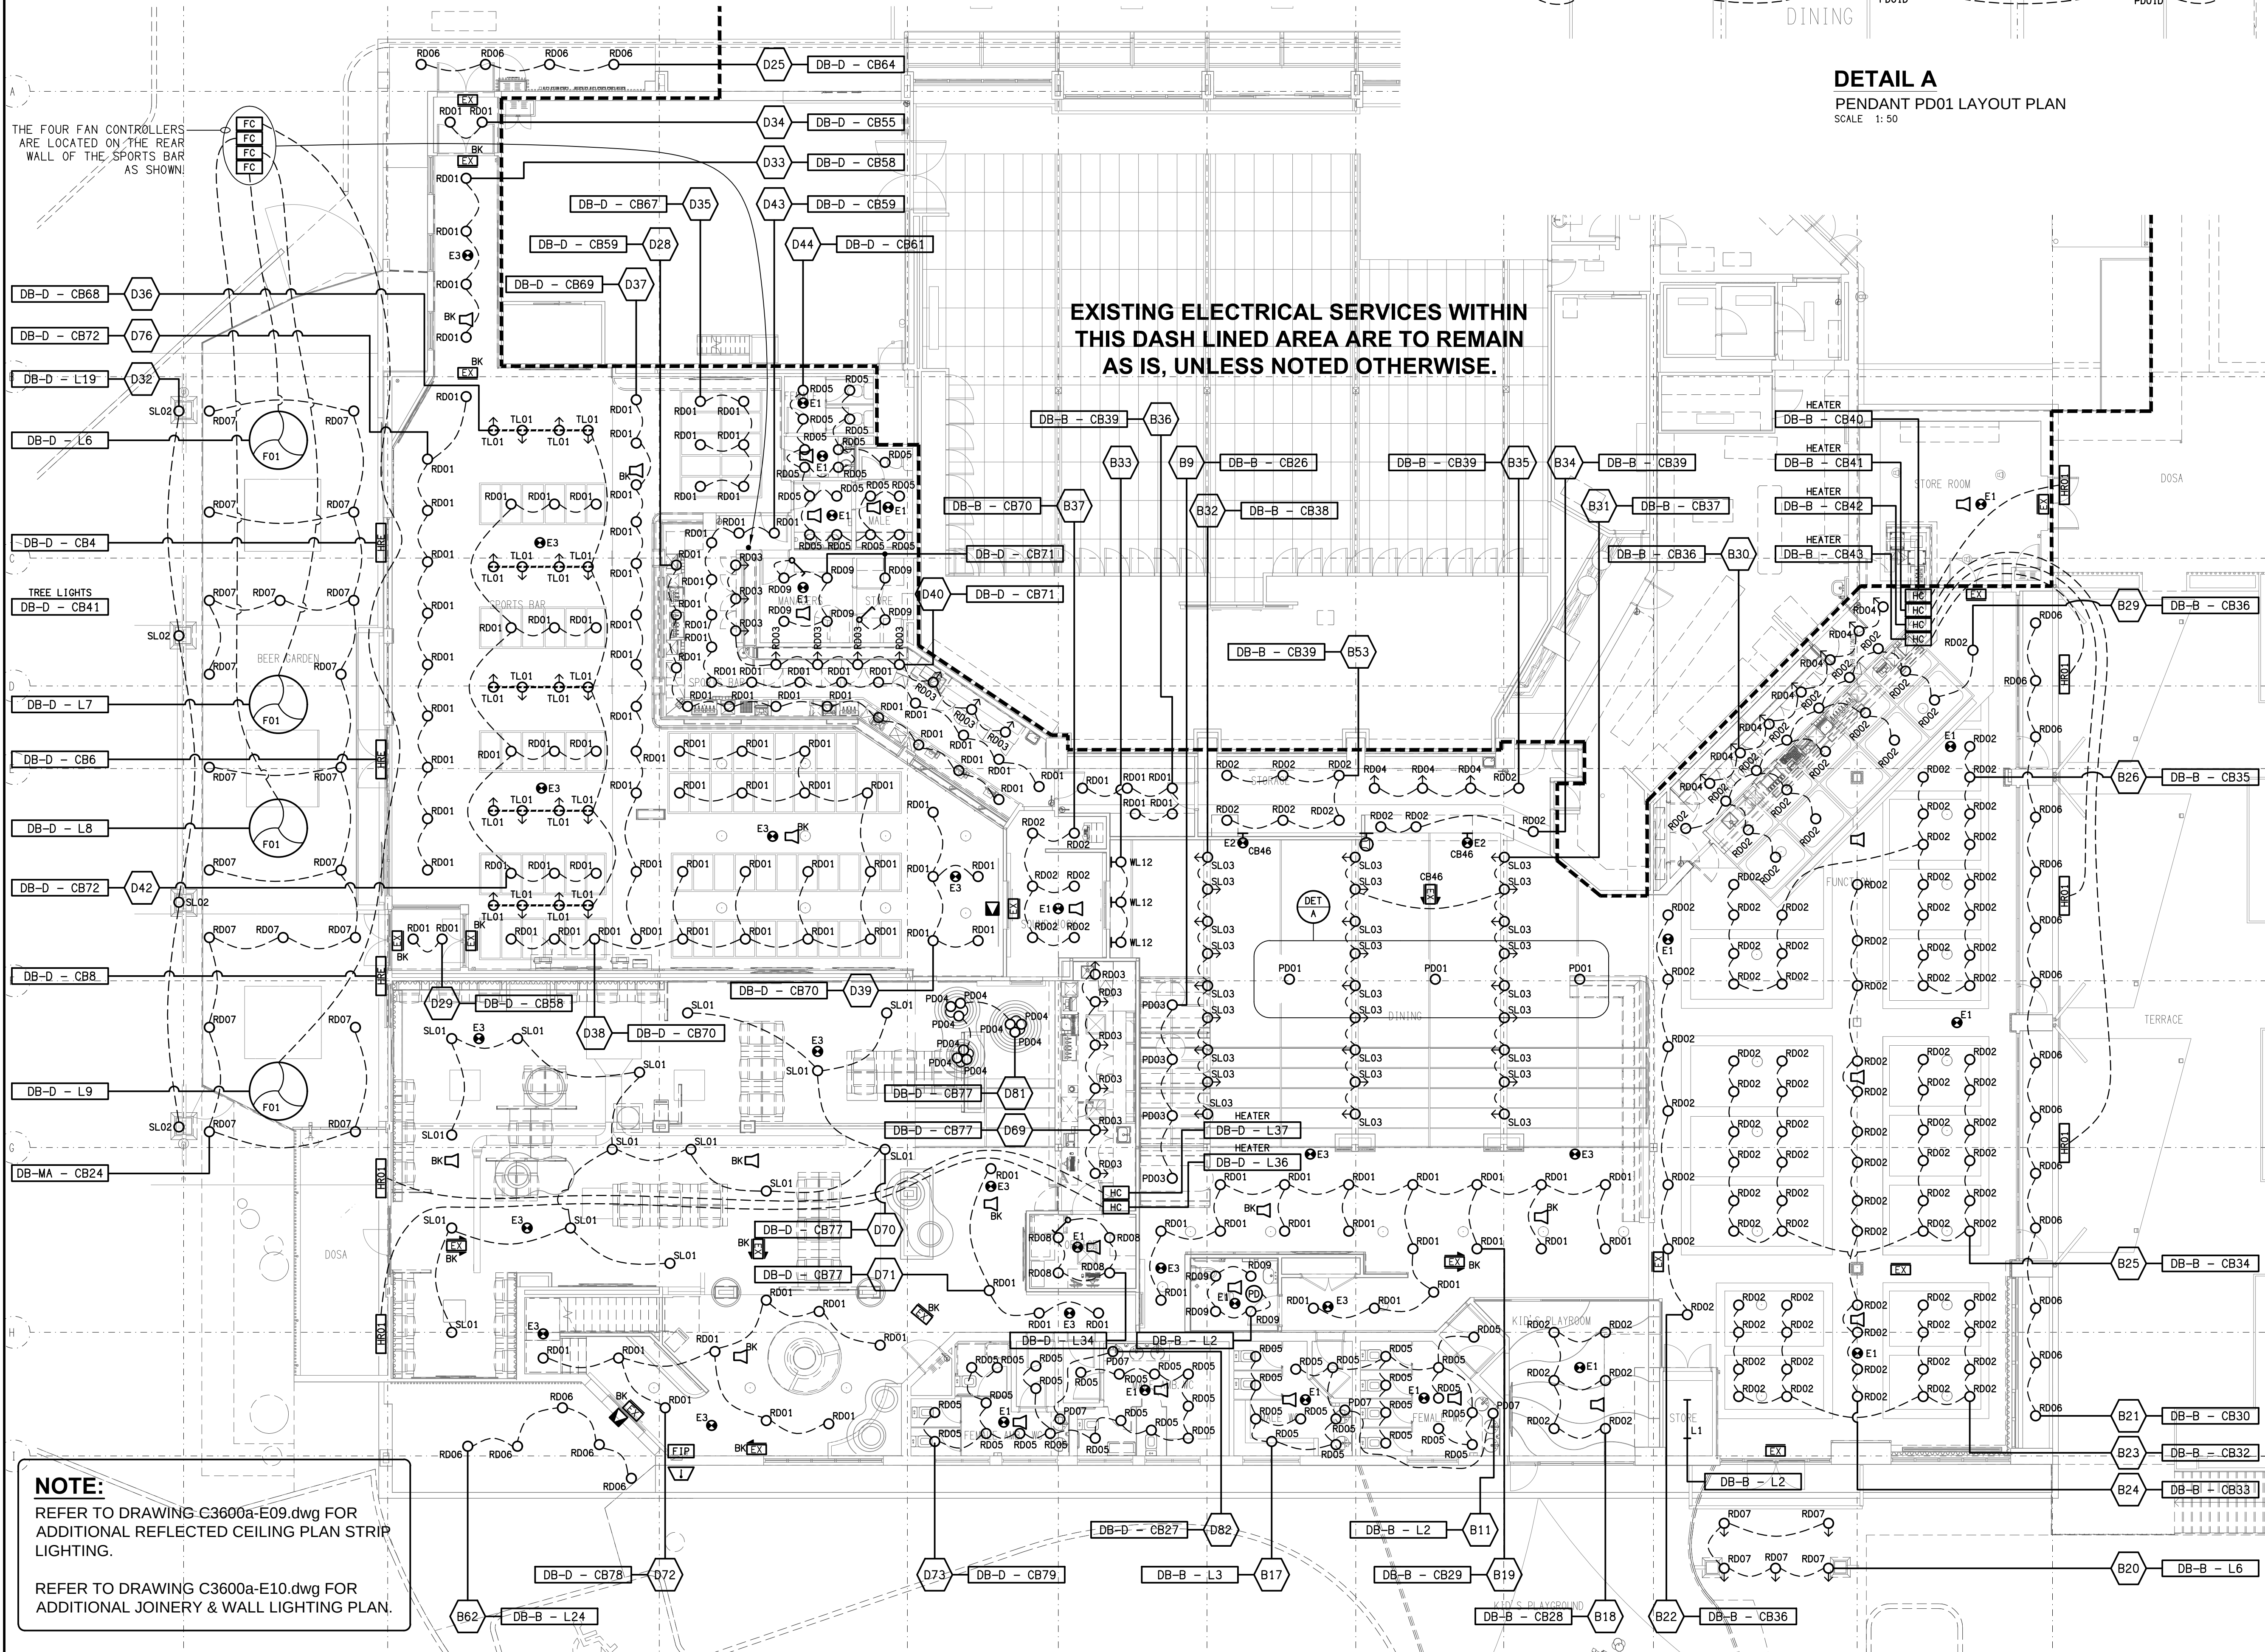

THE FOUR FAN CONTROLLERS ARE LOCATED ON THE REAR WALL OF THE SPORTS BAR AS SHOWN!

EXISTING ELECTRICAL SERVICES WITHIN THIS DASH LINED AREA ARE TO REMAIN AS IS, UNLESS NOTED OTHERWISE.

NOTE:
REFER TO DRAWING C3600a-E09.dwg FOR ADDITIONAL REFLECTED CEILING PLAN STRIP LIGHTING.
REFER TO DRAWING C3600a-E10.dwg FOR ADDITIONAL JOINERY & WALL LIGHTING PLAN.

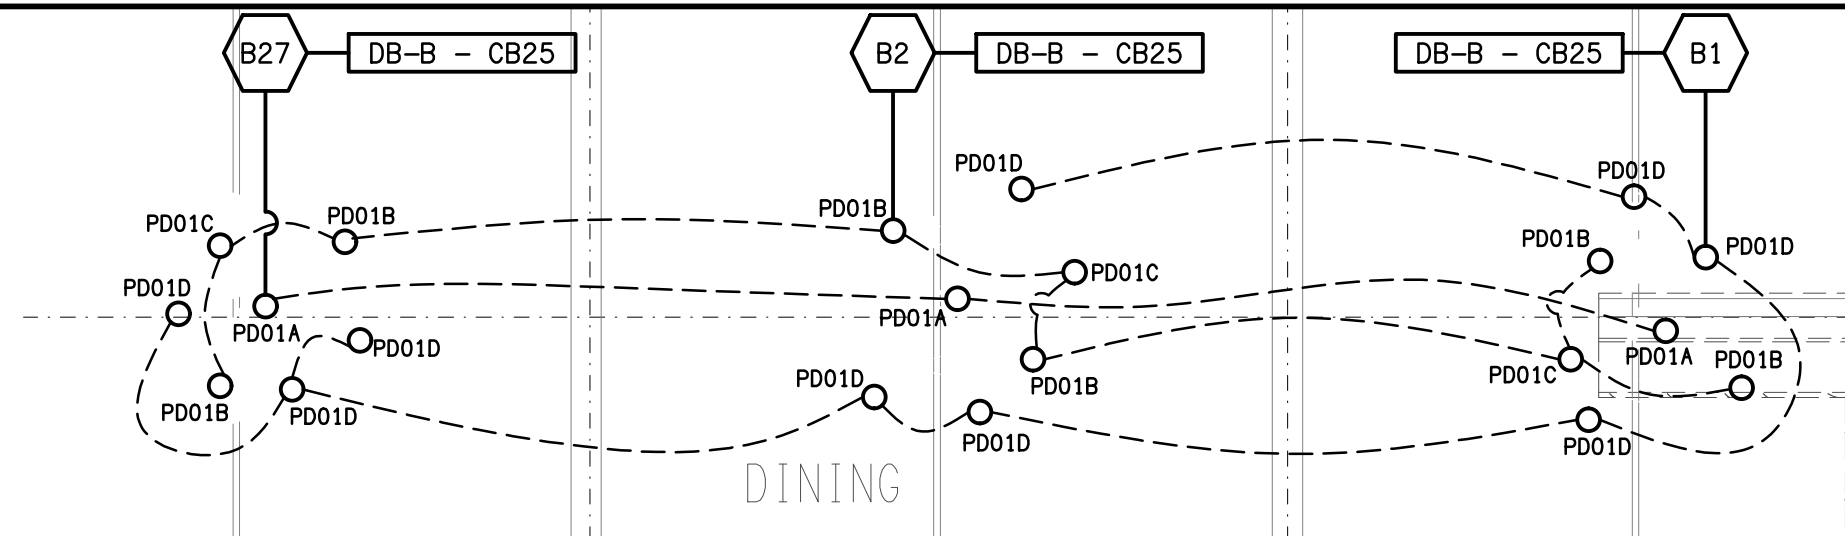

DETAIL A
PENDANT PD01 LAYOUT PLAN
SCALE 1: 50

THE COPYRIGHT OF THIS DRAWING REMAINS THE PROPERTY OF THE ELECTRICAL DESIGN GROUP.
USE FIGURED DIMENSIONS IN PREFERENCE TO SCALE.
ALL DIMENSIONS TO BE VERIFIED ONSITE.



J	AS CONSTRUCTED	02/07/2026
REV:	DESCRIPTION:	DATE:

ELECTRICAL DESIGN GROUP
ELECTRICAL BUILDING SERVICES CONSULTANTS

BRISBANE: P.O. Box 15 Sherwood Qld 4075
Phone: (07) 3278 4375
Email: brisbane@edg.net.au
Web: www.edg.net.au

ELECTRICAL DESIGN GROUP BRISBANE PTY LTD
ACN 092 710 793

PROJECT: **BENOWA TAVERN**

SITE ADDRESS:
**117 ASHMORE ROAD, BENOWA
GOLD COAST**

SCALE: **1:100** SHEET SIZE: **A1**

DRAWING TITLE:

**ELECTRICAL SERVICES
REFLECTED CEILING PLAN**

PROJECT NO: DRAWING NO: REVISION:

C3600a E08 J