


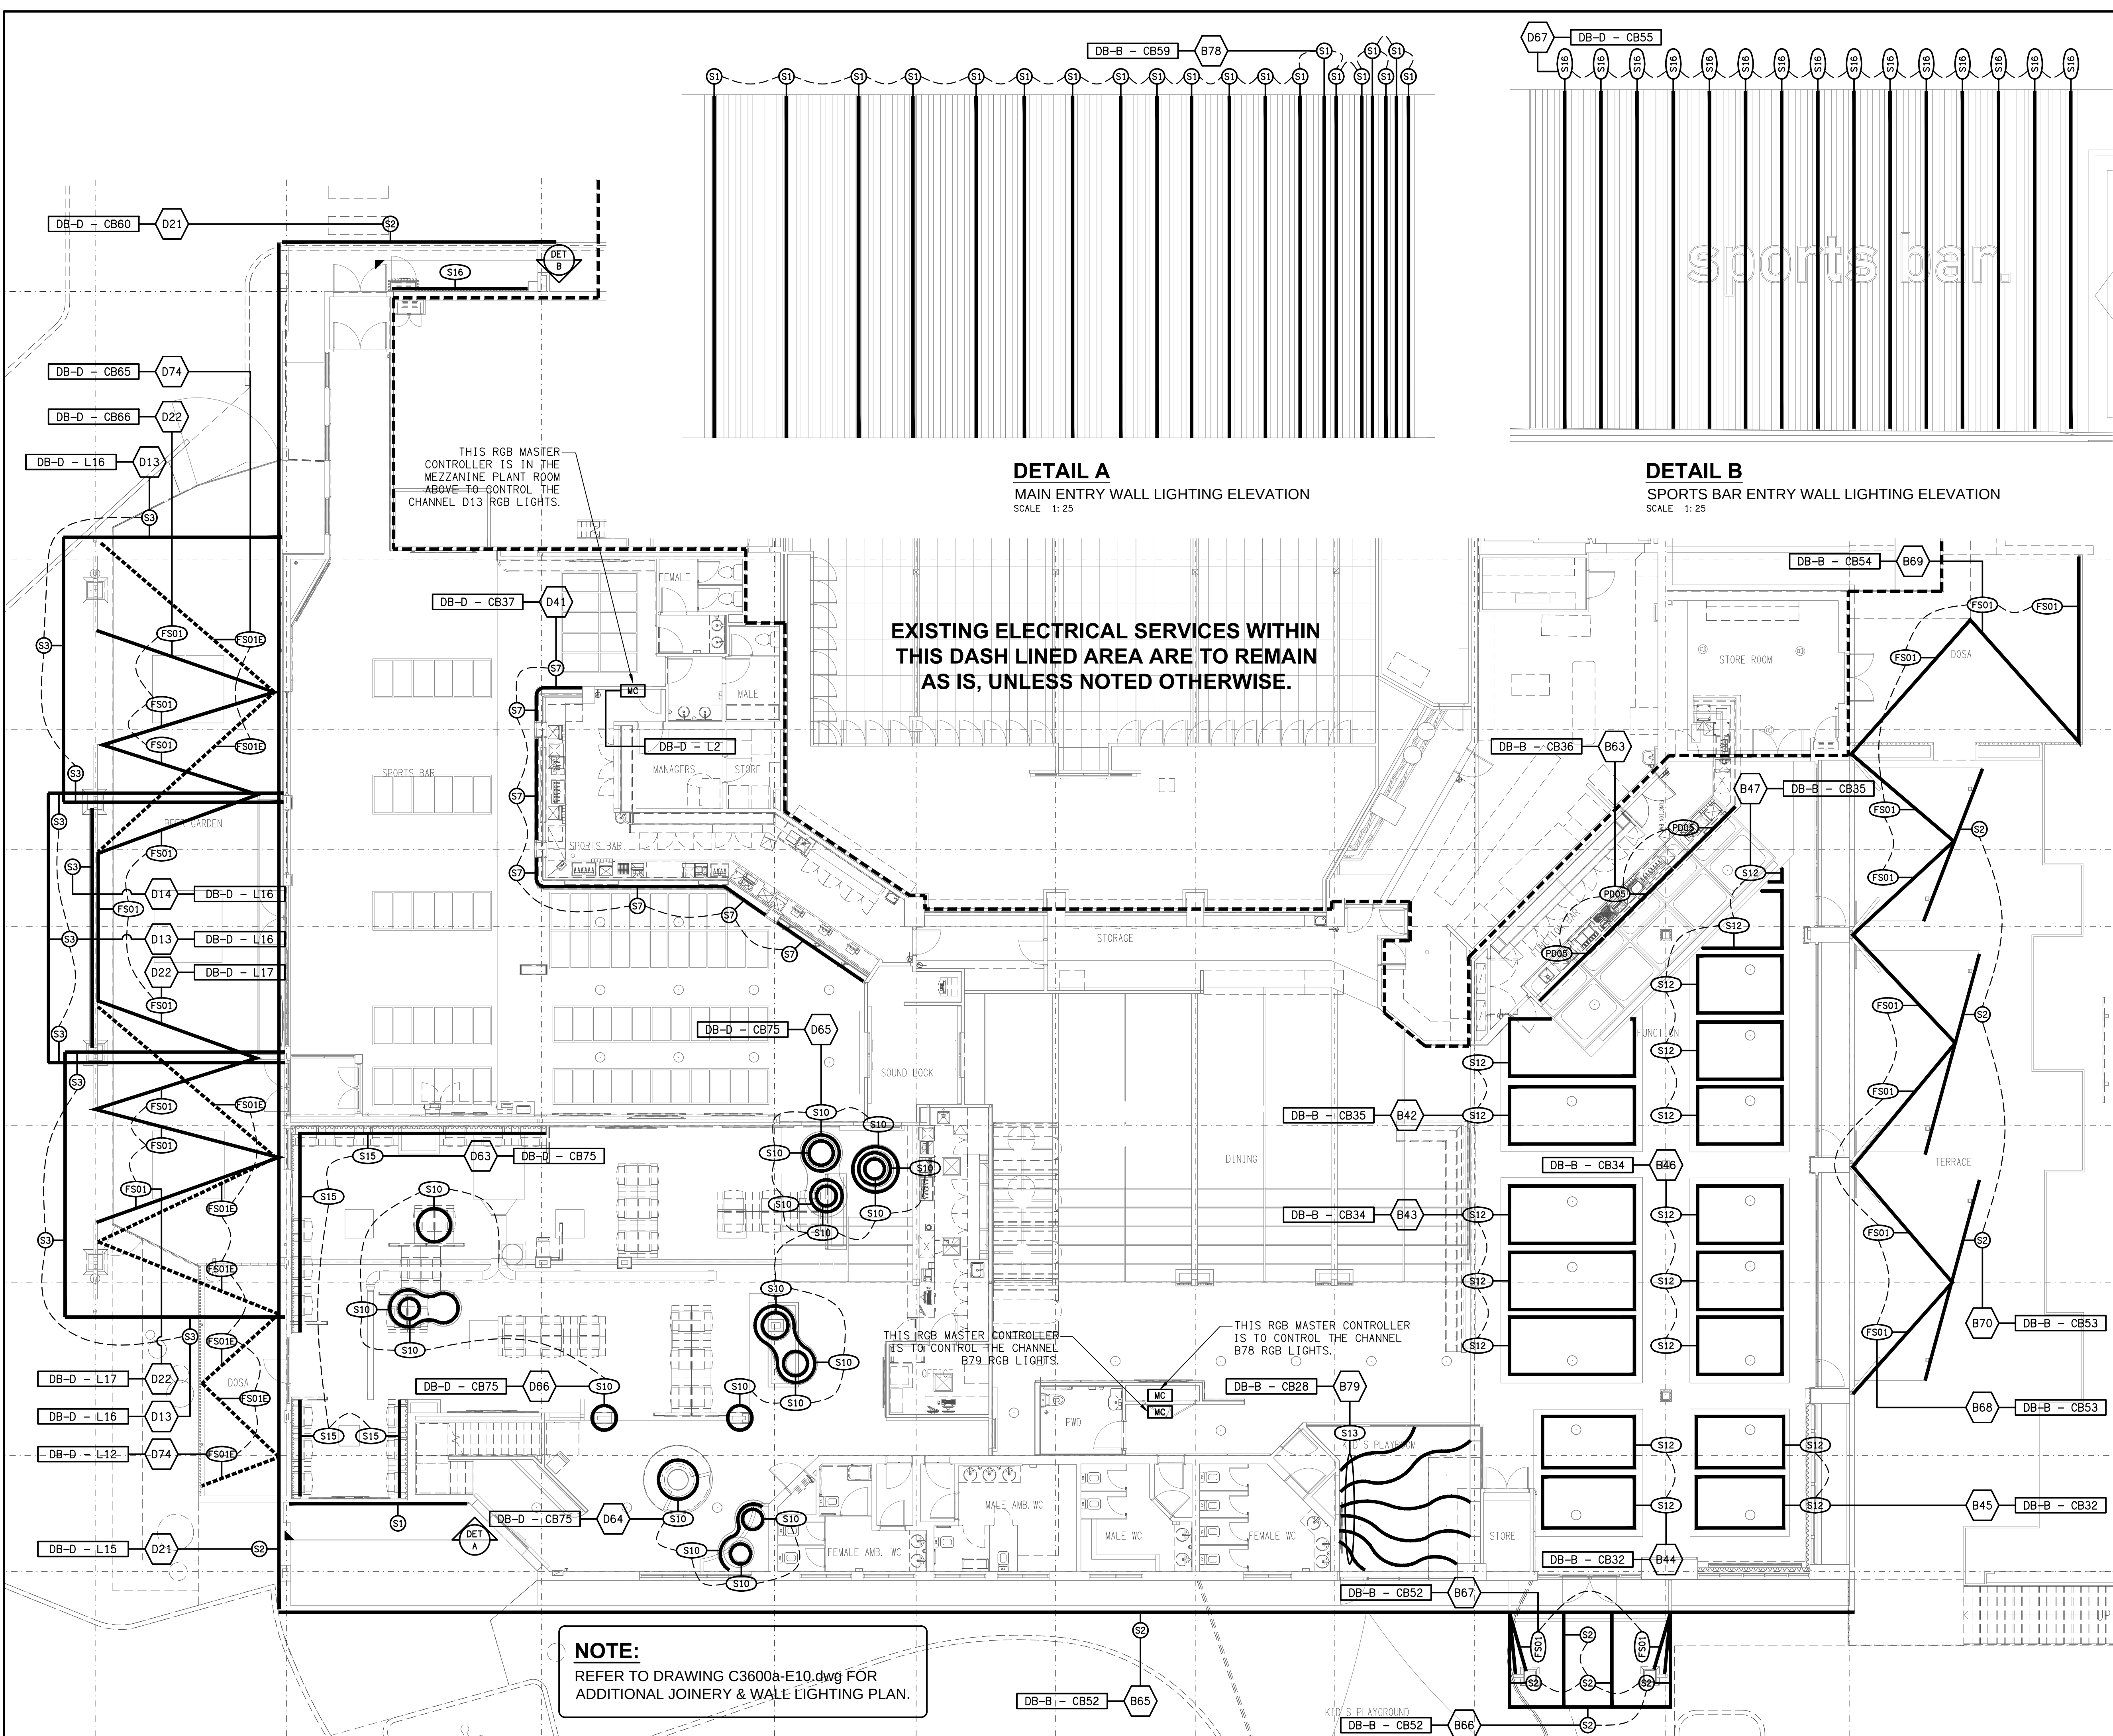

DETAIL A
MAIN ENTRY WALL LIGHTING ELEVATION
SCALE 1: 25

DETAIL B
SPORTS BAR ENTRY WALL LIGHTING ELEVATION
SCALE 1: 25

EXISTING ELECTRICAL SERVICES WITHIN
THIS DASH LINED AREA ARE TO REMAIN
AS IS, UNLESS NOTED OTHERWISE.

NOTE:
REFER TO DRAWING C3600a-E10.dwg FOR
ADDITIONAL JOINERY & WALL LIGHTING PLAN.

THE COPYRIGHT OF THIS DRAWING REMAINS THE PROPERTY OF
THE ELECTRICAL DESIGN GROUP.

USE FIGURED DIMENSIONS IN PREFERENCE TO SCALE.

ALL DIMENSIONS TO BE VERIFIED ONSITE.



G	AS CONSTRUCTED	02/07/2026
REV:	DESCRIPTION:	DATE:

ELECTRICAL DESIGN GROUP
ELECTRICAL BUILDING SERVICES CONSULTANTS

BRISBANE: P.O. Box 15 Sherwood Qld 4075
Phone: (07) 3278 4375
Email: brisbane@edg.net.au
Web: www.edg.net.au

ELECTRICAL DESIGN GROUP BRISBANE PTY LTD
ACN 092 710 793

TRADING AS:
ELECTRICAL DESIGN
GROUP

PROJECT:
BENOWA TAVERN

SITE ADDRESS:
**117 ASHMORE ROAD, BENOWA
GOLD COAST**

SCALE: 1:100 SHEET SIZE: AT A1

DRAWING TITLE:

**ELECTRICAL SERVICES
REFLECTED CEILING PLAN
STRIP LIGHTING**

PROJECT NO: DRAWING NO: REVISION:

C3600a E09 G