


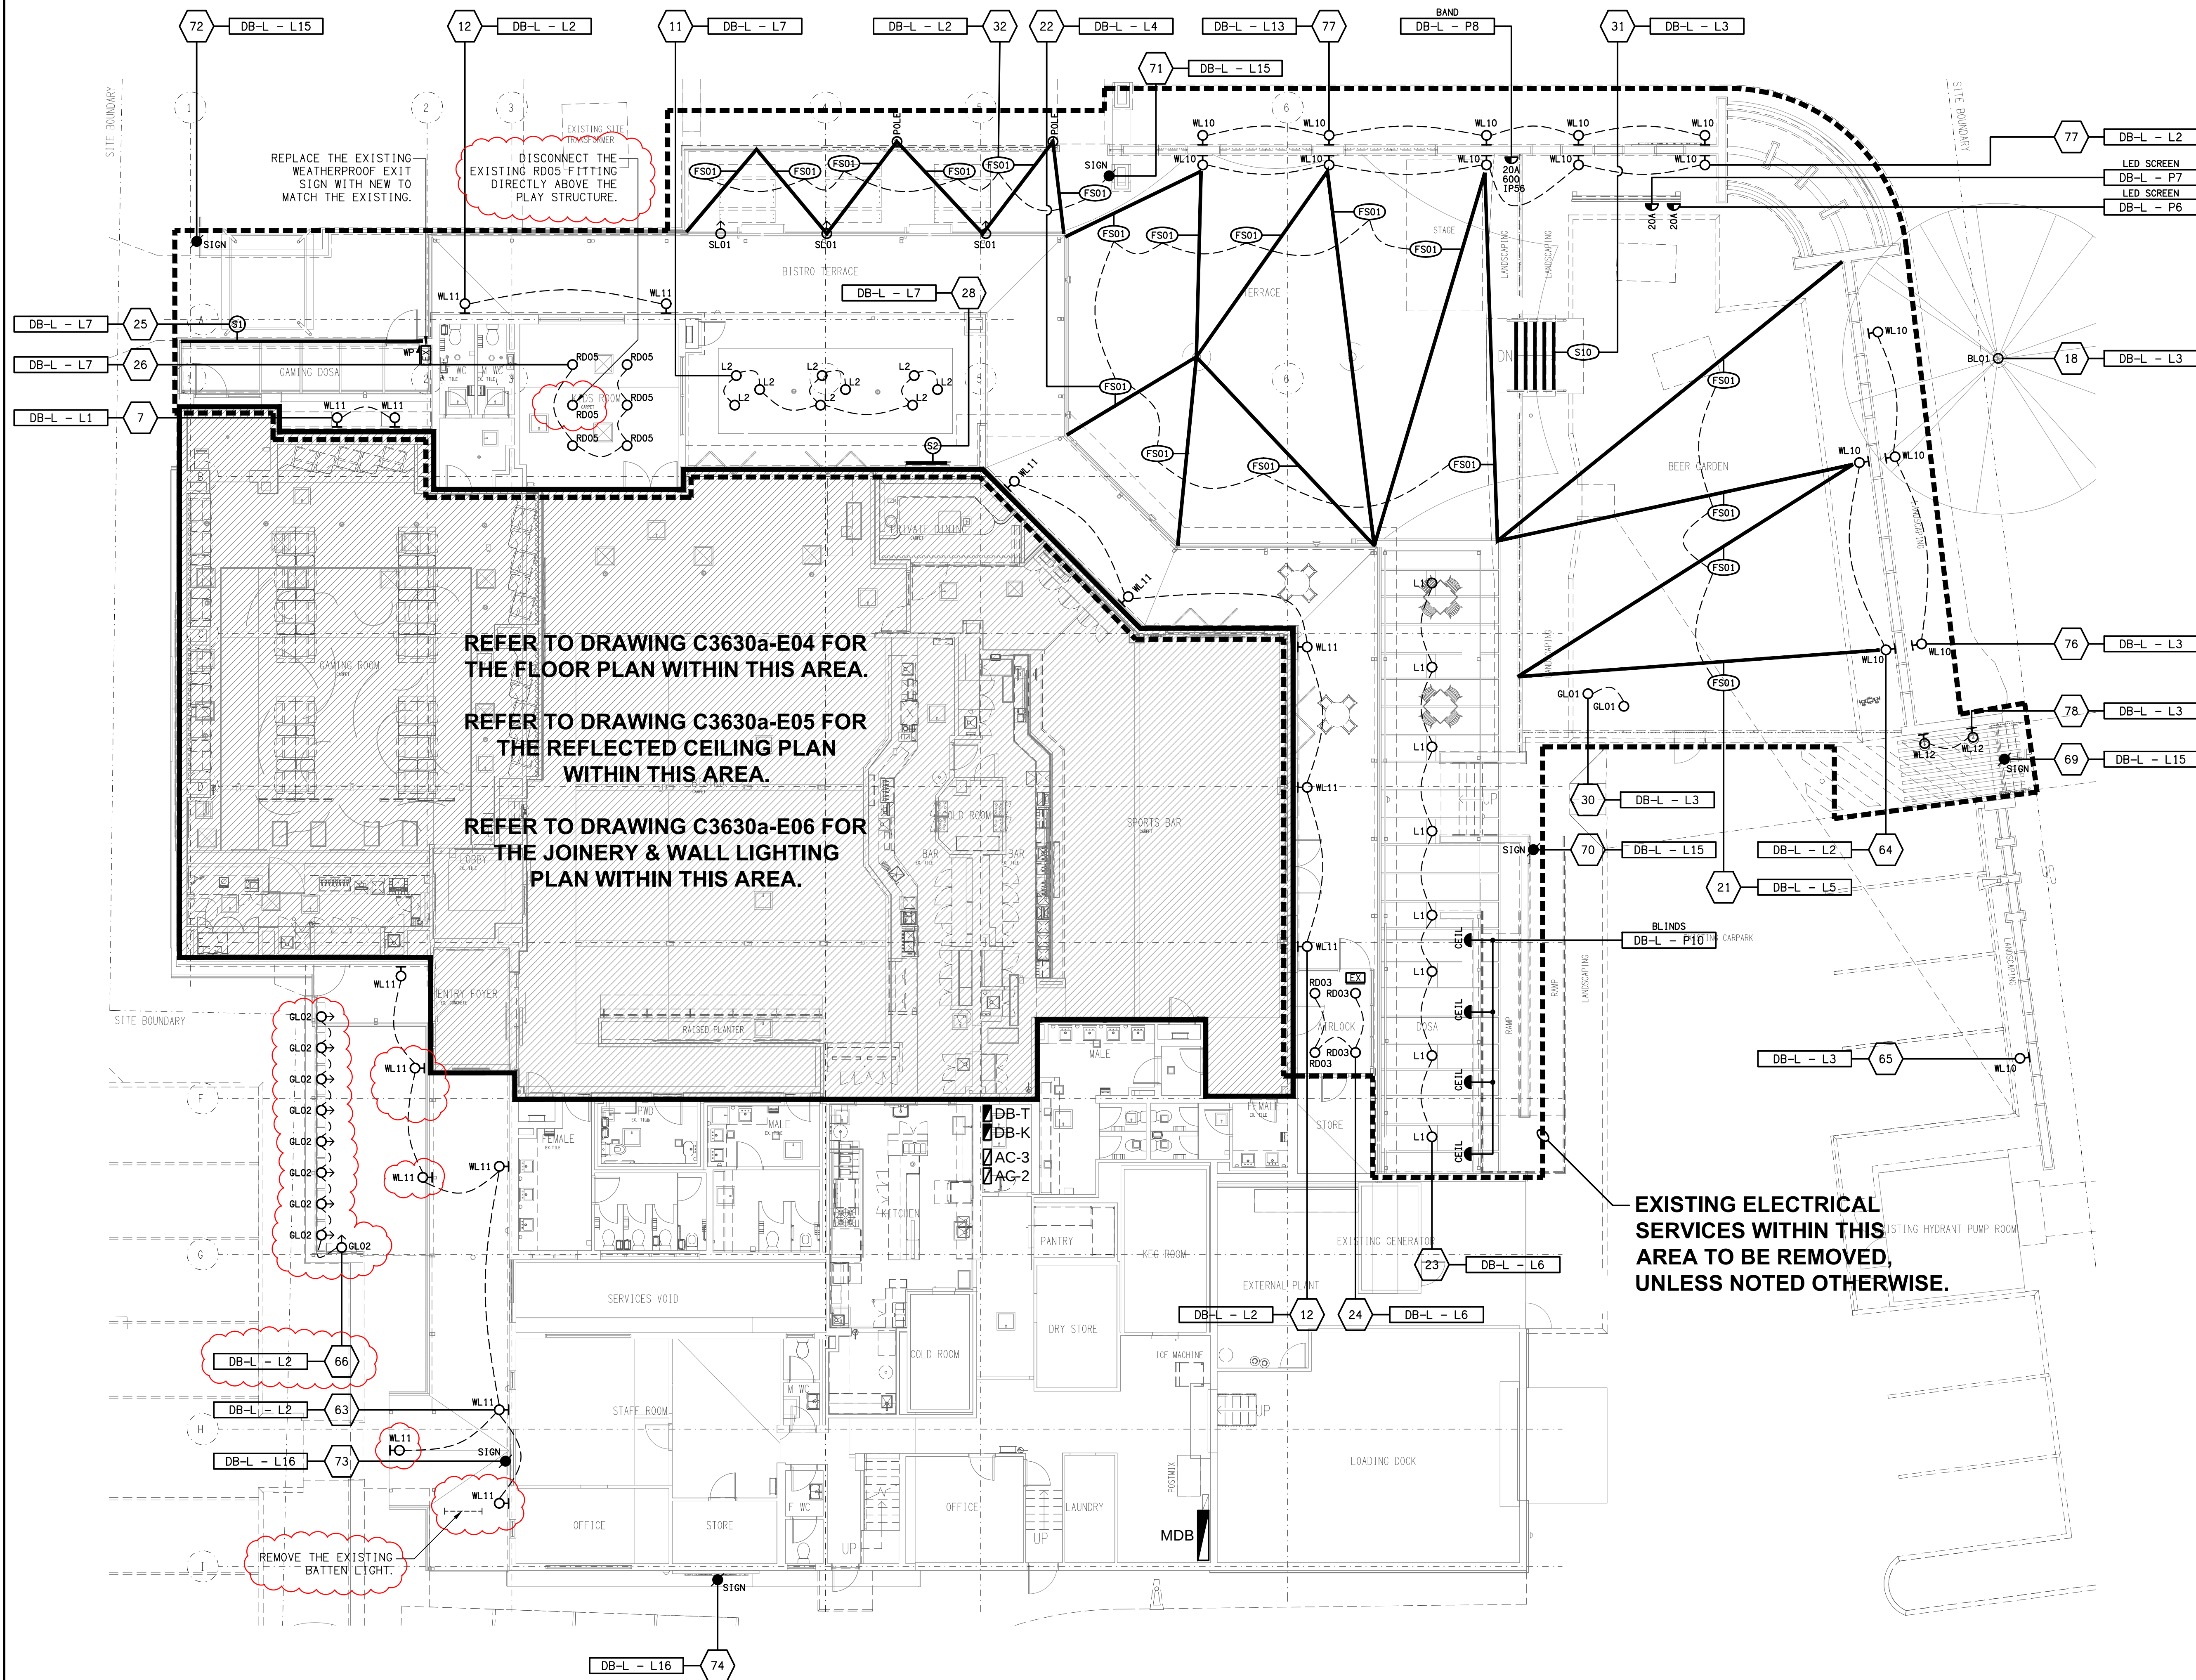

REPLACE THE EXISTING WEATHERPROOF EXIT SIGN WITH NEW TO MATCH THE EXISTING.

DISCONNECT THE EXISTING RD05 FITTING DIRECTLY ABOVE THE PLAY STRUCTURE.

REFER TO DRAWING C3630a-E04 FOR THE FLOOR PLAN WITHIN THIS AREA.

REFER TO DRAWING C3630a-E05 FOR THE REFLECTED CEILING PLAN WITHIN THIS AREA.

REFER TO DRAWING C3630a-E06 FOR THE JOINERY & WALL LIGHTING PLAN WITHIN THIS AREA.

REMOVE THE EXISTING BATTEN LIGHT.

EXISTING ELECTRICAL SERVICES WITHIN THIS AREA TO BE REMOVED, UNLESS NOTED OTHERWISE.

THIS DRAWING CONTAINS THE REVISION CLOUDS FOR BOTH REVISION (F) AND REVISION (G).

G	CONSTRUCTION	27/08/2026
REV:	DESCRIPTION:	DATE:

ELECTRICAL DESIGN GROUP
ELECTRICAL BUILDING SERVICES CONSULTANTS

BRISBANE: P.O. Box 15 Sherwood Qld 4075
Phone: (07) 3278 4375
Email: brisbane@edg.net.au
Web: www.edg.net.au

ELECTRICAL DESIGN GROUP BRISBANE PTY LTD
ACN 092 710 793

TRADING AS:
ELECTRICAL DESIGN GROUP

PROJECT:
JIMBOOMBA TAVERN

SITE ADDRESS:
CORNER MT LINDESAY HIGHWAY & CUSACKS LANE, JIMBOOMBA

SCALE: 1:100 SHEET SIZE: AT A1

DRAWING TITLE:
ELECTRICAL SERVICES OVERALL PLAN

PROJECT NO: DRAWING NO: REVISION:
C3630a E03 G