


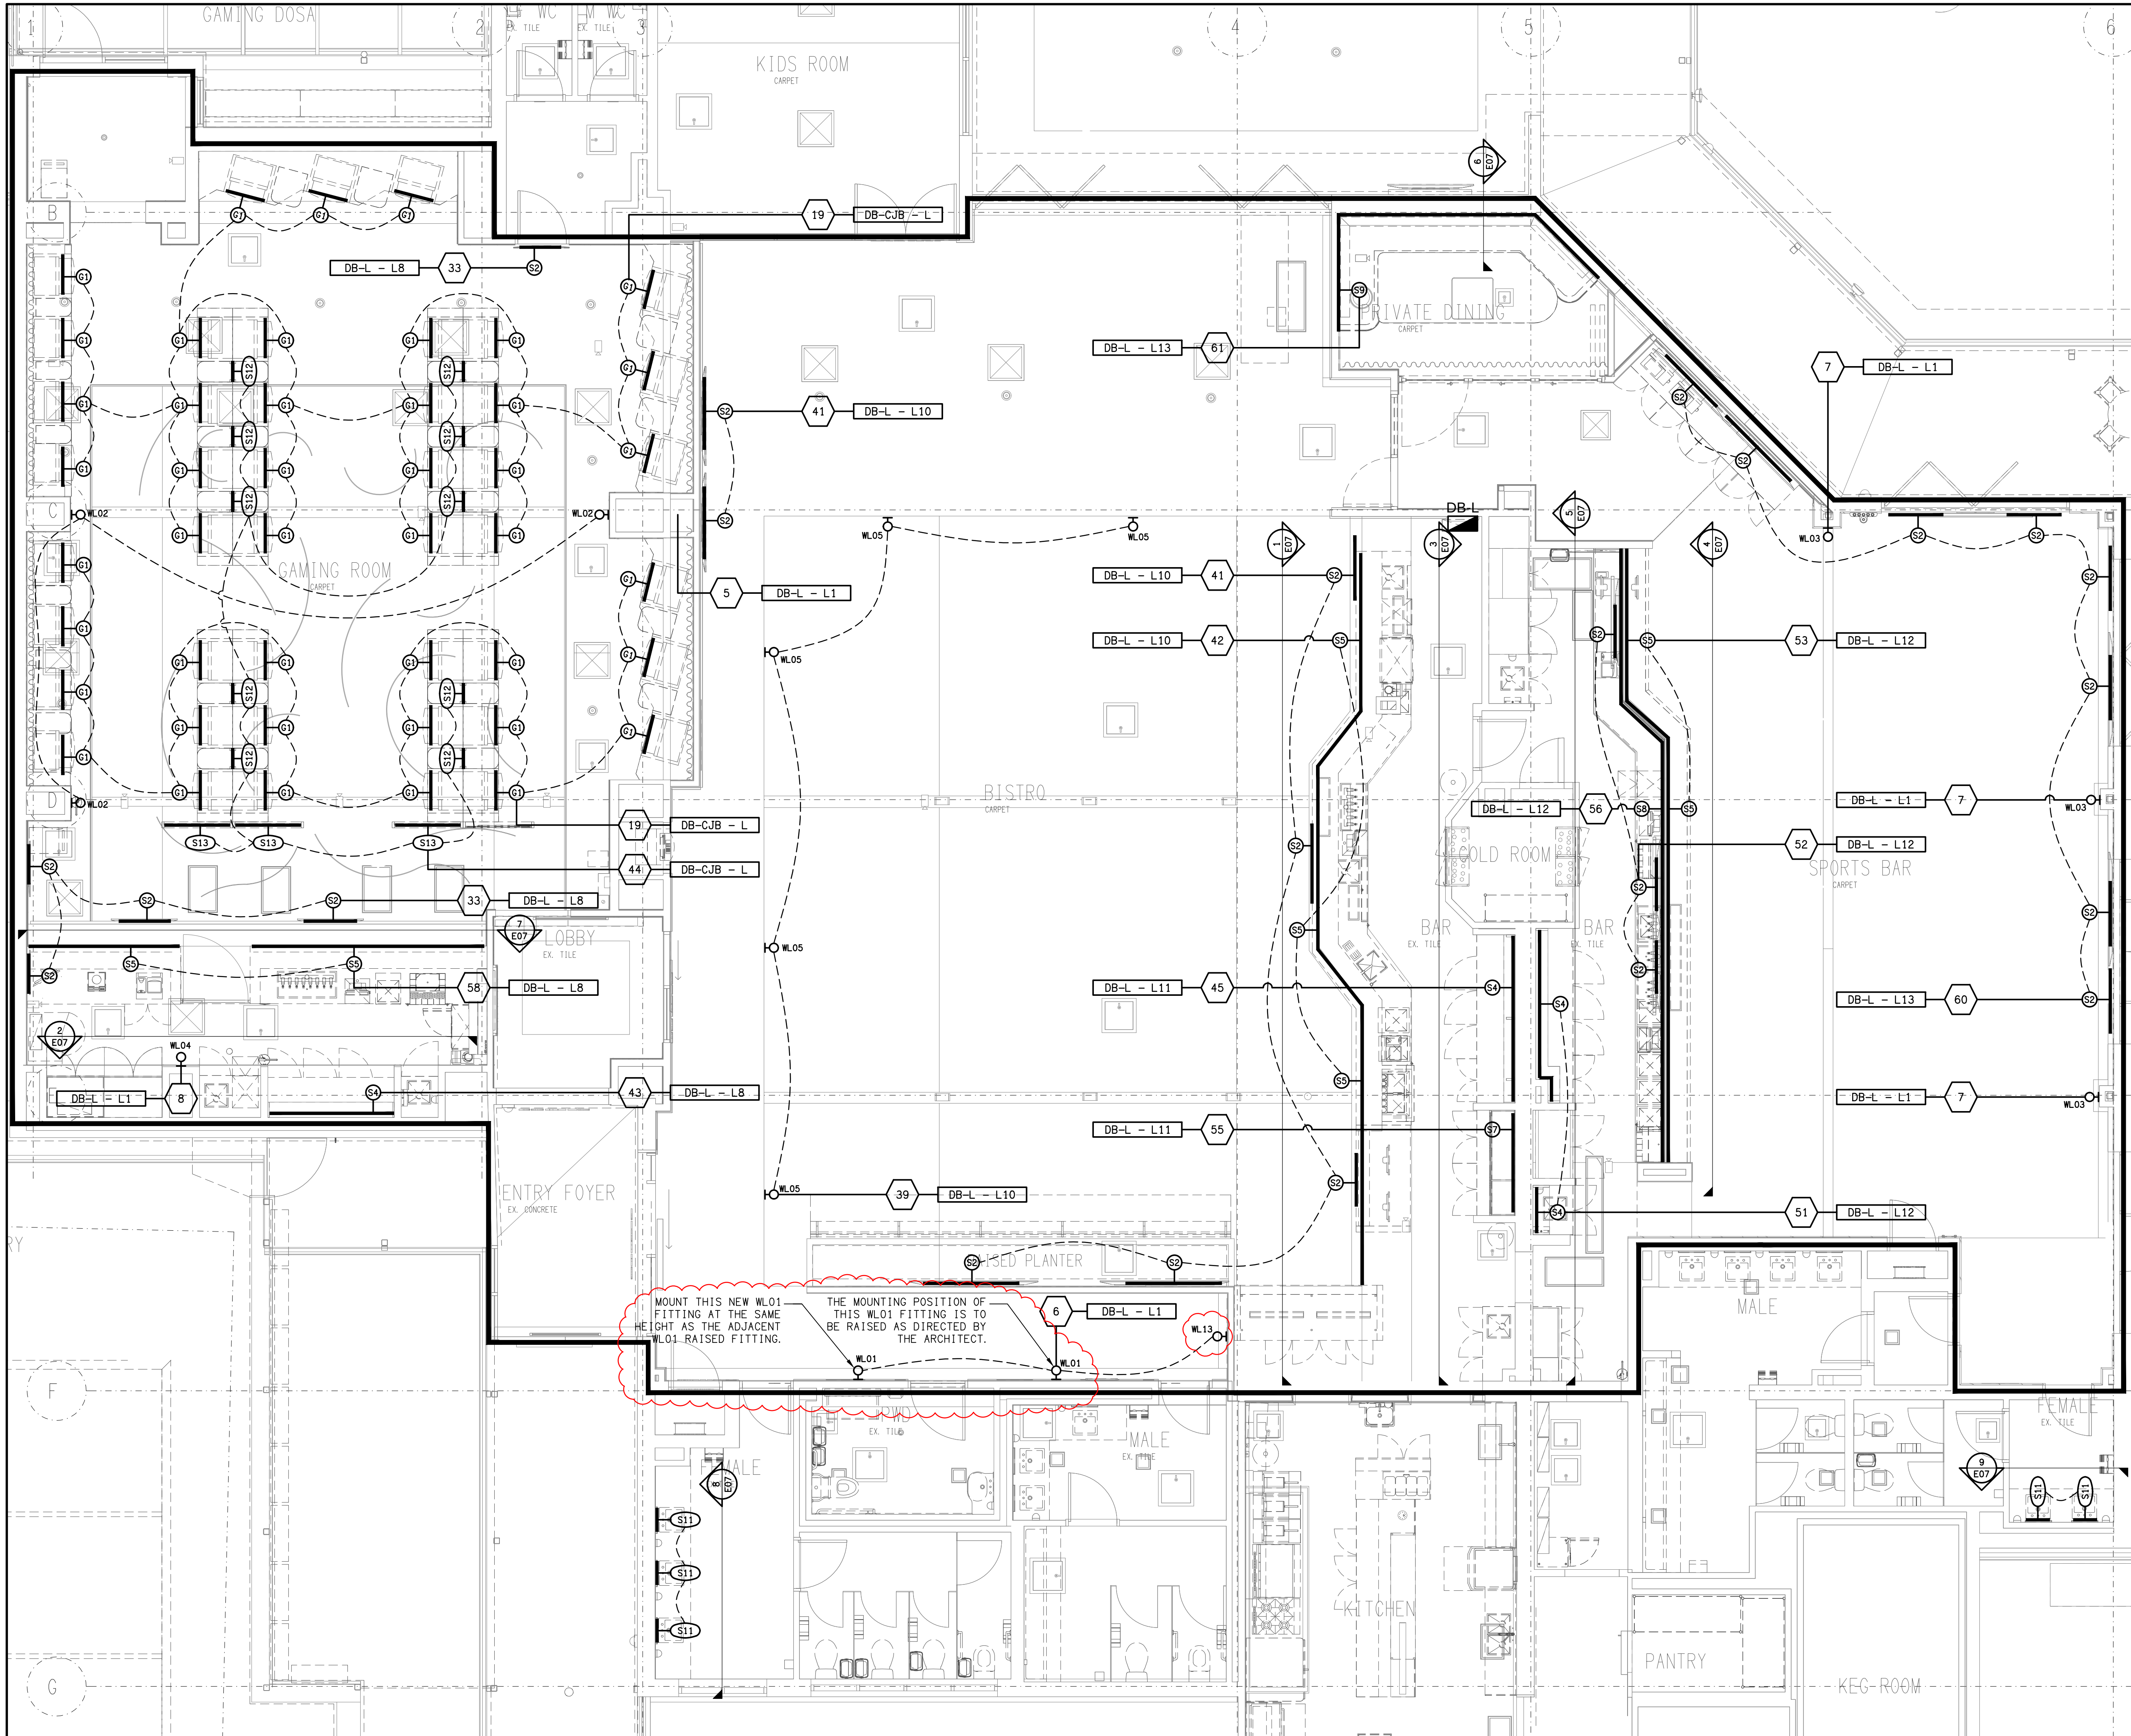

THE COPYRIGHT OF THIS DRAWING REMAINS THE PROPERTY OF THE ELECTRICAL DESIGN GROUP.

USE FIGURED DIMENSIONS IN PREFERENCE TO SCALE.

ALL DIMENSIONS TO BE VERIFIED ONSITE.

F	CONSTRUCTION	21/08/2026
REV.	DESCRIPTION:	DATE:

ELECTRICAL DESIGN GROUP
ELECTRICAL BUILDING SERVICES CONSULTANTS

BRISBANE: P.O. Box 15 Sherwood Qld 4075
Phone: (07) 3278 4375
Email: brisbane@edg.net.au
Web: www.edg.net.au

ELECTRICAL DESIGN GROUP BRISBANE
PTY LTD
ACN 092 710 793

TRADING AS:
ELECTRICAL DESIGN
GROUP

PROJECT:
JIMBOOMBA TAVERN

SITE ADDRESS:
**CORNER MT LINDESAY HIGHWAY &
CUSACKS LANE, JIMBOOMBA**

SCALE: 1:50
SHEET SIZE: AT A1

DRAWING TITLE:

**ELECTRICAL SERVICES
JOINERY & WALL
LIGHTING PLAN**

PROJECT NO. DRAWING NO. REVISION:

C3630a E06 F