


NOTE:
--- R --- EXISTING CONDUITS TO BE REMOVED.

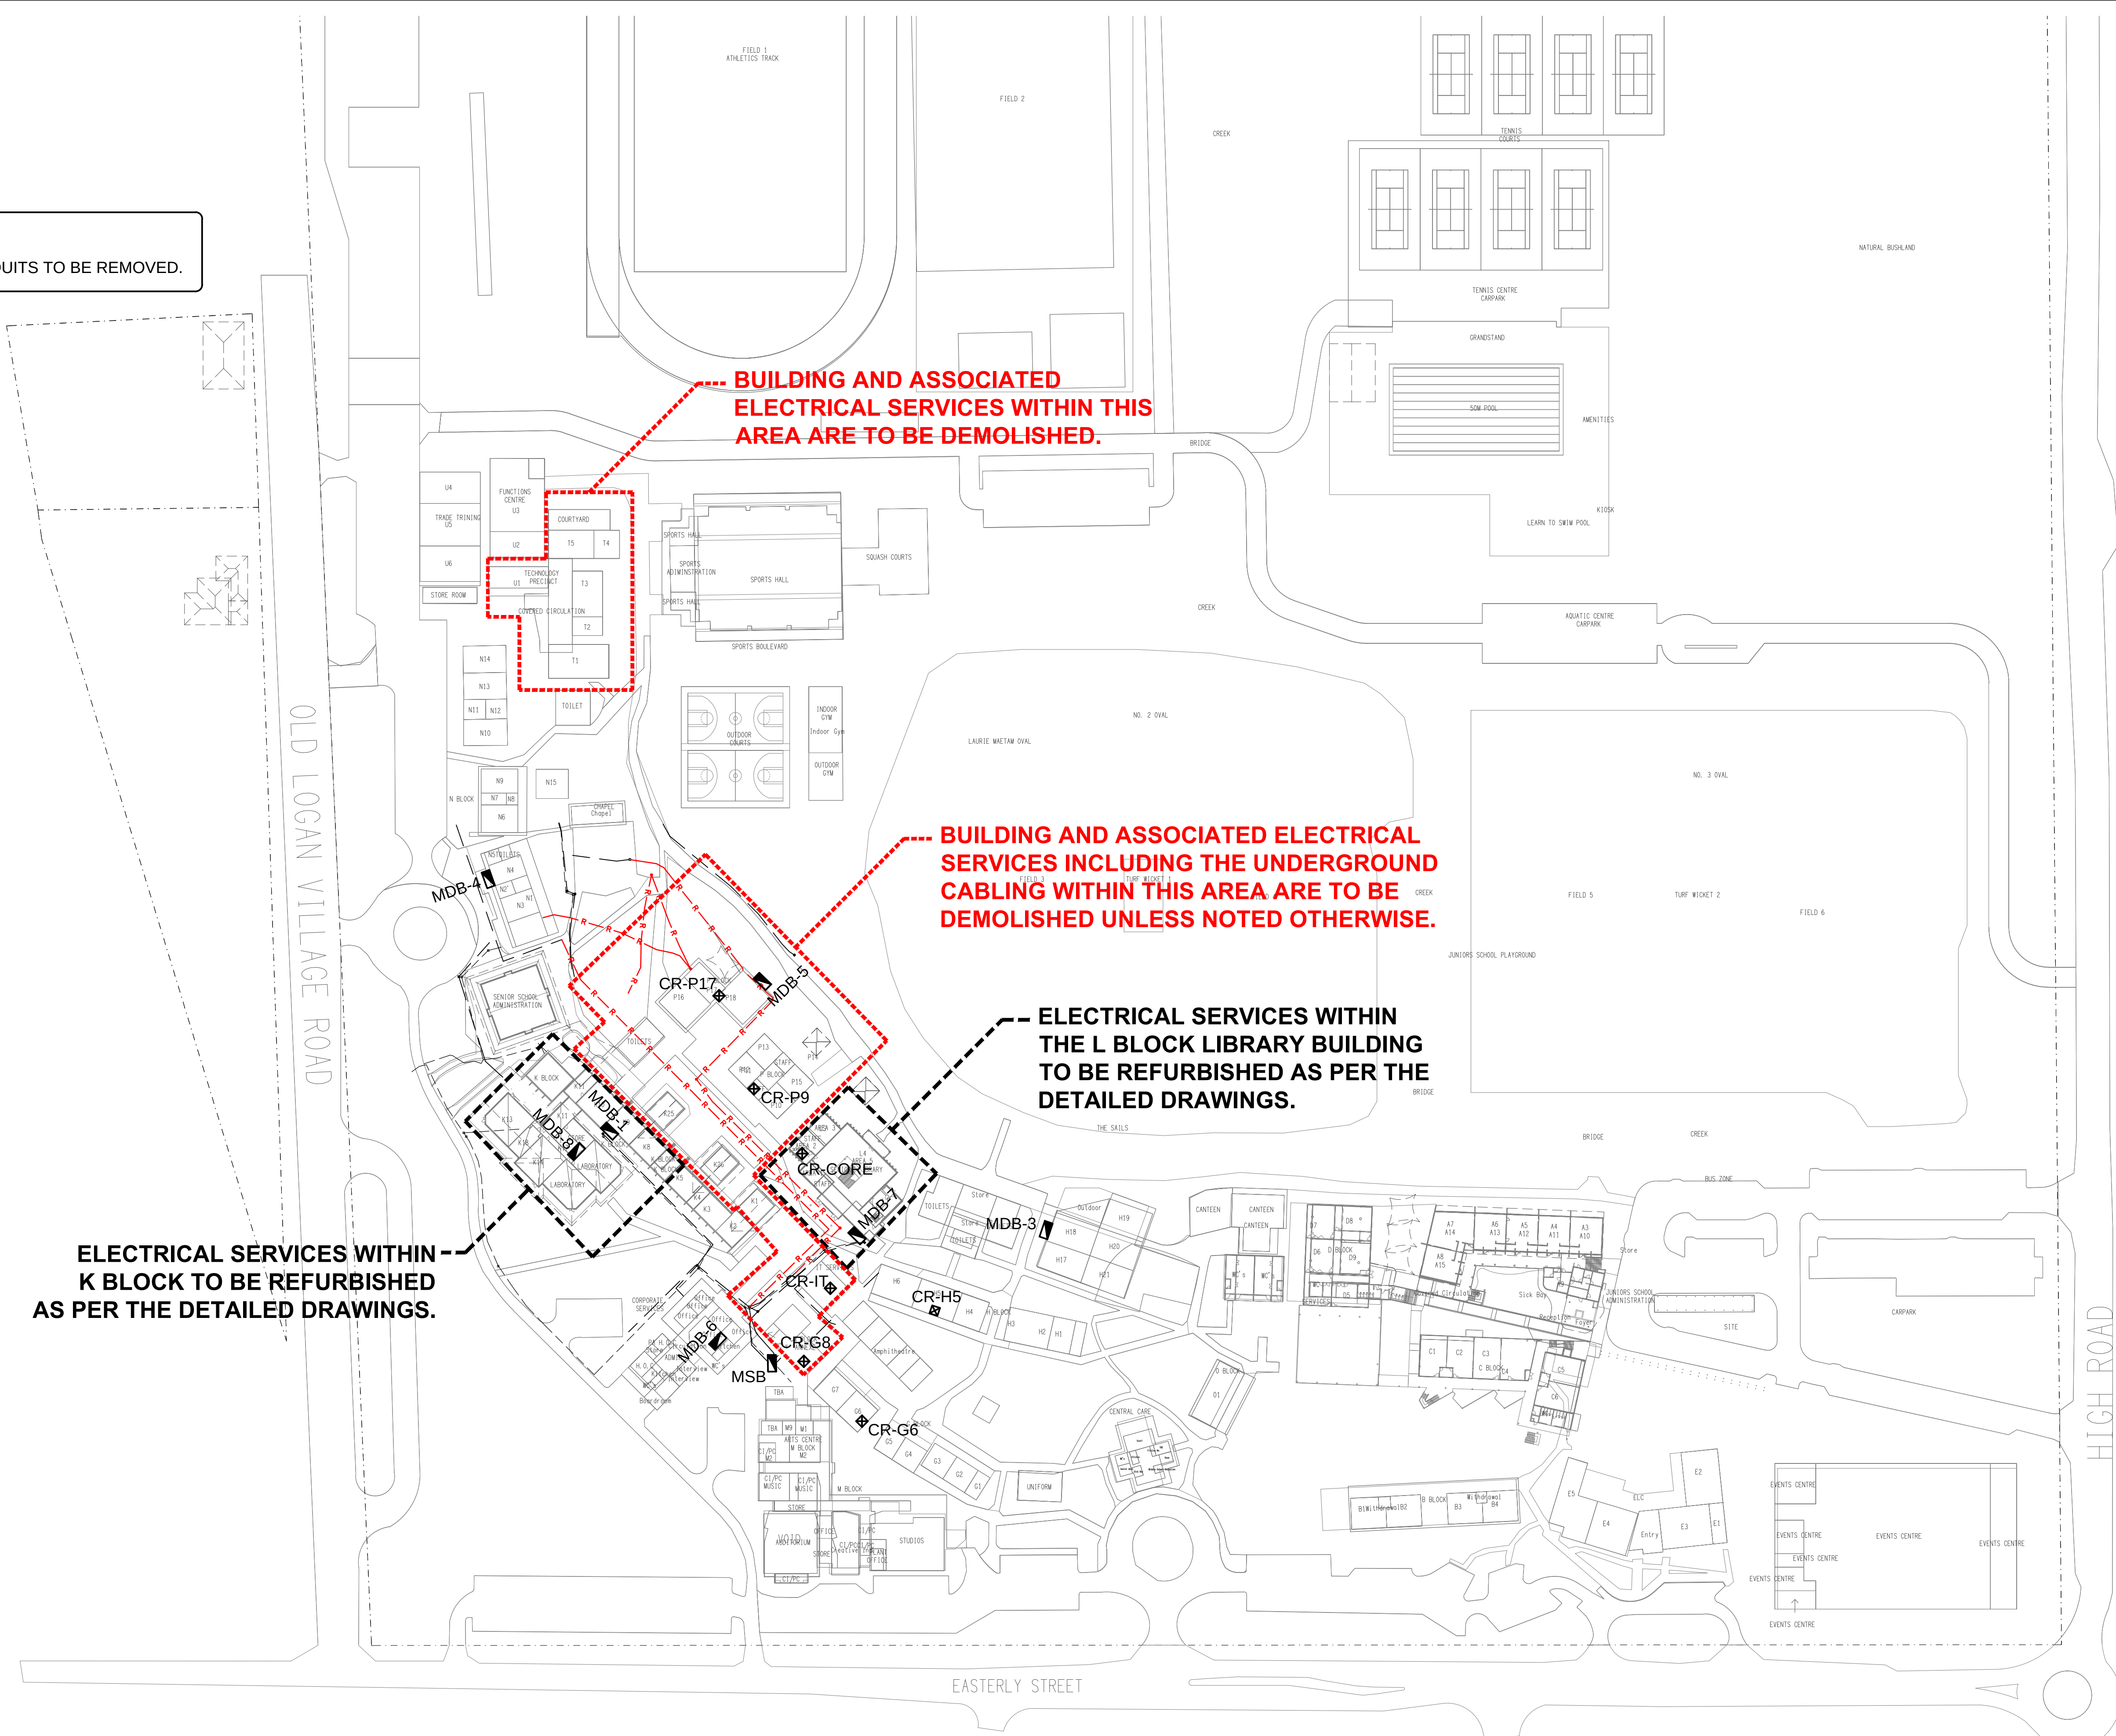

ELECTRICAL DESIGN GROUP BRISBANE
PTY LTD
ACN 092 710 793
TRADING AS:
ELECTRICAL DESIGN GROUP

THE COPYRIGHT OF THIS DRAWING
REMAINS THE PROPERTY OF THE
ELECTRICAL DESIGN GROUP.
USE FIGURED DIMENSIONS
IN PREFERENCE TO SCALE.
ALL DIMENSIONS TO BE
VERIFIED ONSITE.

ELECTRICAL DESIGN GROUP
ELECTRICAL BUILDING SERVICES CONSULTANTS
BRISBANE GOLD COAST

P.O. Box 15, Sherwood Q. 4075
Phone: (07) 3278 4375
Email: brisbane@edg.net.au
Web: www.edg.net.au

PROJECT:
CANTERBURY COLLEGE SENIOR SCHOOL
TALNGAI PRECINCT

182 OLD LOGAN VILLAGE ROAD, WATERFORD

T1	TENDER	14/08/2026
REV.	DESCRIPTION:	DATE:

DRAWING:
**ELECTRICAL SERVICES
EXISTING SITE PLAN**

SCALE:
1:1000

AT A1

PROJECT NO:
C3631a

DRAWING NO:
E05

REVISION:
T1