


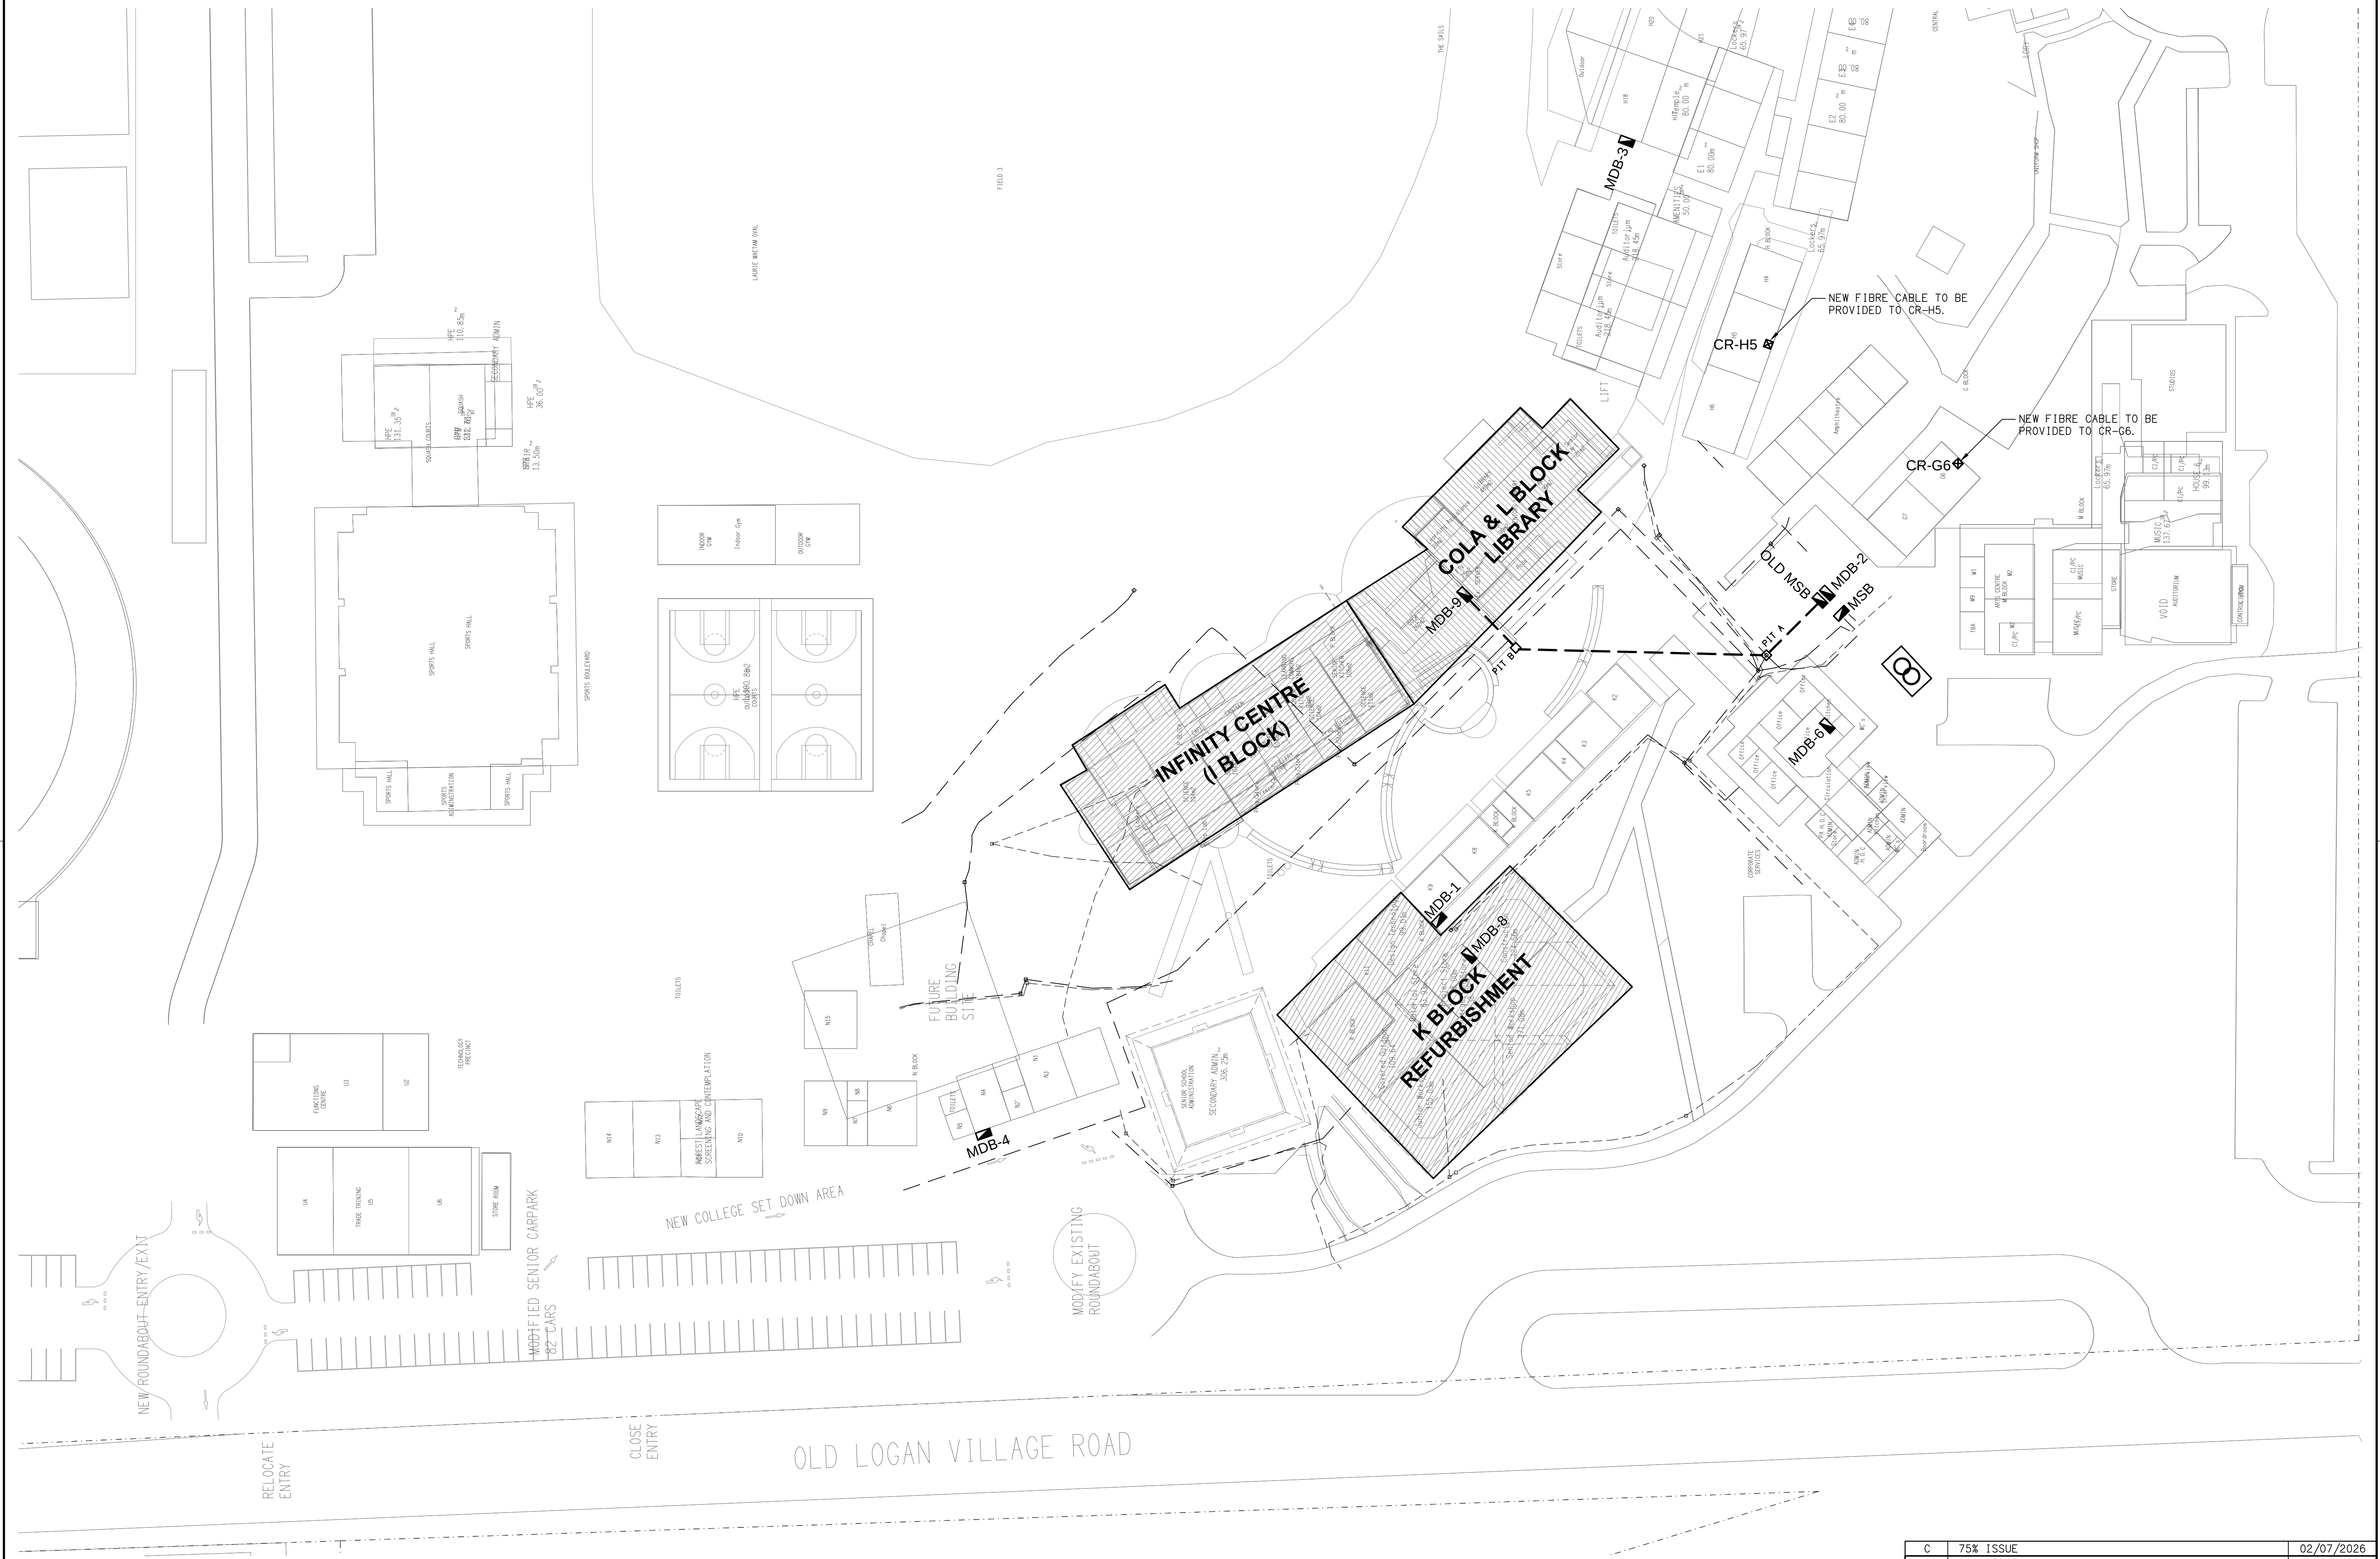

ELECTRICAL DESIGN GROUP BRISBANE PTY LTD ACN 092 710 793 TRADING AS: ELECTRICAL DESIGN GROUP	THE COPYRIGHT OF THIS DRAWING REMAINS THE PROPERTY OF THE ELECTRICAL DESIGN GROUP.	 ELECTRICAL DESIGN GROUP ELECTRICAL BUILDING SERVICES CONSULTANTS BRISBANE GOLD COAST P.O. Box 15, Sherwood Q.4075 Phone: (07) 3278 4375 Email: brisbane@edg.net.au Web: www.edg.net.au	PROJECT: CANTERBURY COLLEGE SENIOR SCHOOL TALNGAI PRECINCT	REV: DESCRIPTION: DATE:			
	USE FIGURED DIMENSIONS IN PREFERENCE TO SCALE.		182 OLD LOGAN VILLAGE ROAD, WATERFORD	DRAWING: ELECTRICAL SERVICES PROPOSED PART SITE PLAN			
	ALL DIMENSIONS TO BE VERIFIED ONSITE.			SCALE: 1:500 AT A1	PROJECT NO: C3631a	DRAWING NO: E07	REVISION: C