


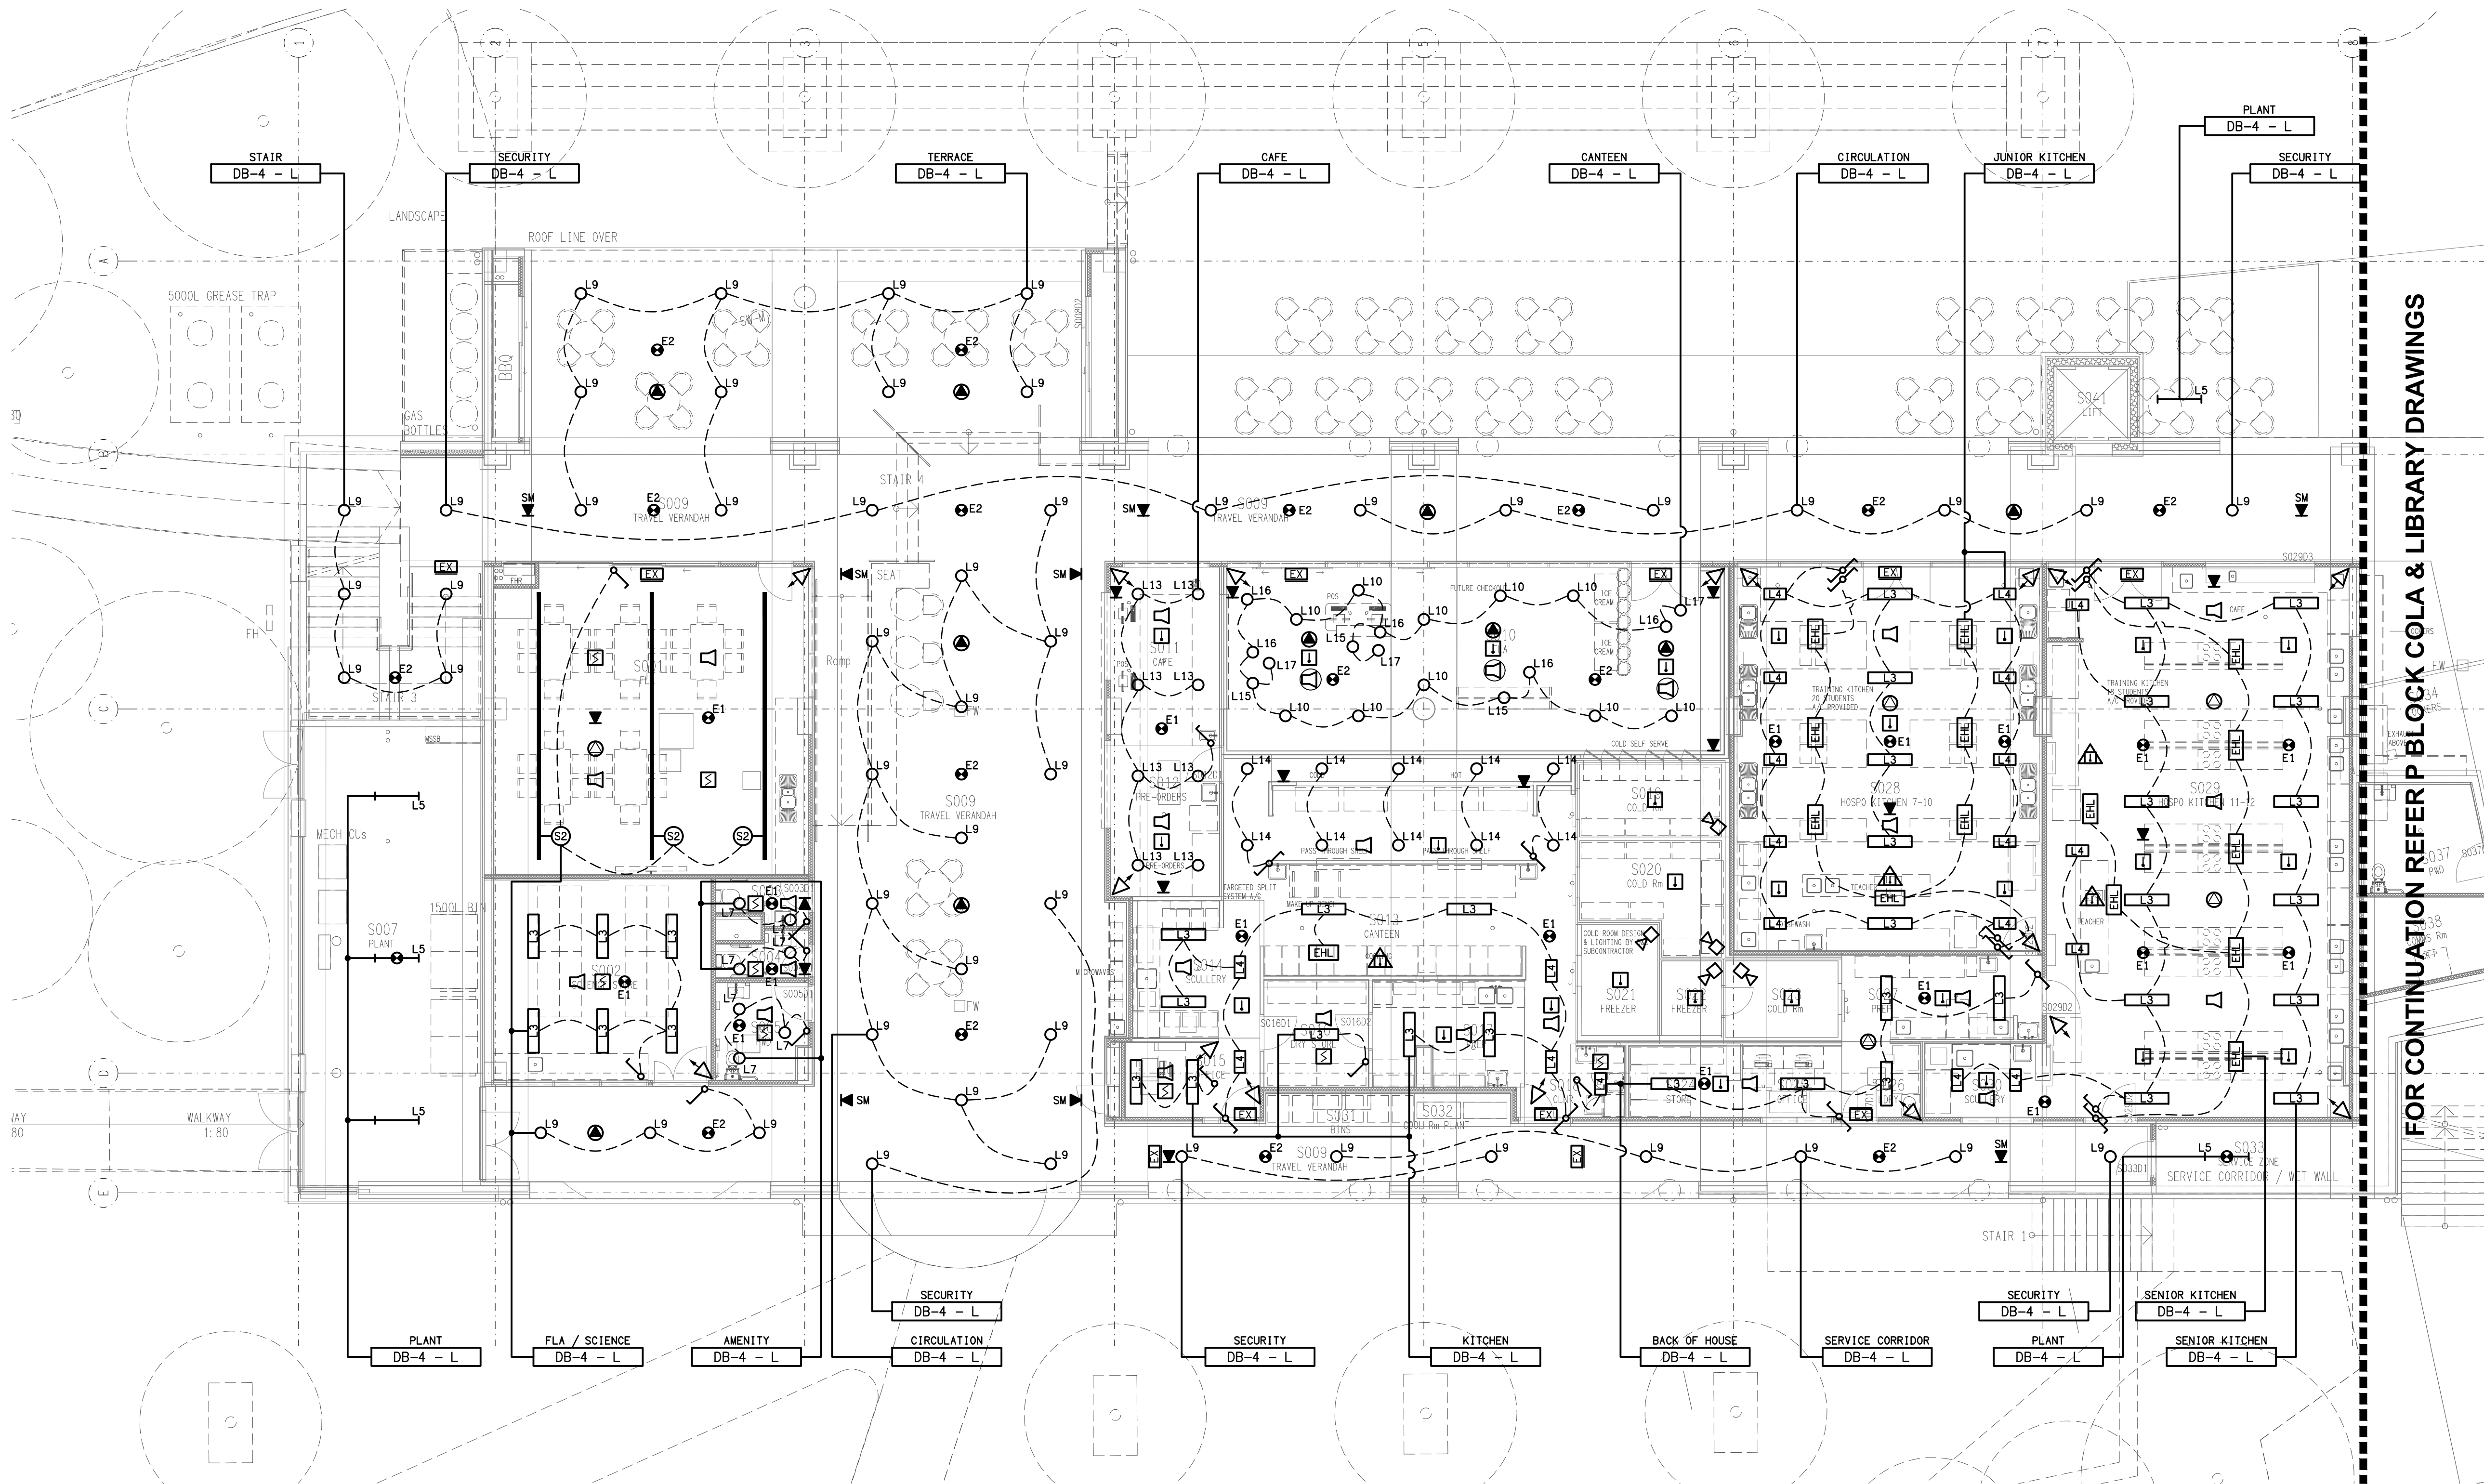

FOR CONTINUATION REFER P BLOCK COLA & LIBRARY DRAWINGS

ELECTRICAL DESIGN GROUP BRISBANE
PTY LTD
ACN 092 710 793
TRADING AS:
ELECTRICAL DESIGN GROUP

THE COPYRIGHT OF THIS DRAWING
REMAINS THE PROPERTY OF THE
ELECTRICAL DESIGN GROUP.
USE FIGURED DIMENSIONS
IN PREFERENCE TO SCALE.
ALL DIMENSIONS TO BE
VERIFIED ONSITE.

ELECTRICAL DESIGN GROUP
ELECTRICAL BUILDING SERVICES CONSULTANTS
BRISBANE GOLD COAST

P.O. Box 15, Sherwood Q, 4075
Phone: (07) 3278 4375
Email: brisbane@edg.net.au
Web: www.edg.net.au

PROJECT:
CANTERBURY COLLEGE SENIOR SCHOOL
TALNGAI PRECINCT

182 OLD LOGAN VILLAGE ROAD, WATERFORD

C	75% ISSUE	02/07/2026
REV:	DESCRIPTION:	DATE:

DRAWING: ELECTRICAL SERVICES INFINITY CENTRE (I BLOCK) LOWER GROUND REFLECTED CEILING PLAN	PROJECT NO:	DRAWING NO: E13	REVISION: C
SCALE: 1:100	AT A1	C3631a	