


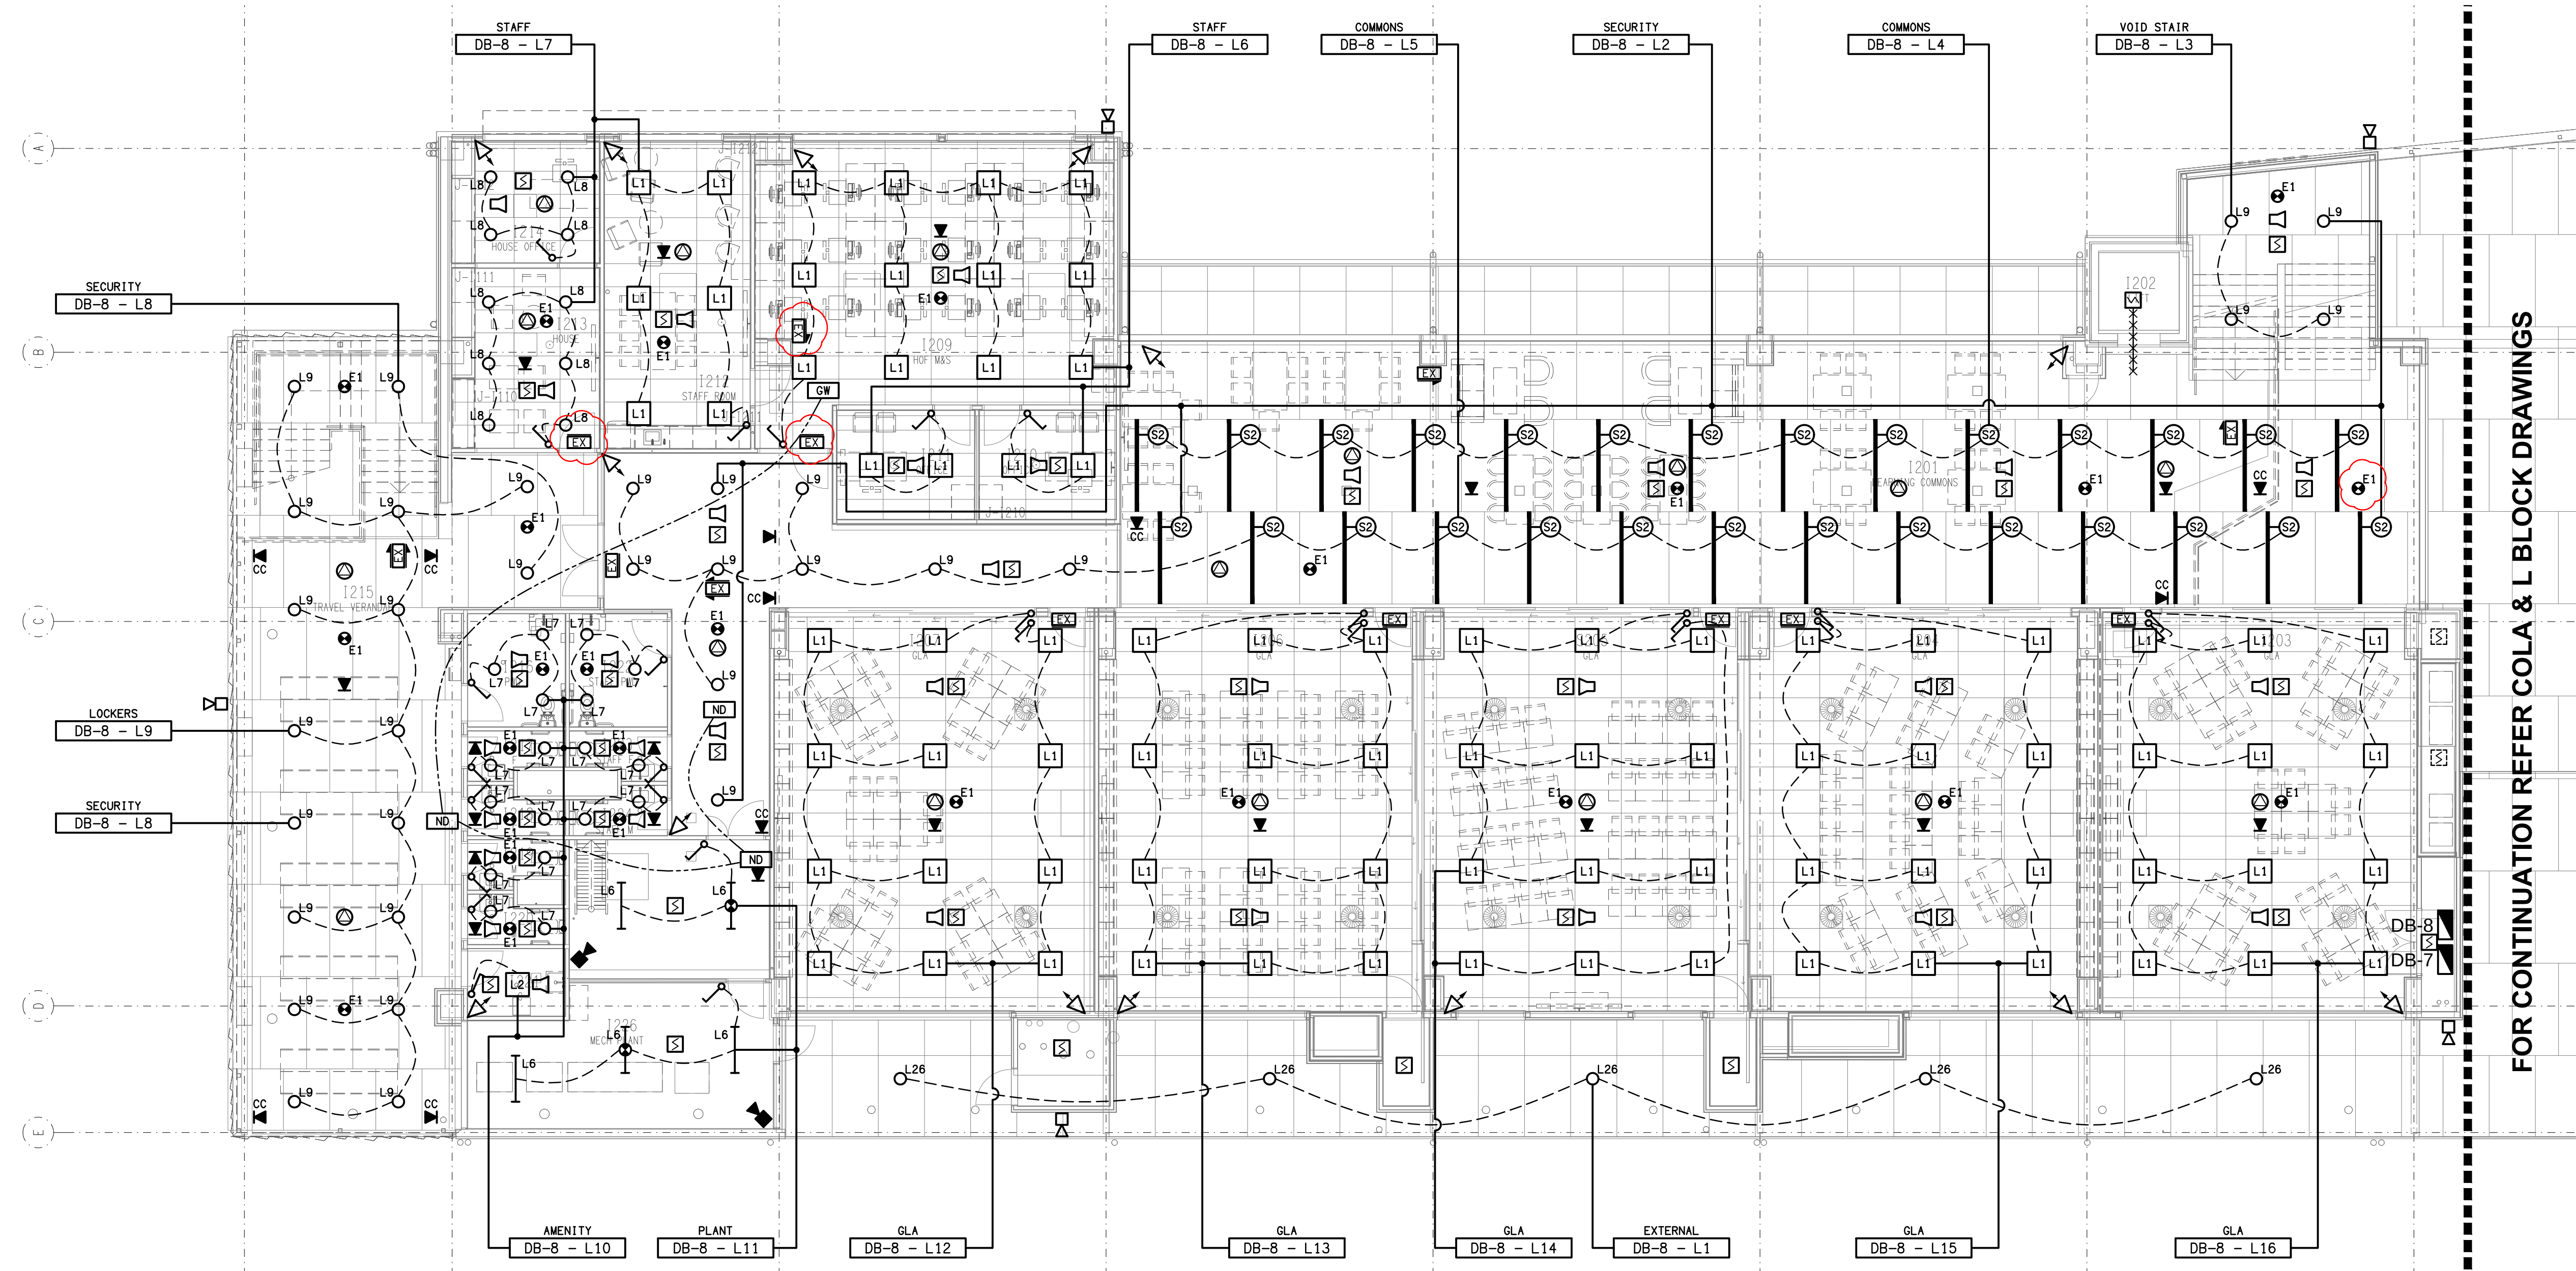

FOR CONTINUATION REFER COLA & L BLOCK DRAWINGS

ELECTRICAL DESIGN GROUP BRISBANE
PTY LTD
ACN 092 710 793
TRADING AS:
ELECTRICAL DESIGN GROUP

THE COPYRIGHT OF THIS DRAWING
REMAINS THE PROPERTY OF THE
ELECTRICAL DESIGN GROUP.
USE FIGURED DIMENSIONS
IN PREFERENCE TO SCALE.
ALL DIMENSIONS TO BE
VERIFIED ONSITE.

ELECTRICAL DESIGN GROUP
ELECTRICAL BUILDING SERVICES CONSULTANTS
BRISBANE GOLD COAST

P.O. Box 15, Sherwood Q. 4075
Phone: (07) 3278 4375
Email: brisbane@edg.net.au
Web: www.edg.net.au

PROJECT:
CANTERBURY COLLEGE SENIOR SCHOOL
TALNGAI PRECINCT

182 OLD LOGAN VILLAGE ROAD, WATERFORD

T2	TENDER	21/08/2026
REV.	DESCRIPTION:	DATE:

DRAWING:	PROJECT NO:	DRAWING NO:	REVISION:
ELECTRICAL SERVICES INFINITY CENTRE (I BLOCK) LEVEL 1 REFLECTED CEILING PLAN			
SCALE:	AT	C3631a	E17
1:100 UNO	A1		T2