
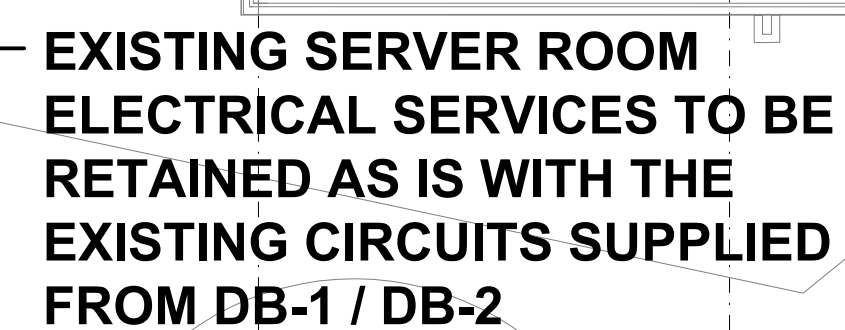


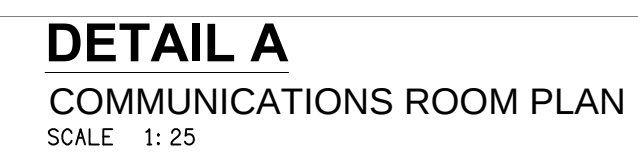

ELECTRICAL DESIGN GROUP BRISBANE PTY LTD ACN 092 710 793 TRADING AS: ELECTRICAL DESIGN GROUP	THE COPYRIGHT OF THIS DRAWING REMAINS THE PROPERTY OF THE ELECTRICAL DESIGN GROUP. USE FIGURED DIMENSIONS IN PREFERENCE TO SCALE. ALL DIMENSIONS TO BE VERIFIED ONSITE.	 ELECTRICAL DESIGN GROUP ELECTRICAL BUILDING SERVICES CONSULTANTS BRISBANE GOLD COAST P.O.Box 15, Sherwood Q.4075 Phone: (07) 3278 4375 Email: brisbane@edg.net.au Web: www.edg.net.au	PROJECT: CANTERBURY COLLEGE SENIOR SCHOOL TALNGAI PRECINCT 182 OLD LOGAN VILLAGE ROAD, WATERFORD	DRAWING: ELECTRICAL SERVICES COLA & L BLOCK LOWER GROUND FLOOR PLAN SCALE: 1:100 UNO AT A1	PROJECT NO: C3631a	DRAWING NO: E21	REVISION: C
--	--	--	---	--	---	--------------------------------------	----------------------------------