



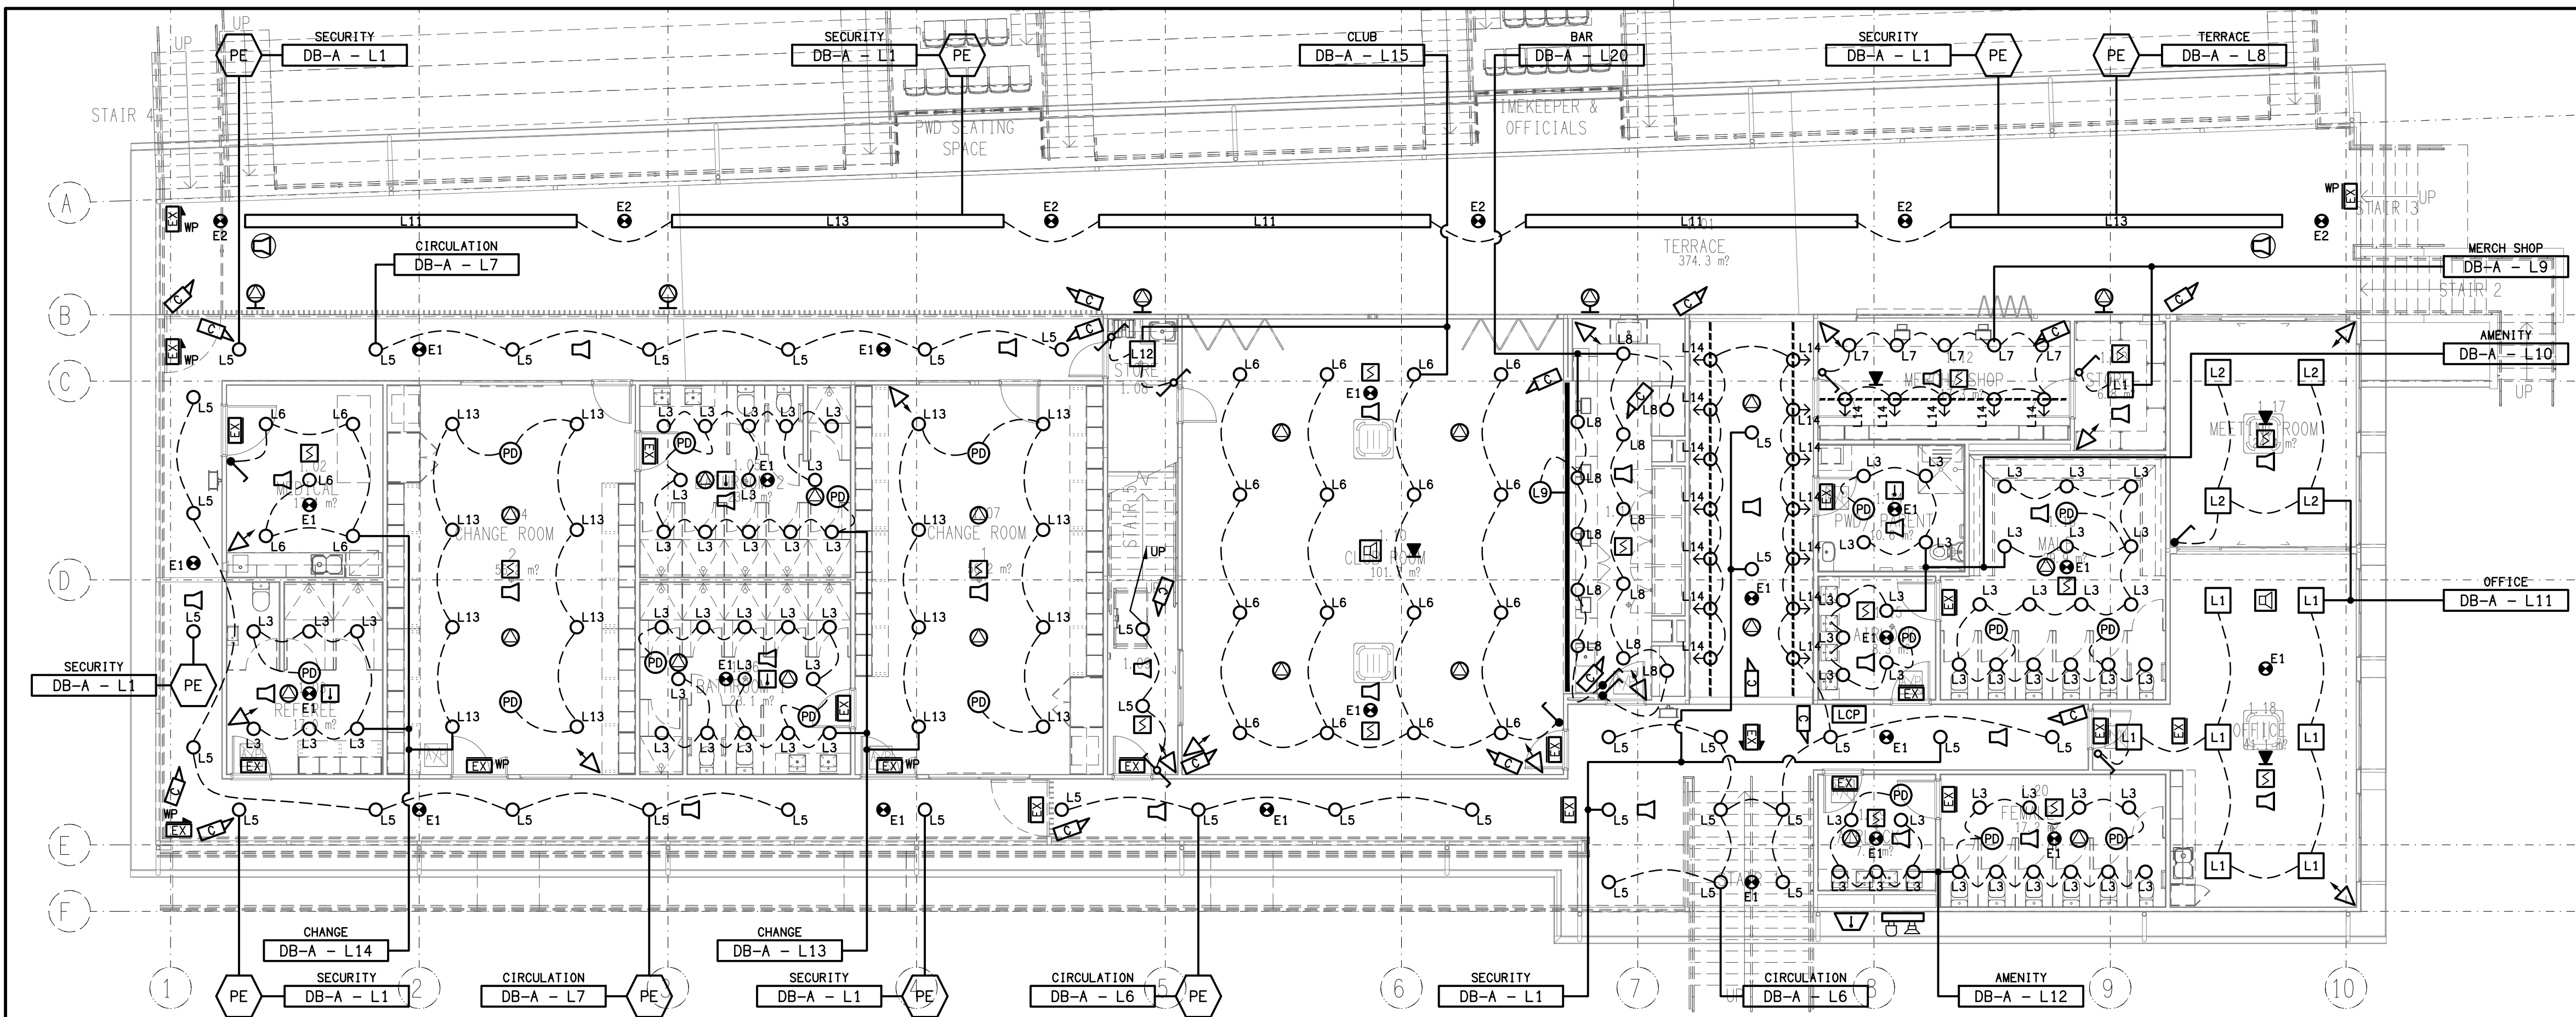


REFLECTED CEILING PLAN

LEVEL 1
SCALE 1: 100

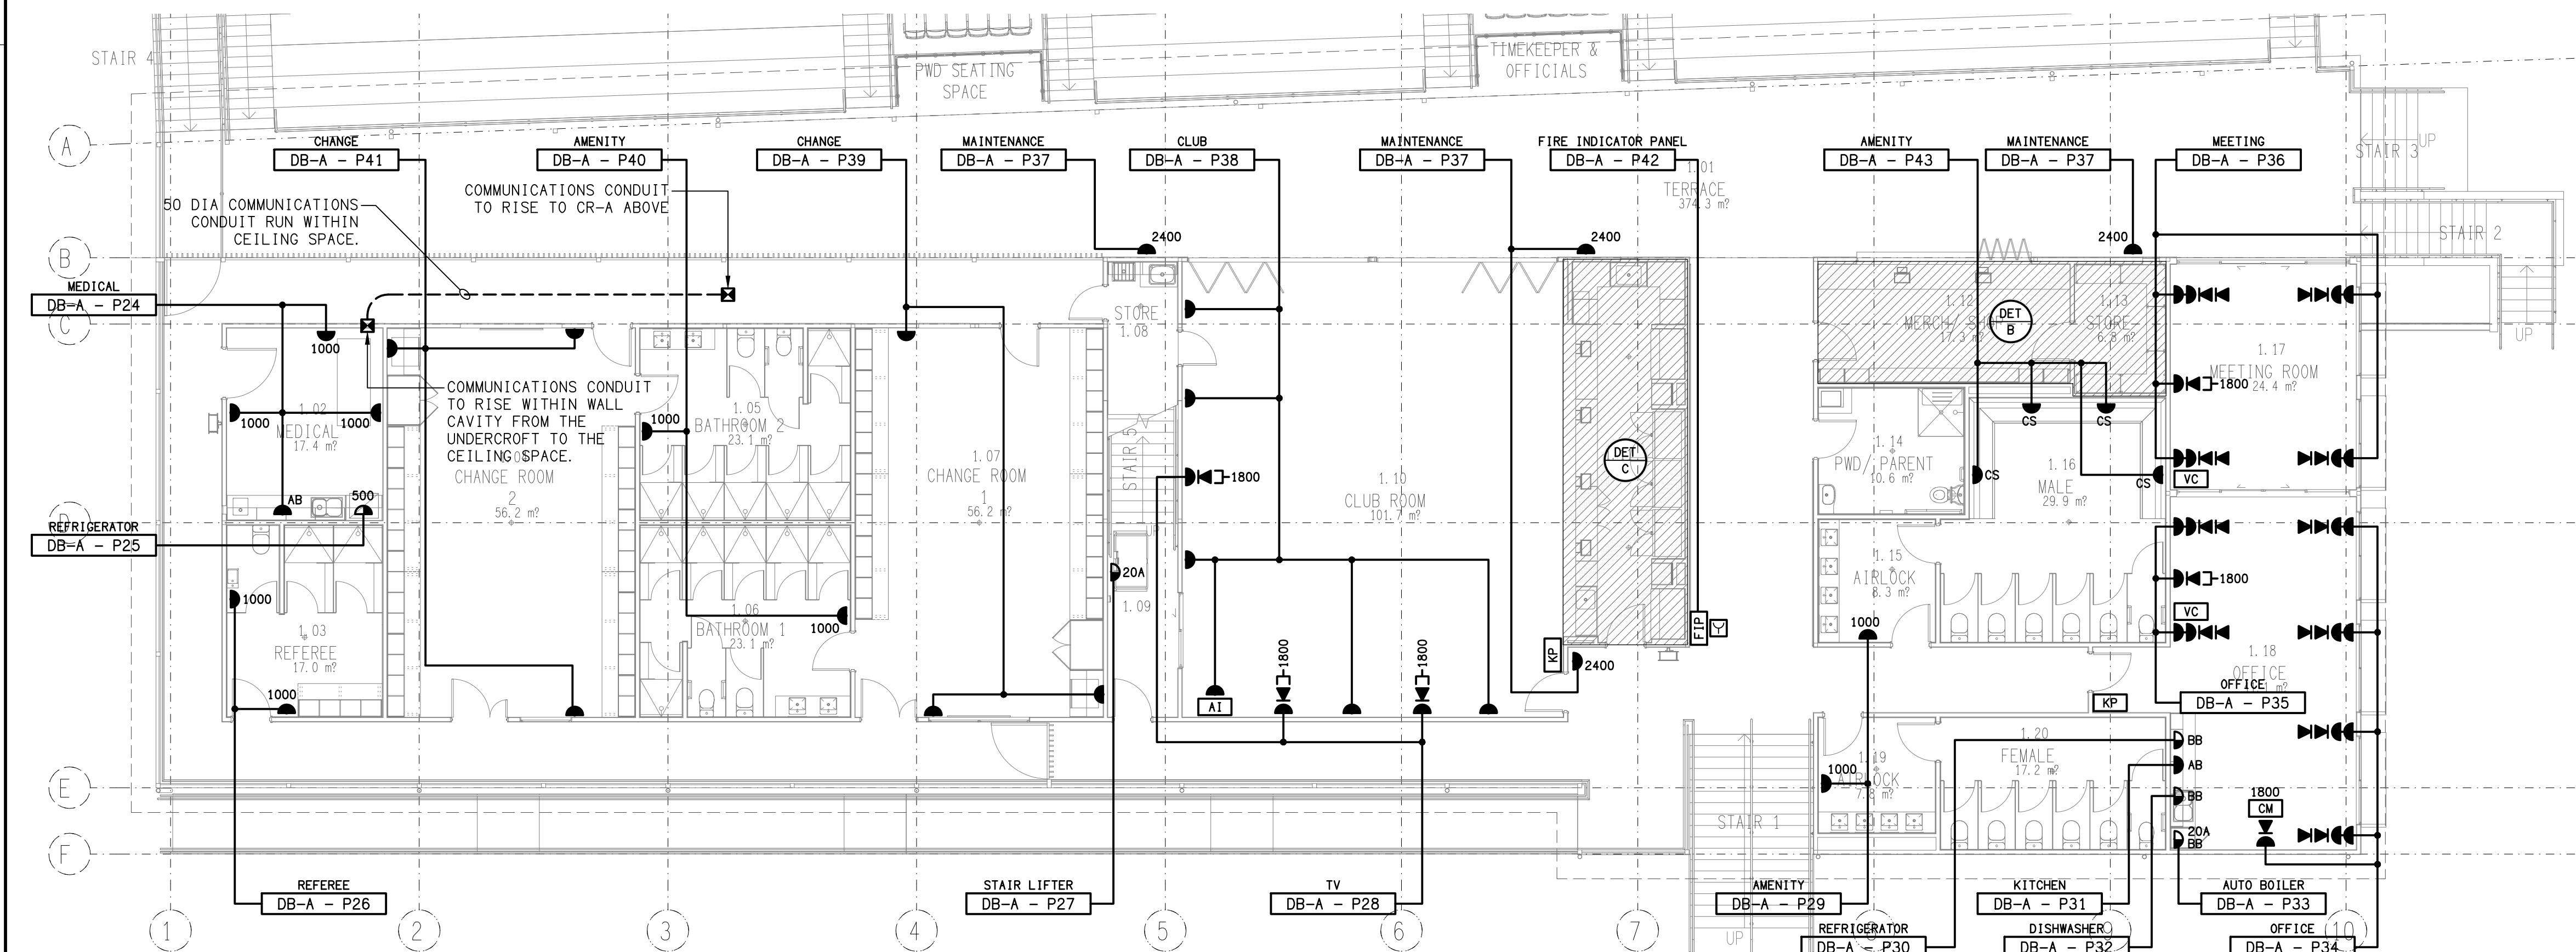


FLOOR PLAN

LEVEL 1
SCALE 1: 100

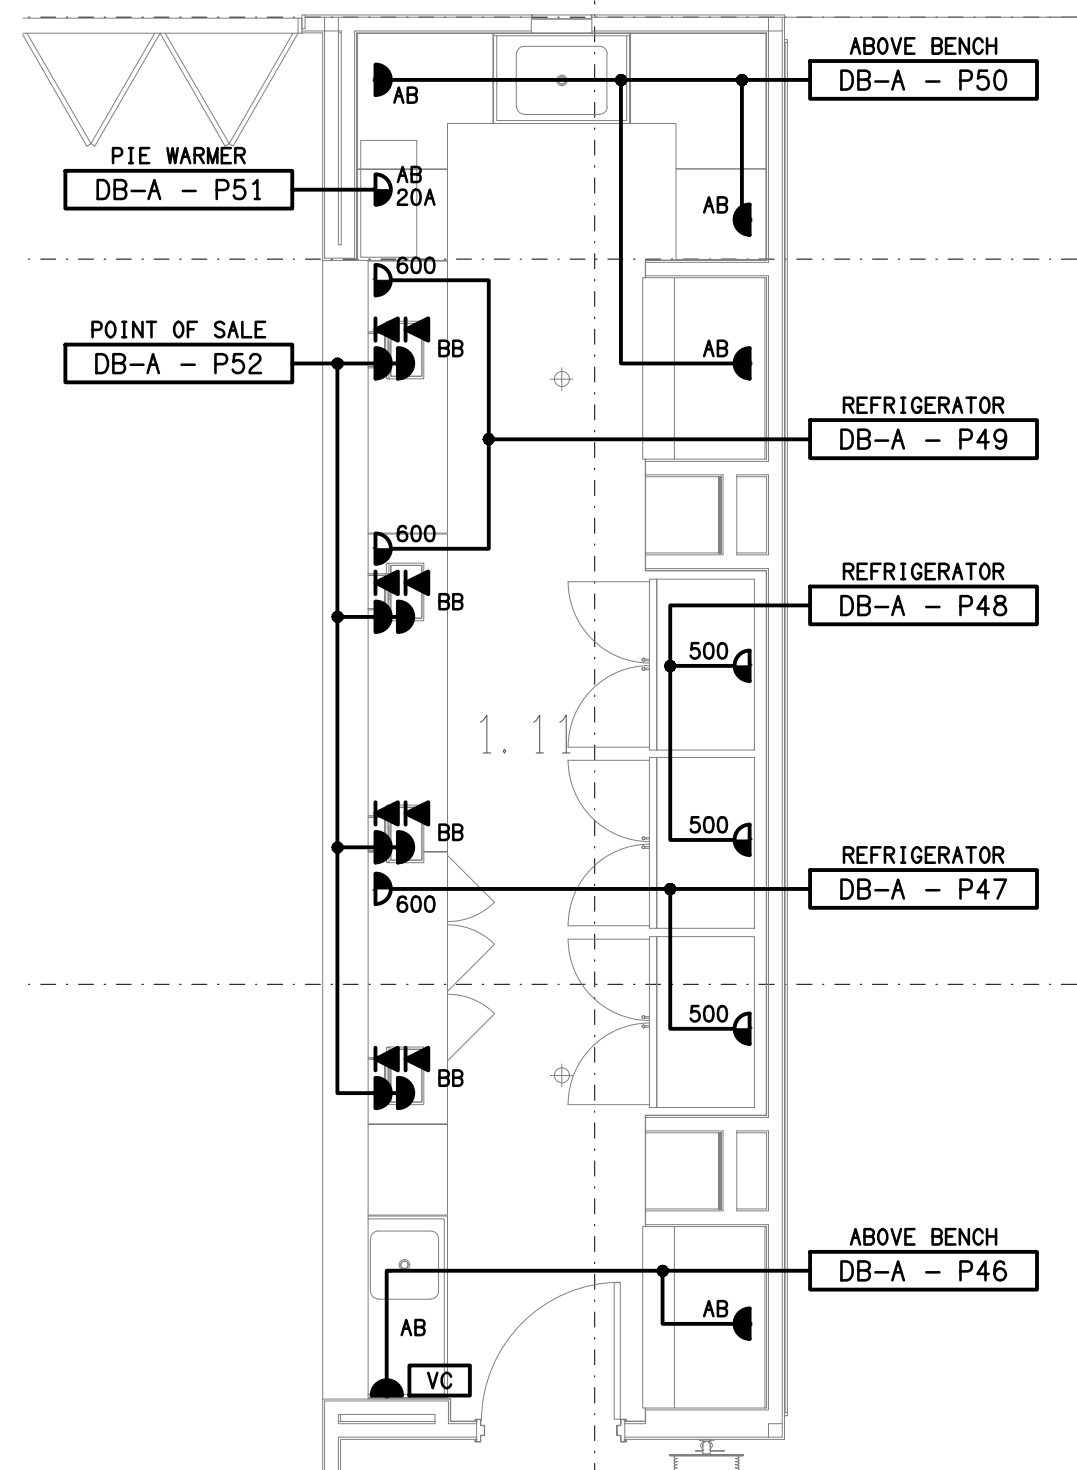

DETAIL C
CLUB ROOM BAR FLOOR PLAN

SCALE 1: 50

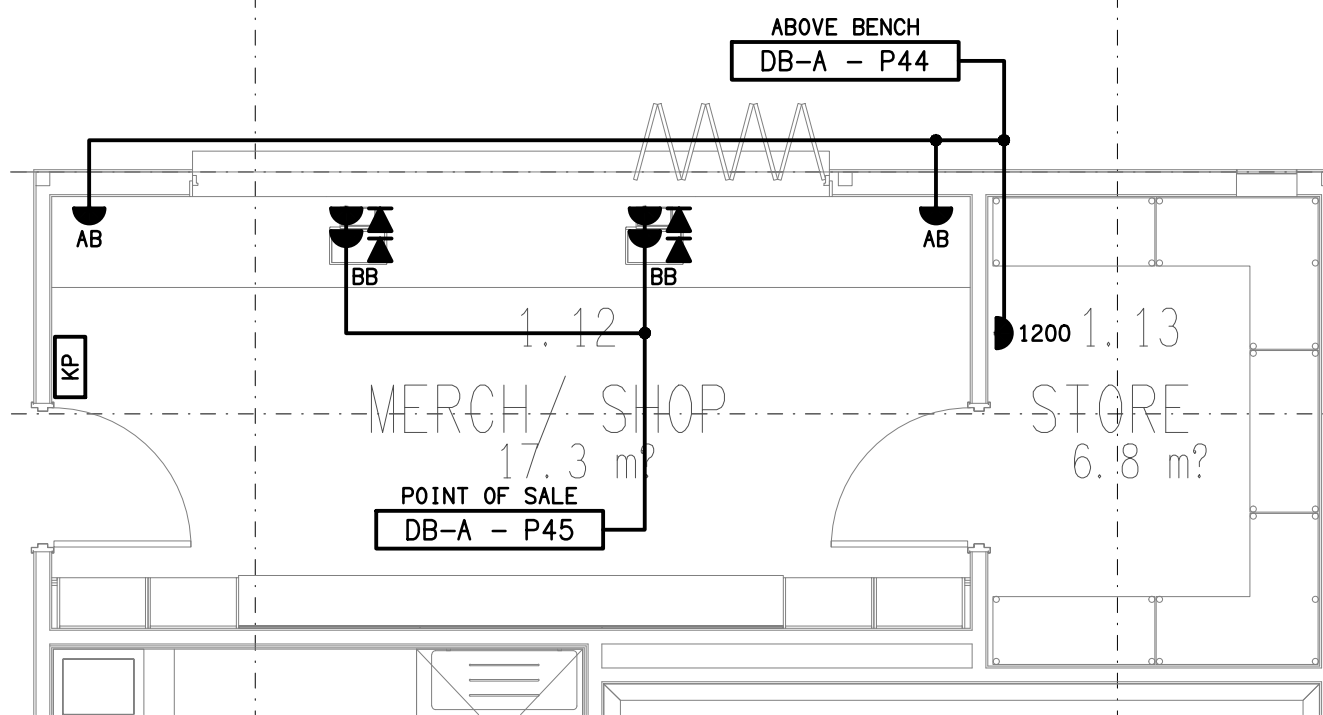

DETAIL B
MERCH SHOP FLOOR PLAN

SCALE 1: 50

ELECTRICAL DESIGN GROUP BRISBANE
PTY LTD
ACN 092 710 793
TRADING AS:
ELECTRICAL DESIGN GROUP

THE COPYRIGHT OF THIS DRAWING
REMAINS THE PROPERTY OF THE
ELECTRICAL DESIGN GROUP.

USE FIGURED DIMENSIONS
IN PREFERENCE TO SCALE.

ALL DIMENSIONS TO BE
VERIFIED ON SITE.

ELECTRICAL DESIGN GROUP
ELECTRICAL BUILDING SERVICES CONSULTANTS
BRISBANE GOLD COAST

P.O. Box 15, Sherwood Q. 4075
Phone: (07) 3278 4375
Email: brisbane@edg.net.au
Web: www.edg.net.au

PROJECT:
BROTHERS RUGBY CLUB - REDEVELOPMENT

103 CROSBY ROAD, ALBION, QUEENSLAND

B	TENDER	07/08/2026
REV.	DESCRIPTION:	DATE:

DRAWING:
**ELECTRICAL SERVICES
LEVEL 1 PLANS**

SCALE:
1:100 UNO

AT A1

PROJECT NO:
C3657a

DRAWING NO:
E07

REVISION:
B