



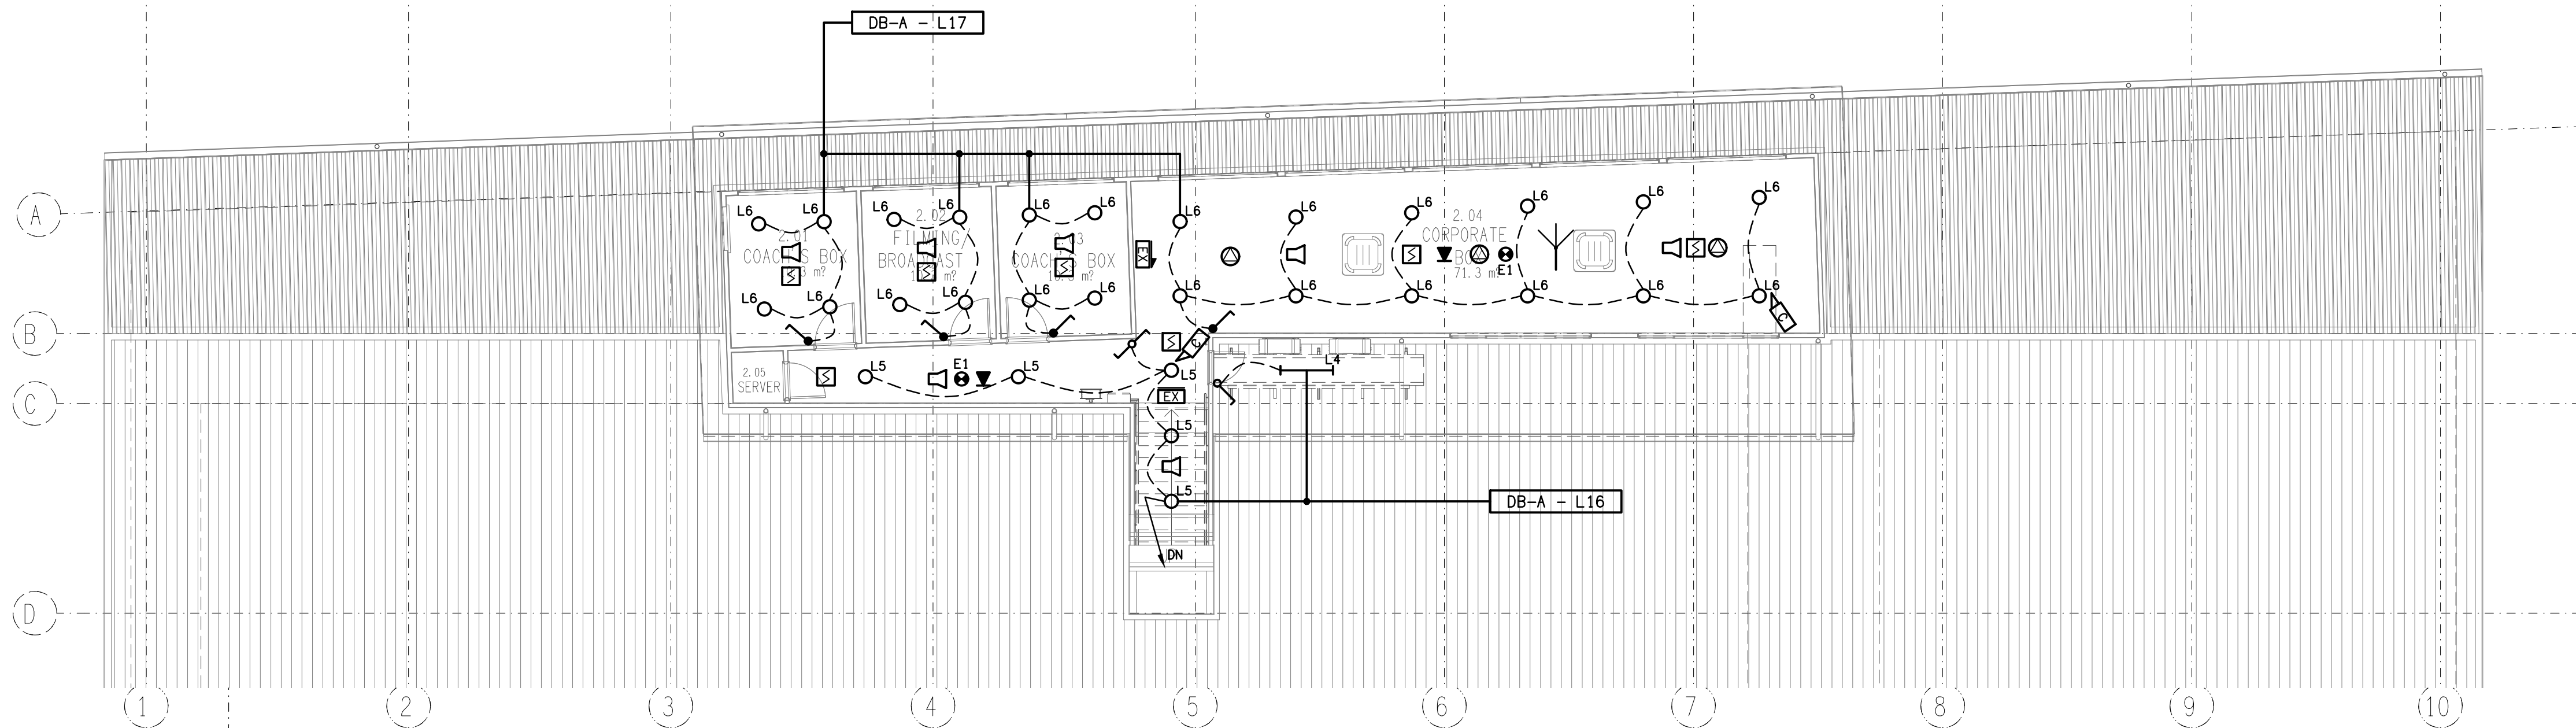

REFLECTED CEILING PLAN
LEVEL 2
SCALE 1: 100

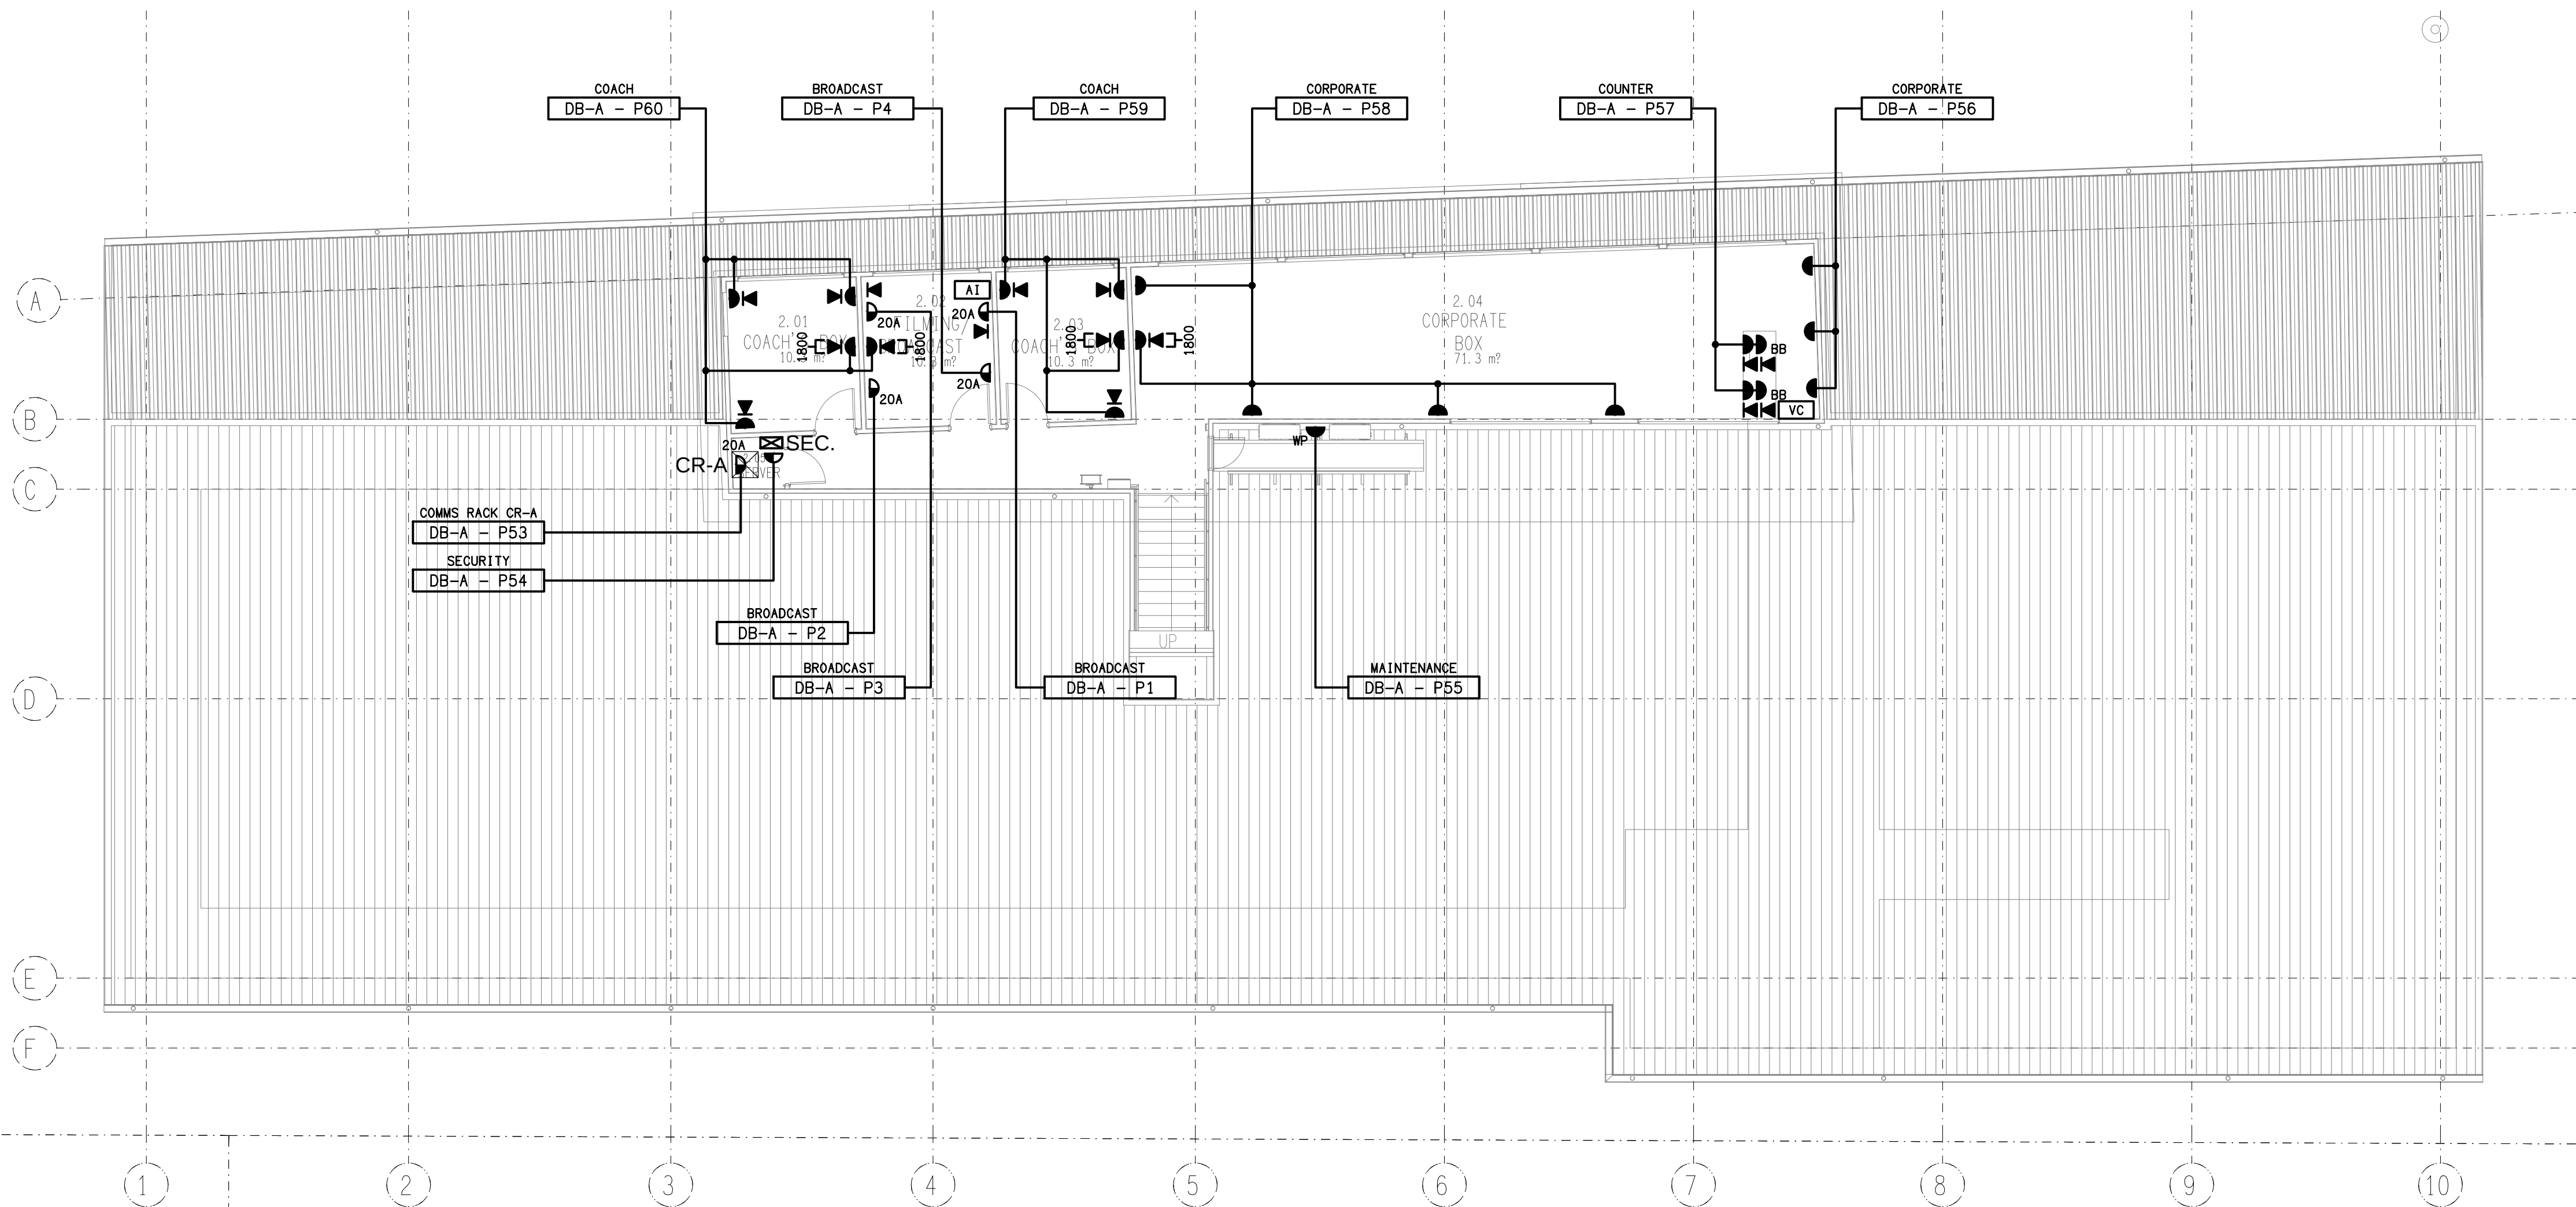

FLOOR PLAN
LEVEL 2
SCALE 1: 100

ELECTRICAL DESIGN GROUP BRISBANE
PTY LTD
ACN 092 710 793
TRADING AS:
ELECTRICAL DESIGN GROUP

THE COPYRIGHT OF THIS DRAWING
REMAINS THE PROPERTY OF THE
ELECTRICAL DESIGN GROUP.
USE FIGURED DIMENSIONS
IN PREFERENCE TO SCALE.
ALL DIMENSIONS TO BE
VERIFIED ONSITE.

ELECTRICAL DESIGN GROUP
ELECTRICAL BUILDING SERVICES CONSULTANTS
BRISBANE GOLD COAST

P.O. Box 15, Sherwood Q.4075
Phone: (07) 3278 4375
Email: brisbane@edg.net.au
Web: www.edg.net.au

PROJECT:
BROTHERS RUGBY CLUB - REDEVELOPMENT

103 CROSBY ROAD, ALBION, QUEENSLAND

B	TENDER	07/08/2026
REV:	DESCRIPTION:	DATE:

DRAWING:
ELECTRICAL SERVICES
LEVEL 2 PLANS

SCALE:
1:100 UNO AT A1

PROJECT NO:
C3657a

DRAWING NO:
E08

REVISION:
B