

LEGEND


- ELECTRICAL SERVICES SWITCHBOARD.
- SWITCHBOARD / CONTROL PANEL NOT PROVIDED AS PART OF THE ELECTRICAL SUBCONTRACT.
- SINGLE POWER OUTLET.
- DOUBLE POWER OUTLET.
- USB DOUBLE POWER OUTLET C/W USB CHARGER.
- DRINK FOUNTAIN OUTLET.
- CEILING SUSPENDED POWER OUTLET.
- ELECTRICAL FLOOR BOX, TYPE AS NOTED.
- SPECIAL PURPOSE POWER OUTLET.
- SINGLE PHASE ISOLATOR.
- THREE PHASE ISOLATOR.
- ELECTRICAL RISER / JUNCTION BOX AS NOTED.
- x DENOTES CONDUIT TYPE.
- PIT x□ ELECTRICAL PIT, TYPE AS NOTED.
- HD HAND DRYER CONNECTION.
- PD LIGHTING PRESENCE DETECTOR SWITCH.
- LCP LIGHTING CONTROL PANEL.
- SPx BMS SWITCH PANEL, TYPE AS NOTED.
- ONE-WAY LIGHT SWITCH.
- TWO-WAY LIGHT SWITCH.
- MANUAL DALI POT DIMMER.
- CIRCUIT LINE.
- SWITCH LINE.
- DB-x - Py POWER CIRCUIT DESIGNATION. DENOTES DB AND CIRCUIT.
- ELECTRICAL EQUIPMENT AS NOTED.
- RK OUTLET MOUNTED IN RECESS KIT.
- H HDMI OUTLET.
- RJ45 COMMUNICATIONS OUTLET.
- DOB DOOR BELL PUSH BUTTON.
- CHT DOOR BELL CHIME.
- CR ACCESS CONTROL CARD READER.
- ES ACCESS CONTROL DOOR ELECTRIC STRIKE, TYPE AS NOTED.
- LIM ACCESS CONTROL LIFT INTERFACE MODULE.
- RSD ACCESS CONTROL ROLLER SHUTTER DOOR INTERFACE.
- AD ACCESS CONTROL AUTO DOOR INTERFACE.
- PB ACCESS CONTROL AUTO DOOR EXIT PUSH BUTTON.
- Security DIRECTIONAL MOTION DETECTOR.
- Security PIEZO SIREN.
- Security KEY PAD.
- Security OVER-RIDE SWITCH.

LEGEND

- SECURITY SIREN STROBE.
- PA HORN / HOOTER.
- RECESSED PA MULTI-TAP CONE SPEAKER.
- SURFACE MOUNTED PA MULTI-TAP CONE SPEAKER.
- M2 PRIVATE METER.
- FUSE.
- SINGLE PHASE.
- THREE PHASE.
- CURRENT TRANSFORMER C/W REMOVABLE LINK.
- FUSE LINK.
- COMBINED FUSE SWITCH.
- CIRCUIT BREAKER.
- ISOLATOR.
- RESIDUAL CURRENT DEVICE.
- CONTACTOR - NORMALLY OPEN.
- CONTACTOR - NORMALLY CLOSED.
- REFER TO DETAIL NOTED FOR THE AREA SHOWN HATCHED. ADDITIONAL OUTLETS & FITTINGS MAY BE SHOWN ON DETAIL.
- E1: GENERAL RECESSED LED EMERGENCY LIGHT. WHITE.
- E2: GENERAL WALL MOUNTED LED EMERGENCY LIGHT. WHITE.
- E3: WEATHERPROOF WALL MOUNTED LED EMERGENCY LIGHT.
- E4: GENERAL ROD SUSPENDED LED EMERGENCY LIGHT. BLACK.
- E5: GENERAL SURFACE MOUNTED LED EMERGENCY LIGHT. WHITE.
- EX: EMERGENCY LED EXIT LIGHT.
- EX WP: WEATHERPROOF EMERGENCY LED EXIT LIGHT.
- L1: 600 x 600 T-BAR MOUNTED LED FLAT PANEL.
- L2: 300 x 1200 T-BAR MOUNTED LED FLAT PANEL.
- L3: 1200 LONG SURFACE LED BATTEN C/W SENSOR.
- L4: GROUND LEVEL CIRCULATION SURFACE SQUARE DOWNLIGHT.
- L5: RECESSED AMENITY LED DOWNLIGHT.
- L6: SUSPENDED LINEAR EXTRUSION LIGHT.
- L7: SURFACE MOUNTED TRACK LIGHTING.
- L8: LEVEL 1 CIRCULATION RECESSED DOWNLIGHT.
- L9: INCUBATOR PENDANT.
- L10: WALL MOUNTED AREA LIGHT.
- L11: LED STRIP LIGHT.
- L12: RECESSED LED DOWNLIGHT.
- L13: KITCHENETTE OVERHEAD CUPBOARD STRIP LIGHT.
- L14: RECESSED ADJUSTABLE DOWNLIGHT.
- L15: SUSPENDED LINEAR EXTRUSION LIGHT.
- L16: OFFICE DESK OVERHEAD CUPBOARD STRIP LIGHT.

LEGEND

- KS ROLLER SHUTTER KEY SWITCH.
- MATV OUTLET.
- MATV ANTENNA, MOUNTED ON ROOF.

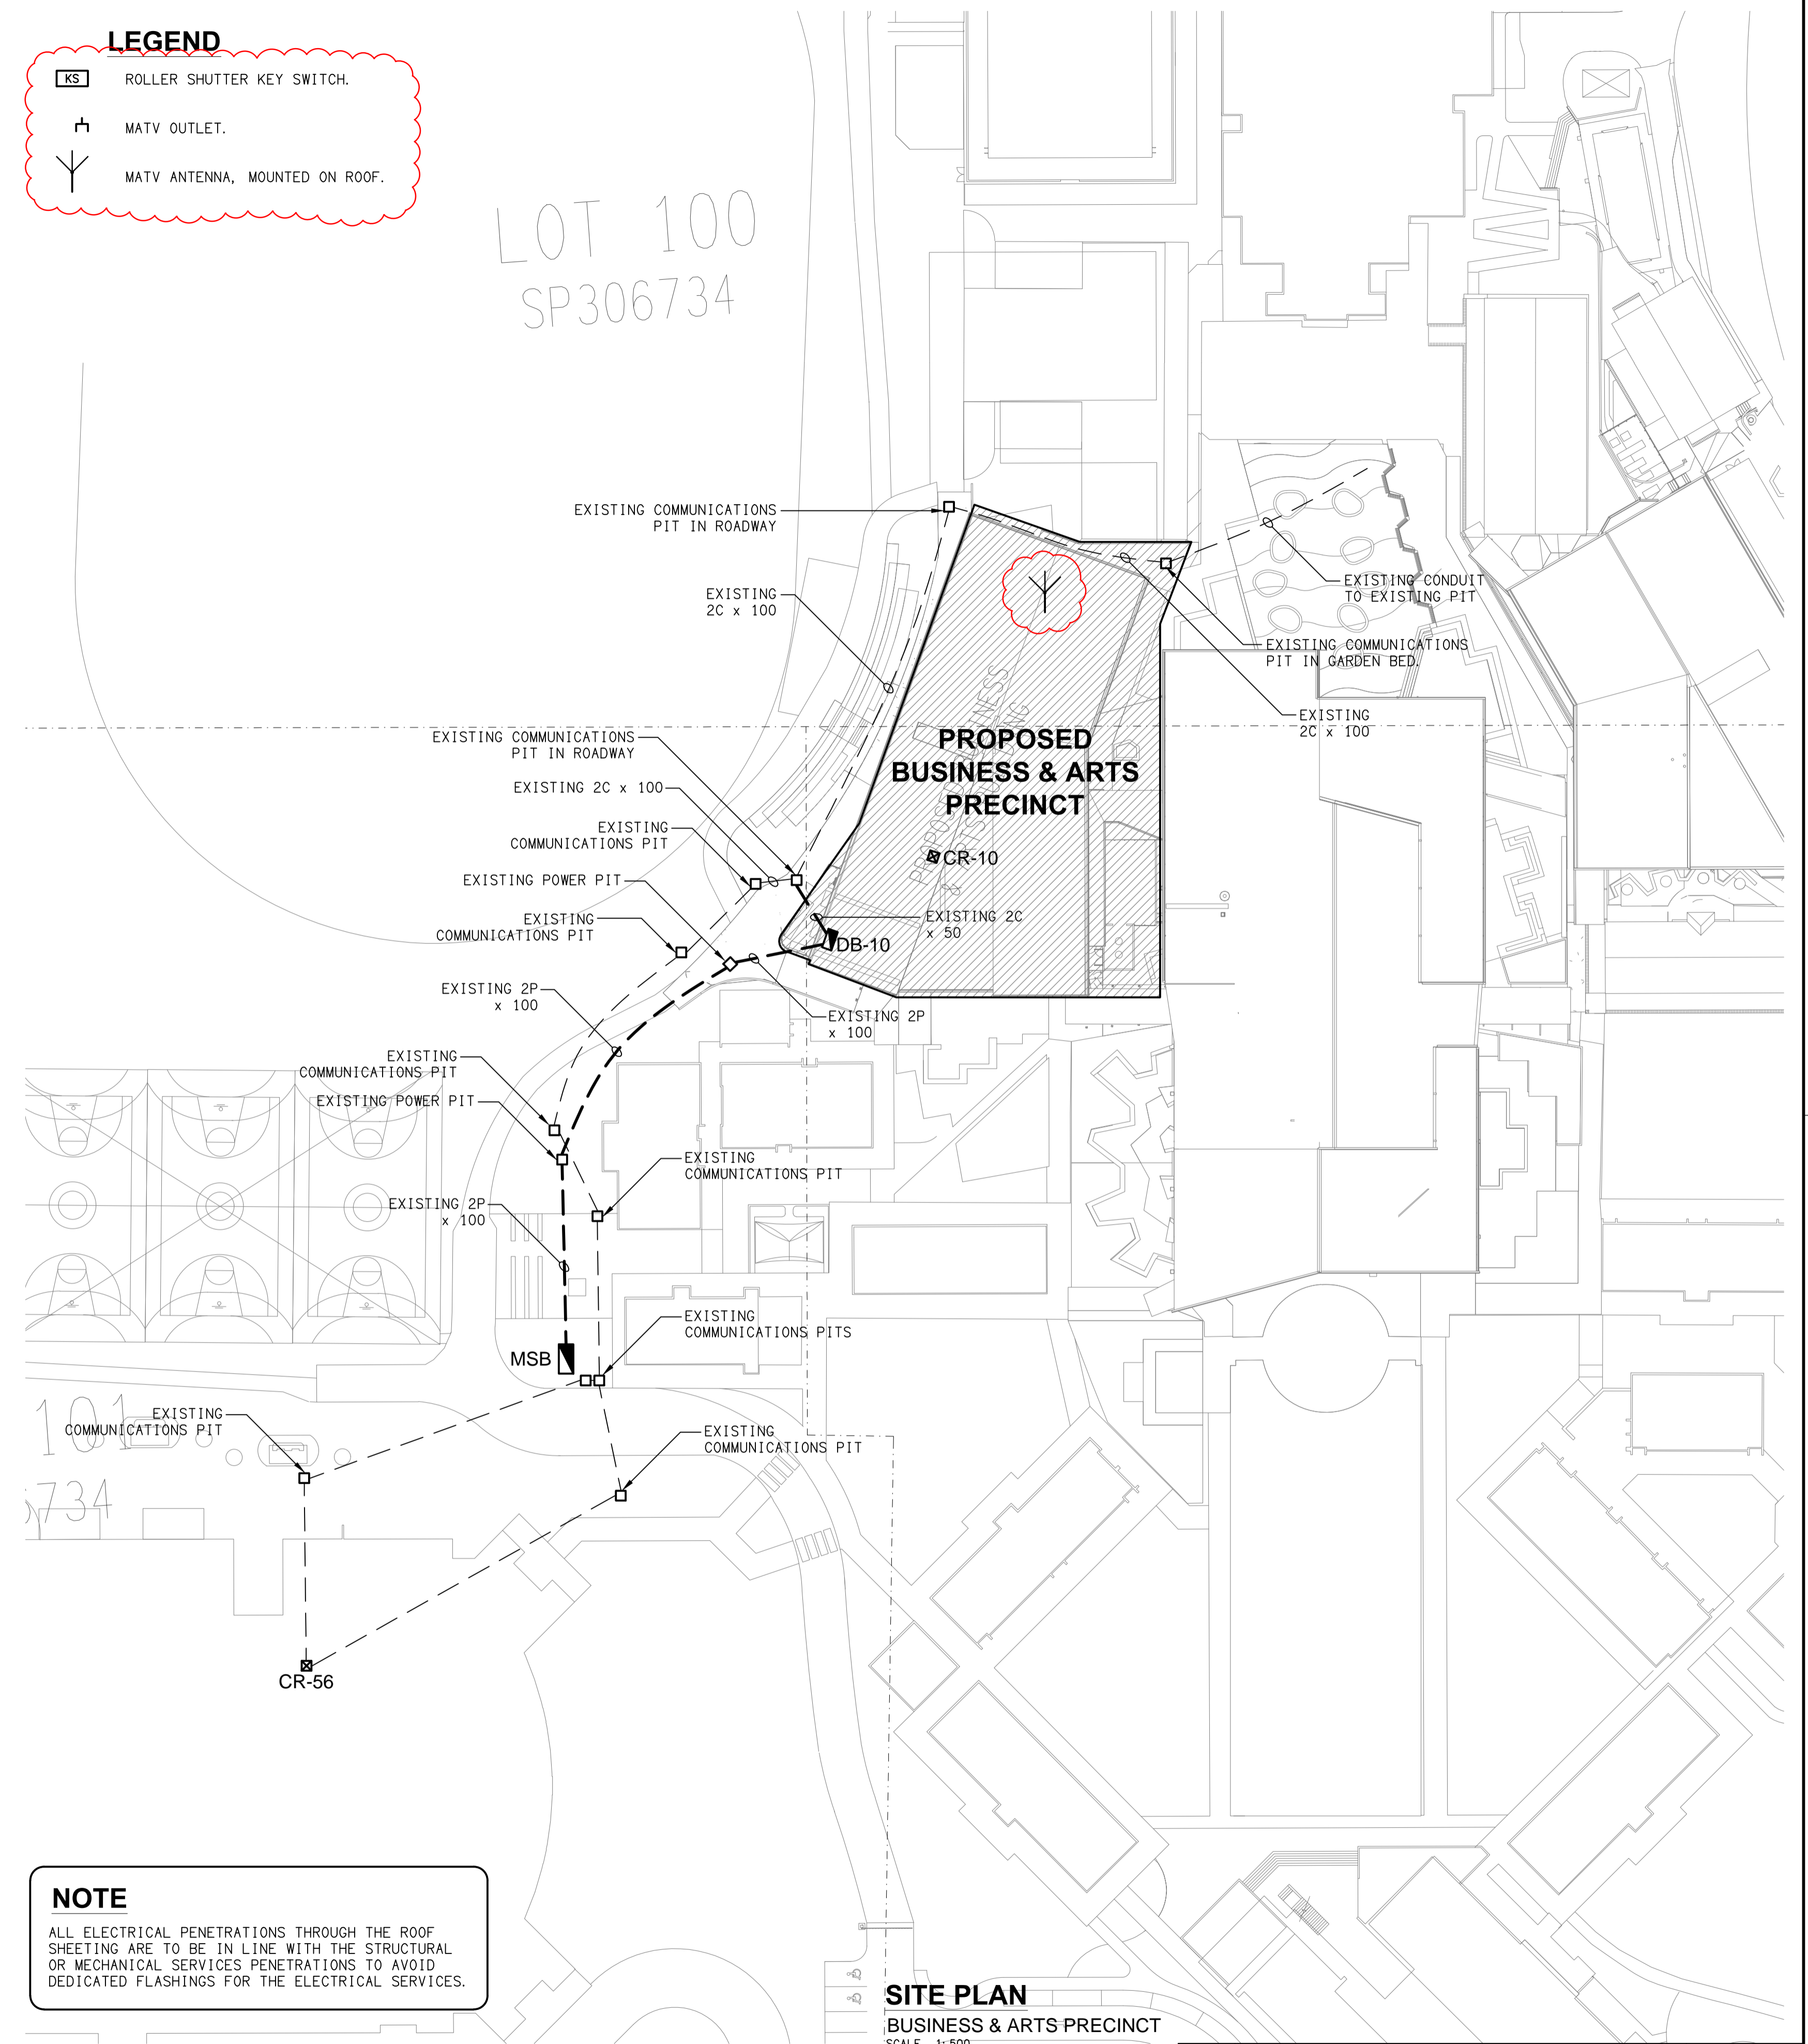

NOTE
ALL ELECTRICAL PENETRATIONS THROUGH THE ROOF SHEETING ARE TO BE IN LINE WITH THE STRUCTURAL OR MECHANICAL SERVICES PENETRATIONS TO AVOID DEDICATED FLASHINGS FOR THE ELECTRICAL SERVICES.

SITE PLAN
BUSINESS & ARTS PRECINCT
SCALE 1:500

ELECTRICAL DESIGN GROUP BRISBANE
PTY LTD
ACN 092 710 793
TRADING AS:
ELECTRICAL DESIGN GROUP

THE COPYRIGHT OF THIS DRAWING
REMAINS THE PROPERTY OF THE
ELECTRICAL DESIGN GROUP.
USE FIGURED DIMENSIONS
IN PREFERENCE TO SCALE.
ALL DIMENSIONS TO BE
VERIFIED ONSITE.

ELECTRICAL DESIGN GROUP
ELECTRICAL BUILDING SERVICES CONSULTANTS
BRISBANE GOLD COAST
P.O. Box 15, Sherwood Q.4075
Phone: (07) 3278 4375
Email: brisbane@edg.net.au
Web: www.edg.net.au

PROJECT:
**ORMISTON COLLEGE
BUSINESS & ARTS PRECINCT**
97 DUNDAS STREET WEST, ORMISTON

D	CONSTRUCTION	16/06/2026
REV:	DESCRIPTION:	DATE:
DRAWING: ELECTRICAL SERVICES LEGEND & SITE PLAN		
SCALE: 1:500	AT A1	PROJECT NO: C3666a
		DRAWING NO: E01
		REVISION: D