




DETAIL B
ART STORAGE CUPBOARD ELEVATION
SCALE 1:25

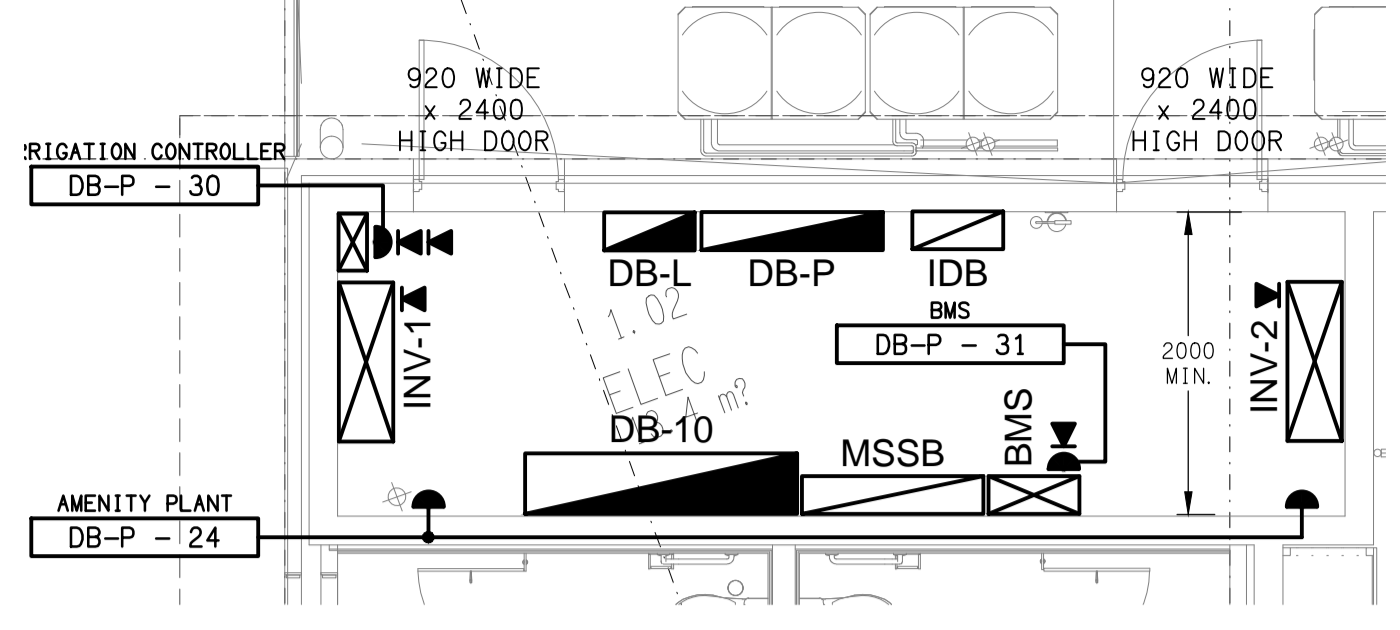

DETAIL A
ELECTRICAL ROOM PLAN
SCALE 1:50

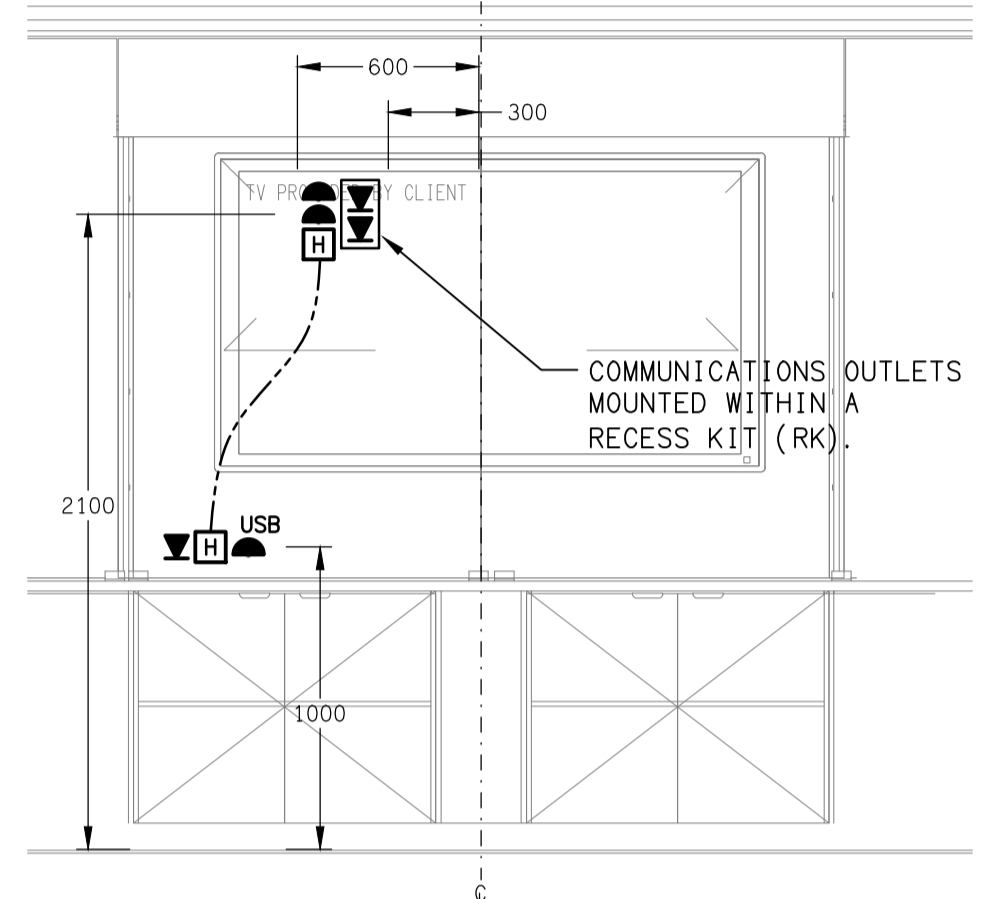

DETAIL C
TYPICAL GLA TEACHERS WALL ELEVATION
SCALE 1:25

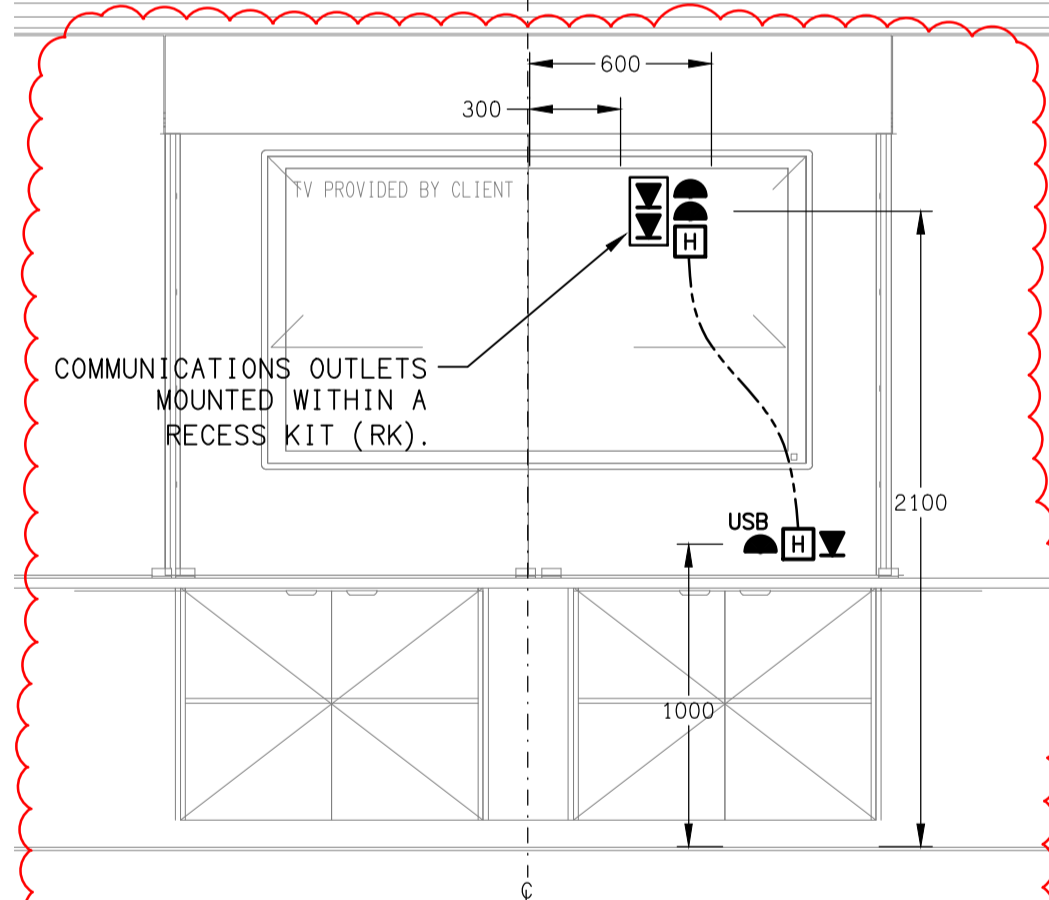

DETAIL D
TYPICAL ART STUDIO TEACHERS WALL ELEVATION
SCALE 1:25

ELECTRICAL DESIGN GROUP BRISBANE PTY LTD
ACN 092 710 793
TRADING AS:
ELECTRICAL DESIGN GROUP

THE COPYRIGHT OF THIS DRAWING REMAINS THE PROPERTY OF THE ELECTRICAL DESIGN GROUP.
USE FIGURED DIMENSIONS IN PREFERENCE TO SCALE.
ALL DIMENSIONS TO BE VERIFIED ONSITE.

ELECTRICAL DESIGN GROUP
ELECTRICAL BUILDING SERVICES CONSULTANTS
BRISBANE GOLD COAST
P.O. Box 15, Sherwood Q.4075
Phone: (07) 3278 4375
Email: brisbane@edg.net.au
Web: www.edg.net.au

PROJECT:
**ORMISTON COLLEGE
BUSINESS & ARTS PRECINCT**
97 DUNDAS STREET WEST, ORMISTON

E	CONSTRUCTION	16/06/2026
REV:	DESCRIPTION:	DATE:
DRAWING: ELECTRICAL SERVICES GROUND LEVEL FLOOR PLAN		
SCALE: 1:100	PROJECT NO: C3666a	DRAWING NO: E04
AT A1	REVISION: E	