



SITE PLAN
BOOM GATE LOCATIONS
SCALE 1:750

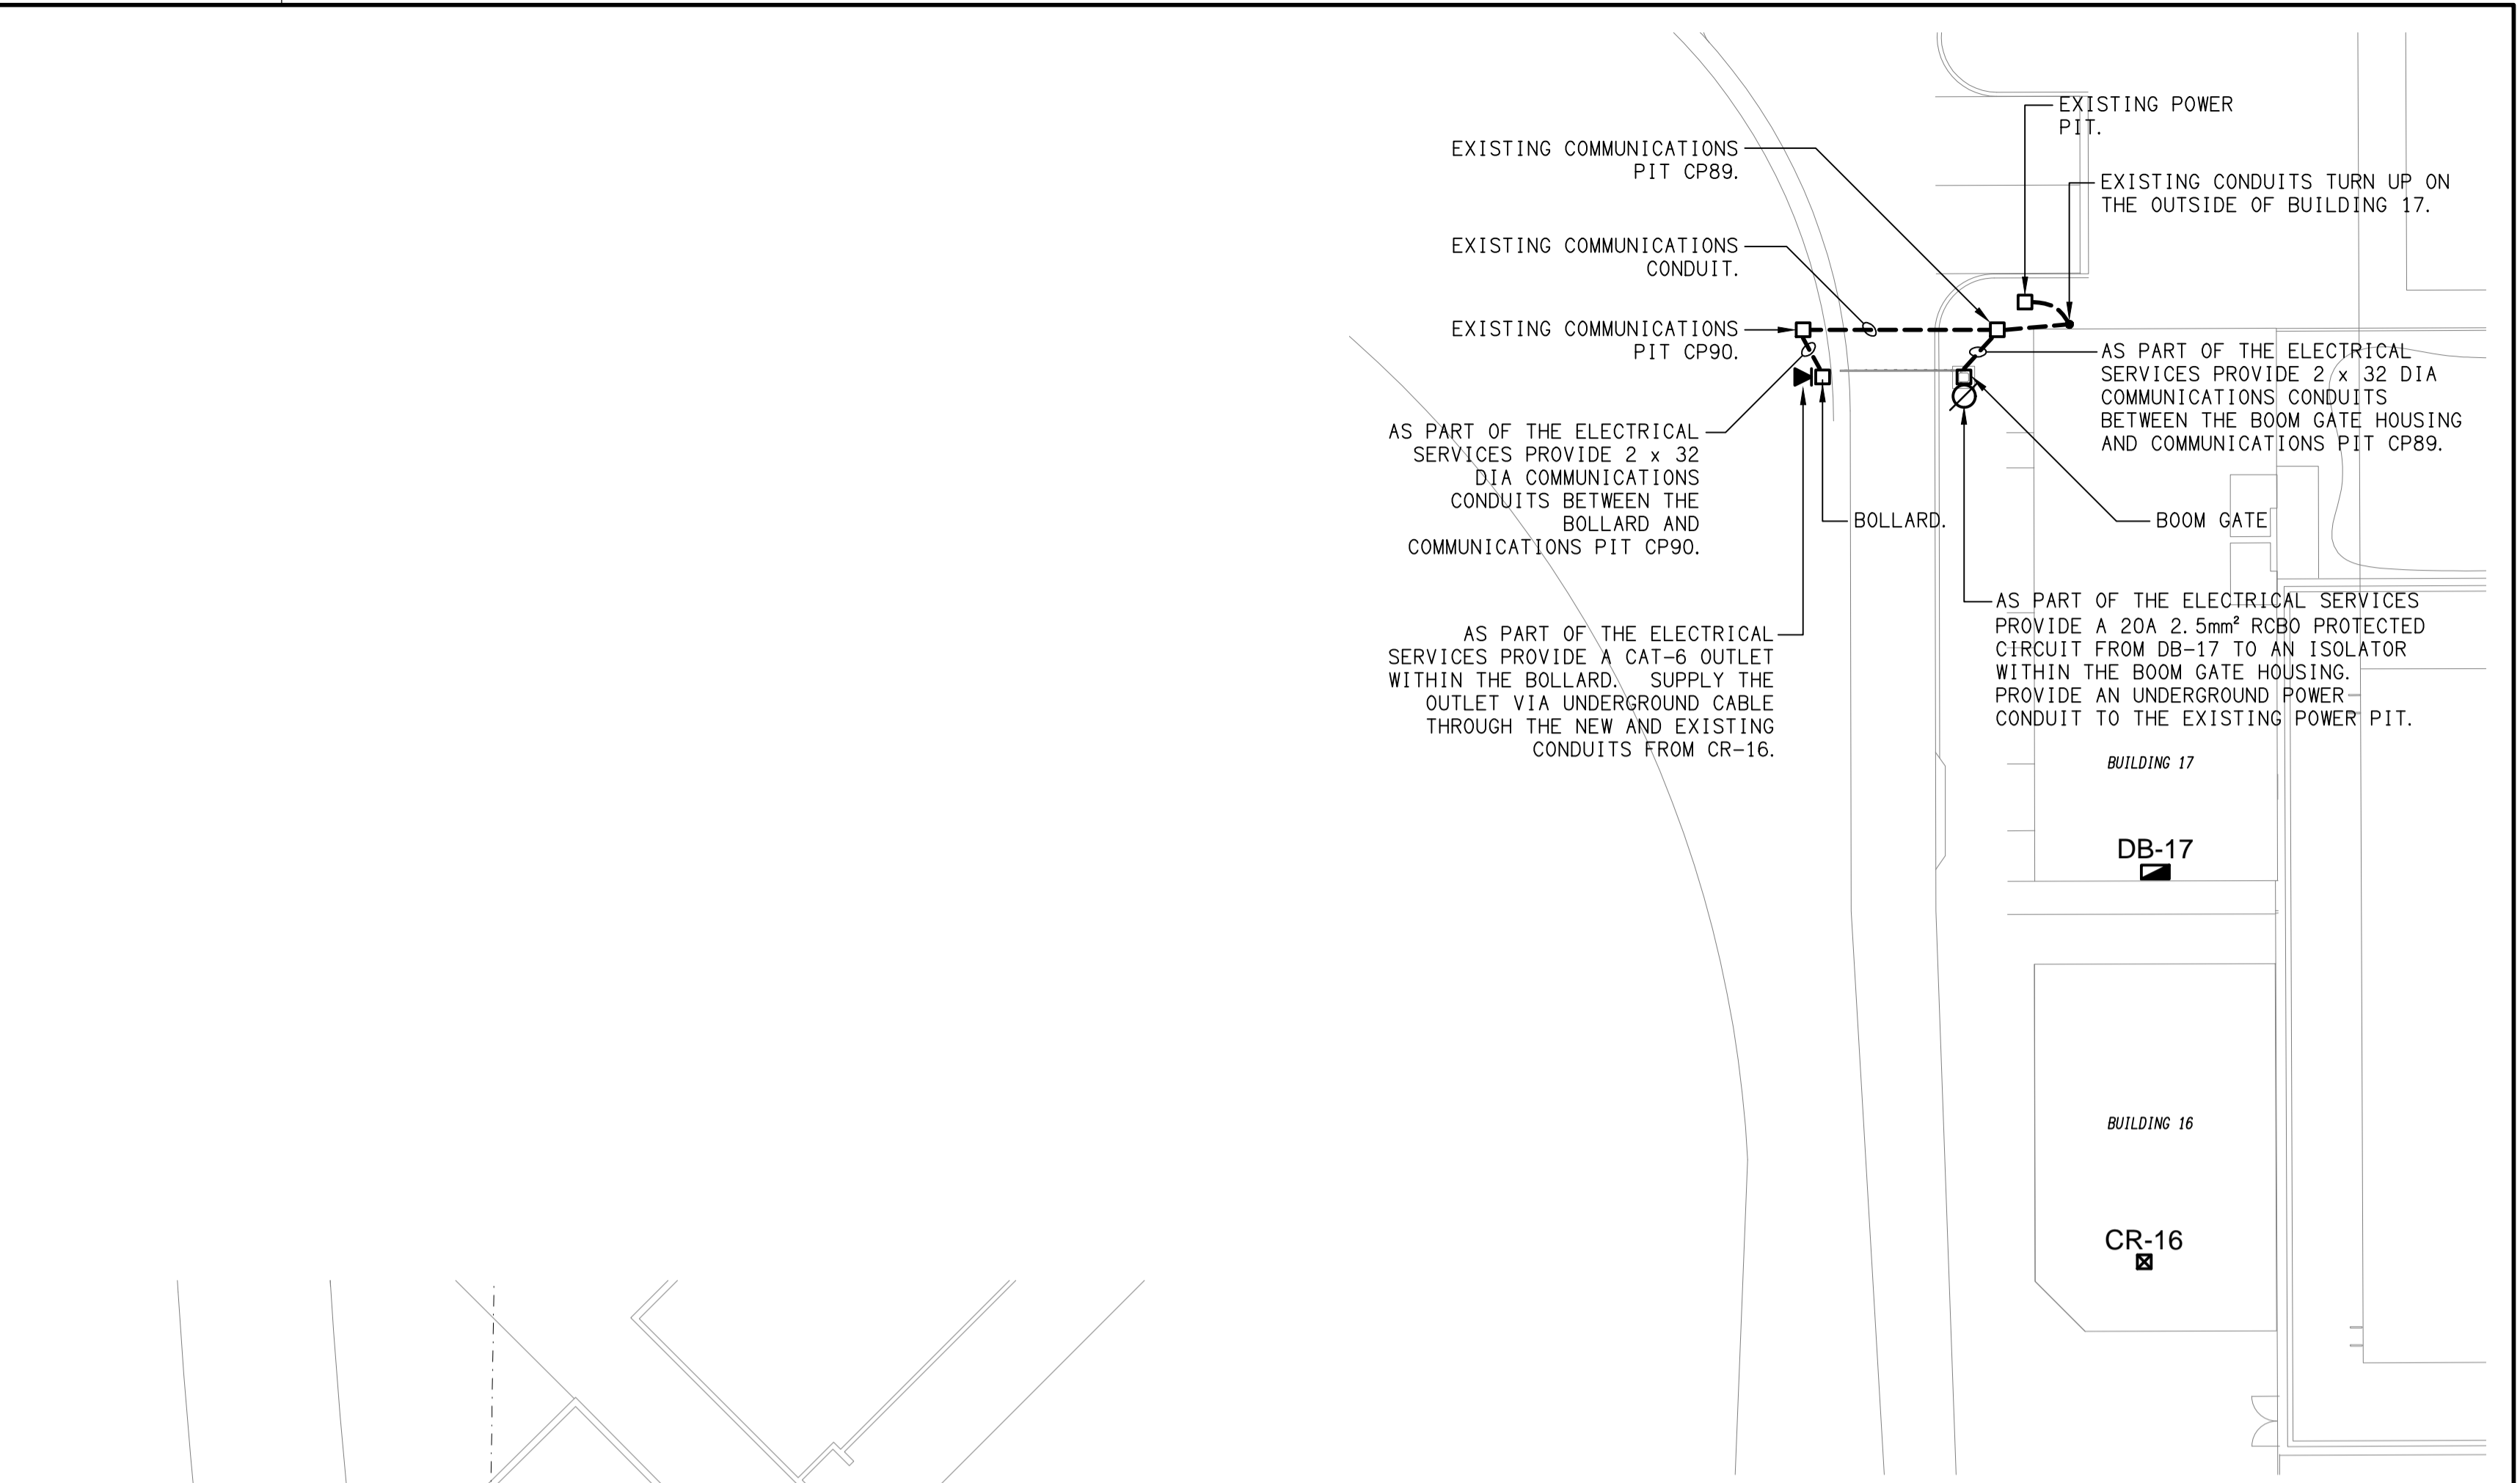

NORTH BOOM GATE
DETAILED ELECTRICAL PLAN
SCALE 1:200

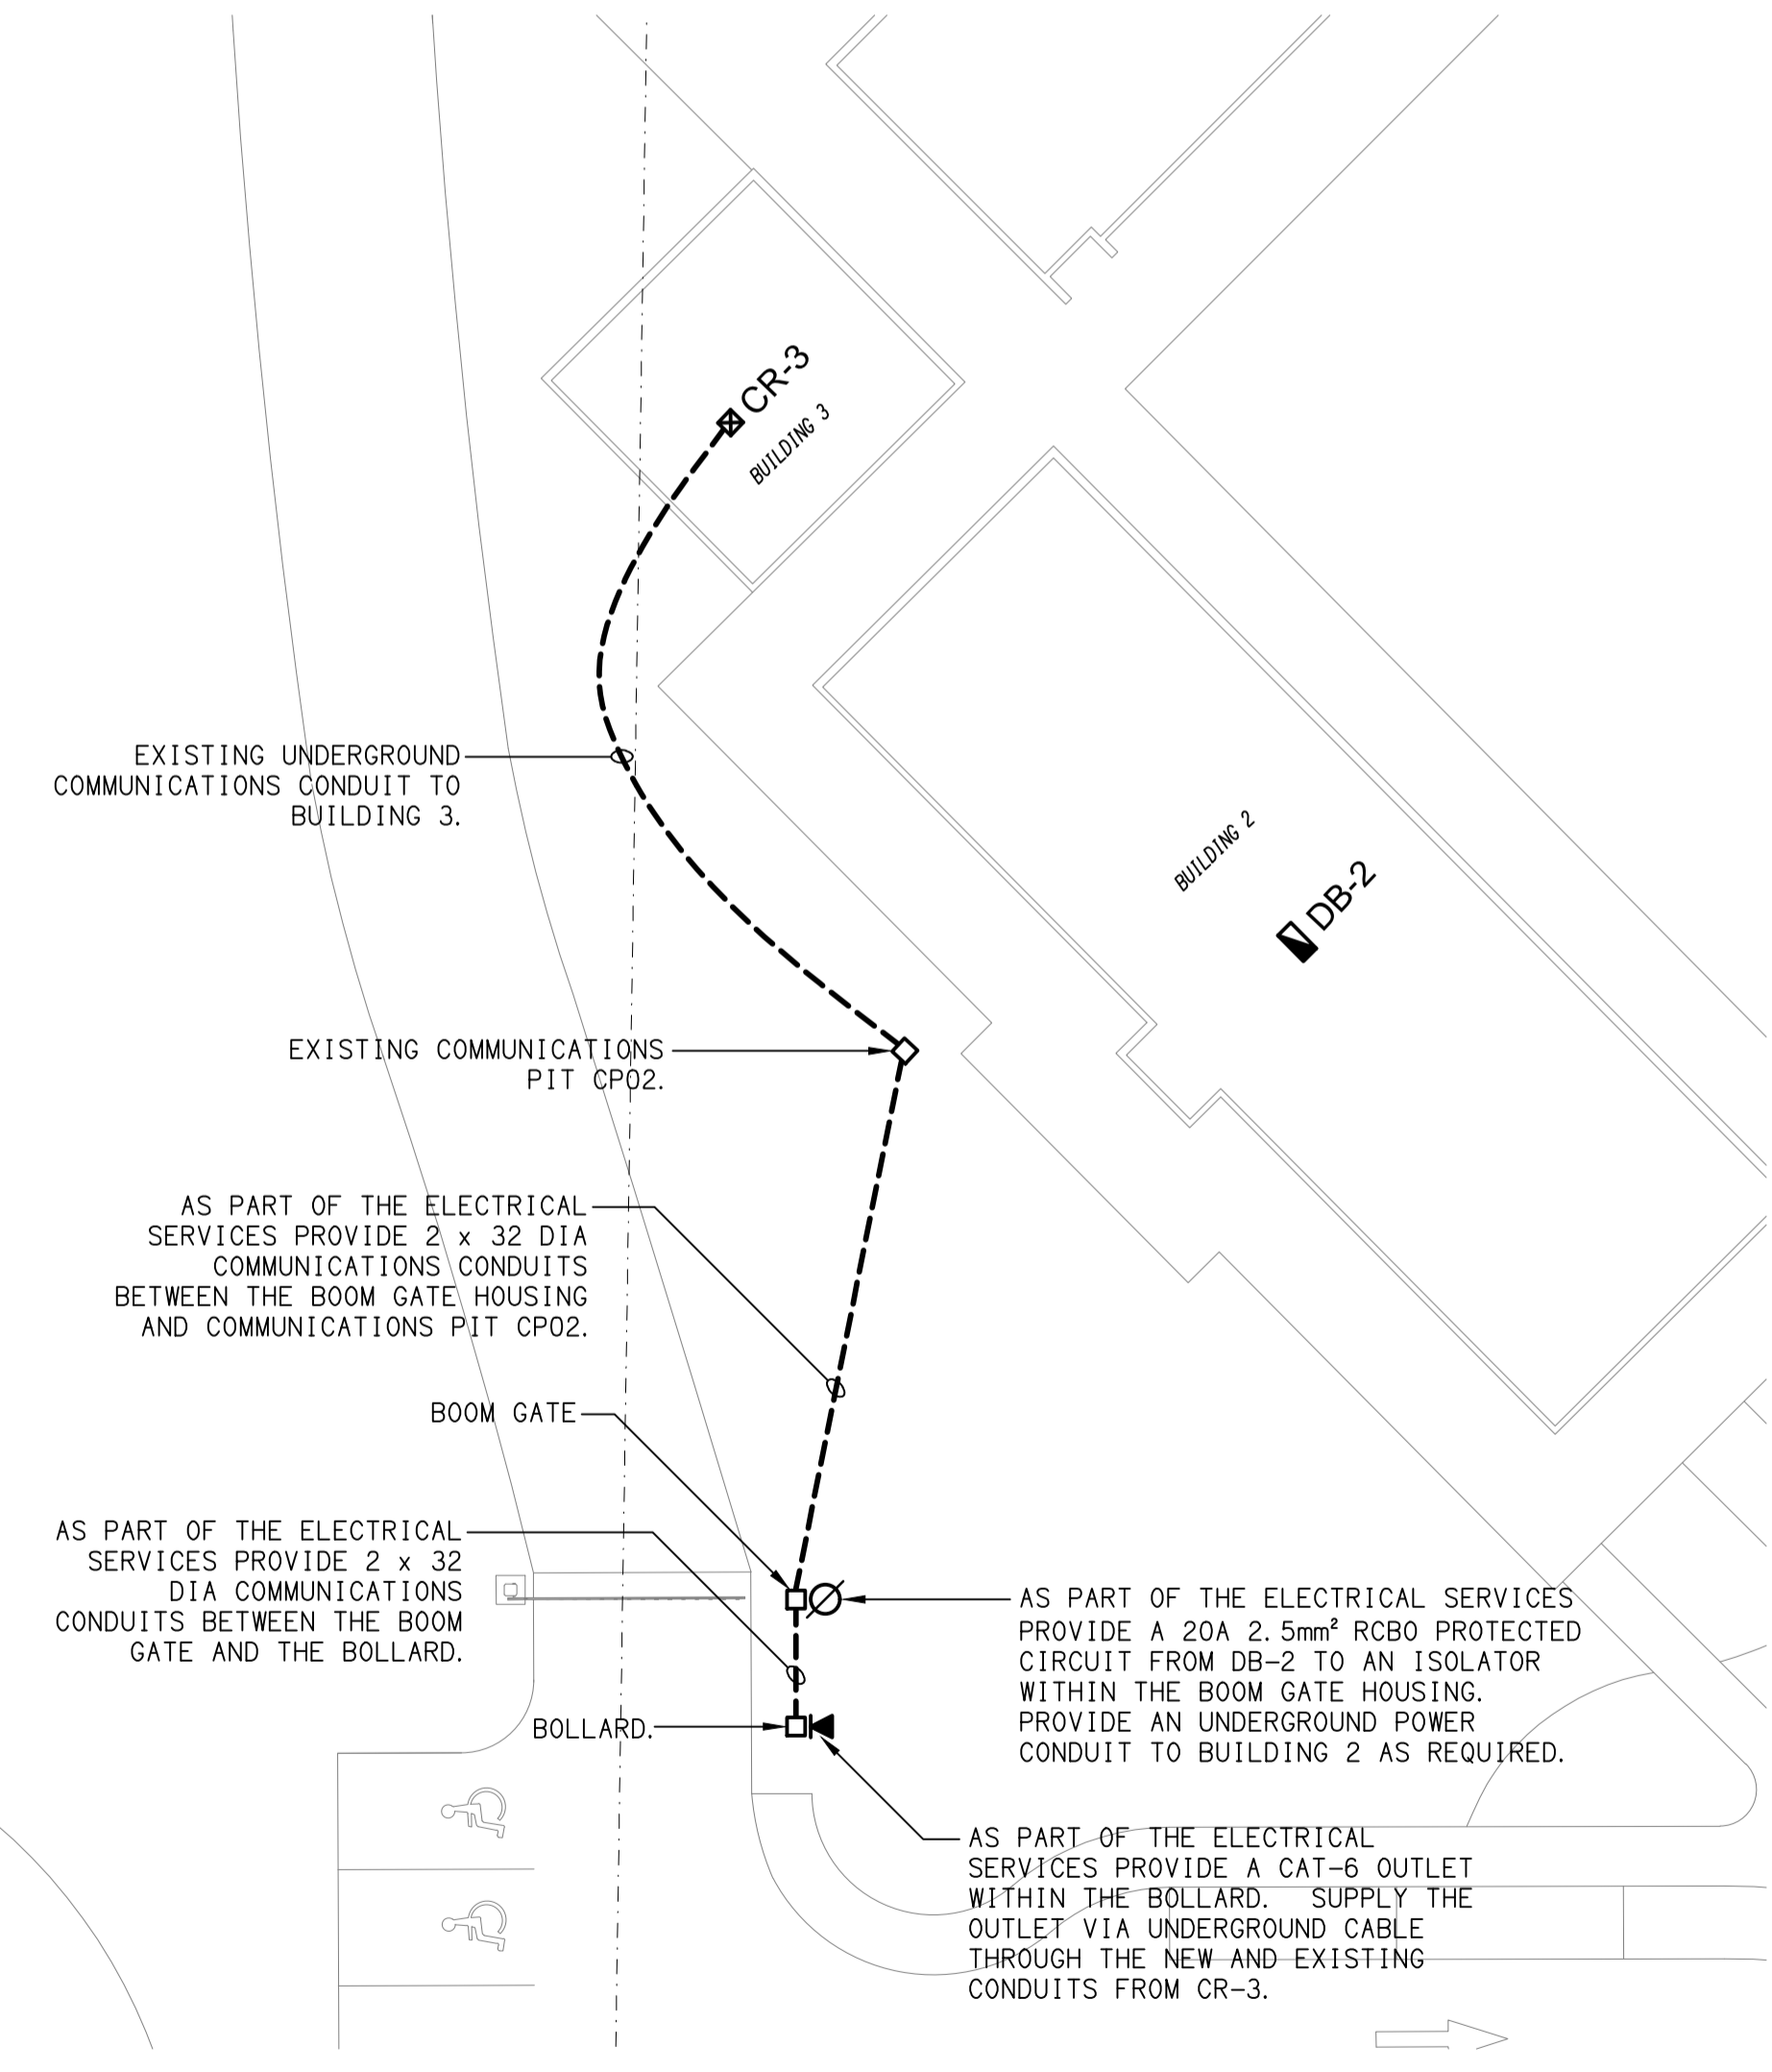

SOUTH BOOM GATE
DETAILED ELECTRICAL PLAN
SCALE 1:200

ELECTRICAL DESIGN GROUP BRISBANE
PTY LTD
ACN 092 710 793
TRADING AS:
ELECTRICAL DESIGN GROUP

THE COPYRIGHT OF THIS DRAWING
REMAINS THE PROPERTY OF THE
ELECTRICAL DESIGN GROUP.
USE FIGURED DIMENSIONS
IN PREFERENCE TO SCALE.
ALL DIMENSIONS TO BE
VERIFIED ONSITE.

ELECTRICAL DESIGN GROUP
ELECTRICAL BUILDING SERVICES CONSULTANTS
BRISBANE GOLD COAST
P.O. Box 15, Sherwood Q.4075
Phone: (07) 3278 4375
Email: brisbane@edg.net.au
Web: www.edg.net.au

PROJECT:
**ORMISTON COLLEGE
BUSINESS & ARTS PRECINCT**
97 DUNDAS STREET WEST, ORMISTON

| | | |
|--|--------------|------------------------------|
| B | CONSTRUCTION | 16/06/2026 |
| REV: | DESCRIPTION: | DATE: |
| DRAWING: ELECTRICAL SERVICES BOOM GATE SITE PLAN | | |
| SCALE: 1:750 & 1:200 | AT A1 | PROJECT NO: C3666a |
| | | DRAWING NO: E09 |
| | | REVISION: B |