
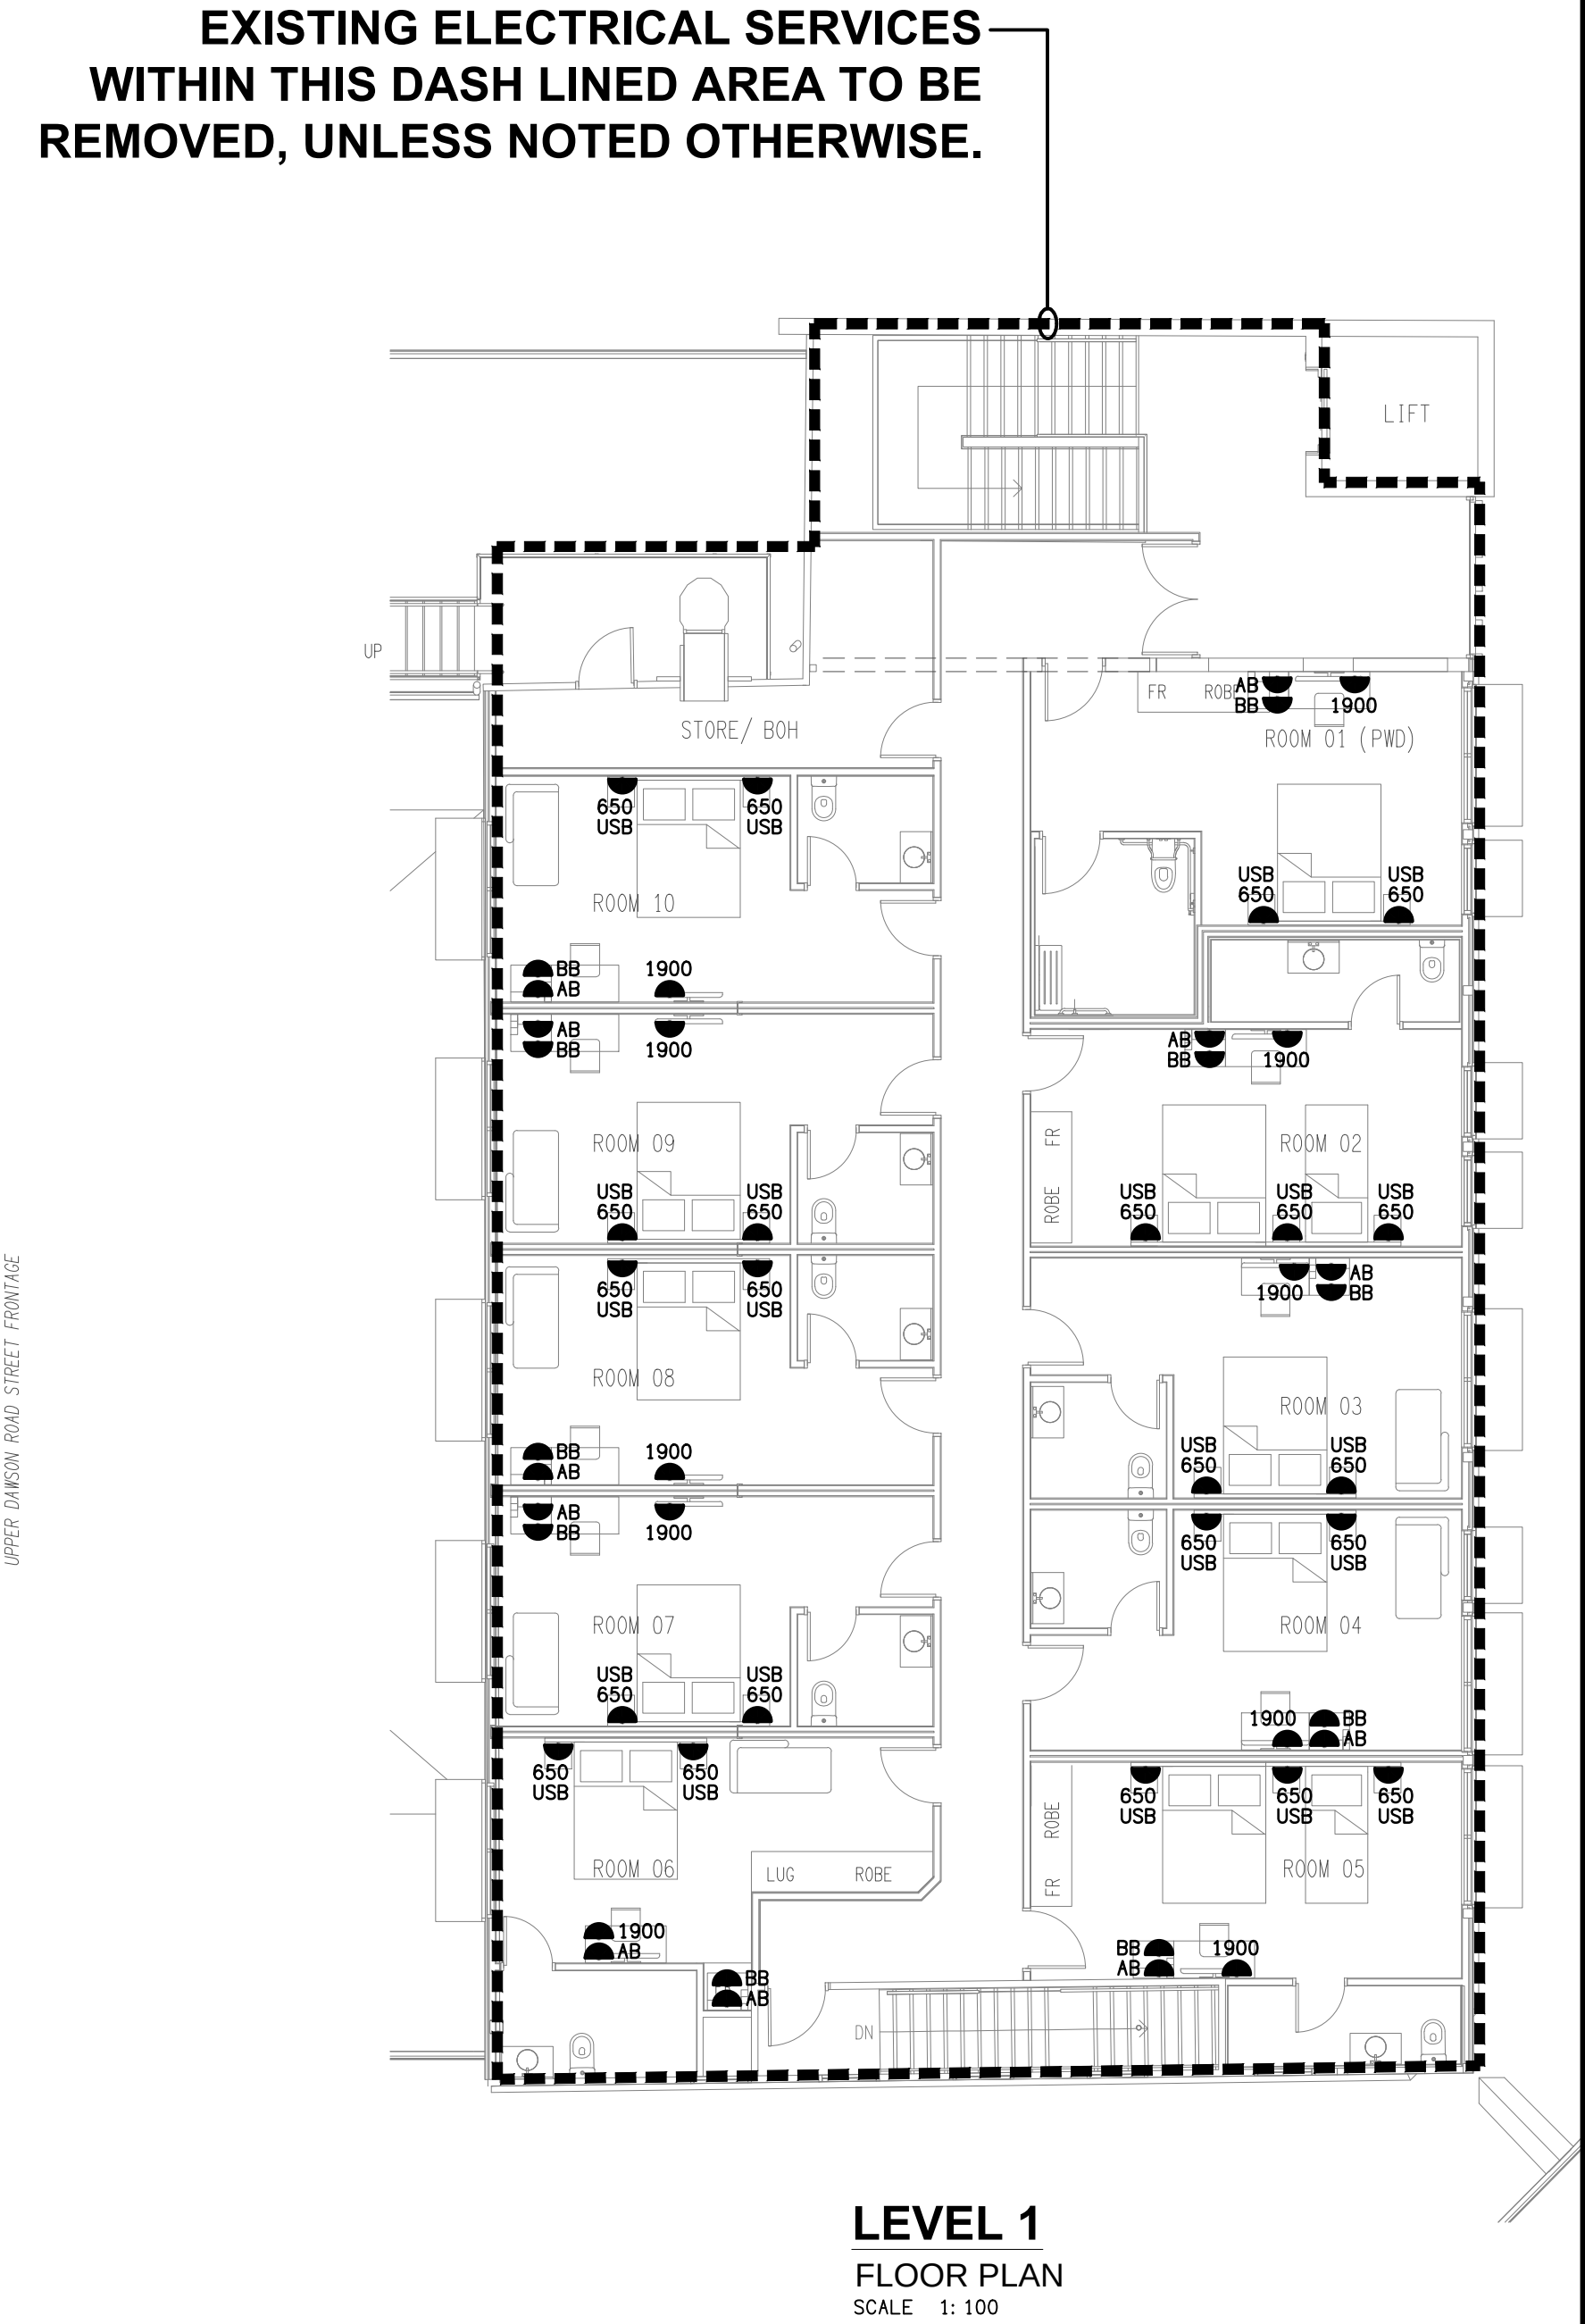


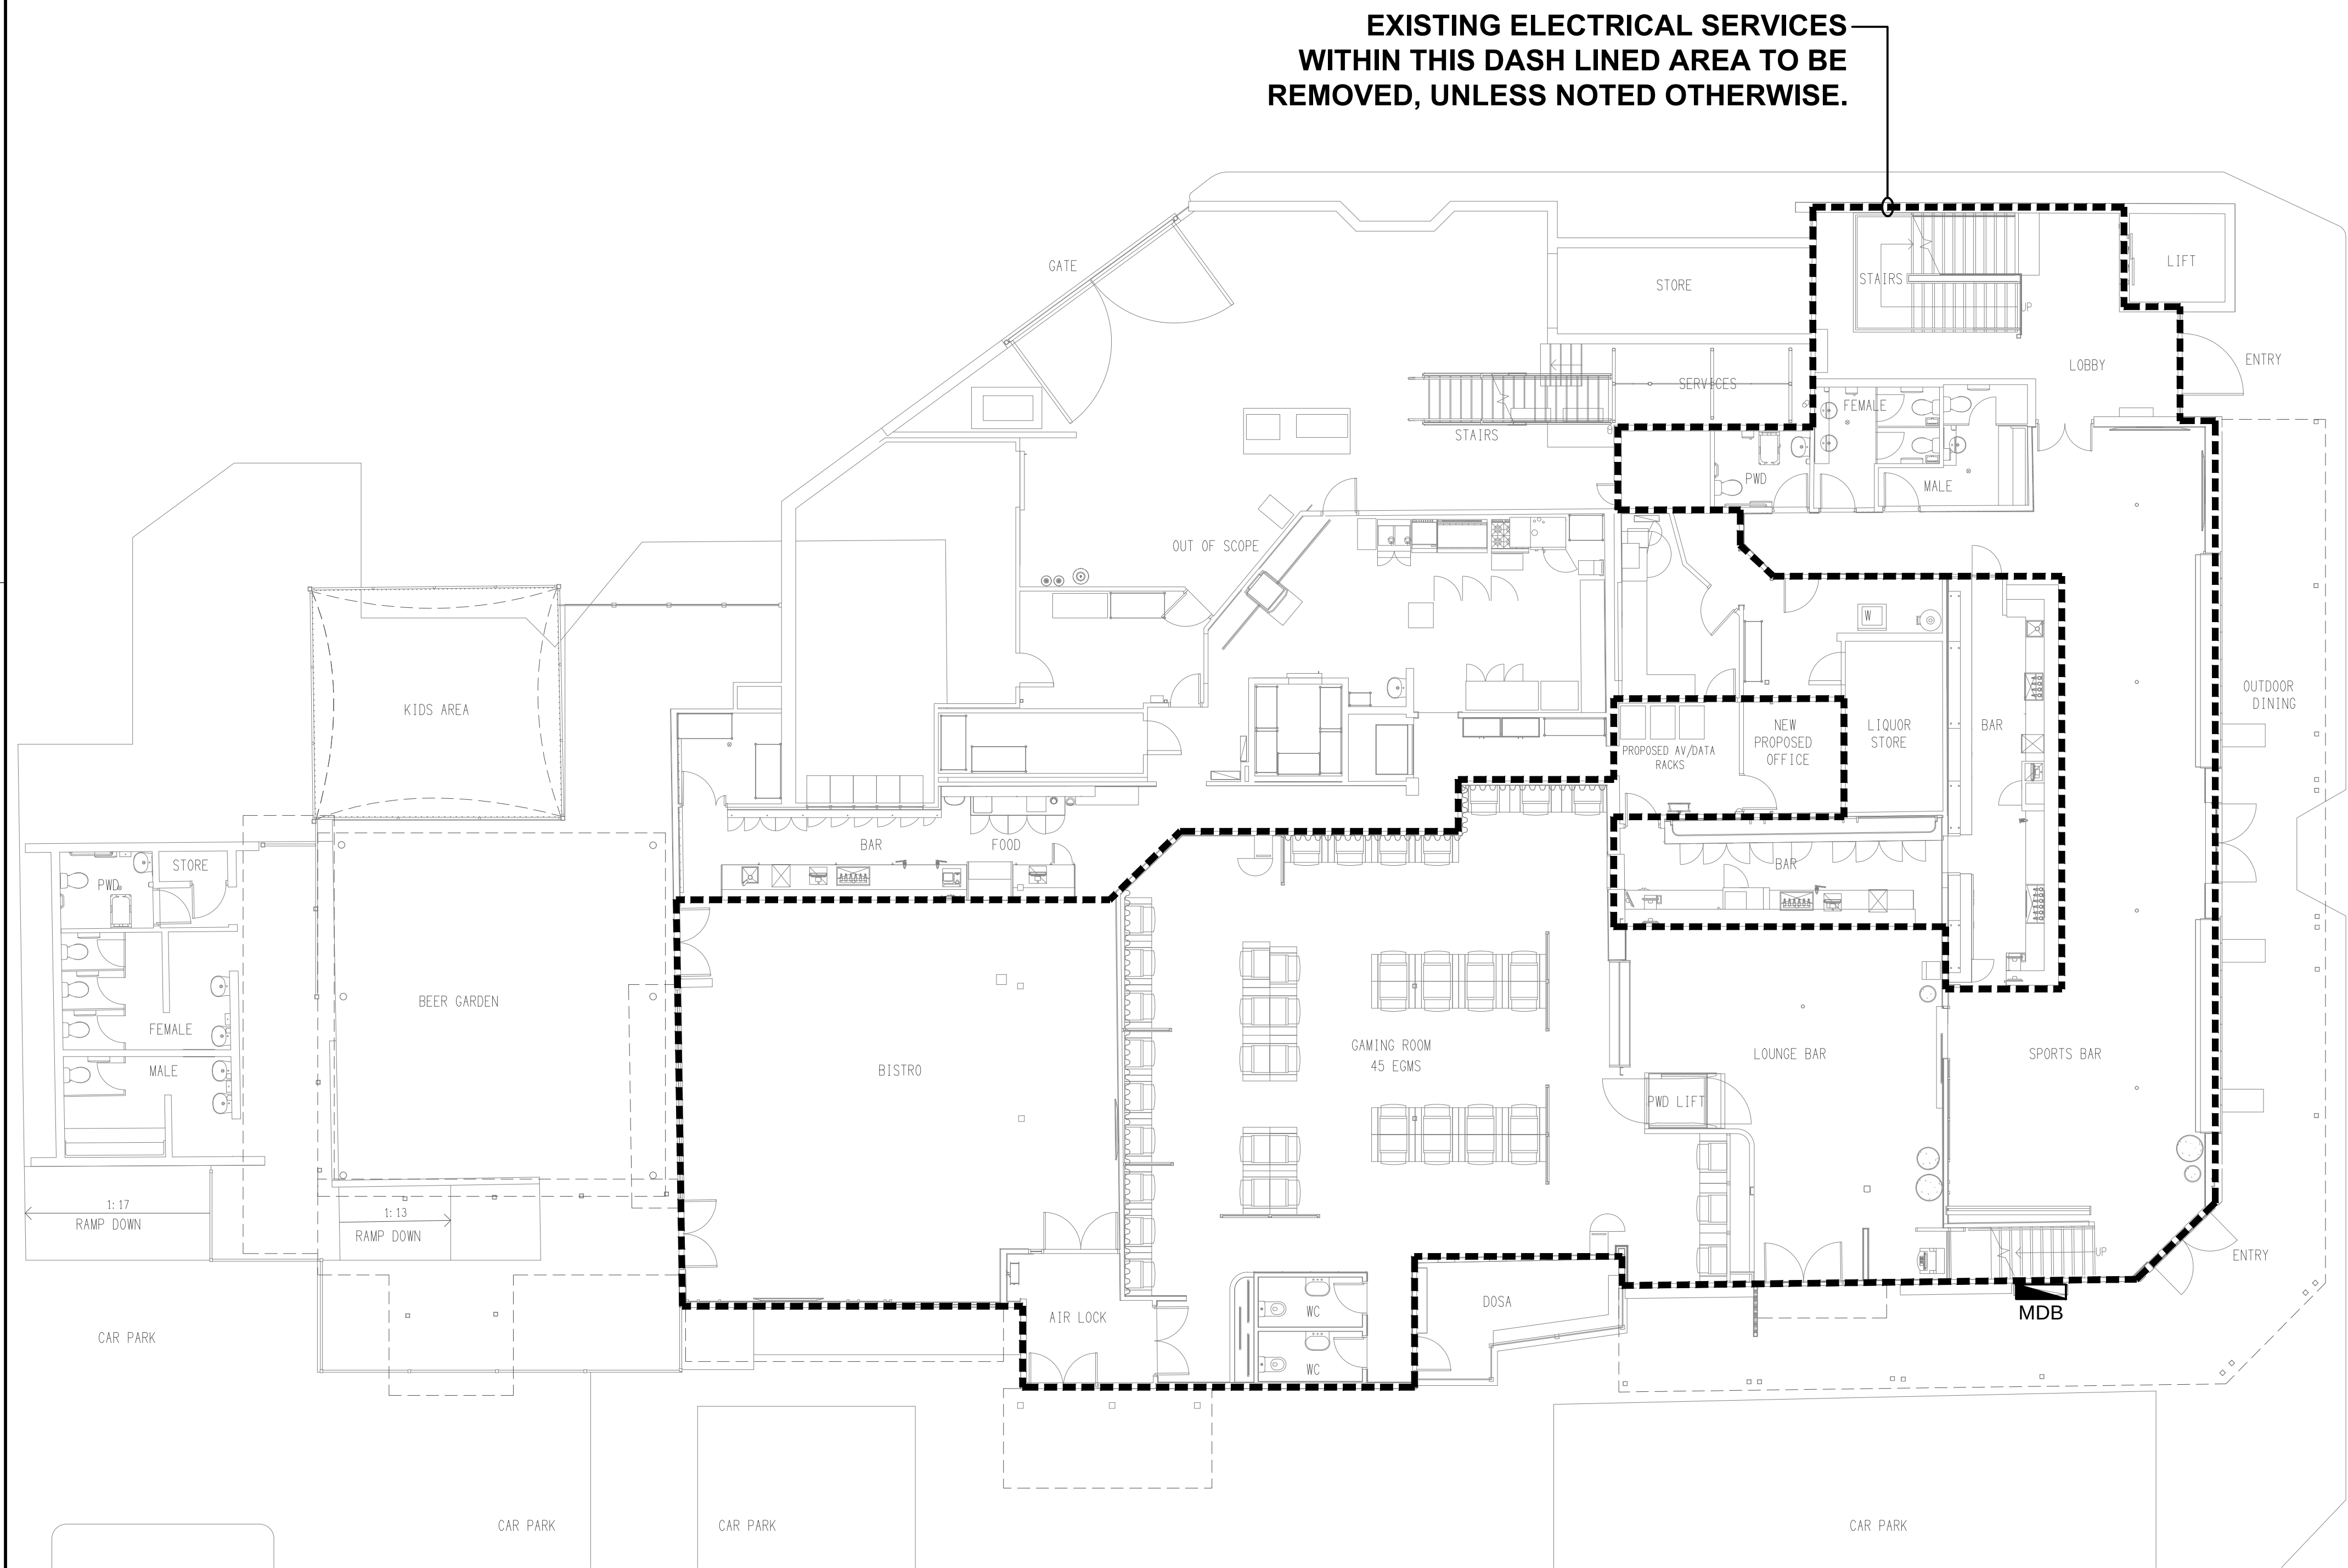

ELECTRICAL DESIGN GROUP BRISBANE PTY LTD ACN 092 710 793 TRADING AS: ELECTRICAL DESIGN GROUP	THE COPYRIGHT OF THIS DRAWING REMAINS THE PROPERTY OF THE ELECTRICAL DESIGN GROUP.	ELECTRICAL DESIGN GROUP ELECTRICAL BUILDING SERVICES CONSULTANTS BRISBANE GOLD COAST P.O.Box 15, Sherwood Q.4075 Phone: (07) 3278 4375 Email: brisbane@edg.net.au Web: www.edg.net.au	PROJECT: ALLENSTOWN HOTEL	DRAWING: ELECTRICAL SERVICES FLOOR PLAN		
	USE FIGURED DIMENSIONS IN PREFERENCE TO SCALE.		SCALE: 1:100 UNO AT A1			
	ALL DIMENSIONS TO BE VERIFIED ONSITE.		PROJECT NO: C3685a DRAWING NO: E03 REVISION: A			