




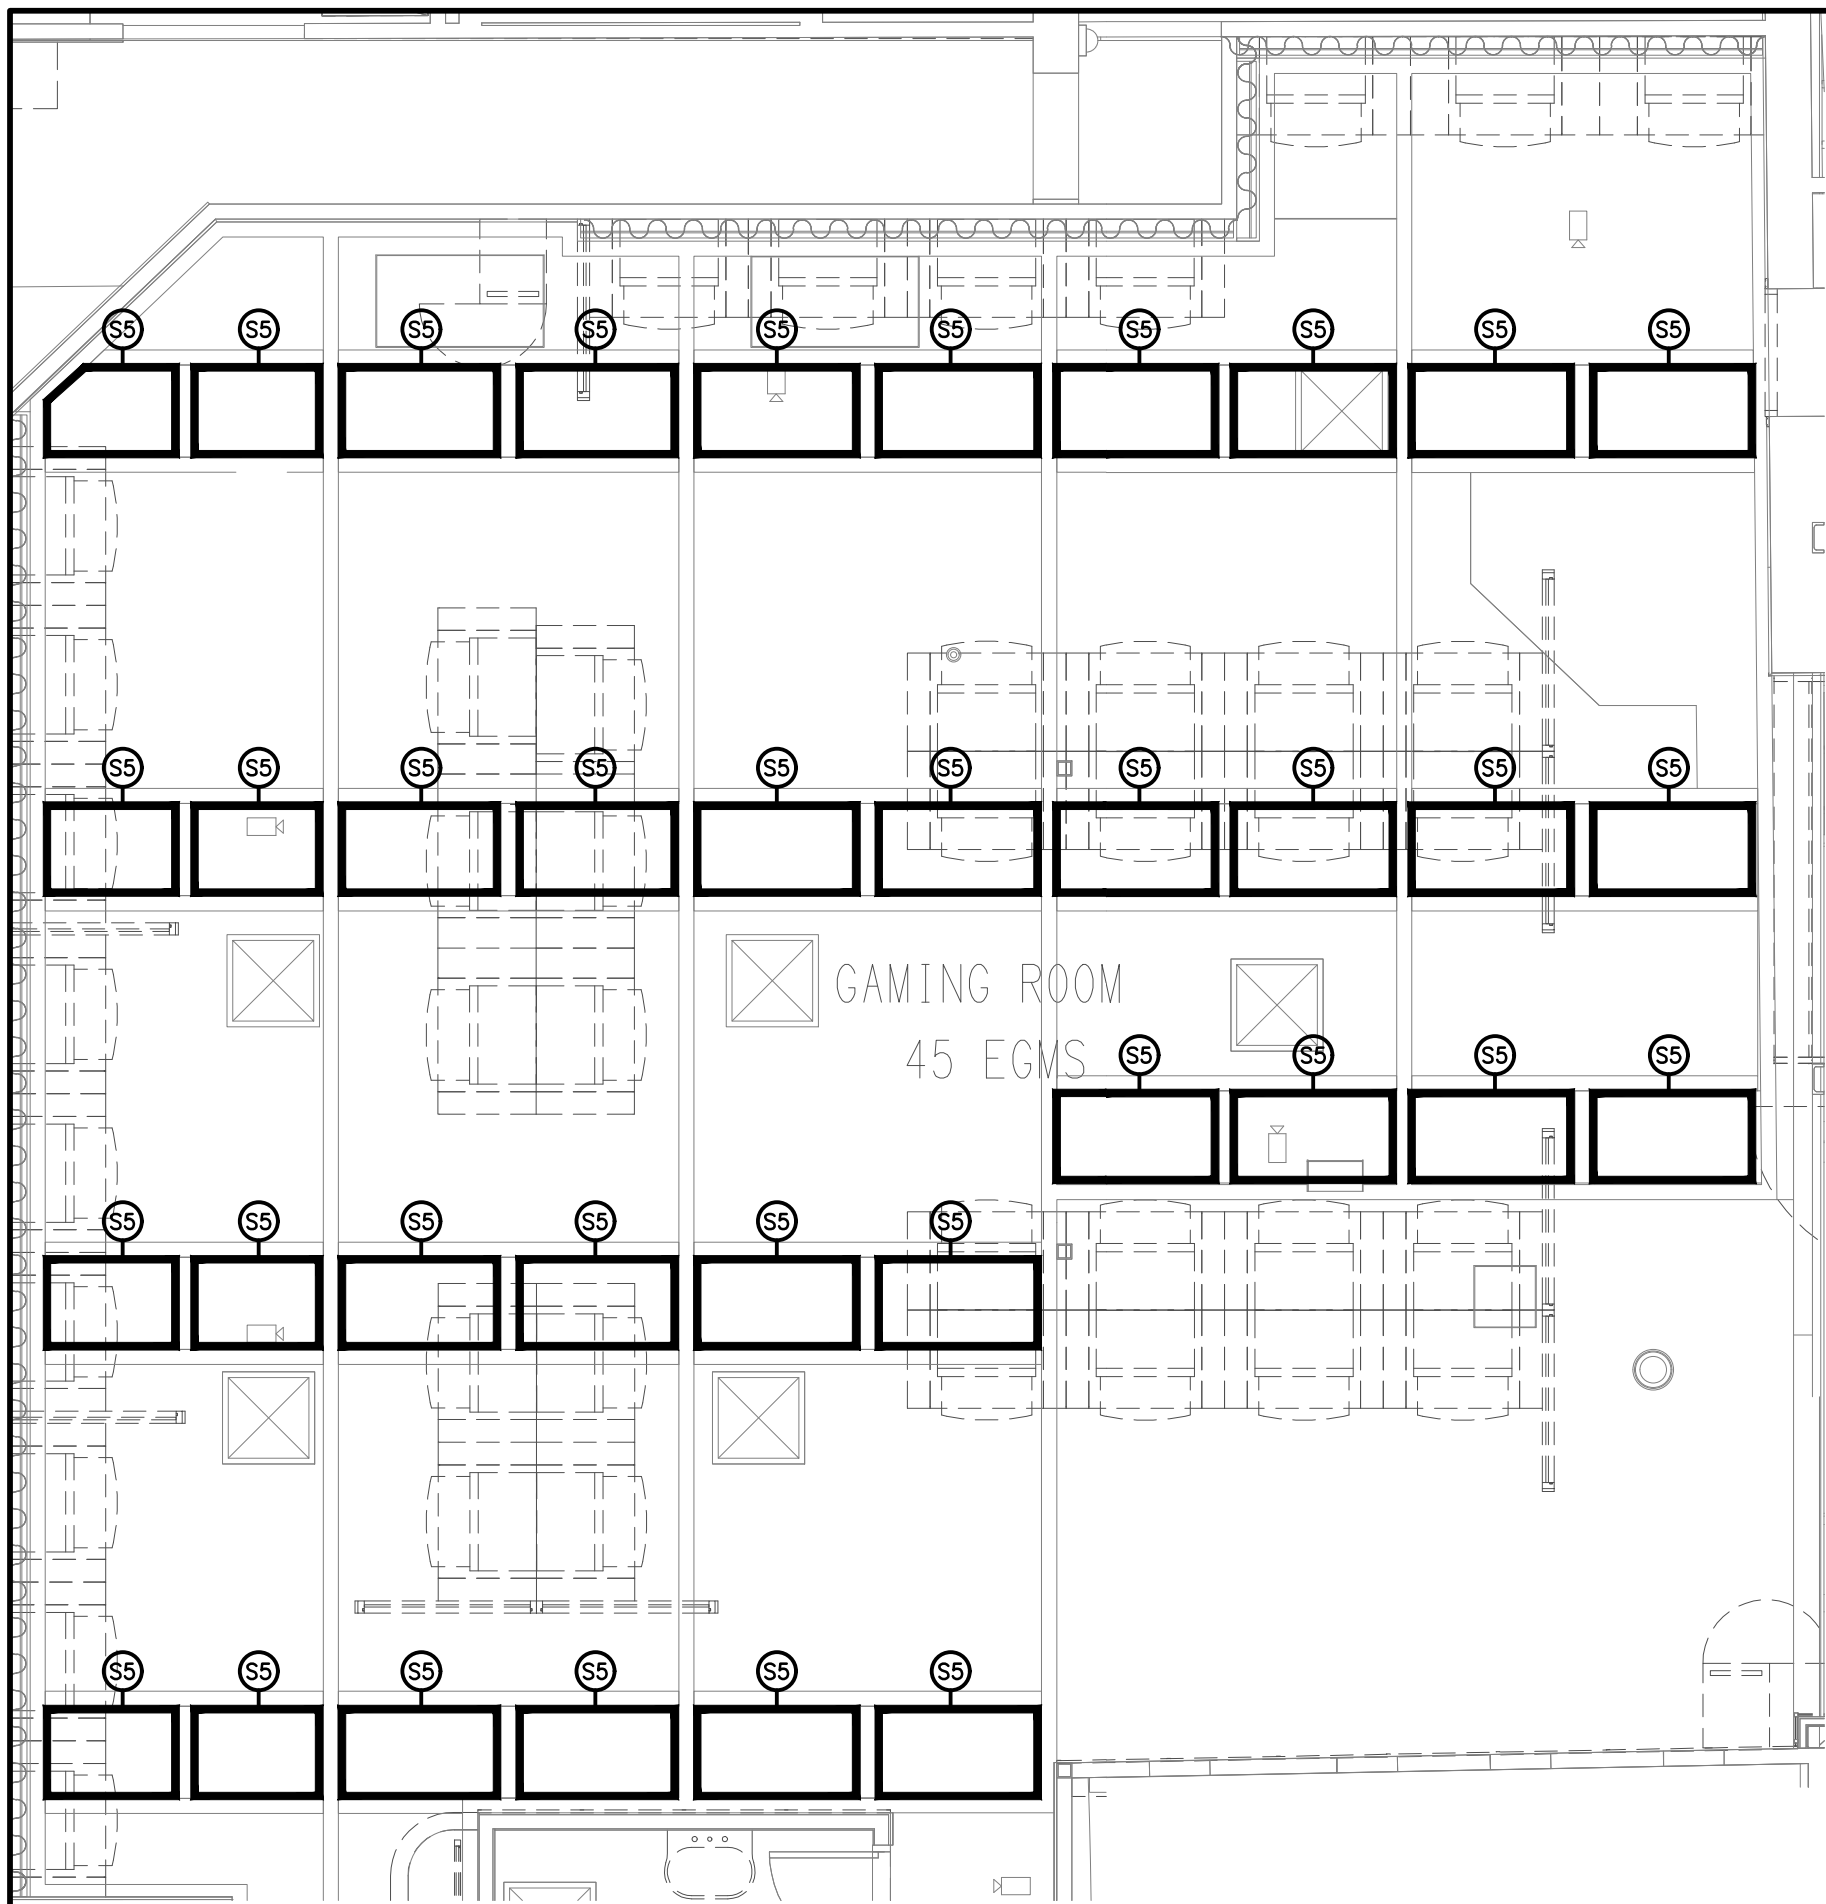


DETAIL B
GAMING ROOM S5 FEATURE LIGHTING PLAN
SCALE 1: 50

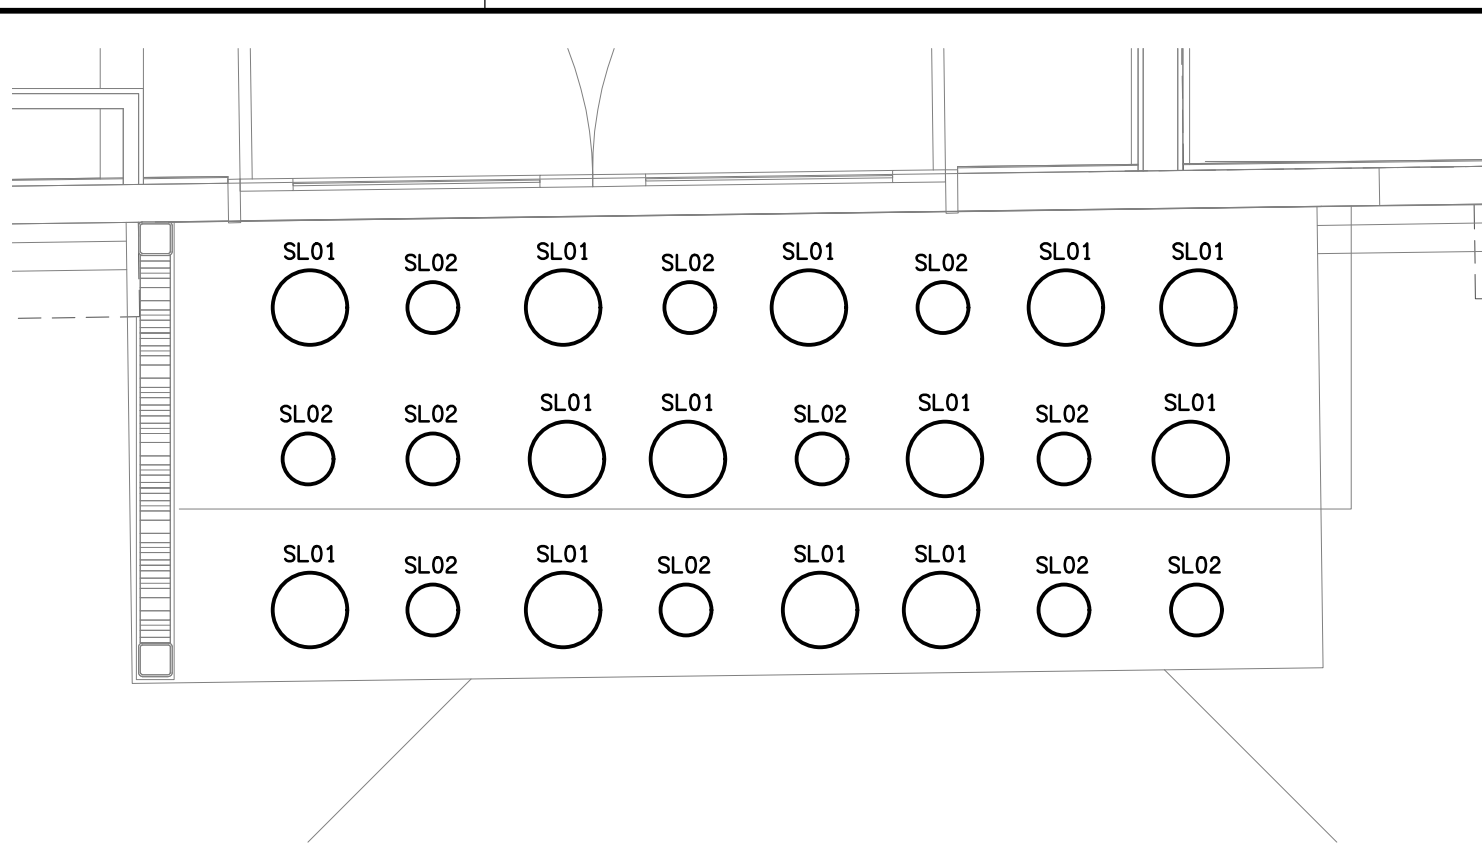


DETAIL A
ENTRY FEATURE LIGHTING PLAN
SCALE 1: 20

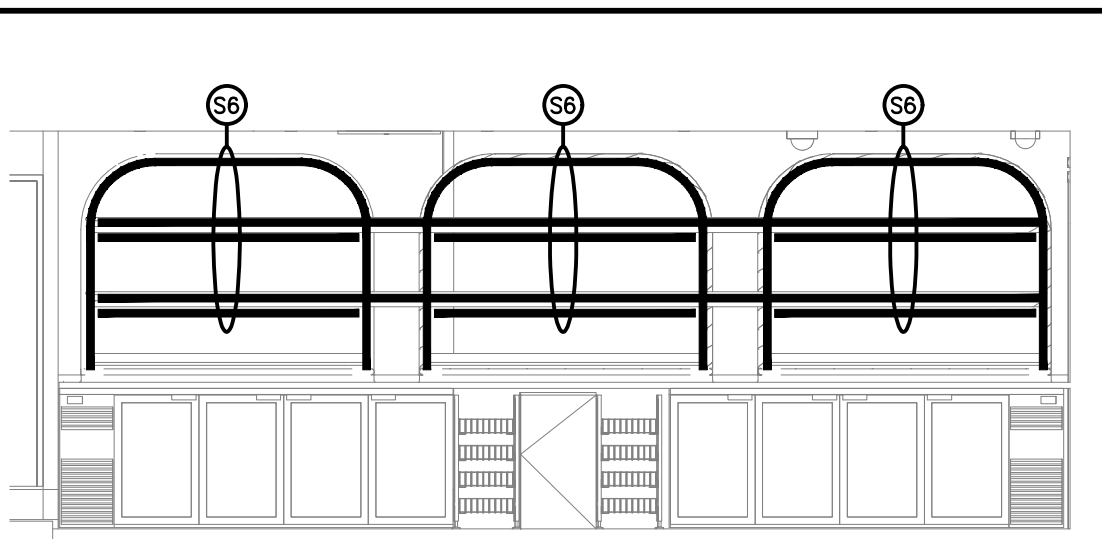

DETAIL B
GAMING BAR REAR WALL ELEVATION
SCALE 1: 50

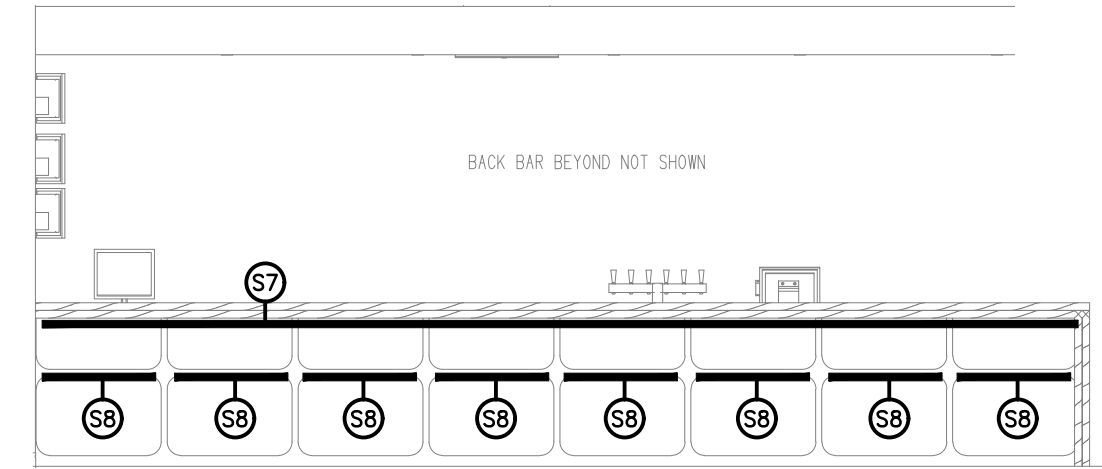

DETAIL C
GAMING BAR FRONT COUNTER ELEVATION
SCALE 1: 50

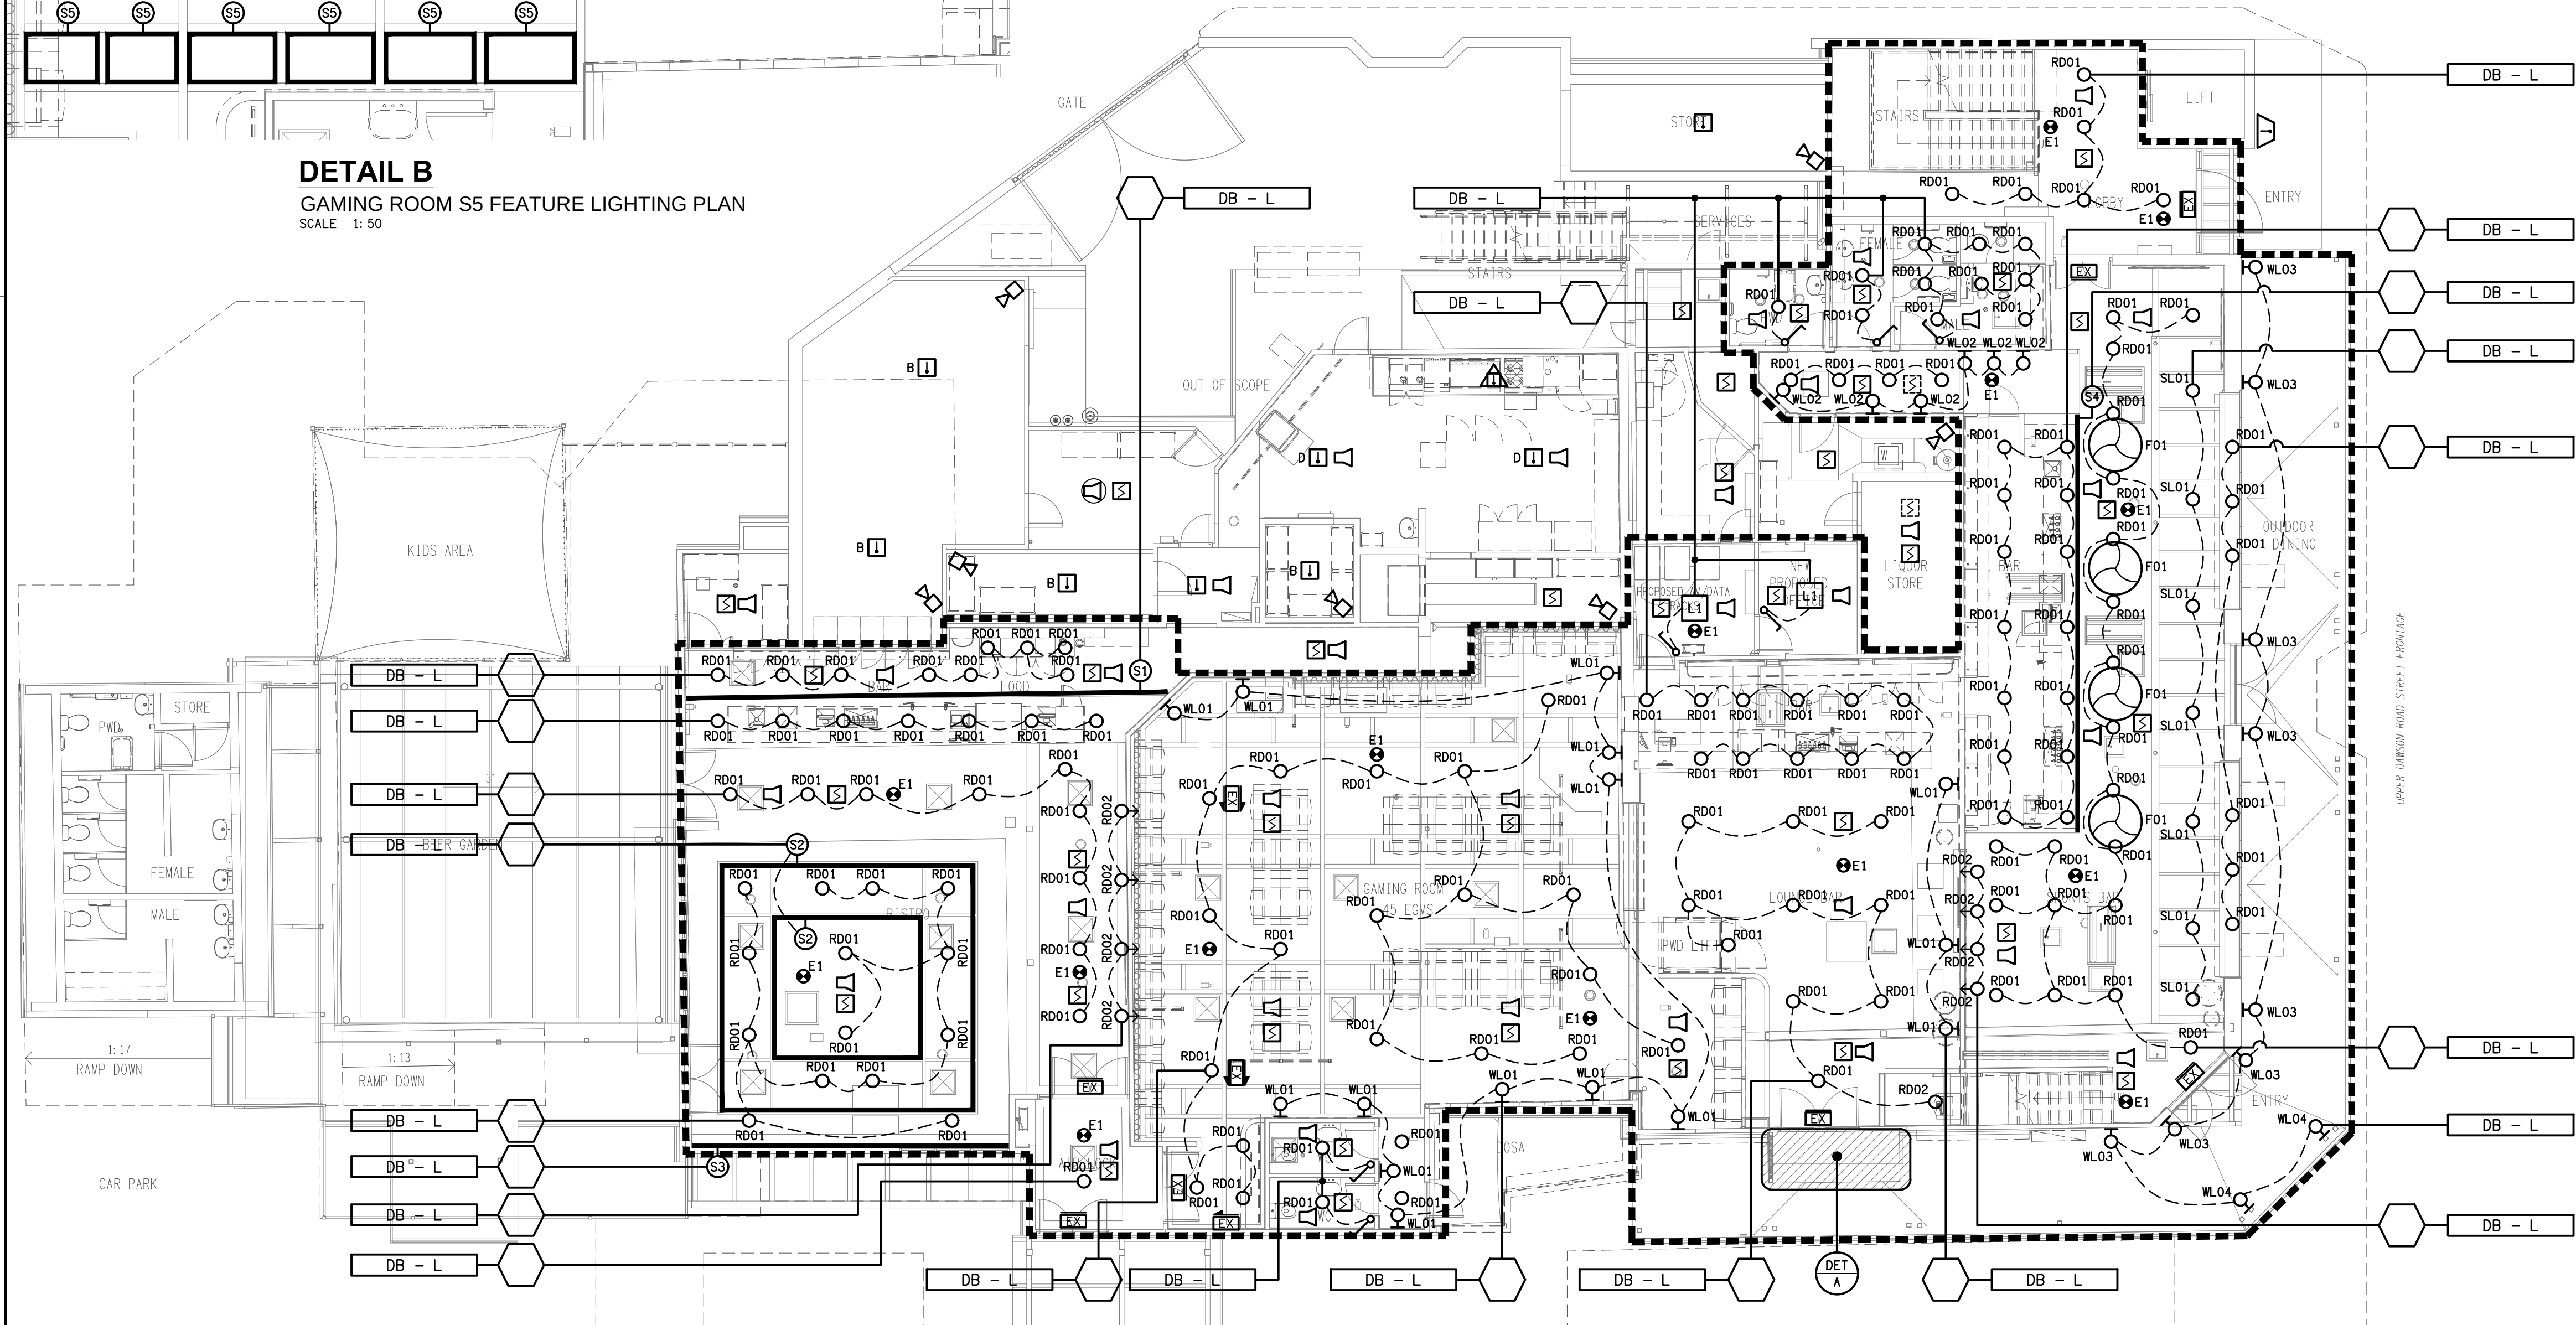

LEVEL 1
REFLECTED CEILING PLAN
SCALE 1: 100

