



ELECTRICAL DESIGN GROUP

ELECTRICAL BUILDING SERVICES CONSULTANTS

P.O. Box 15, SHERWOOD Q. 4075

Phone: (07) 3278 4375

Website: www.edg.net.au Email: brisbane@edg.net.au

C3685a - ALLENSTOWN HOTEL

C3685a-0001(A).xls

ELECTRICAL SERVICES CONTRACT DOCUMENT SCHEDULE

 
REVISION A - 08 AUGUST 2026

ISSUING INFORMATION				DATE OF ISSUE							
				DAY	07						
				MONTH	08						
				YEAR	26						
				REASON FOR ISSUE	P						
A = APPROVAL				C = CONSTRUCTION				N = COORDINATION			
				P = PRELIMINARY				T = TENDER			

DISTRIBUTION				NUMBER OF COPIES							
WWW.EDG.NET.AU				1E							
CAYAS & WARD				1E							
P = PRINT				T = TRACING				D = DISC			
				E = EMAIL				F = FAX			


DOCUMENTS				REVISION							
C3685a-E01.dwg	LEGEND			A							
C3685a-E02.dwg	NOTES			A							
C3685a-E03.dwg	FLOOR PLANS			A							
C3685a-E04.dwg	REFLECTED CEILING PLANS			A							
C3685a-0001.xls	CONTRACT DOCUMENT SCHEDULE			A							
C3685a-0002.xls	EQUIPMENT SCHEDULE										
C3685a-0004.xls	LIGHTING CONTROL SCHEDULE										
C3685a-0005.xls	DISTRIBUTION BOARD DB-A SCHEDULE										
C3685a-0006.xls	DISTRIBUTION BOARD DB-B SCHEDULE										
C3685a-0001.zip	FITTING & OUTLET DATASHEETS										

LEGEND


-  ELECTRICAL SERVICES SWITCHBOARD.
-  SWITCHBOARD / CONTROL PANEL NOT PROVIDED AS PART OF THE ELECTRICAL SUBCONTRACT.
-  SINGLE POWER OUTLET.
-  DOUBLE POWER OUTLET.
-  EXIST  EXISTING POWER OUTLET TO REAMIN AS NOTED.
-  SIGNAGE CONNECTION.
-  SPx LIGHTING CONTROL SWITCHPANEL, TYPE x.
-  ONE-WAY LIGHT SWITCH.
-  CIRCUIT LINE.
-  SWITCH LINE.
-  DB-x - Py POWER CIRCUIT DESIGNATION. DENOTES DB AND CIRCUIT.
-  LIGHTING CONTROL CHANNEL REFERENCE.
-  ELECTRICAL EQUIPMENT AS NOTED.
-  REFER TO DETAIL NOTED FOR THE AREA SHOWN HATCHED. ADDITIONAL OUTLETS & FITTINGS MAY BE SHOWN ON DETAIL.
-  E1  E1: GENERAL CEILING RECESSED LED EMERGENCY LIGHT, WHITE.
-  EX: EMERGENCY LED EXIT LIGHT, WHITE.
-  FIP FIRE INDICATOR PANEL.
-  SMOKE DETECTOR.
-  CONCEALLED SPACE SMOKE DETECTOR.
-   ASPIRATING SMOKE DETECTOR.
-  THERMAL DETECTOR. TYPE x.
-  THERMAL DUCT PROBE DETECTOR.
-  RECESSES FIRE ALARM SPEAKER.
-  SURFACE MOUNTED FIRE ALARM SPEAKER.
-  FIRE ALARM HORN SPEAKER.
-  VISUAL INDICATOR.
-  WL01  WL01: DECORATIVE WALL LIGHT.
-  WL02  WL02: DECORATIVE WALL LIGHT.
-  WL03  WL03: DECORATIVE WALL LIGHT.
-  WL04  WL04: DECORATIVE WALL LIGHT.

LEGEND

-  RD01  RD01: 90 DIA RECESSED DOWNLIGHT, WHITE.
-  RD02  RD02: ADJUSTABLE 75 DIA RECESSED DOWNLIGHT, WHITE.
-  F01: CEILING FAN AND CONTROLS.
-  SL01  SL01: LARGE DECORATIVE SURFACE MOUNTED SPHERE.
-  SL02  SL02: SMALL DECORATIVE SURFACE MOUNTED SPHERE.
-  L1: 600 X 600 FLATE PANEL LIGHT C/W PB RECESS KIT.
-  S1: WARM WHITE STRAIGHT LED STRIP LIGHT RECESSED INTO THE CEILING.
-  S2: WARM WHITE STRAIGHT LED STRIP LIGHT RECESSED INTO THE CEILING.
-  S3: WARM WHITE STRAIGHT LED STRIP LIGHT RECESSED INTO THE CEILING.
-  S4: WARM WHITE STRAIGHT LED STRIP LIGHT RECESSED INTO THE CEILING.
-  S5: WARM WHITE STRAIGHT LED STRIP LIGHT CONFIGURED IN A RECTANGLE RECESSED INTO THE GAMING CEILING.
-  S6: WARM WHITE FLEXIBLE LED STRIP LIGHT MOUNTED WITHIN THE REAR BAR JOINERY.
-  S7: WARM WHITE STRAIGHT LED STRIP LIGHT MOUNTED WITHIN THE BAR FRONT.
-  S8: WARM WHITE STRAIGHT LED STRIP LIGHT MOUNTED WITHIN THE BAR FRONT.
-  TRL02  TRL02: SURFACE MOUNTED TRACK LIGHT.
-  LP01  LP01: ACOMMODATION DECORATIVE WALL LIGHT.
-  LP03  LP03: ACCOMMODATION CORRIDOR CEILING LIGHT.
-  LP04  LP04: ACCOMMODATION CEILING LIGHT.
-  LP07  LP07: ACCOMMODATION CEILING LIGHT.

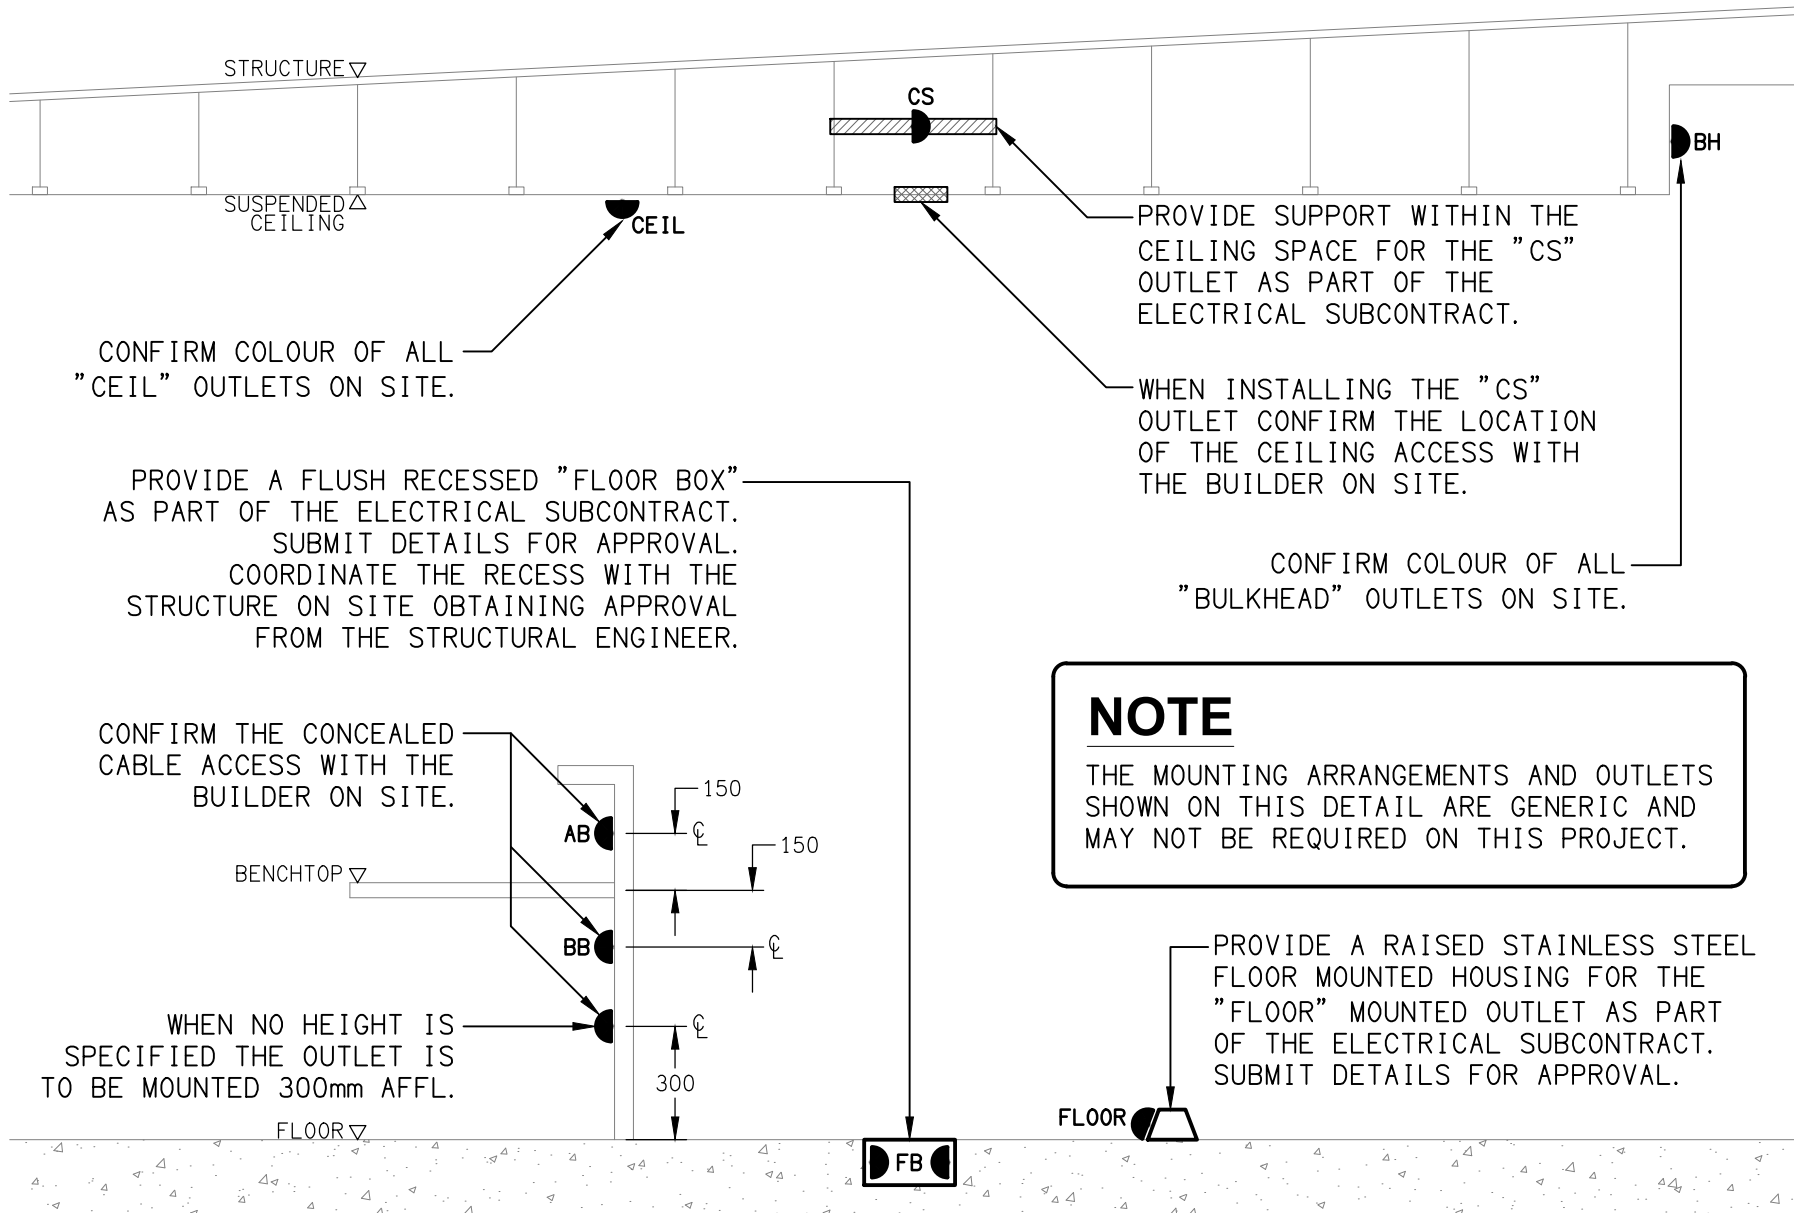


DETAIL
TYPICAL OUTLET MOUNTINGS
NOT TO SCALE

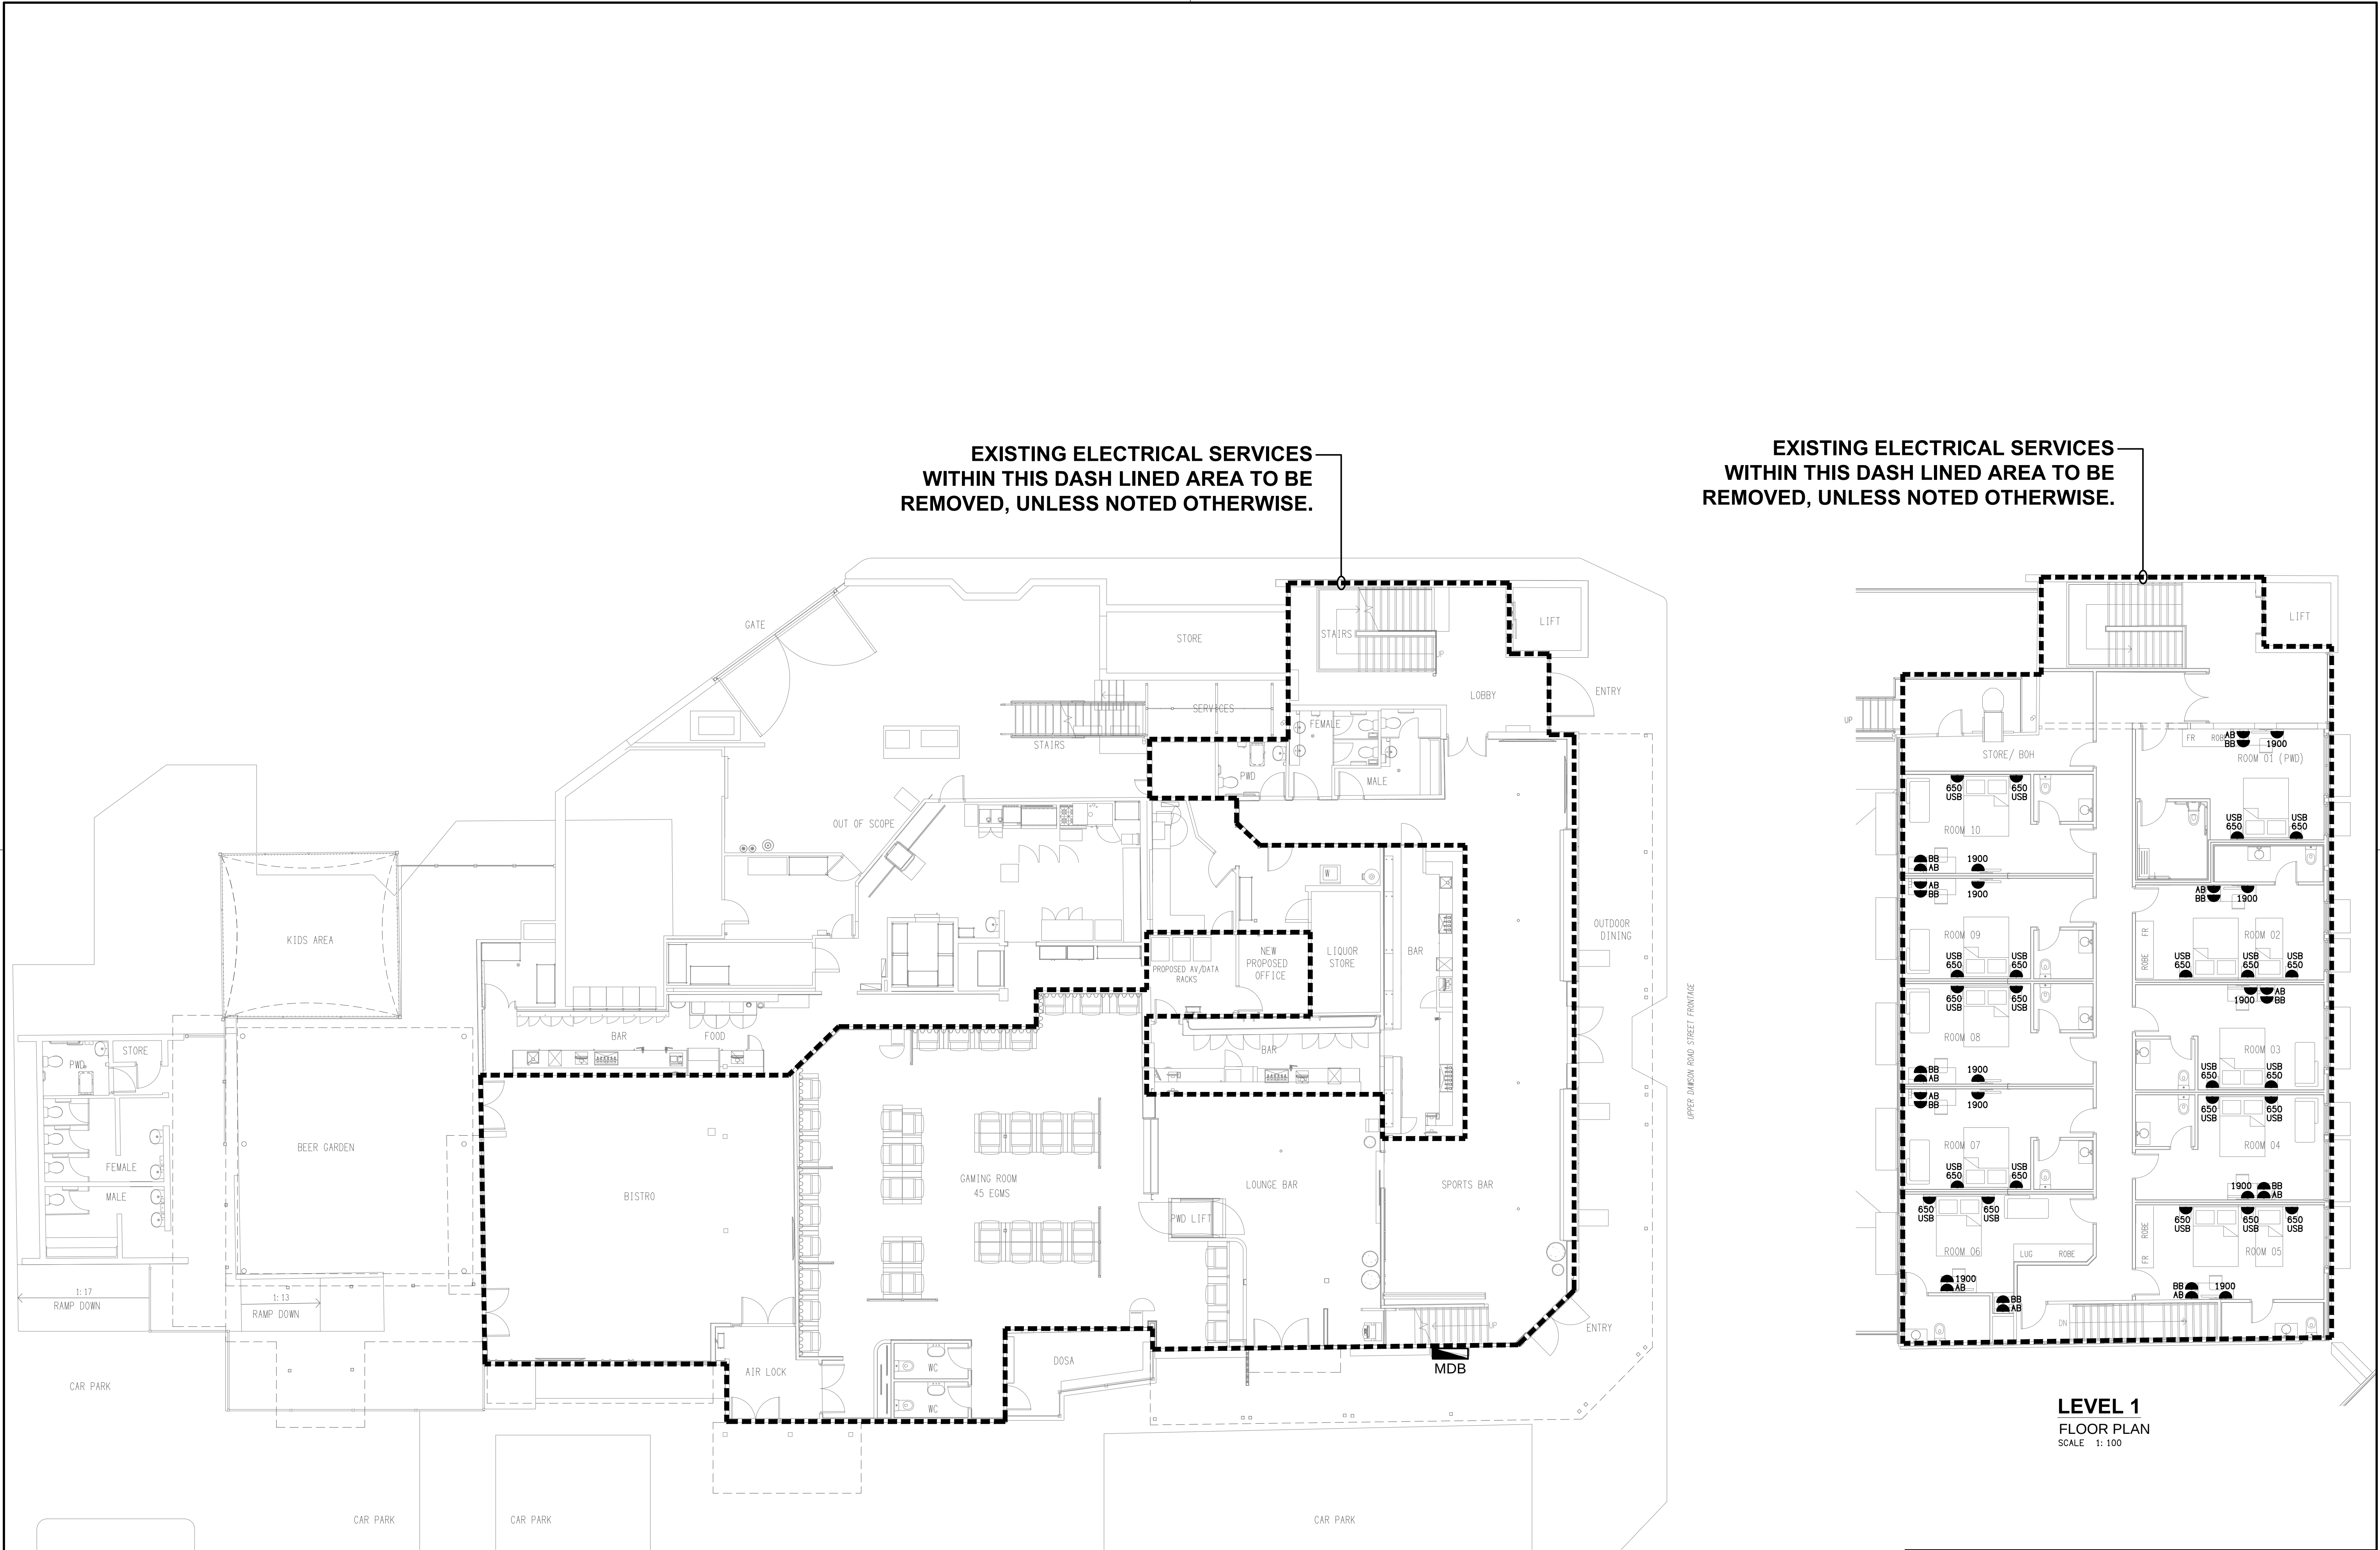


LEVEL 1
FLOOR PLAN
SCALE 1: 100


ELECTRICAL DESIGN GROUP BRISBANE PTY LTD ACN 092 710 793 TRADING AS: ELECTRICAL DESIGN GROUP		THE COPYRIGHT OF THIS DRAWING REMAINS THE PROPERTY OF THE ELECTRICAL DESIGN GROUP. USE FIGURED DIMENSIONS IN PREFERENCE TO SCALE. ALL DIMENSIONS TO BE VERIFIED ONSITE.		ELECTRICAL DESIGN GROUP ELECTRICAL BUILDING SERVICES CONSULTANTS BRISBANE GOLD COAST P.O.Box 15, Sherwood Q.4075 Phone: (07) 3278 4375 Email: brisbane@edg.net.au Web: www.edg.net.au		PROJECT: ALLENSTOWN HOTEL 14 UPPER DAWSON ROAD, ALLENSTOWN, ROCKHAMPTON, QLD		DRAWING: ELECTRICAL SERVICES FLOOR PLAN SCALE: 1:100 UNO AT A1 PROJECT NO: C3685a DRAWING NO: E03 REVISION: A		
--	--	--	--	--	--	--	--	---	--	--

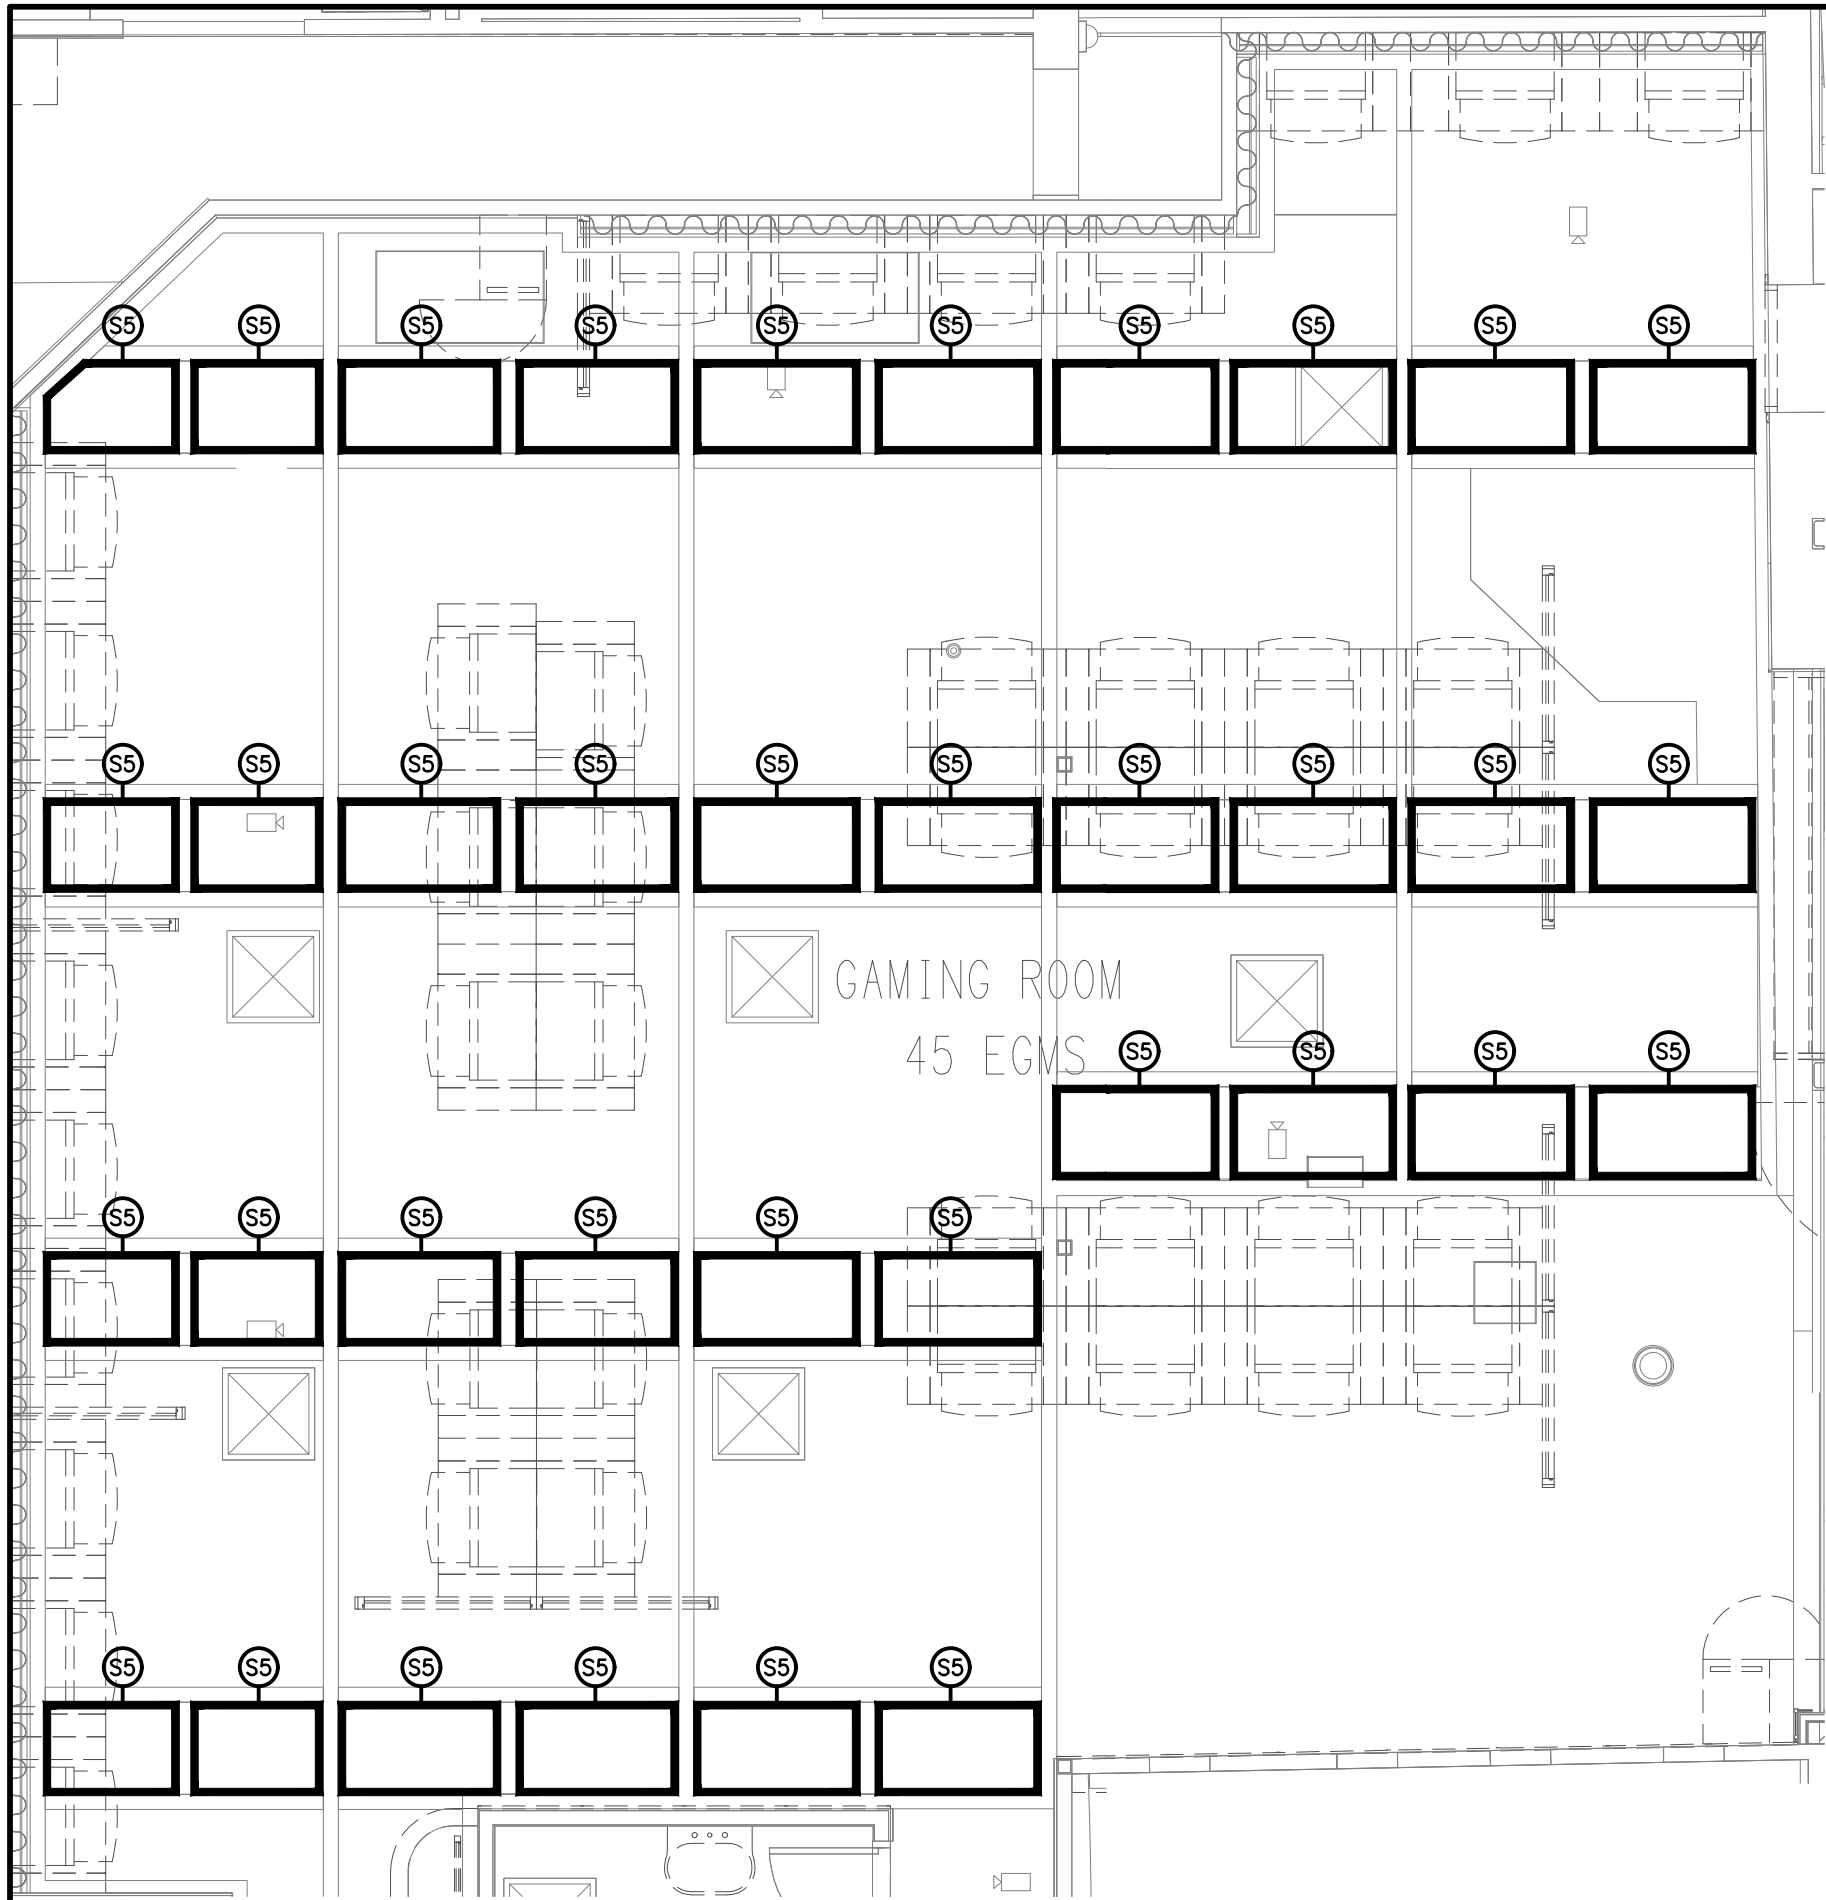


DETAIL B
GAMING ROOM S5 FEATURE LIGHTING PLAN
SCALE 1: 50

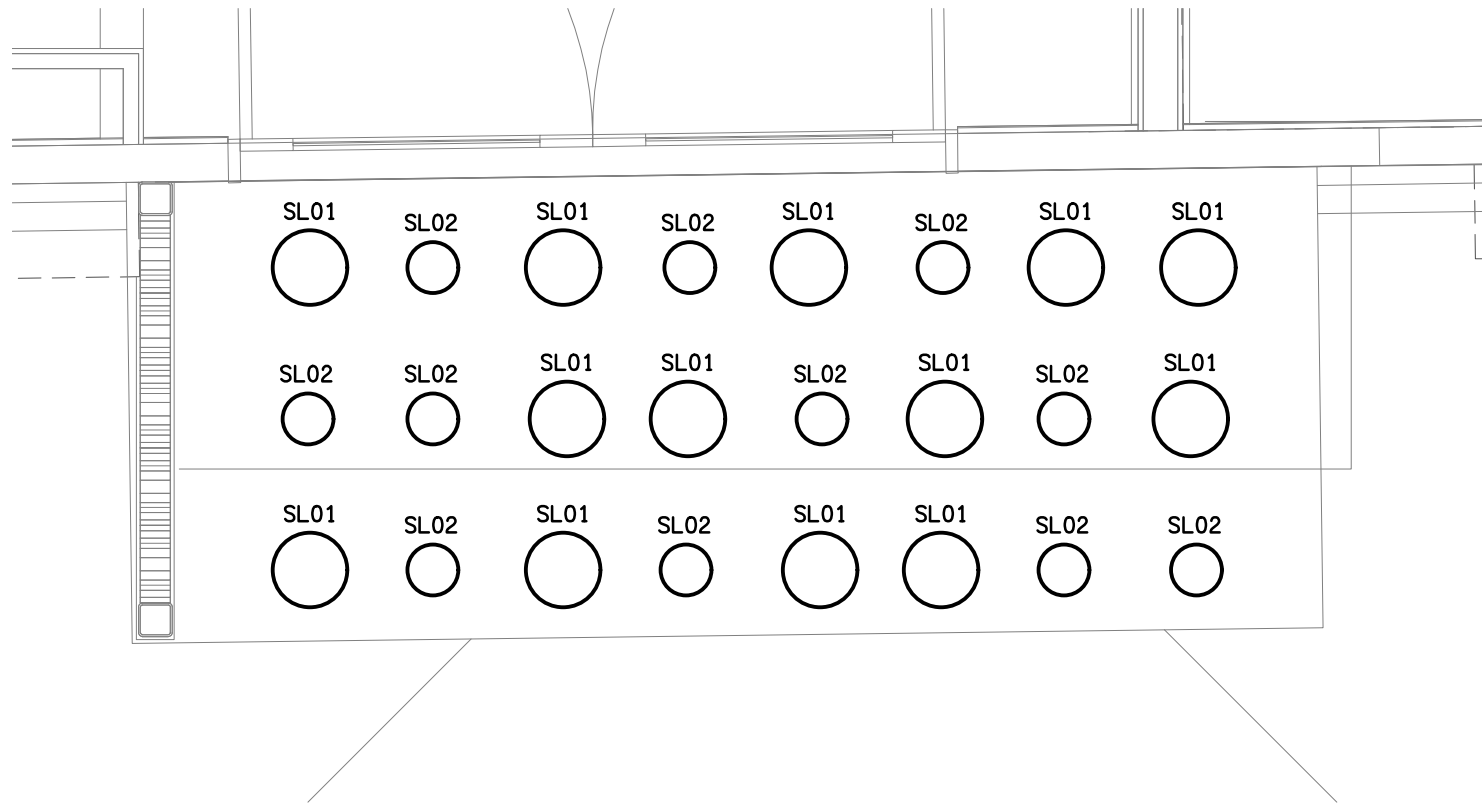


DETAIL A
ENTRY FEATURE LIGHTING PLAN
SCALE 1: 20

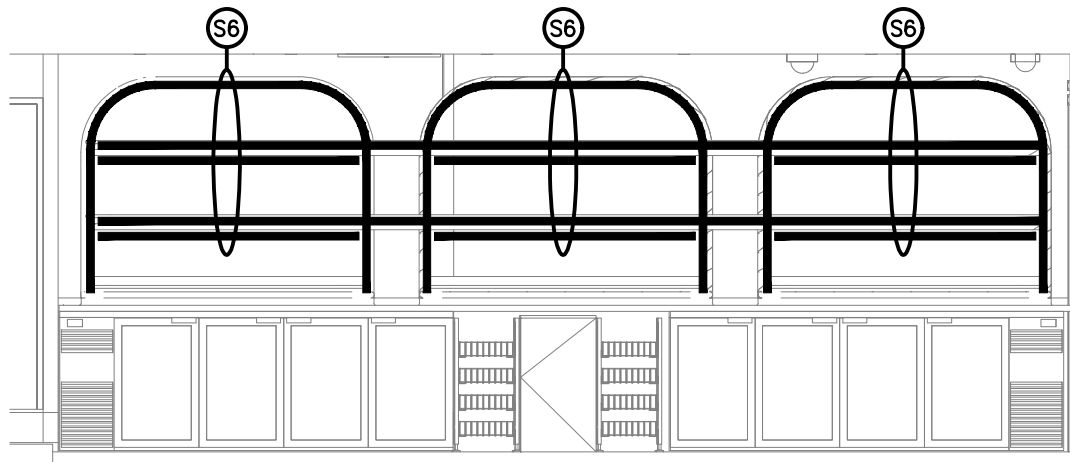

DETAIL B
GAMING BAR REAR WALL ELEVATION
SCALE 1: 50

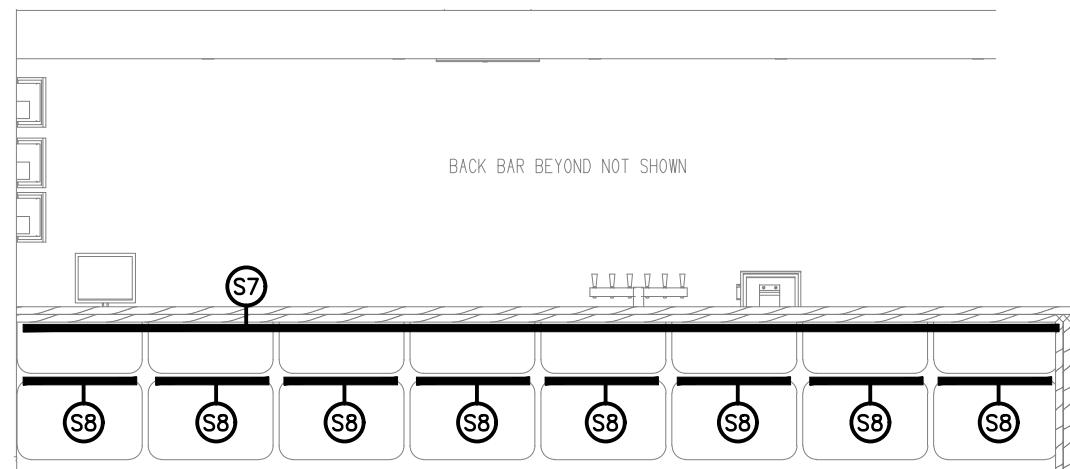

DETAIL C
GAMING BAR FRONT COUNTER ELEVATION
SCALE 1: 50

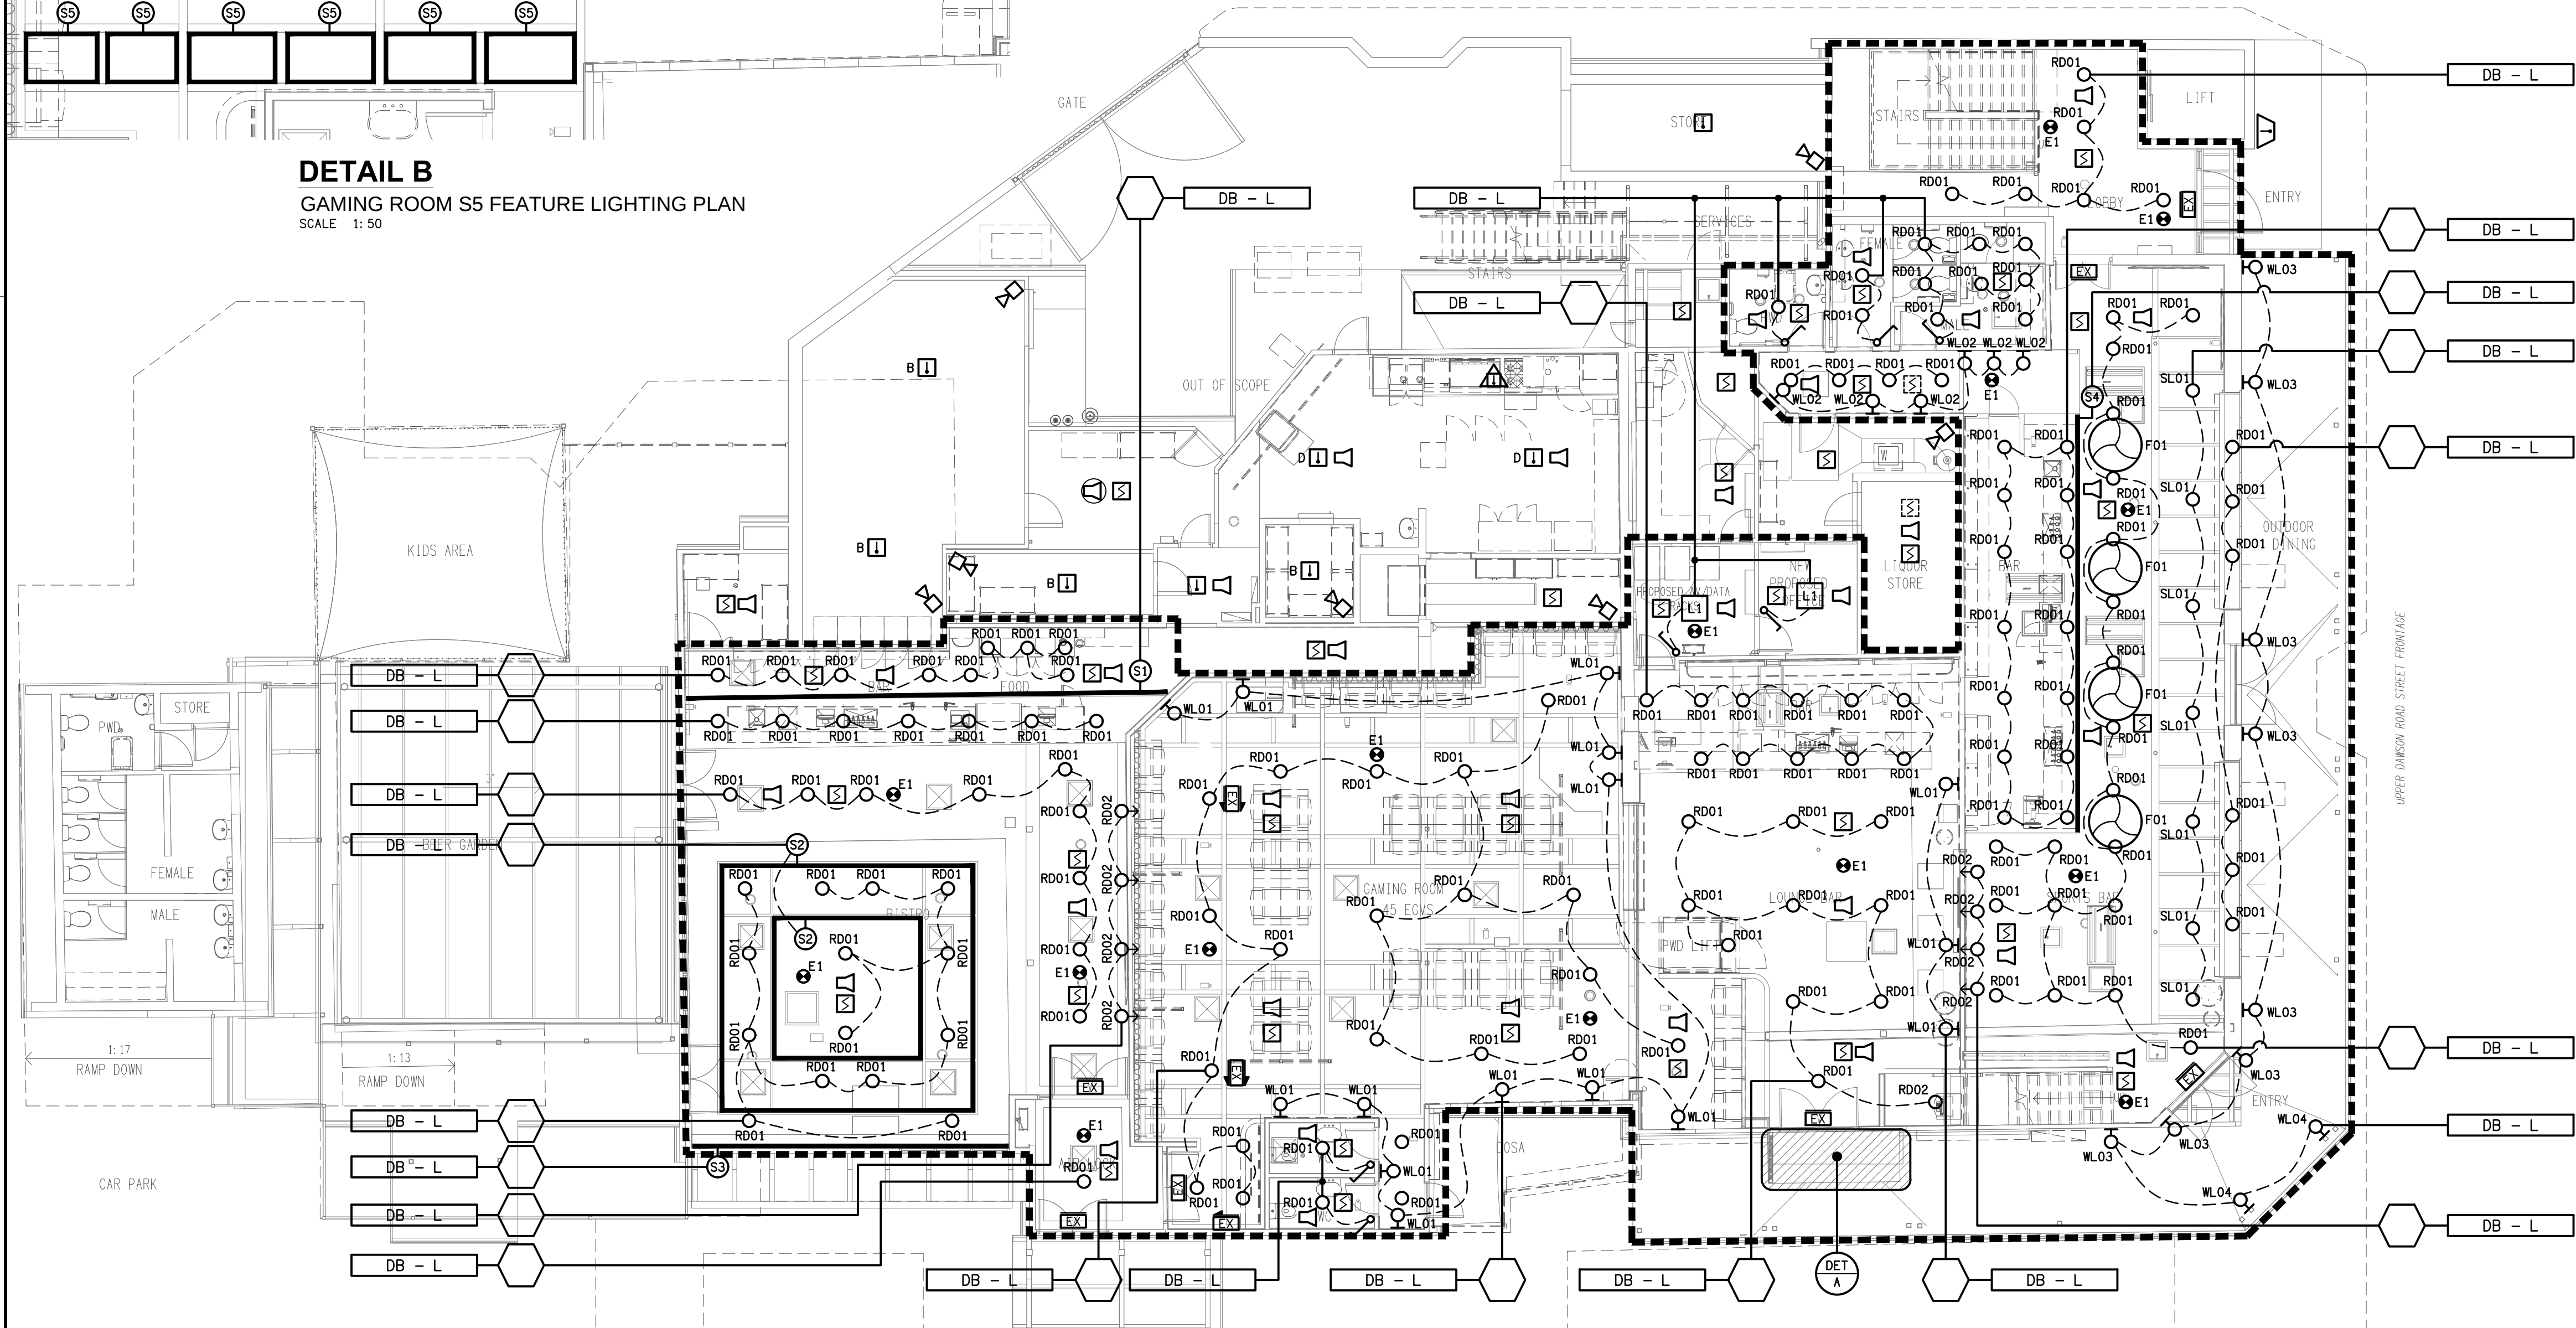

LEVEL 1
REFLECTED CEILING PLAN
SCALE 1: 100

