



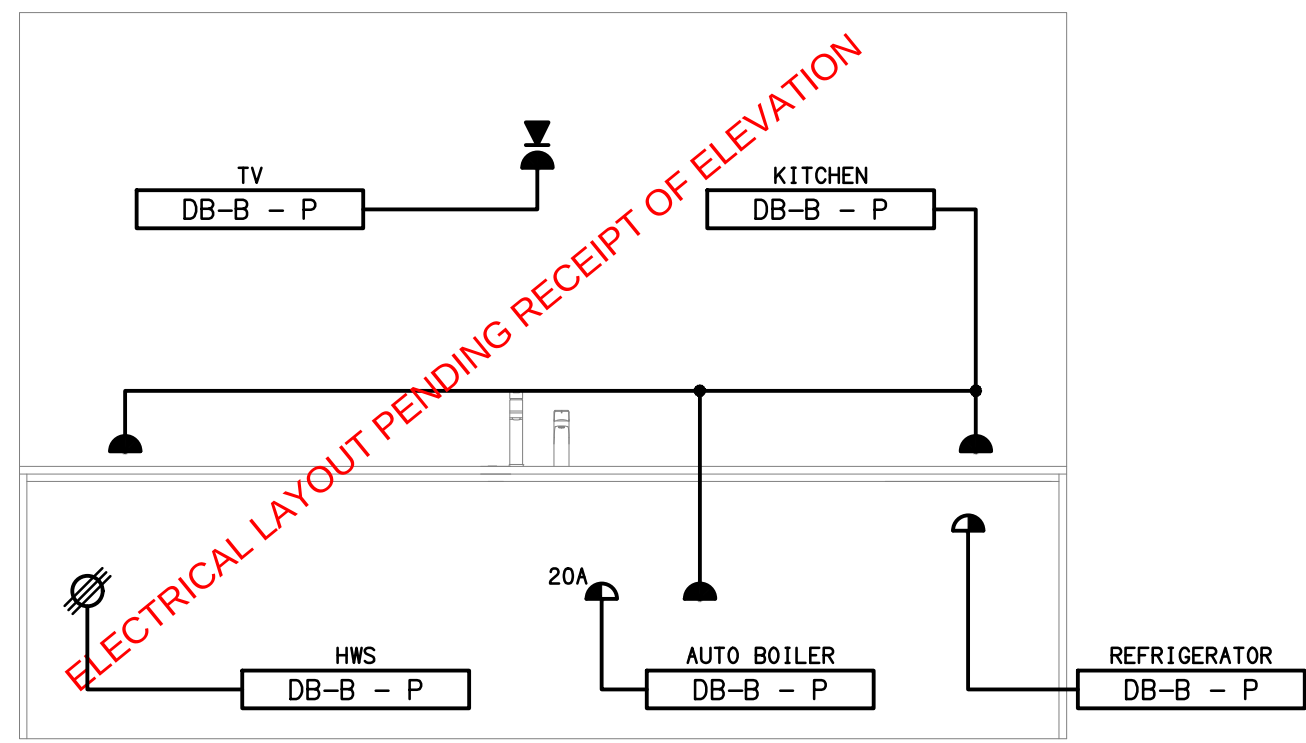


DETAIL A

CUSTOMER KITCHENETTE ELEVATION
SCALE 1: 25

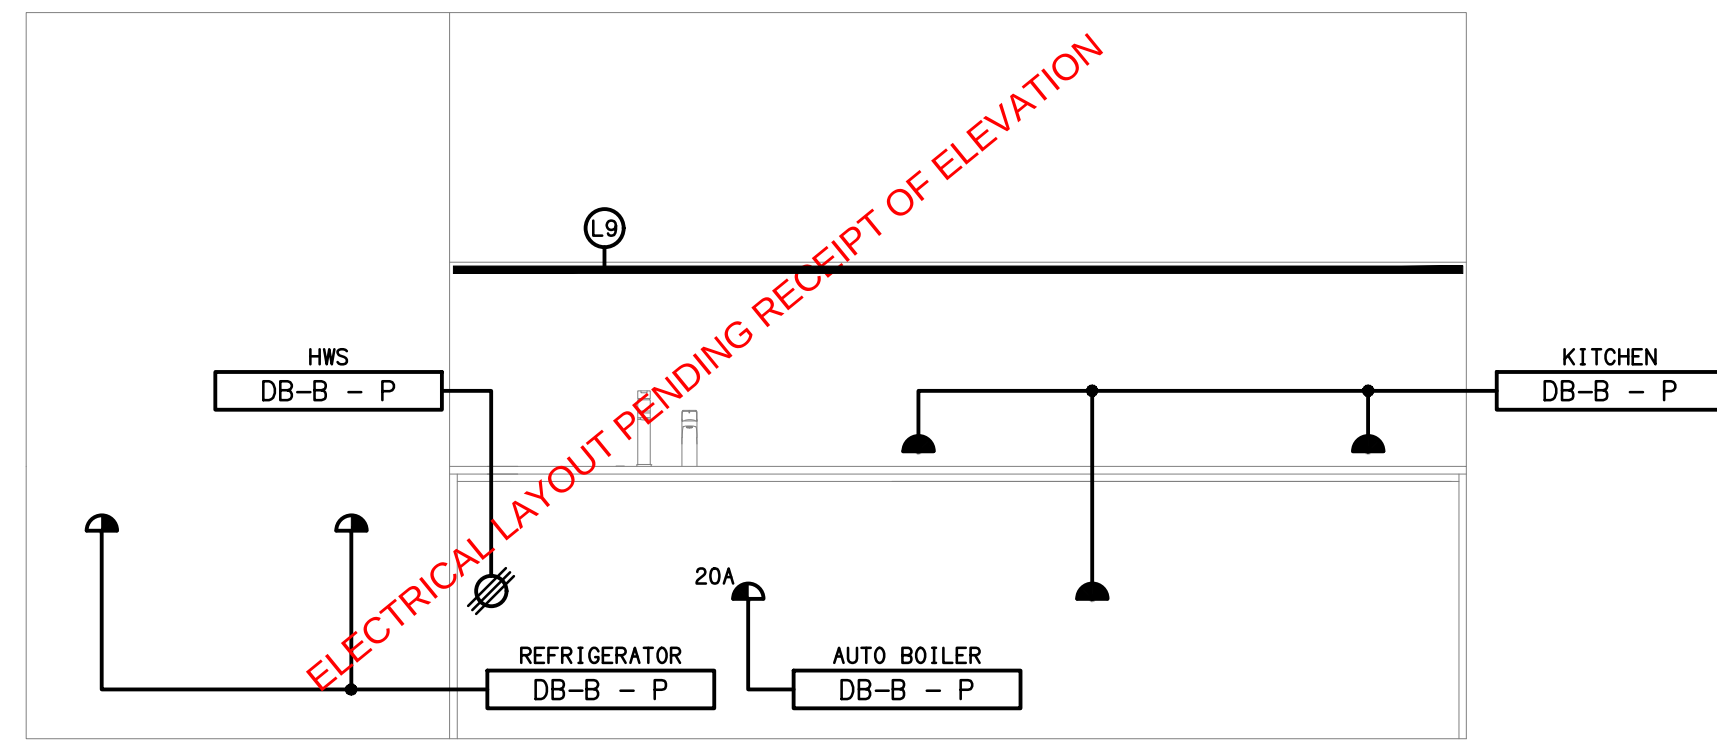


DETAIL B

MEETING KITCHENETTE ELEVATION
SCALE 1: 25

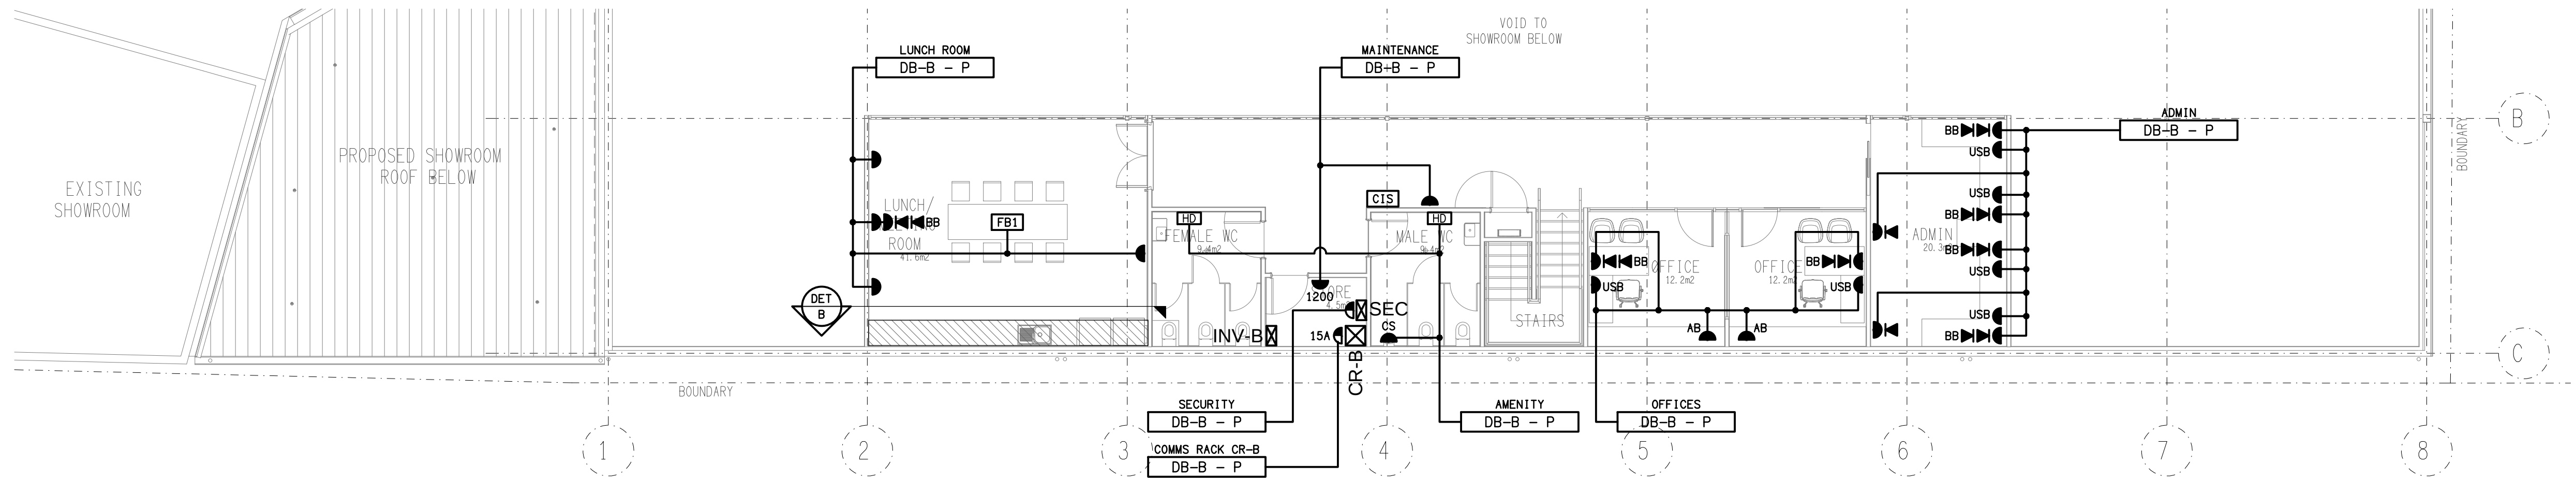

MEZZANINE LEVEL

FLOOR PLAN
SCALE 1: 100

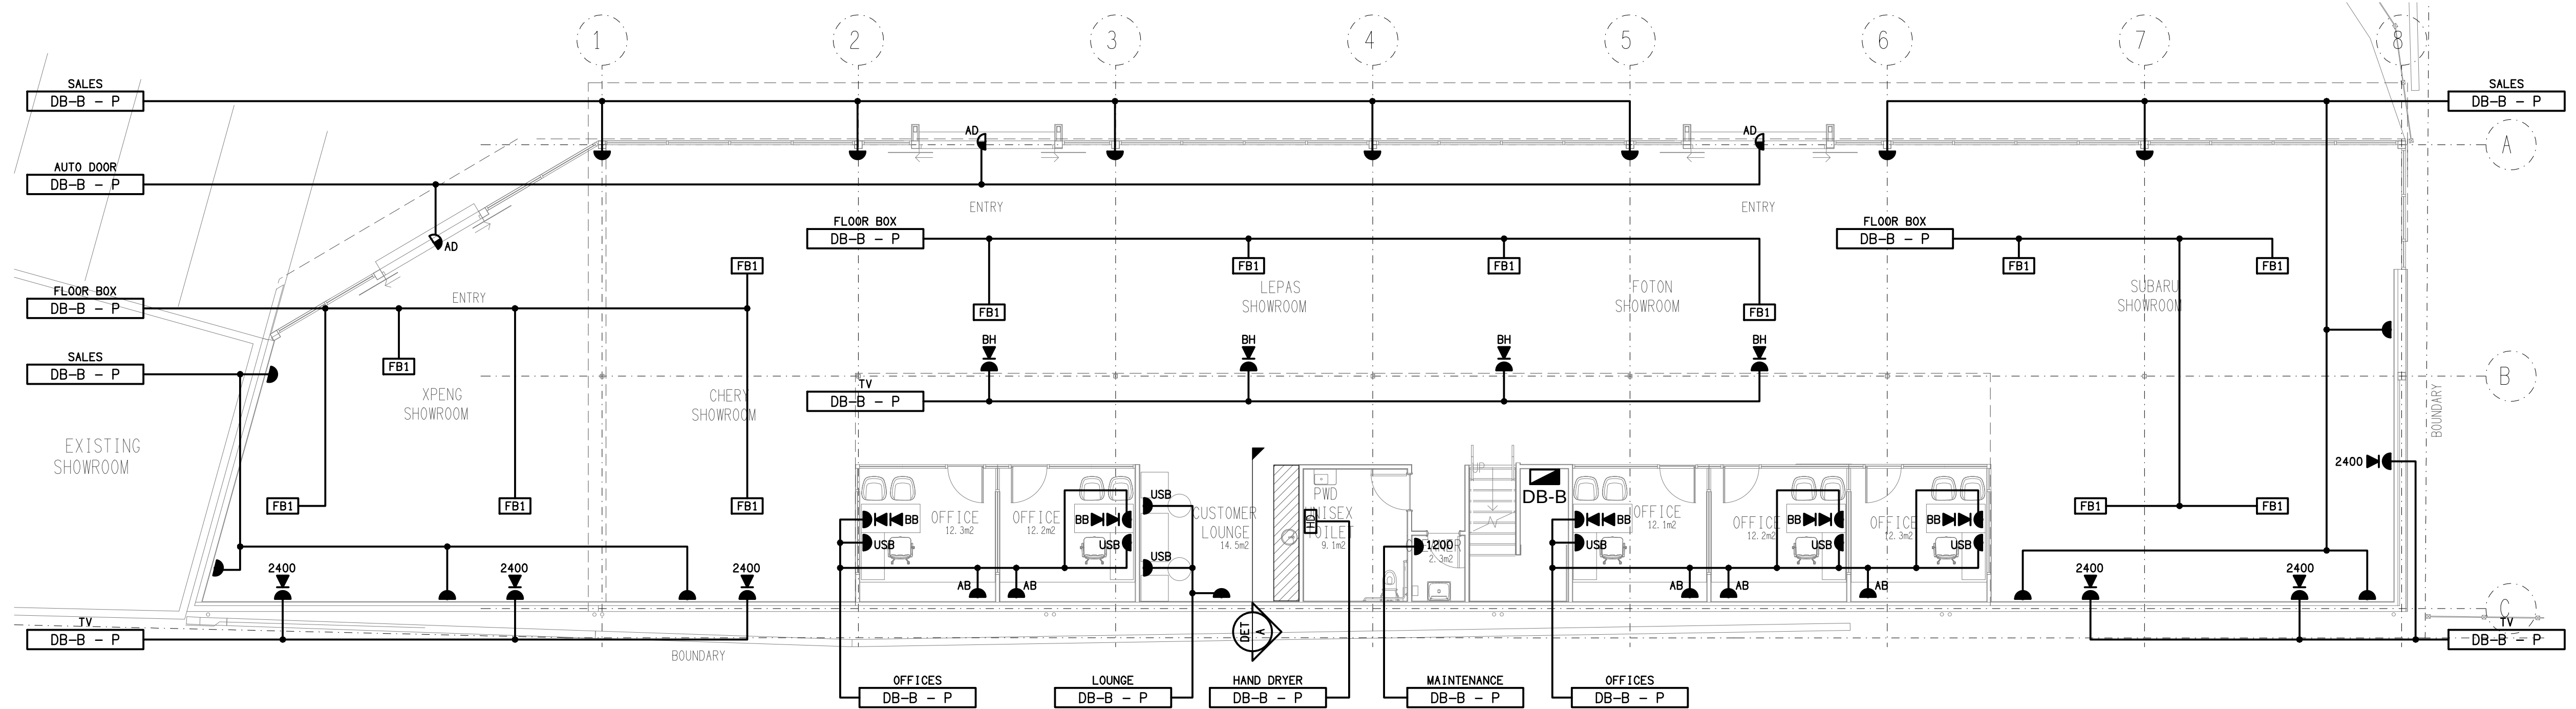

GROUND LEVEL

FLOOR PLAN
SCALE 1: 100

ELECTRICAL DESIGN GROUP BRISBANE
PTY LTD
ACN 092 710 793
TRADING AS:
ELECTRICAL DESIGN GROUP

THE COPYRIGHT OF THIS DRAWING
REMAINS THE PROPERTY OF THE
ELECTRICAL DESIGN GROUP.
USE FIGURED DIMENSIONS
IN PREFERENCE TO SCALE.
ALL DIMENSIONS TO BE
VERIFIED ONSITE.

ELECTRICAL DESIGN GROUP
ELECTRICAL BUILDING SERVICES CONSULTANTS
BRISBANE GOLD COAST

P.O. Box 15, Sherwood Q, 4075
Phone: (07) 3278 4375
Email: brisbane@edg.net.au
Web: www.edg.net.au

PROJECT:
BARTONS - EASTSIDE AUTOMALL

200 TINGAL ROAD, WYNNUM

A	PRELIMINARY	15/07/2026
REV.	DESCRIPTION:	DATE:

DRAWING:
**ELECTRICAL SERVICES
FLOOR PLANS**

SCALE:
1:100 UNO

AT A1

PROJECT NO:
C3694a

DRAWING NO:
E04

REVISION:
A