




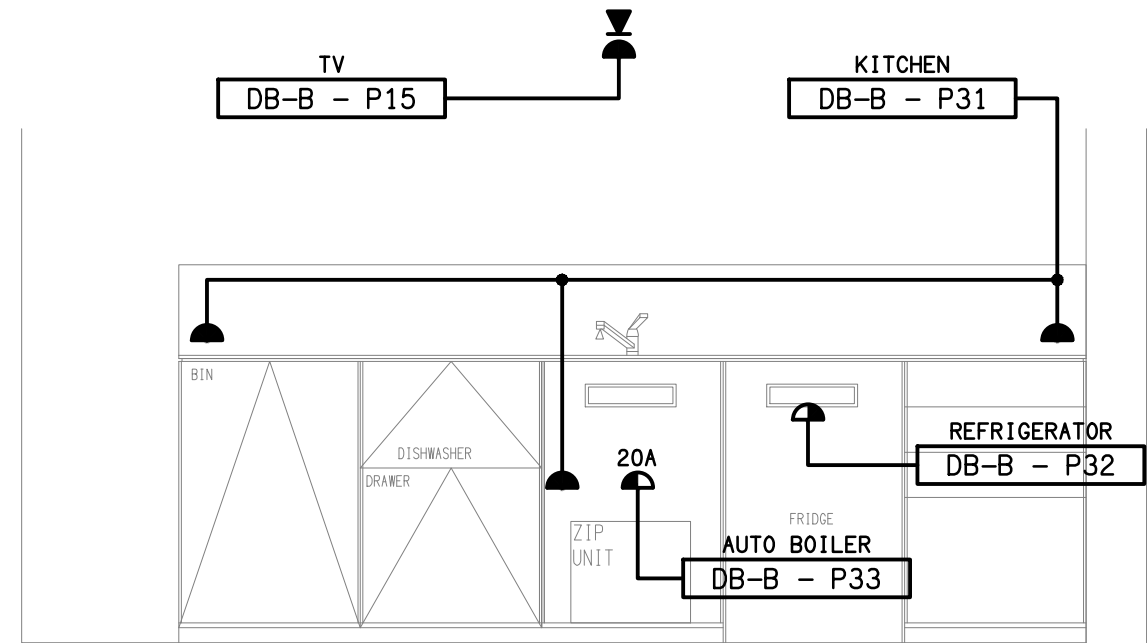


DETAIL A
CUSTOMER KITCHENETTE ELEVATION
SCALE 1: 25

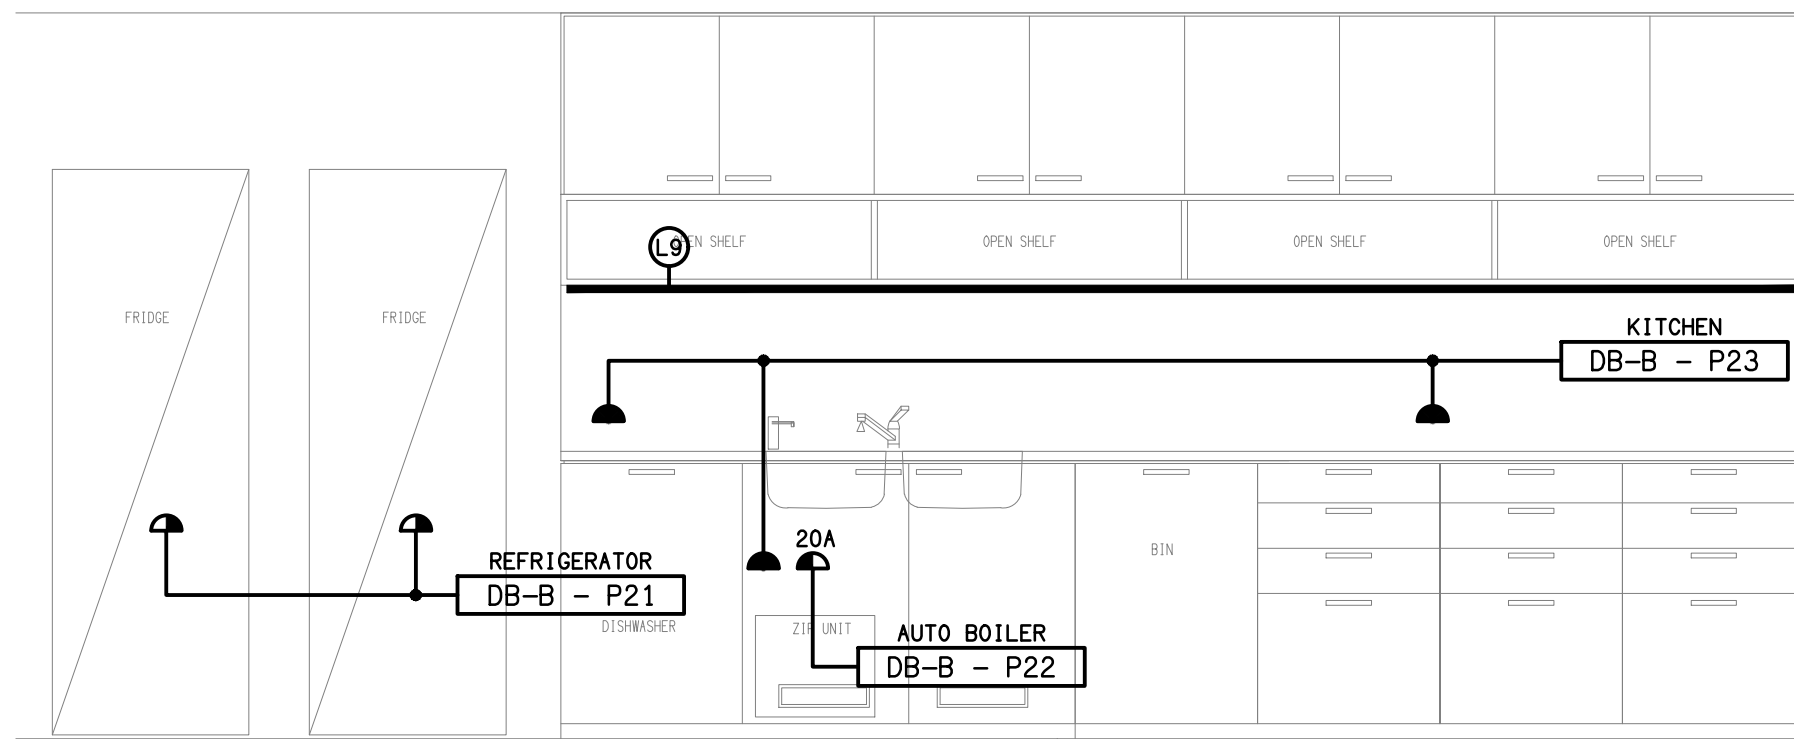

DETAIL B
MEETING KITCHENETTE ELEVATION
SCALE 1: 25

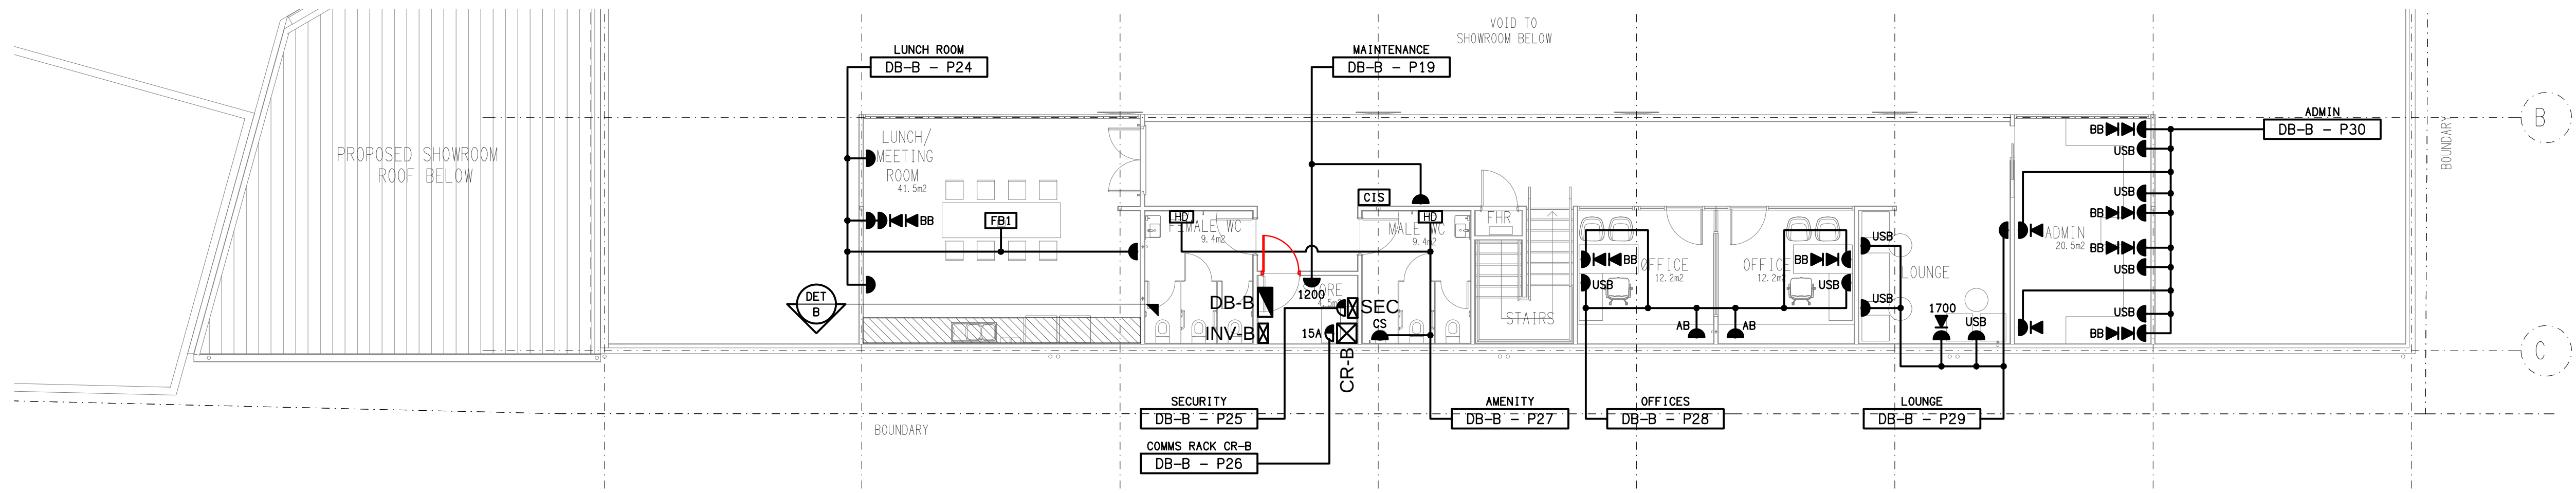

MEZZANINE LEVEL
FLOOR PLAN
SCALE 1: 100

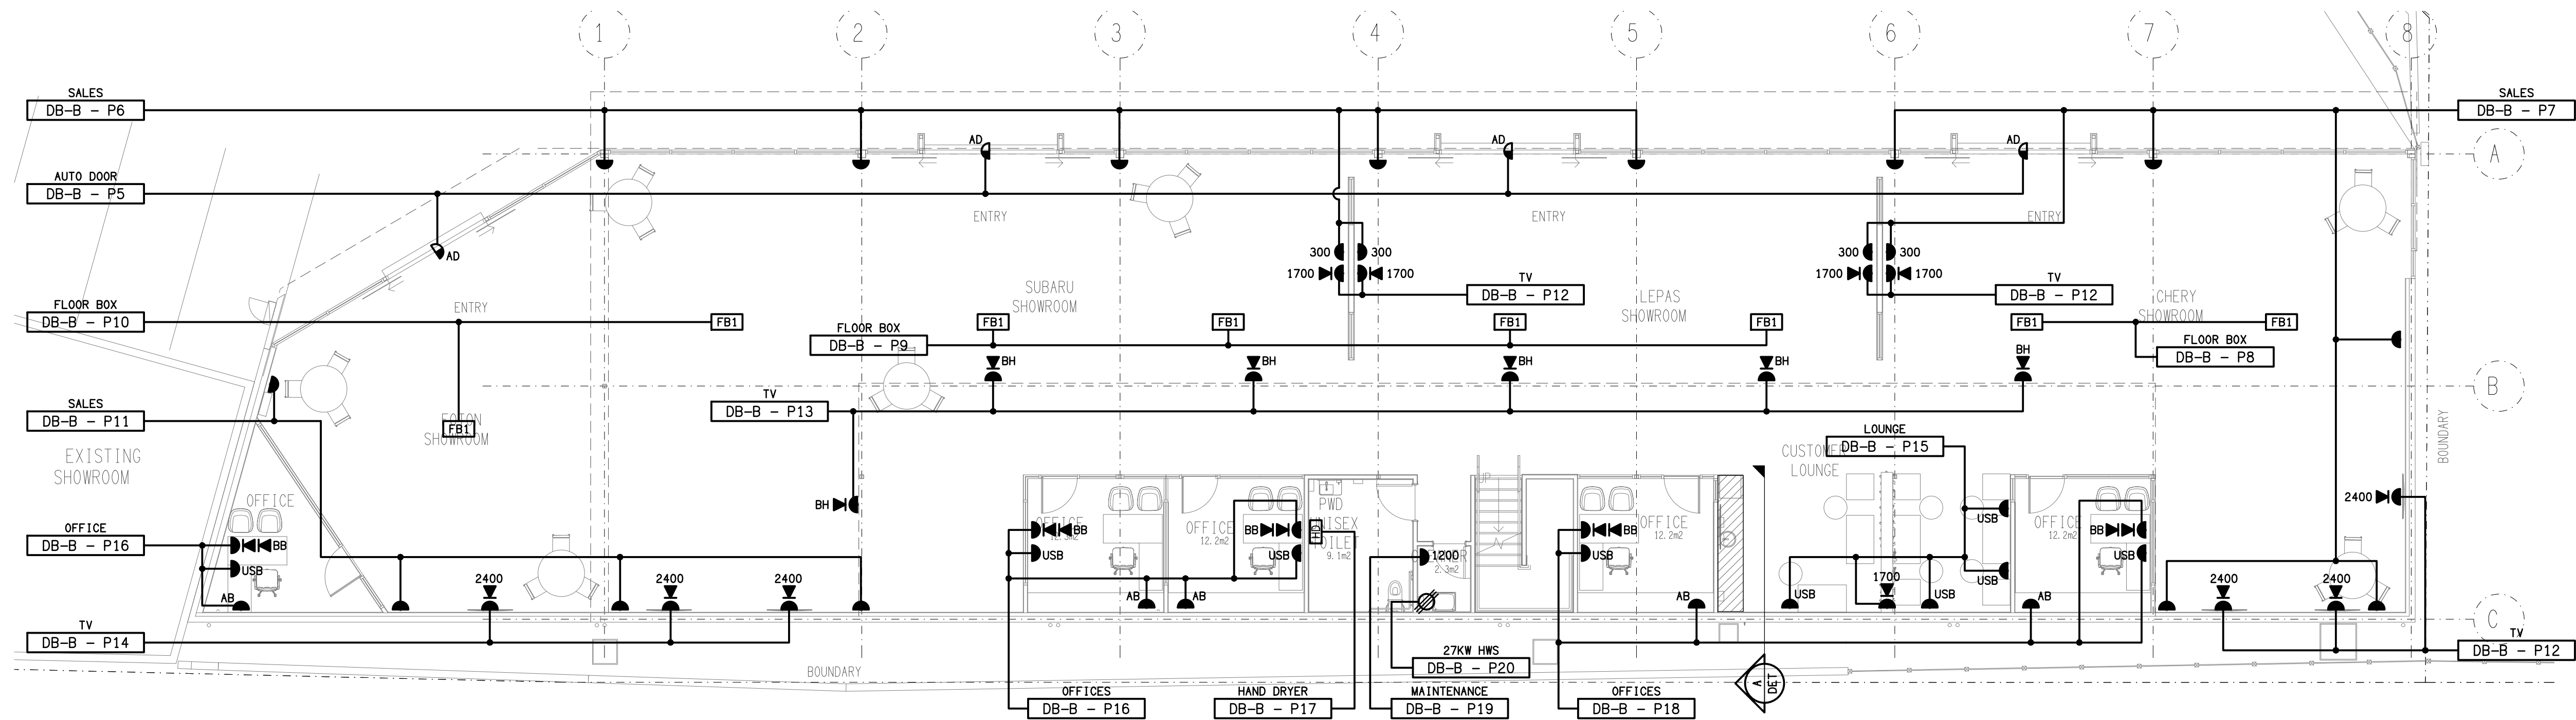

GROUND LEVEL
FLOOR PLAN
SCALE 1: 100

ELECTRICAL DESIGN GROUP BRISBANE
PTY LTD
ACN 092 710 793
TRADING AS:
ELECTRICAL DESIGN GROUP

THE COPYRIGHT OF THIS DRAWING
REMAINS THE PROPERTY OF THE
ELECTRICAL DESIGN GROUP.
USE FIGURED DIMENSIONS
IN PREFERENCE TO SCALE.
ALL DIMENSIONS TO BE
VERIFIED ONSITE.

ELECTRICAL DESIGN GROUP
ELECTRICAL BUILDING SERVICES CONSULTANTS
BRISBANE GOLD COAST
P.O. Box 15, Sherwood Q.4075
Phone: (07) 3278 4375
Email: brisbane@edg.net.au
Web: www.edg.net.au

PROJECT:
BARTONS - EASTSIDE AUTOMALL
200 TINGAL ROAD, WYNNUM

B	TENDER	08/09/2026
REV.	DESCRIPTION:	DATE:
DRAWING:	ELECTRICAL SERVICES FLOOR PLANS	
SCALE:	PROJECT NO:	DRAWING NO:
1:100 UNO	C3694a	E04
AT A1	REVISION:	B