



LEVEL 3
FLOOR / REFLECTED CEILING PLAN
SCALE 1:200

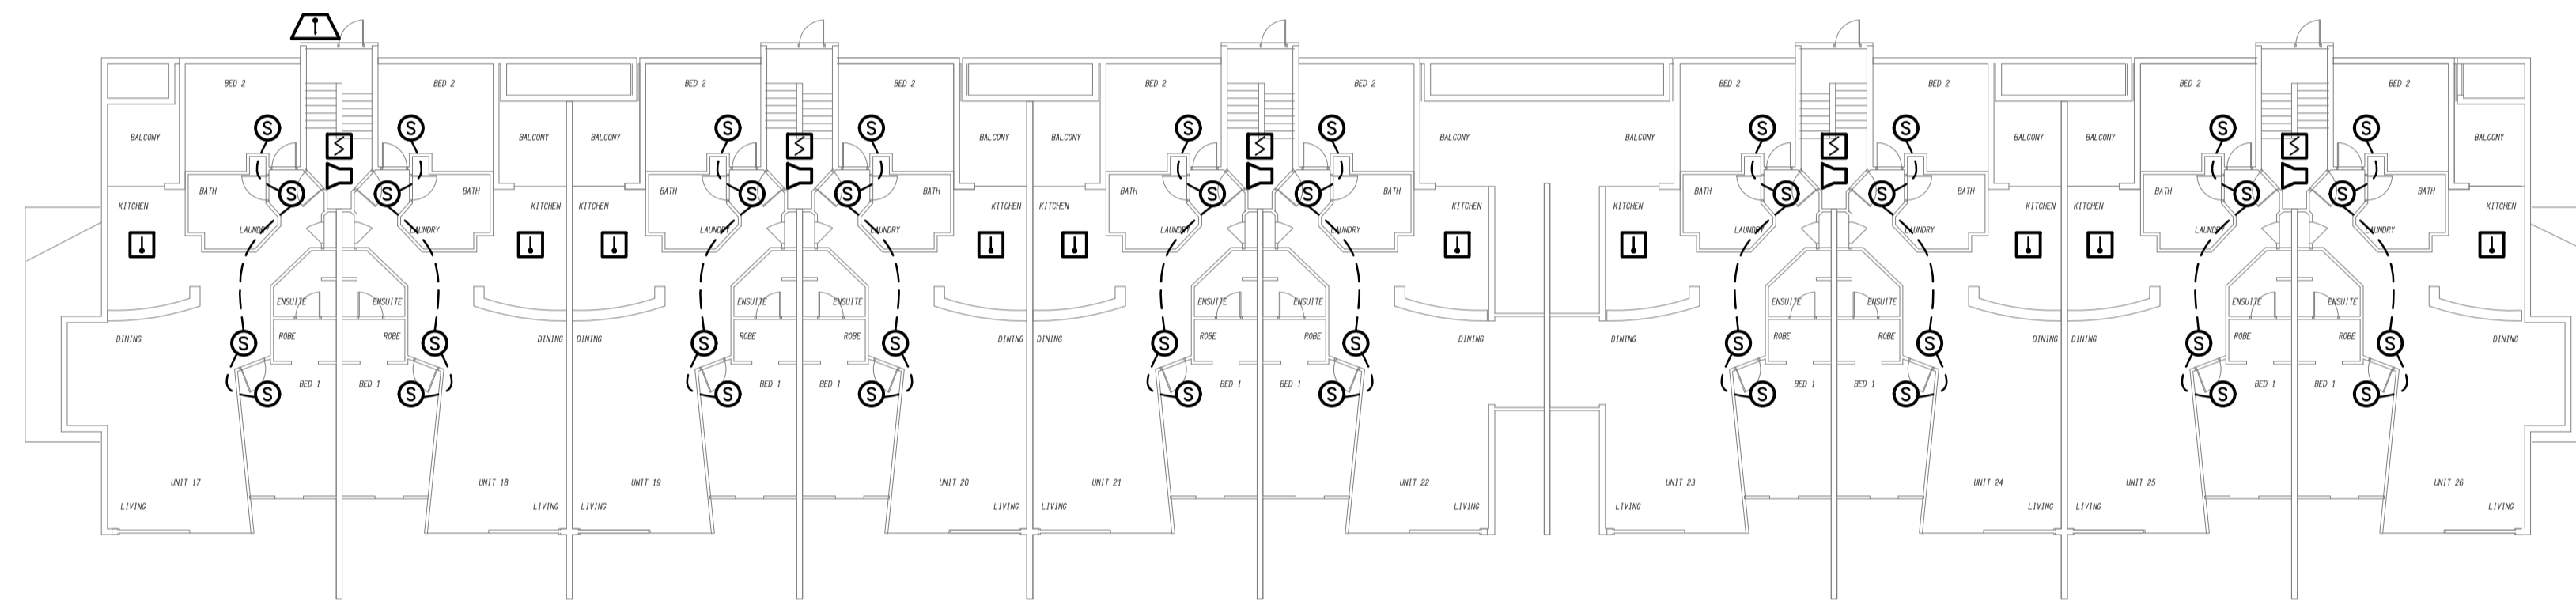

LEVEL 2
FLOOR / REFLECTED CEILING PLAN
SCALE 1:200

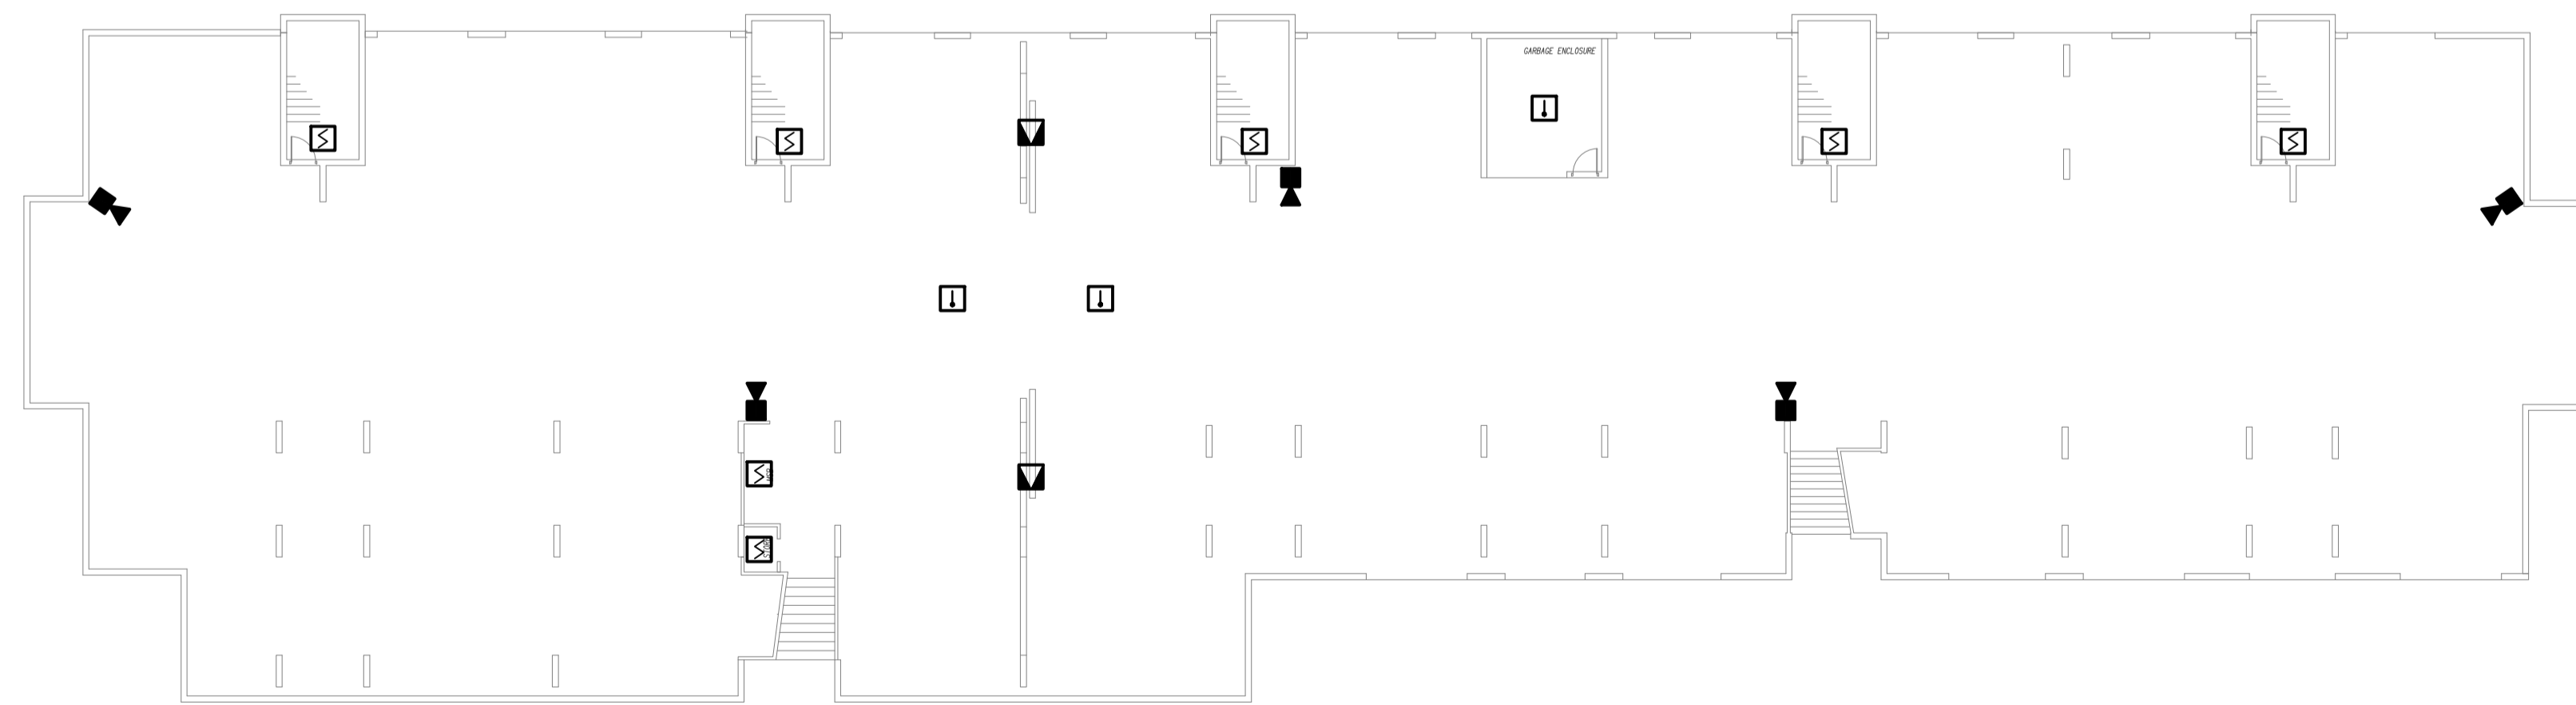

LEVEL 1
FLOOR / REFLECTED CEILING PLAN
SCALE 1:200

ELECTRICAL DESIGN GROUP BRISBANE
PTY LTD
ACN 092 710 793
TRADING AS:
ELECTRICAL DESIGN GROUP

THE COPYRIGHT OF THIS DRAWING
REMAINS THE PROPERTY OF THE
ELECTRICAL DESIGN GROUP.

USE FIGURED DIMENSIONS
IN PREFERENCE TO SCALE.
ALL DIMENSIONS TO BE
VERIFIED ONSITE.

ELECTRICAL DESIGN GROUP
ELECTRICAL BUILDING SERVICES CONSULTANTS
BRISBANE GOLD COAST

P.O.Box 15, Sherwood Q.4075
Phone: (07) 3278 4375
Email: brisbane@edg.net.au
Web: www.edg.net.au

PROJECT:
MERCANTILE, DALGETY PLACE

135 MACQUARIE STREET, TENERIFFE

B	TENDER	23/06/2026
REV:	DESCRIPTION:	DATE:

DRAWING:
ELECTRICAL SERVICES
BLOCKS C & D
LEVEL 1, 2 & 3 PLANS

SCALE:
1:200

AT A1

PROJECT NO:
C3700a

DRAWING NO:
E04

REVISION:
B