


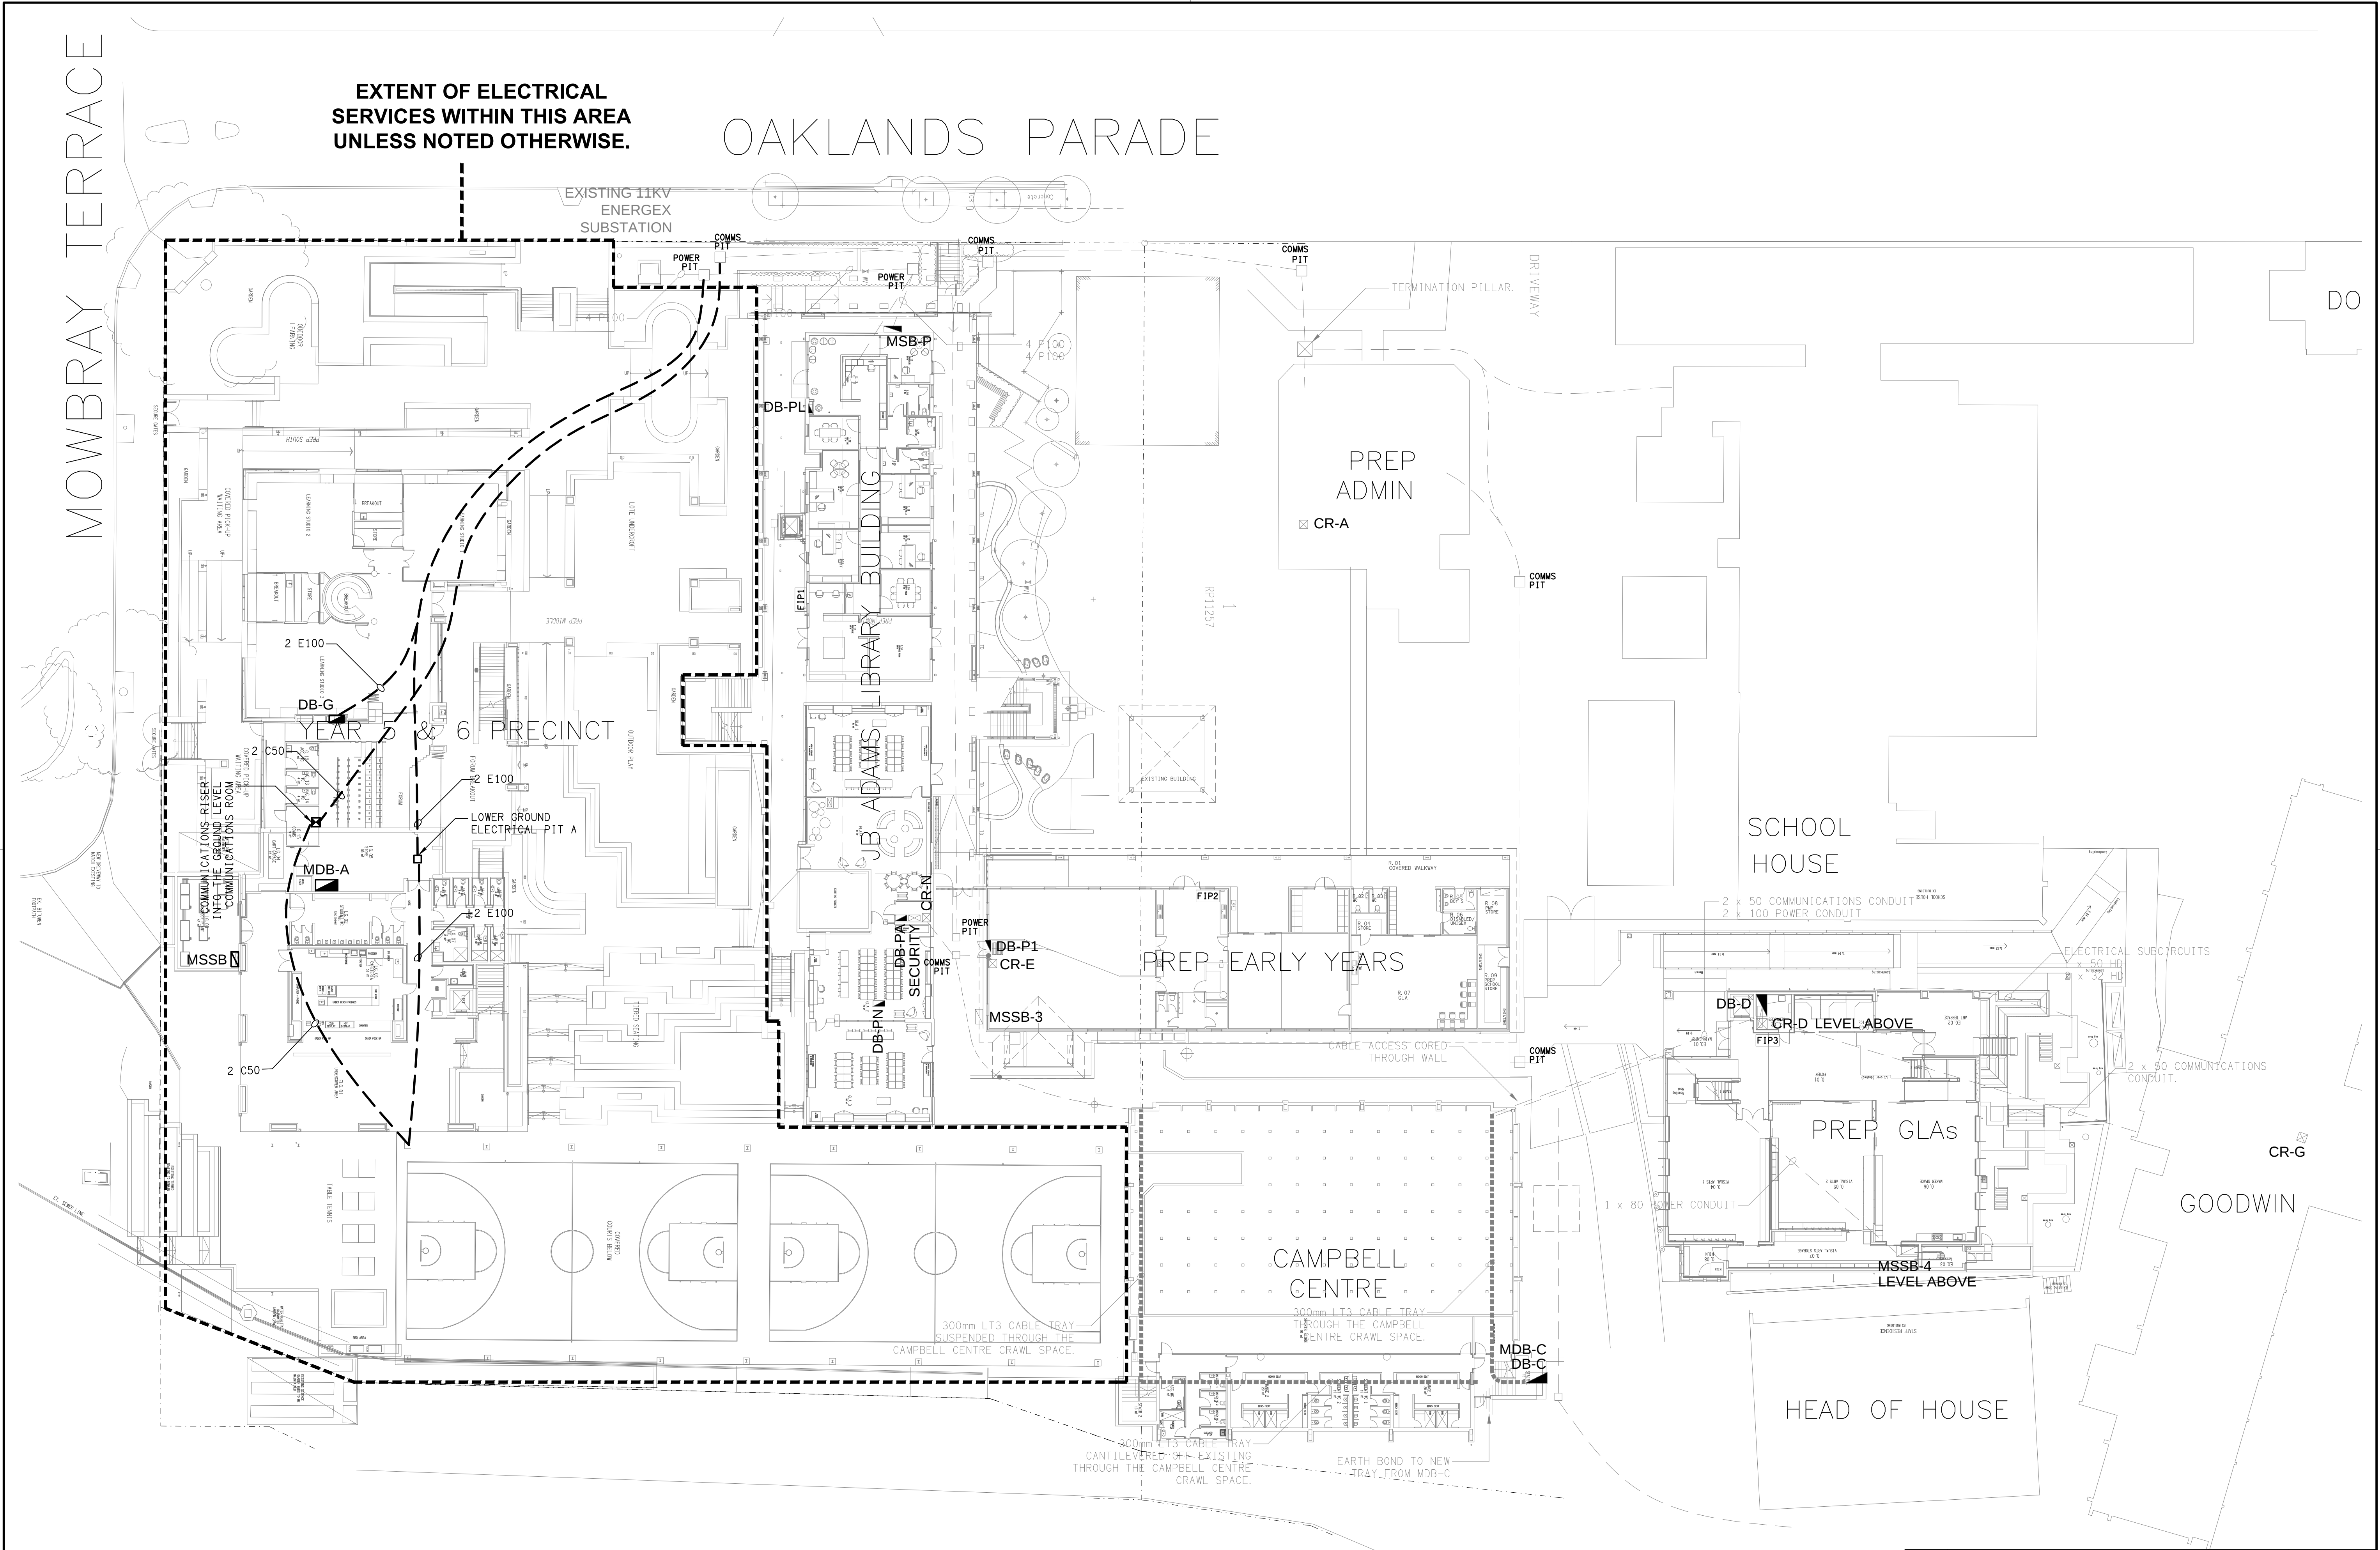

ELECTRICAL DESIGN GROUP BRISBANE PTY LTD ACN 092 710 793 TRADING AS: ELECTRICAL DESIGN GROUP	THE COPYRIGHT OF THIS DRAWING REMAINS THE PROPERTY OF THE ELECTRICAL DESIGN GROUP. USE FIGURED DIMENSIONS IN PREFERENCE TO SCALE. ALL DIMENSIONS TO BE VERIFIED ONSITE.	ELECTRICAL DESIGN GROUP ELECTRICAL BUILDING SERVICES CONSULTANTS BRISBANE GOLD COAST P.O.Box 15, Sherwood Q.4075 Phone: (07) 3278 4375 Email: brisbane@edg.net.au Web: www.edg.net.au	PROJECT: ANGLICAN CHURCH GRAMMAR SCHOOL YEAR 5 & 6 PRECINCT OAKLANDS PARADE, EAST BRISBANE	DRAWING: ELECTRICAL SERVICES PROPOSED SITE PLAN SCALE: 1:250 AT A1 PROJECT NO: C3733a DRAWING NO: E05 REVISION: T1
--	--	--	--	---