




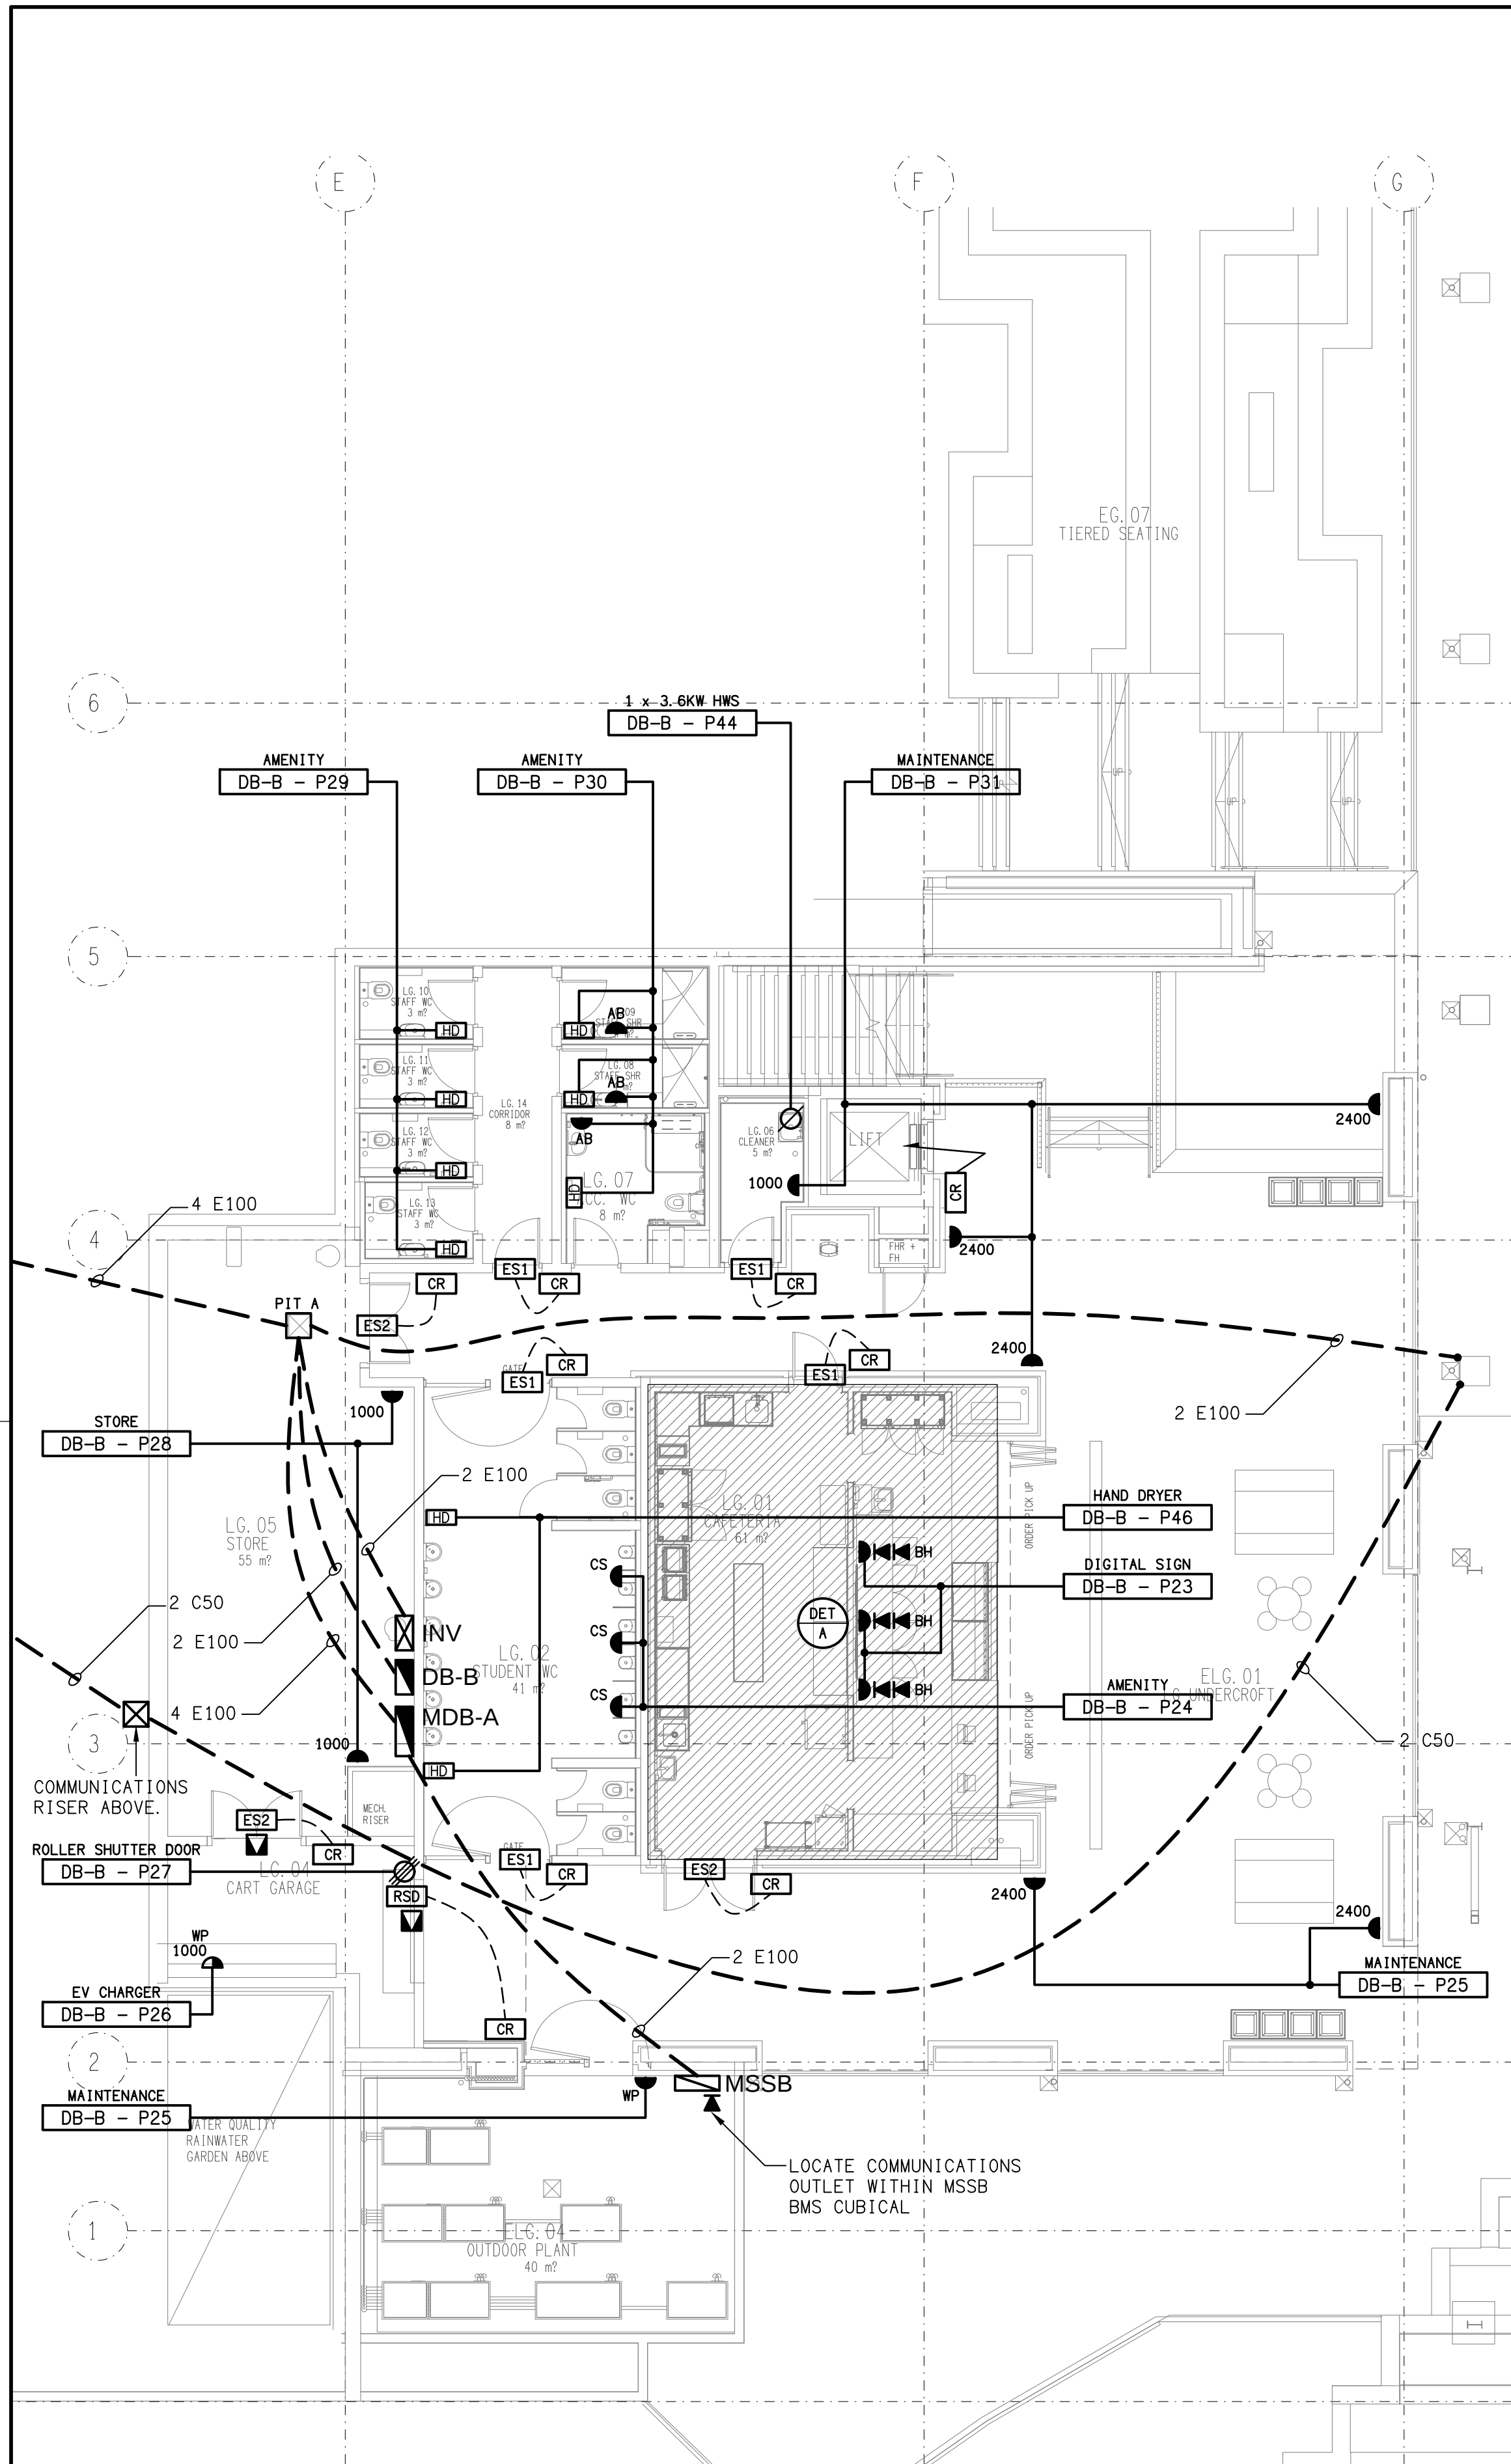

LOWER GROUND
PRECINCT FLOOR PLAN
SCALE 1: 100

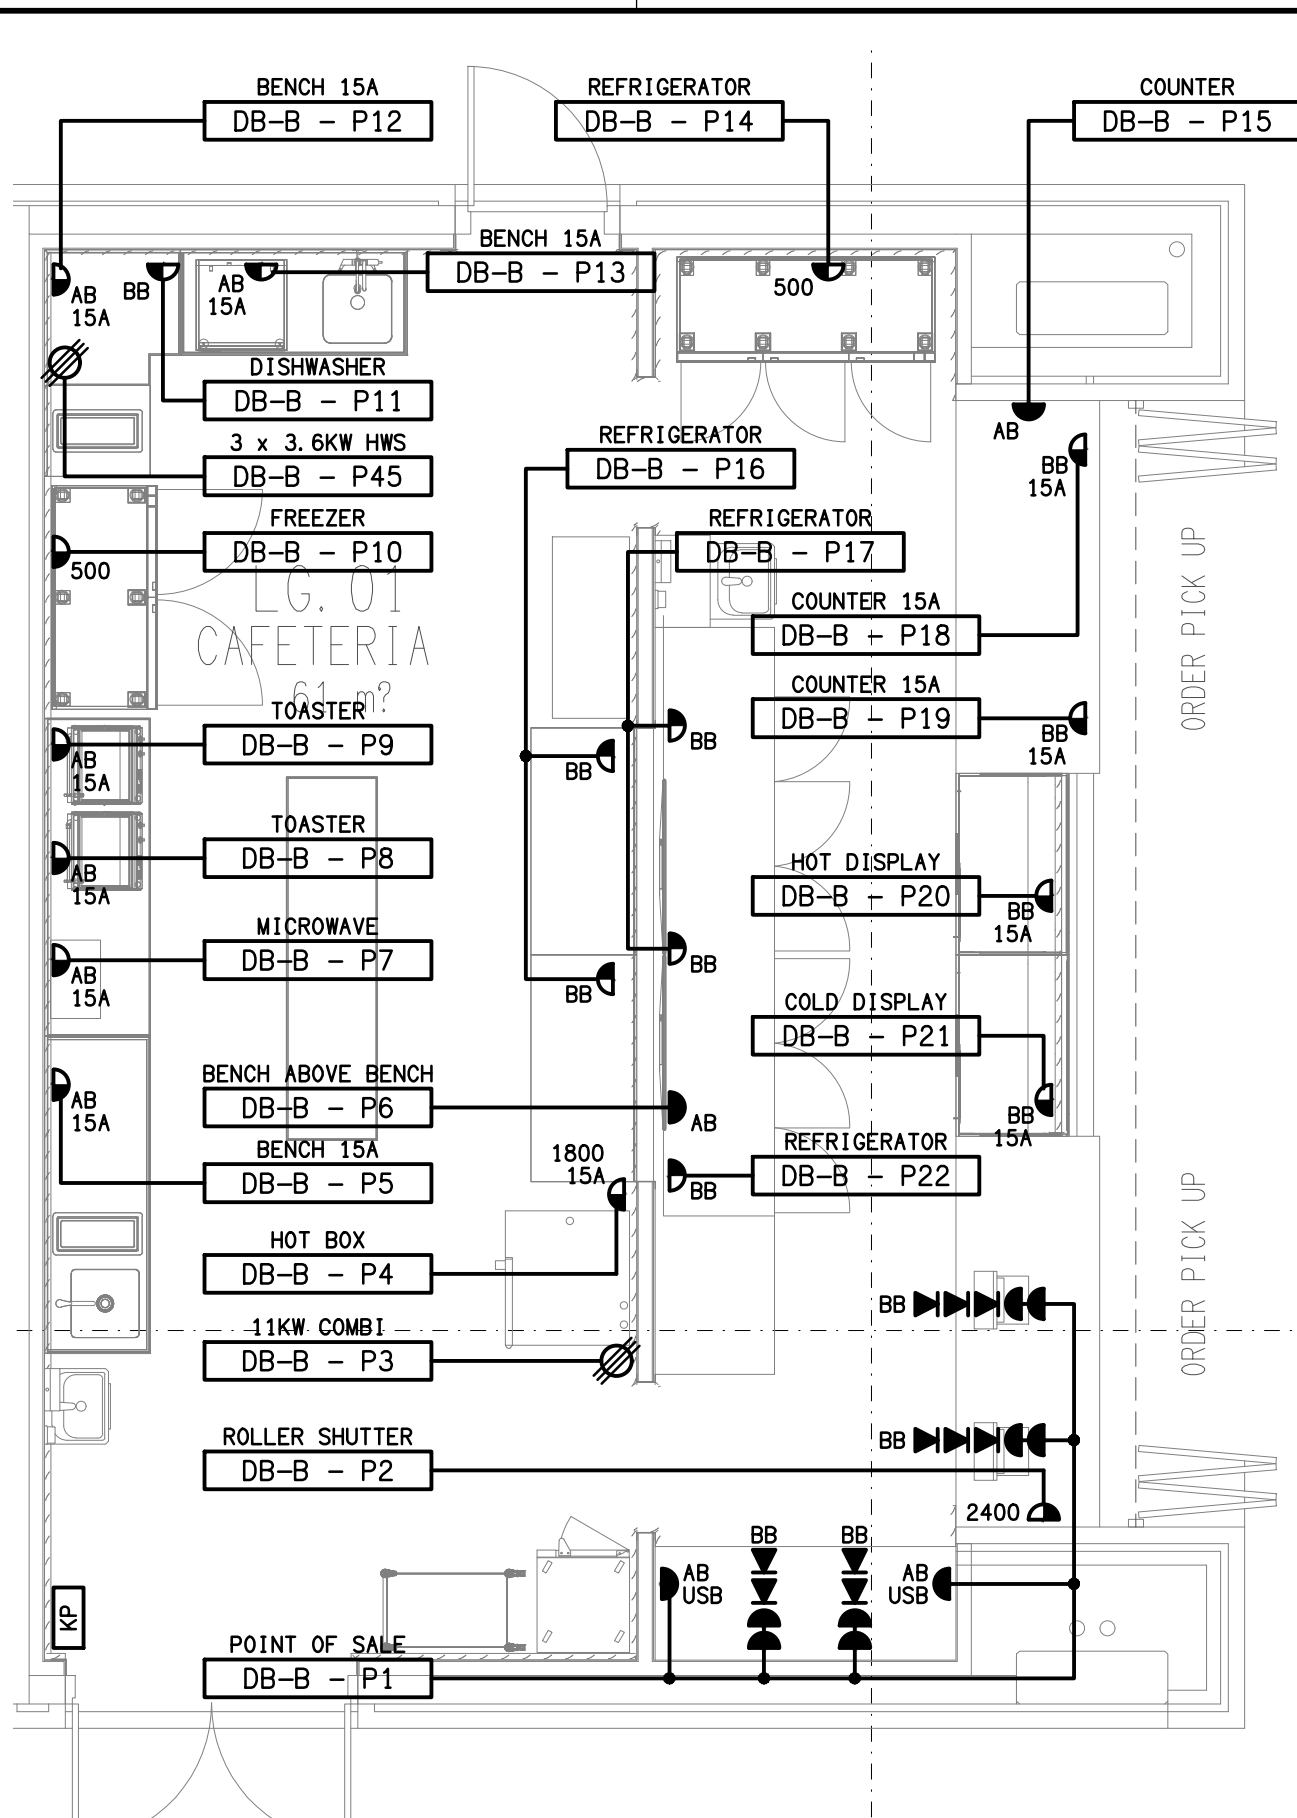

DETAIL A
CAFETERIA FLOOR PLAN
SCALE 1: 50

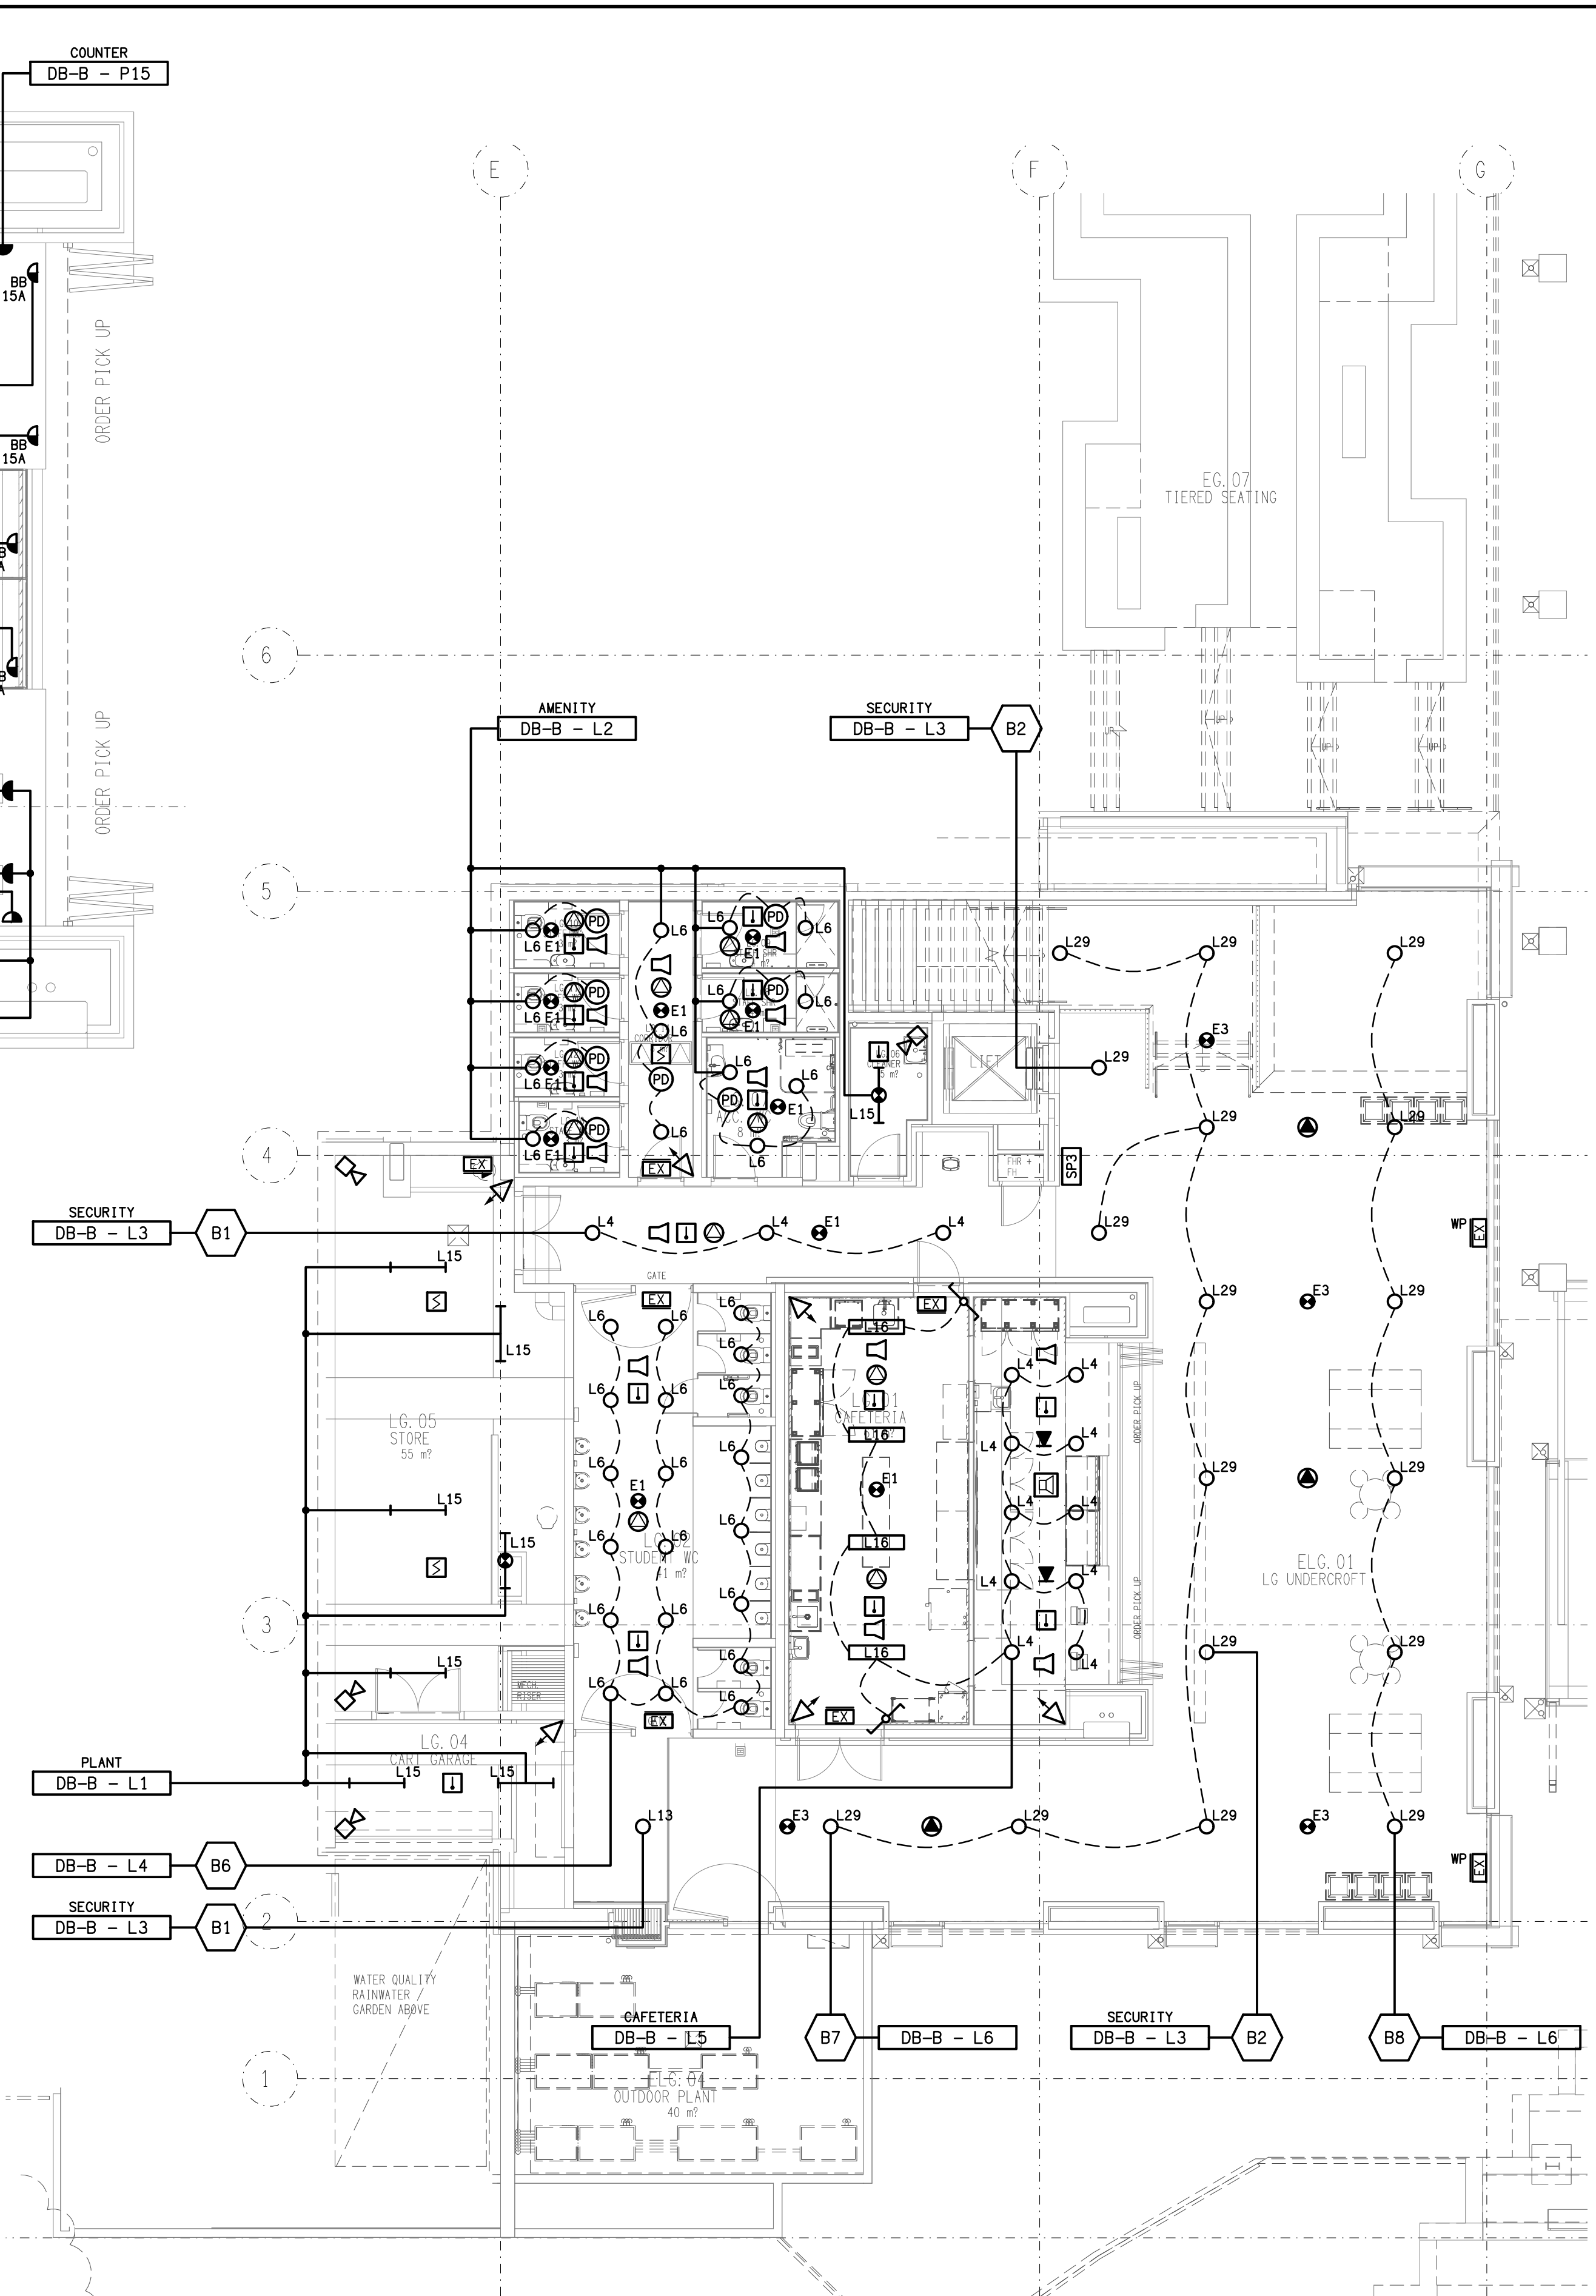

LOWER GROUND
PRECINCT REFLECTED CEILING PLAN
SCALE 1: 100

ELECTRICAL DESIGN GROUP BRISBANE
PTY LTD
ACN 092 710 793
TRADING AS:
ELECTRICAL DESIGN GROUP

THE COPYRIGHT OF THIS DRAWING
REMAINS THE PROPERTY OF THE
ELECTRICAL DESIGN GROUP.
USE FIGURED DIMENSIONS
IN PREFERENCE TO SCALE.
ALL DIMENSIONS TO BE
VERIFIED ONSITE.

ELECTRICAL DESIGN GROUP
ELECTRICAL BUILDING SERVICES CONSULTANTS
BRISBANE GOLD COAST

P.O.Box 15, Sherwood Q.4075
Phone: (07) 3278 4375
Email: brisbane@edg.net.au
Web: www.edg.net.au

PROJECT:
ANGLICAN CHURCH GRAMMAR SCHOOL
YEAR 5 & 6 PRECINCT

OAKLANDS PARADE, EAST BRISBANE

T1	TENDER	11/09/2026
REV.	DESCRIPTION:	DATE:

DRAWING:
ELECTRICAL SERVICES
PRECINCT
LOWER GROUND PLANS

SCALE:
1:100 UNO AT A1

PROJECT NO:
C3733a

DRAWING NO:
E07

REVISION:
T1